


E:\DWC\6500PLUS\6789F FALLON CREST\Photometric\PHOTO.dwg, Photo, 12/30/2004 12:11:56 PM, Station 38 ALJ

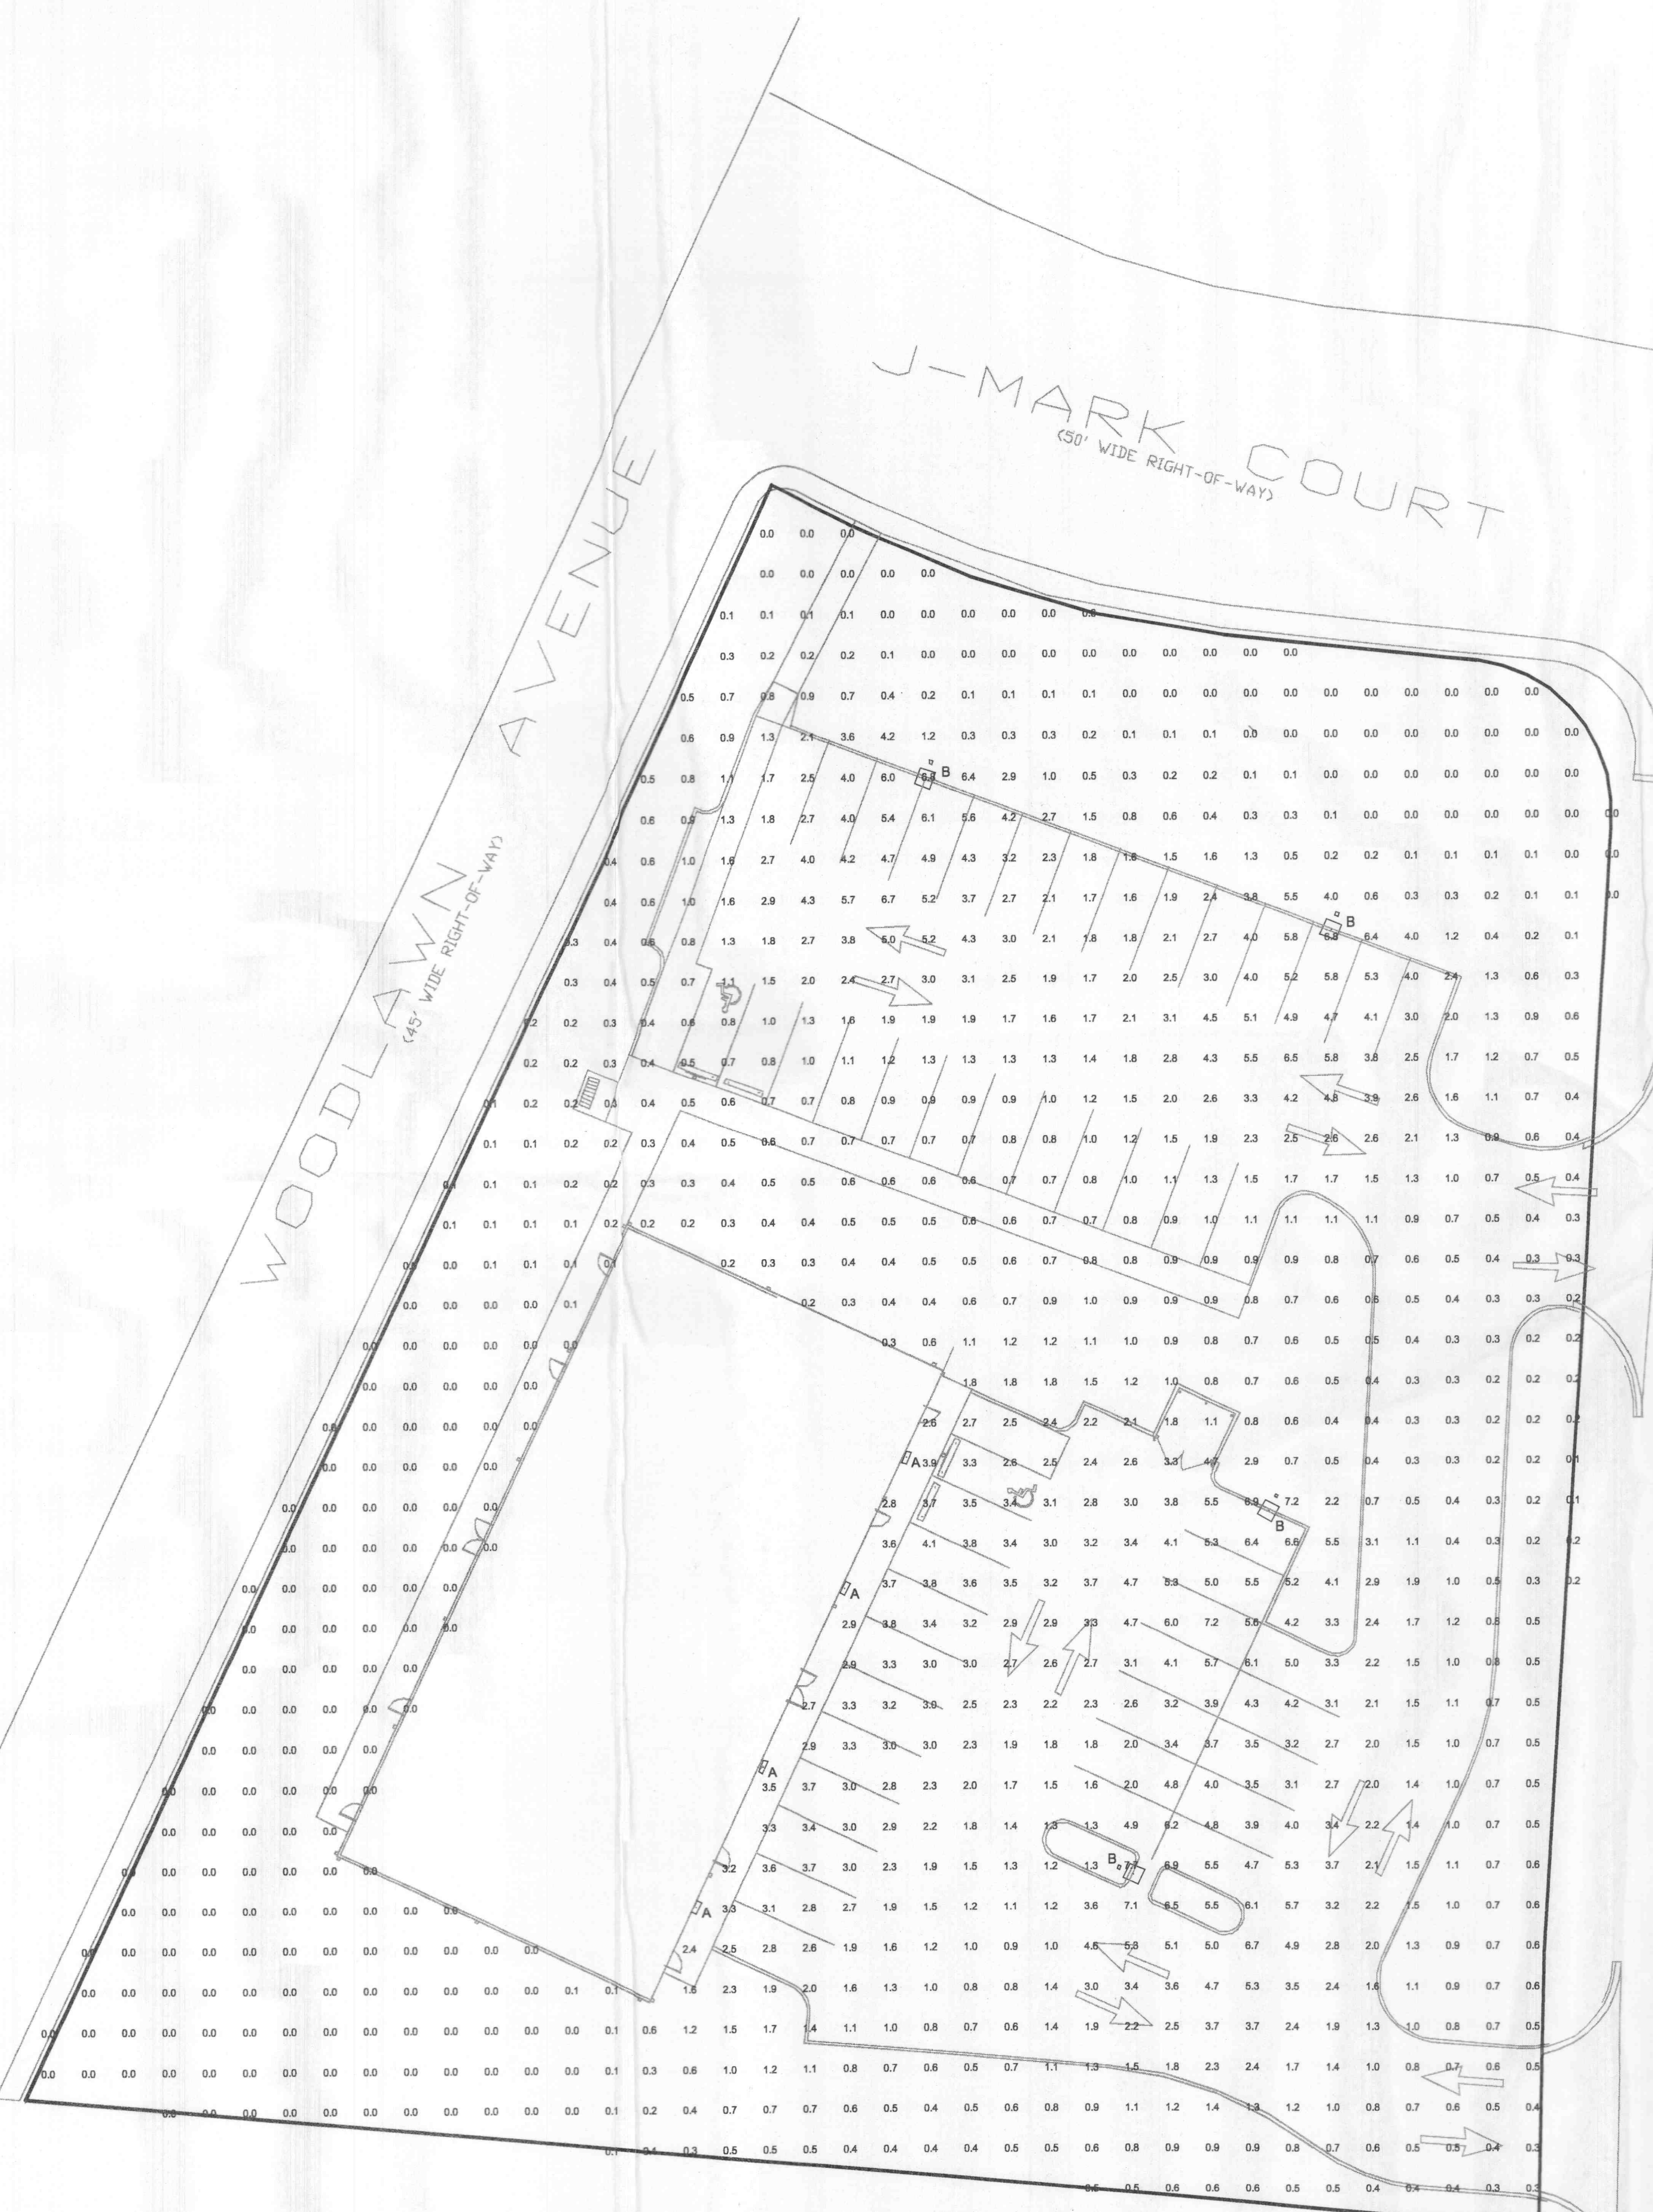

Plan View  
Scale 1" = 20'

STATISTICS					
Description	Avg	Max	Min	Max/Min	Avg/Min
PROPERTY	1.4 fc	7.7 fc	0.0 fc	N/A	N/A

LUMINAIRE SCHEDULE									
Symbol	Label	Qty	Catalog Number	Description	Lamp	File	Lumens	LLF	Watts
□	A	4	TWH 175M	GLASS REFRACTOR WALL-PAK	ONE 175-WATT CLEAR METAL HALIDE, HORIZONTAL POS.	94121101.lvs	11700	0.72	215
□	B	4	KSF2 400S RASC	ARE LIGHT WITH TYPE 4 CUT-OFF REFLECTOR, FLAT GLASS LENS.	ONE 400-WATT CLEAR HIGH PRESSURE SODIUM, HORIZONTAL POS.	93042201.lvs	50000	0.72	457

WOODLAWN OFFICE BUILDING  
SITE PHOTOMETRICS

Designer  
LCC  
Date  
Dec 29 2004  
Scale  
1" = 20'  
Drawing No.