

### PERIMAPAK™ SERIES

#### 250/400 WATT WALL PACK

The Perimapak Series is a heavy duty wall mount luminaire for mounting heights of 18-25 feet. Its aesthetic appearance makes this product ideal for perimeter lighting around parking garages, industrial plants, tunnels, or any area where a high performance, decorative high wattage luminaire is required.

**Housing** — Rugged, die-cast aluminum with bronze chip resistant finish. Door frame includes two hinges for easy relamping.

**Reflector** — Heavy duty, prismatic borosilicate glass for wide spread distribution.

**Reflector** — Stippled reflector is designed to work in conjunction with refractor for optimum performance.

**Ballast** — Class "H" insulated, -40°F starting (-20°F, MH) high power factor, 60 Hz. Isolated ballast chamber provides cooler operation and full ballast life.

**Additional Features** — Two 1/2" side entries for surface conduit mounting... photocell available for field installation... wire guard and polycarbonate shield available... quick and easy to install... U.L. 1572 listed, suitable for wet locations.

#### ORDERING INFORMATION

Catalog Number	Lamp Type	Wattage	Voltage	Weight
				lbs. kgs.
PRP-250H-118	High-Pressure Sodium	250	Quad-Tap	36 16.3
PRP-400H-118	High-Pressure Sodium	400	Quad-Tap	48 21.8
PRP-250H-118	Metal Halide	250	Quad-Tap	36 16.3
PRP-400H-118	Metal Halide	400	Quad-Tap	48 21.8


\*Mercury Vapor lamps may be operated on Metal Halide ballast.  
\*\*QUAD-TAP™ (20, 208, 240, 277 volt)

#### ACCESSORIES

For field installation on the Perimapak series. Must be ordered separately.

Catalog Number	Description
PRP-WG	Wire Guard††
PRP-PS	Polycarbonate Shield*
PTA-8	Photocell


SCALE 1" = 40'

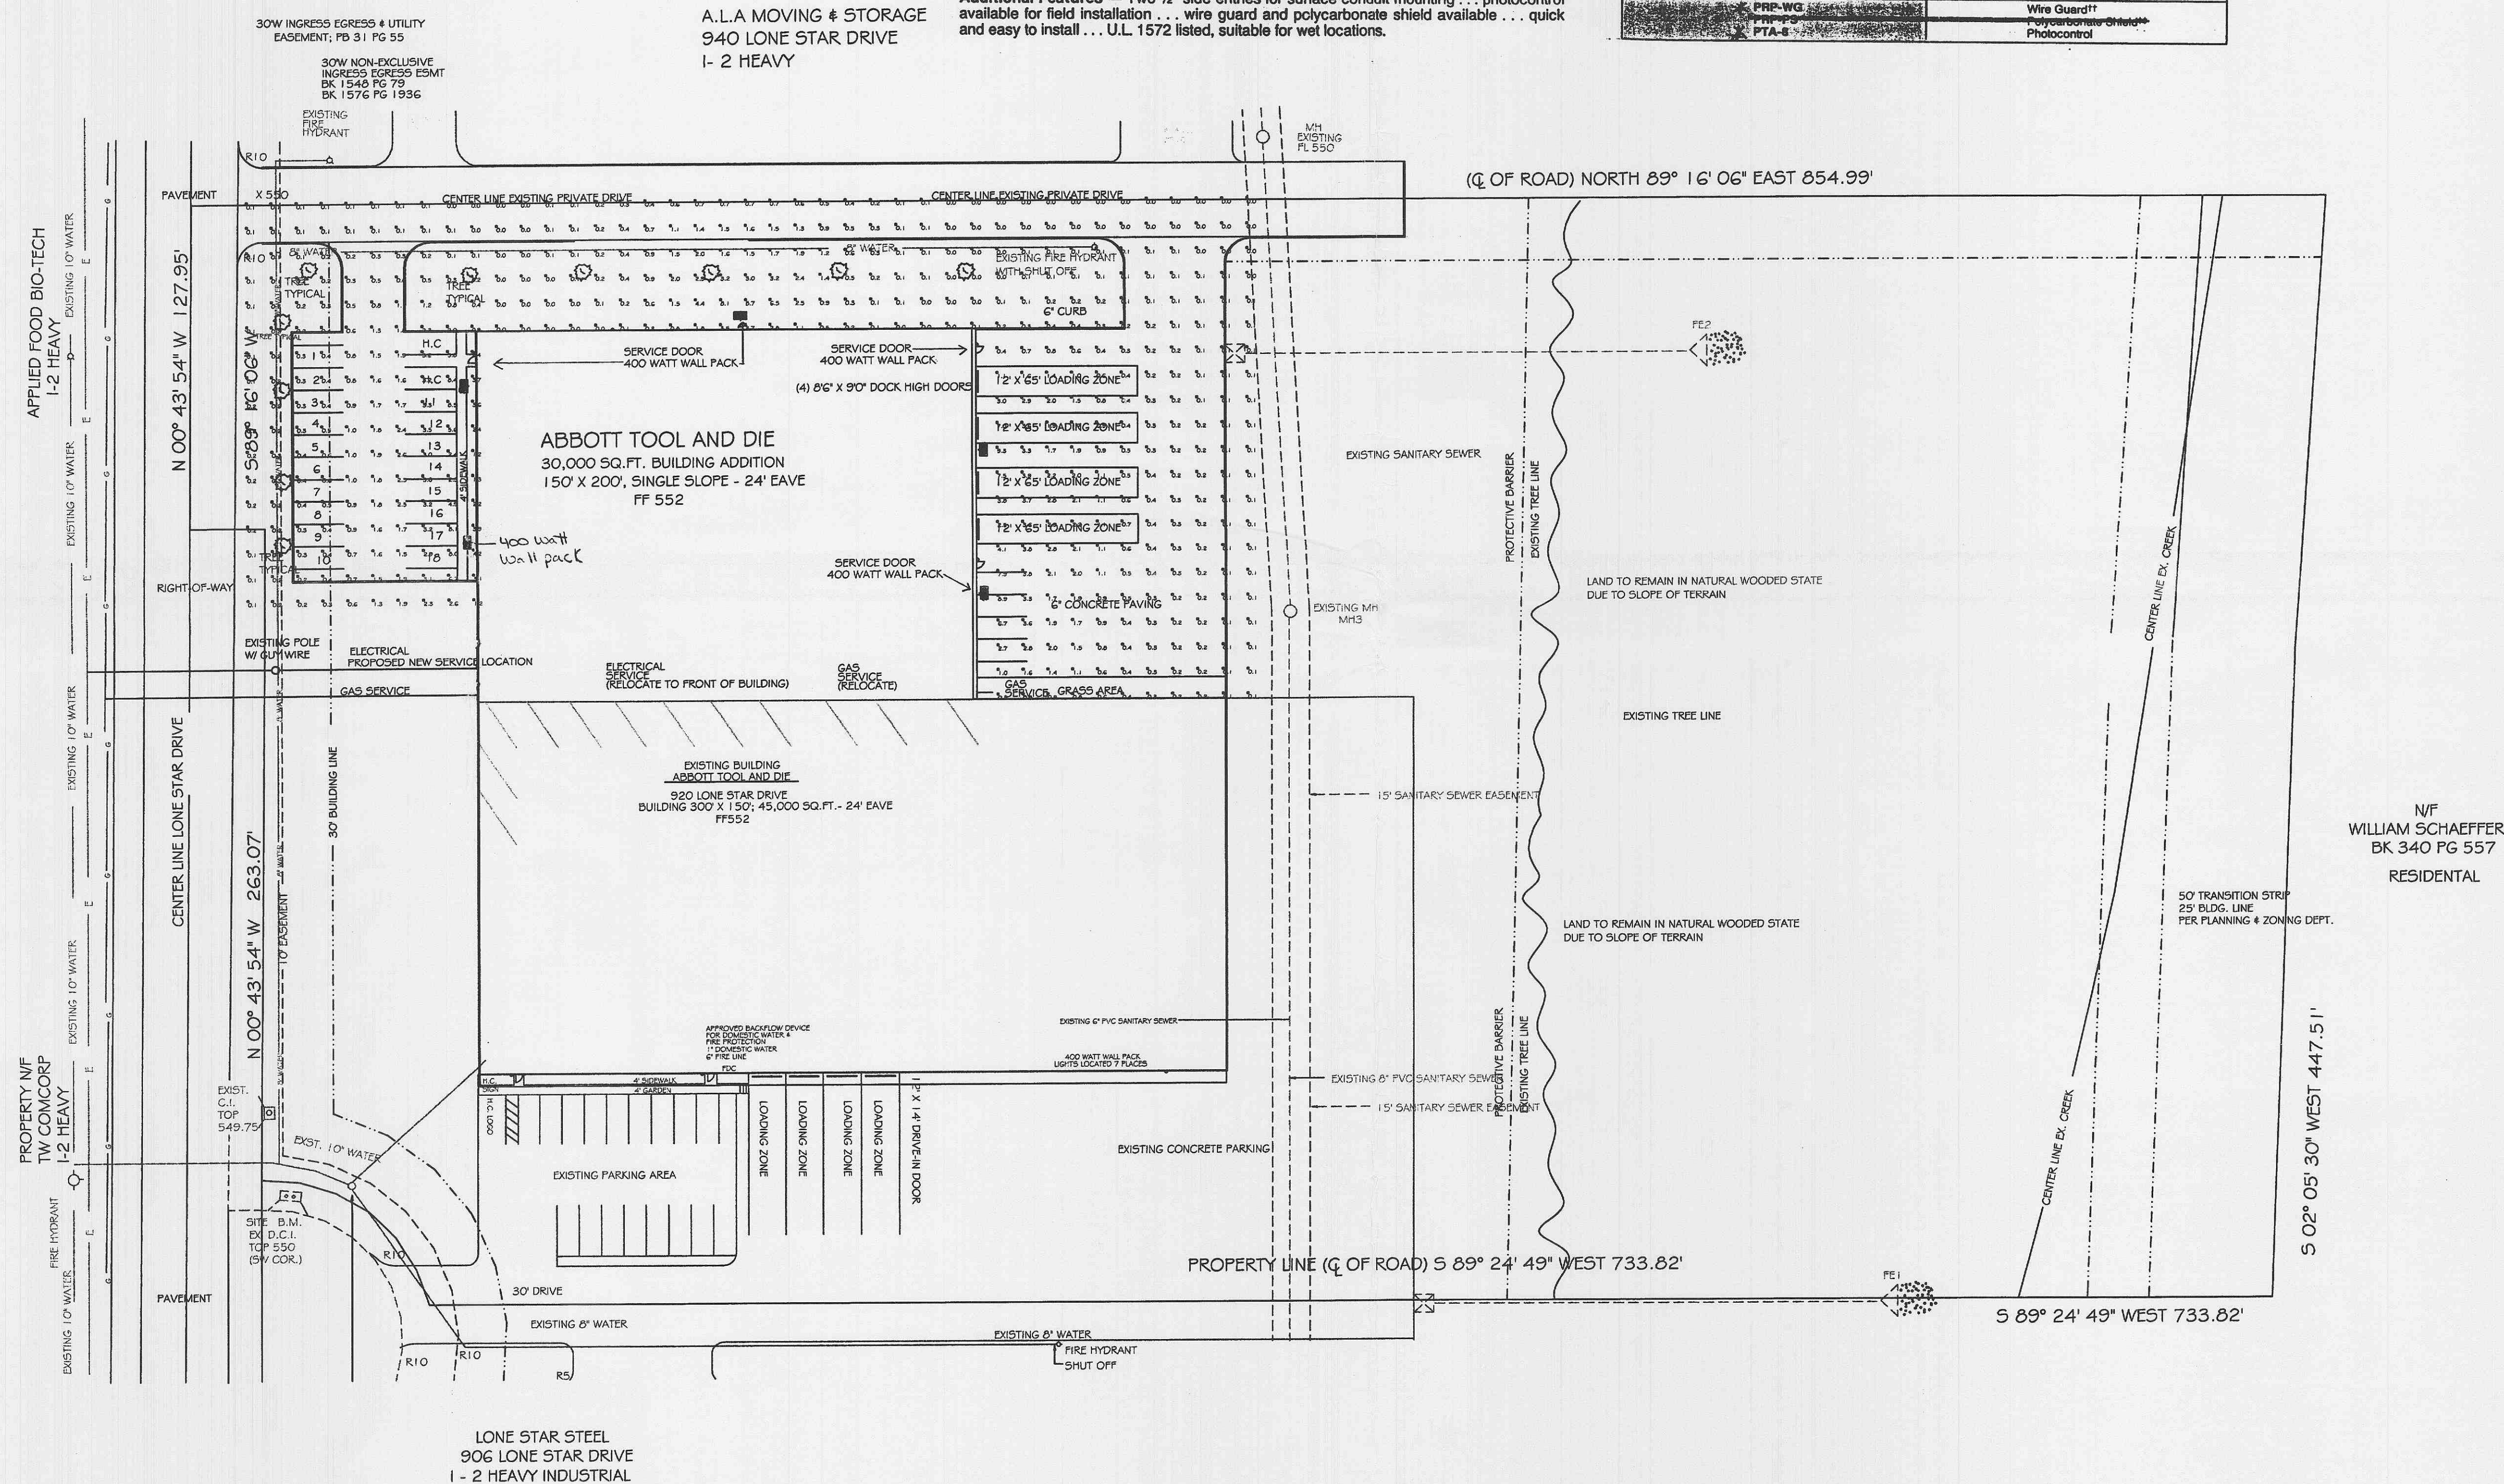

A NEW 30,000 SQ. FT. ADDITION  
 ABBOTT TOOL AND DIE  
 920 LONE STAR DRIVE  
 OFALLON, MO. 63366

LIGHTING PLAN

Bill Davis Inc.  
 2209 Droste Road  
 St. Charles, Mo. 63301  
 (636) 949-0680  
 Fax (636) 949-6706

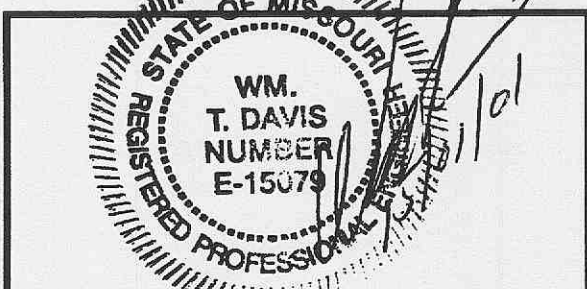

ABBOTT TOOL AND DIE  
 LIGHTING PLAN  
 920 LONE STAR DRIVE  
 A 30,000 SQ. FT. ADDITION

Project ABBOTT TOOL	Sheet 5/5
Date 12/1/00	Rev. 3-1-01
Scale 1" = 40'	