
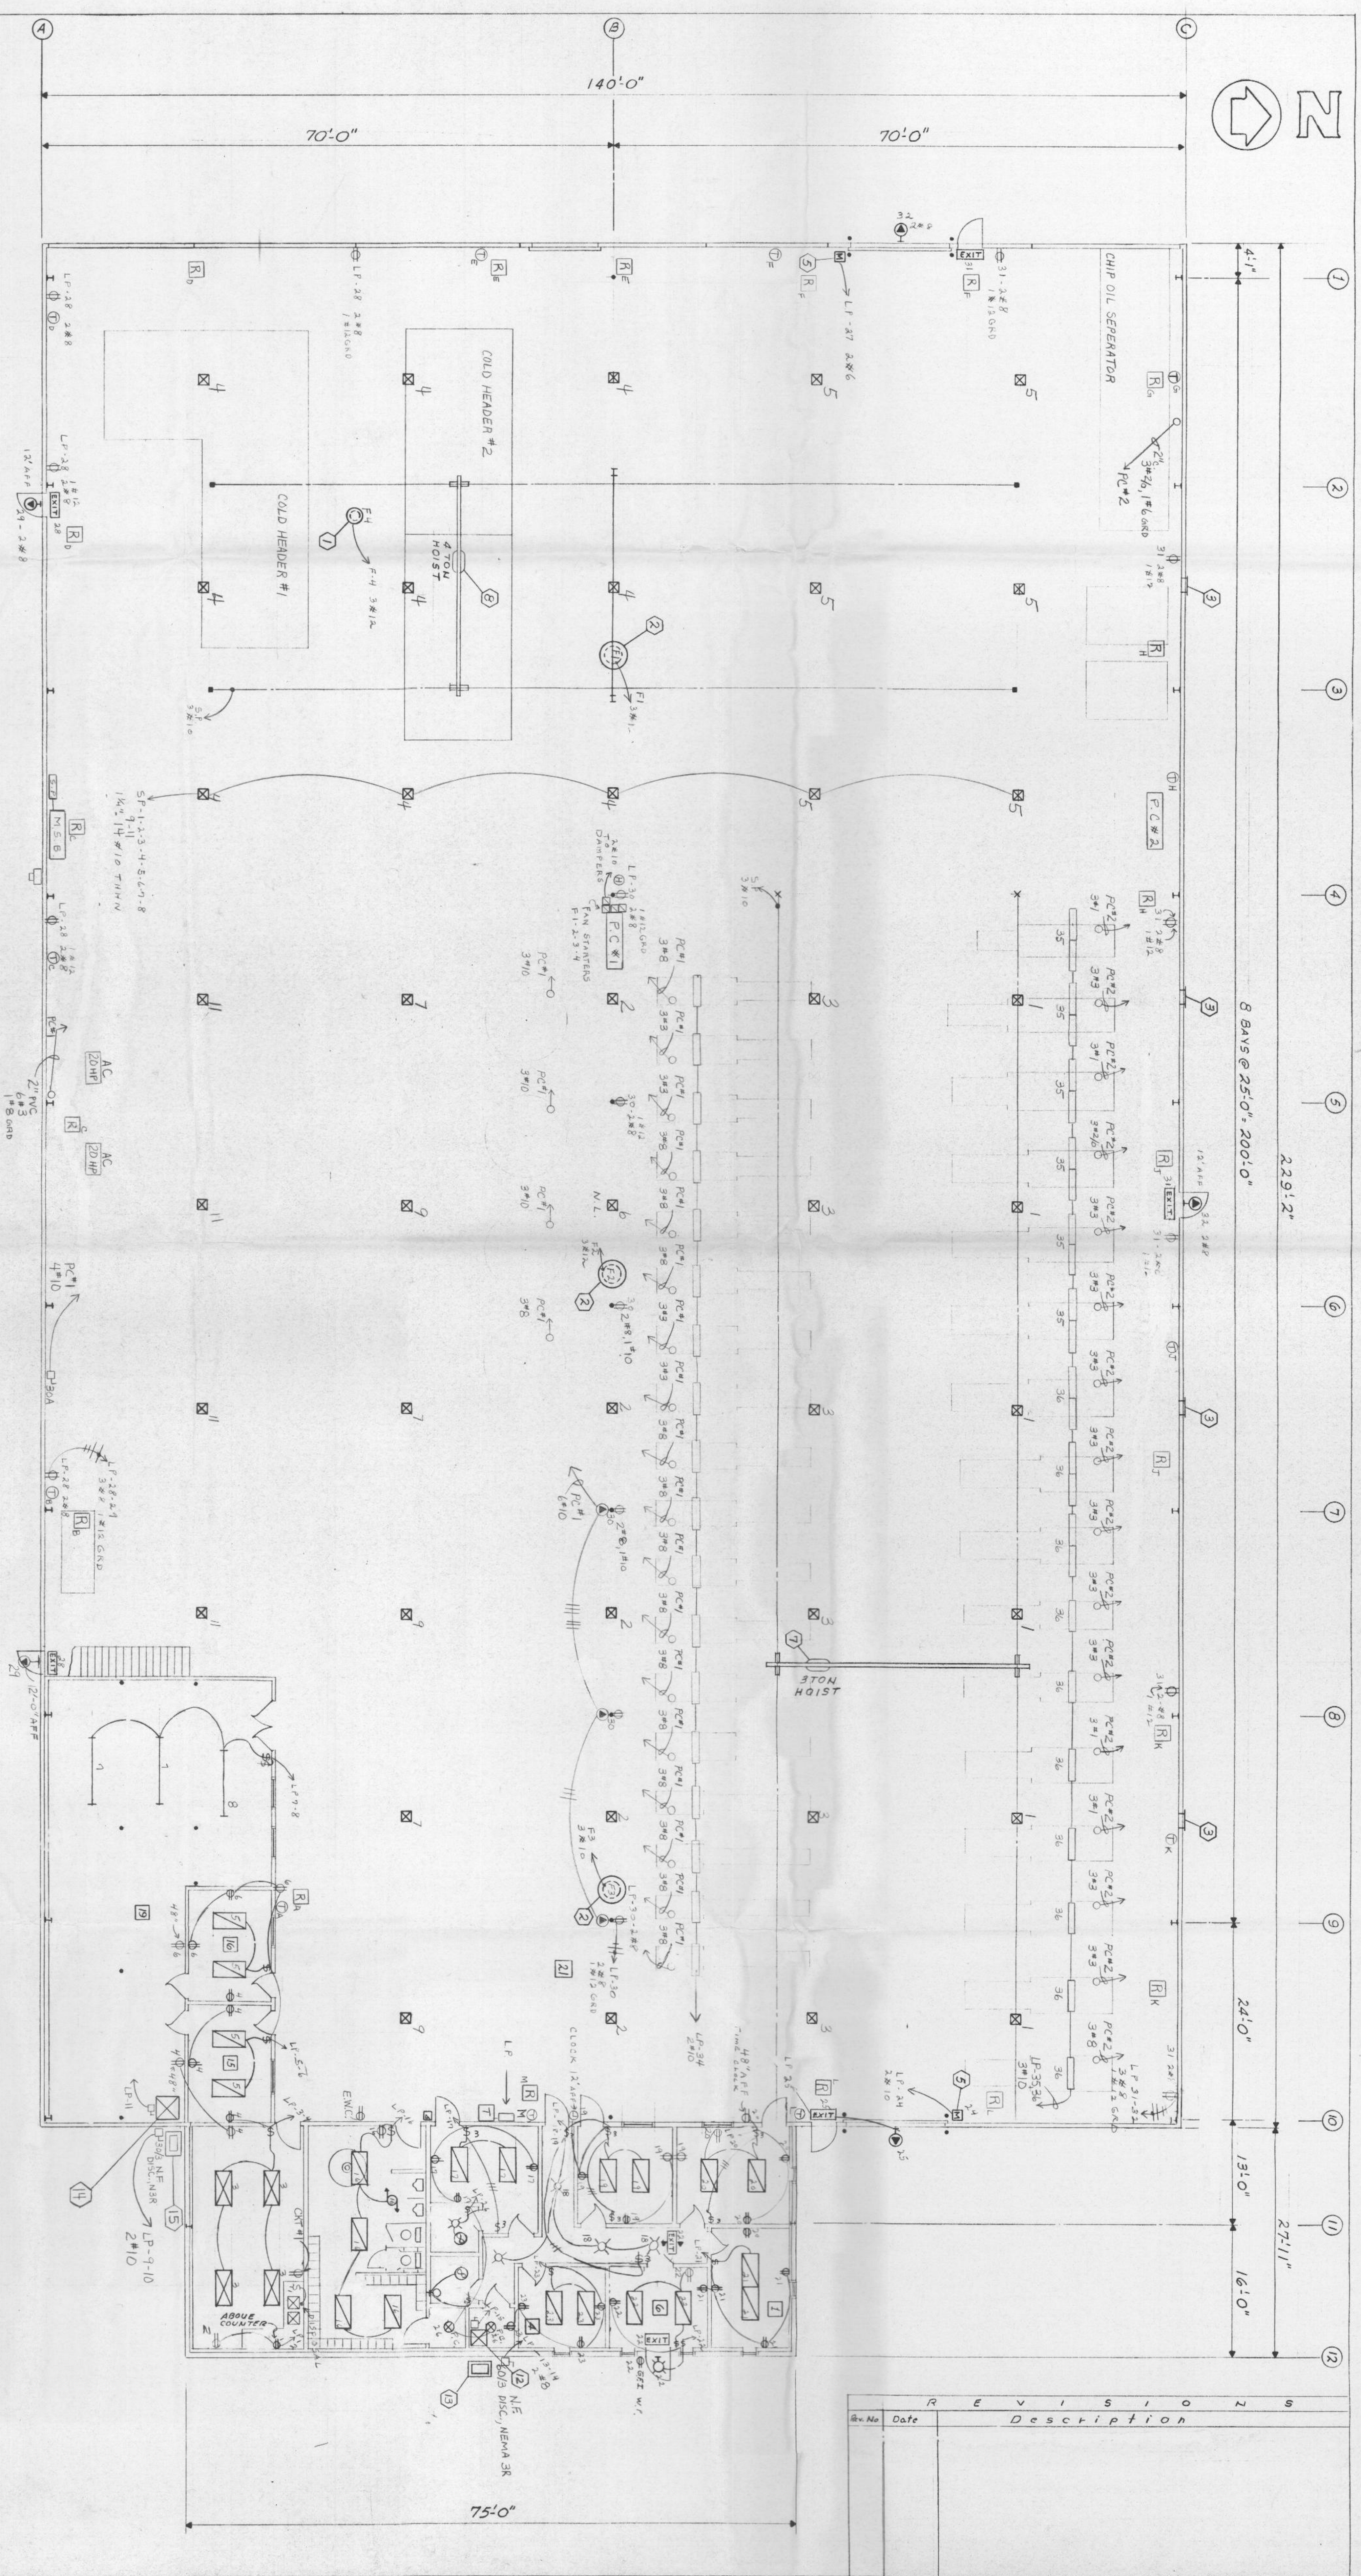


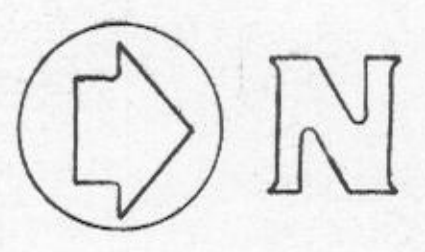

L I G H T I N G L E G E N D

- 2 1/4" 40W T8s, GRID TYPE FLUORESCENT
- 400W - LOW BAY METAL HALIDE HID FIXTURE
- 8' LONG, 2-1/2" W T8s, SUSP TYPE FLUORESCENT
- EXIT SIGN W/ BATTERY PK

- 50 W SODIUM VAPOR SECURITY (a. PHOTO CELL)
- 50 W OUTSIDE LIGHT
- CEILING MOUNTED INCANDESCENT FIXTURE P. C. W/ C.O.
- 48" INDUSTRIAL FLOOR, 2 LAMP, FHO

- 110 V DUPLEX RECEPTACLE
- 645 RADIANT HTR
- SINGLE POLE SWITCH
- 3WAY SWITCH

DATON OR APPROVED EQUAL NO. EACH REQ'D.	EQUIPMENT TO BE FURNISHED AND INSTALLED BY OTHERS AND WIRING BY THE ELECTRICAL CONTRACTOR	FURNISHED AND INSTALLED BY
75693 1	13 1/2" ROOF EXHAUSTER 240V/3Ø	GEN. CONTR.
75693 3	24 1/2" ROOF EXHAUSTERS (SYNCHRONIZED)	GEN. CONTR.
45663 4	20" MOTORIZED DAMPER 230V	GEN. CONTR.
2	H.A.C.H. DOOR OPERATORS	GEN. CONTR.
1	3 TON HOIST 480V/3Ø	FURNISHED BY OWNER INSTALLED BY GEN. CONTR.
1	6" DIA. MOUNTED EXHAUST FAN - WASH ROOM	HVAC CONTR.
4	1/2 HP EXHAUST FAN - TOILET	HVAC CONTR.
1	ELEC OPERATED FLOOR MOUNTED WATER COOLER	PUMP CONTR.
1	BTU GAS FURNACE	HVAC CONTR.
1	TOU AIR COND COMPRESSOR	HVAC CONTR.
1	BTU GAS FURNACE	HVAC CONTR.
1	TOU AIR COND COMPRESSOR	HVAC CONTR.

NOTE:
PHONE SYSTEM BY THE OWNER
ALL WIRE THIN COPPER



ELECTRICAL PLAN
Scale 1/8" = 1'-0"
H&K MACHINE SERVICE INC.
O'Fallon, MO.
Drawn By: DMS Date 7/15/86
Job # 191 Sheet No. E-1

Rev. No.	Date	Description