




NOTE:
 1. UNDERGROUND NOTES FROM SHALL BE TYPE
 2. ALL ABOVE GROUND WATER PIPING SHALL BE
 TYPE "N" COBOL.
 3. ALL UNDERGROUND SOIL, WASTE AND VENT PIPING
 SHALL SLOPE AT 3 PER FT.
 4. REMOVE DEEP SOIL P-TURNS UNDER ALL FLOOR
 DECKS.

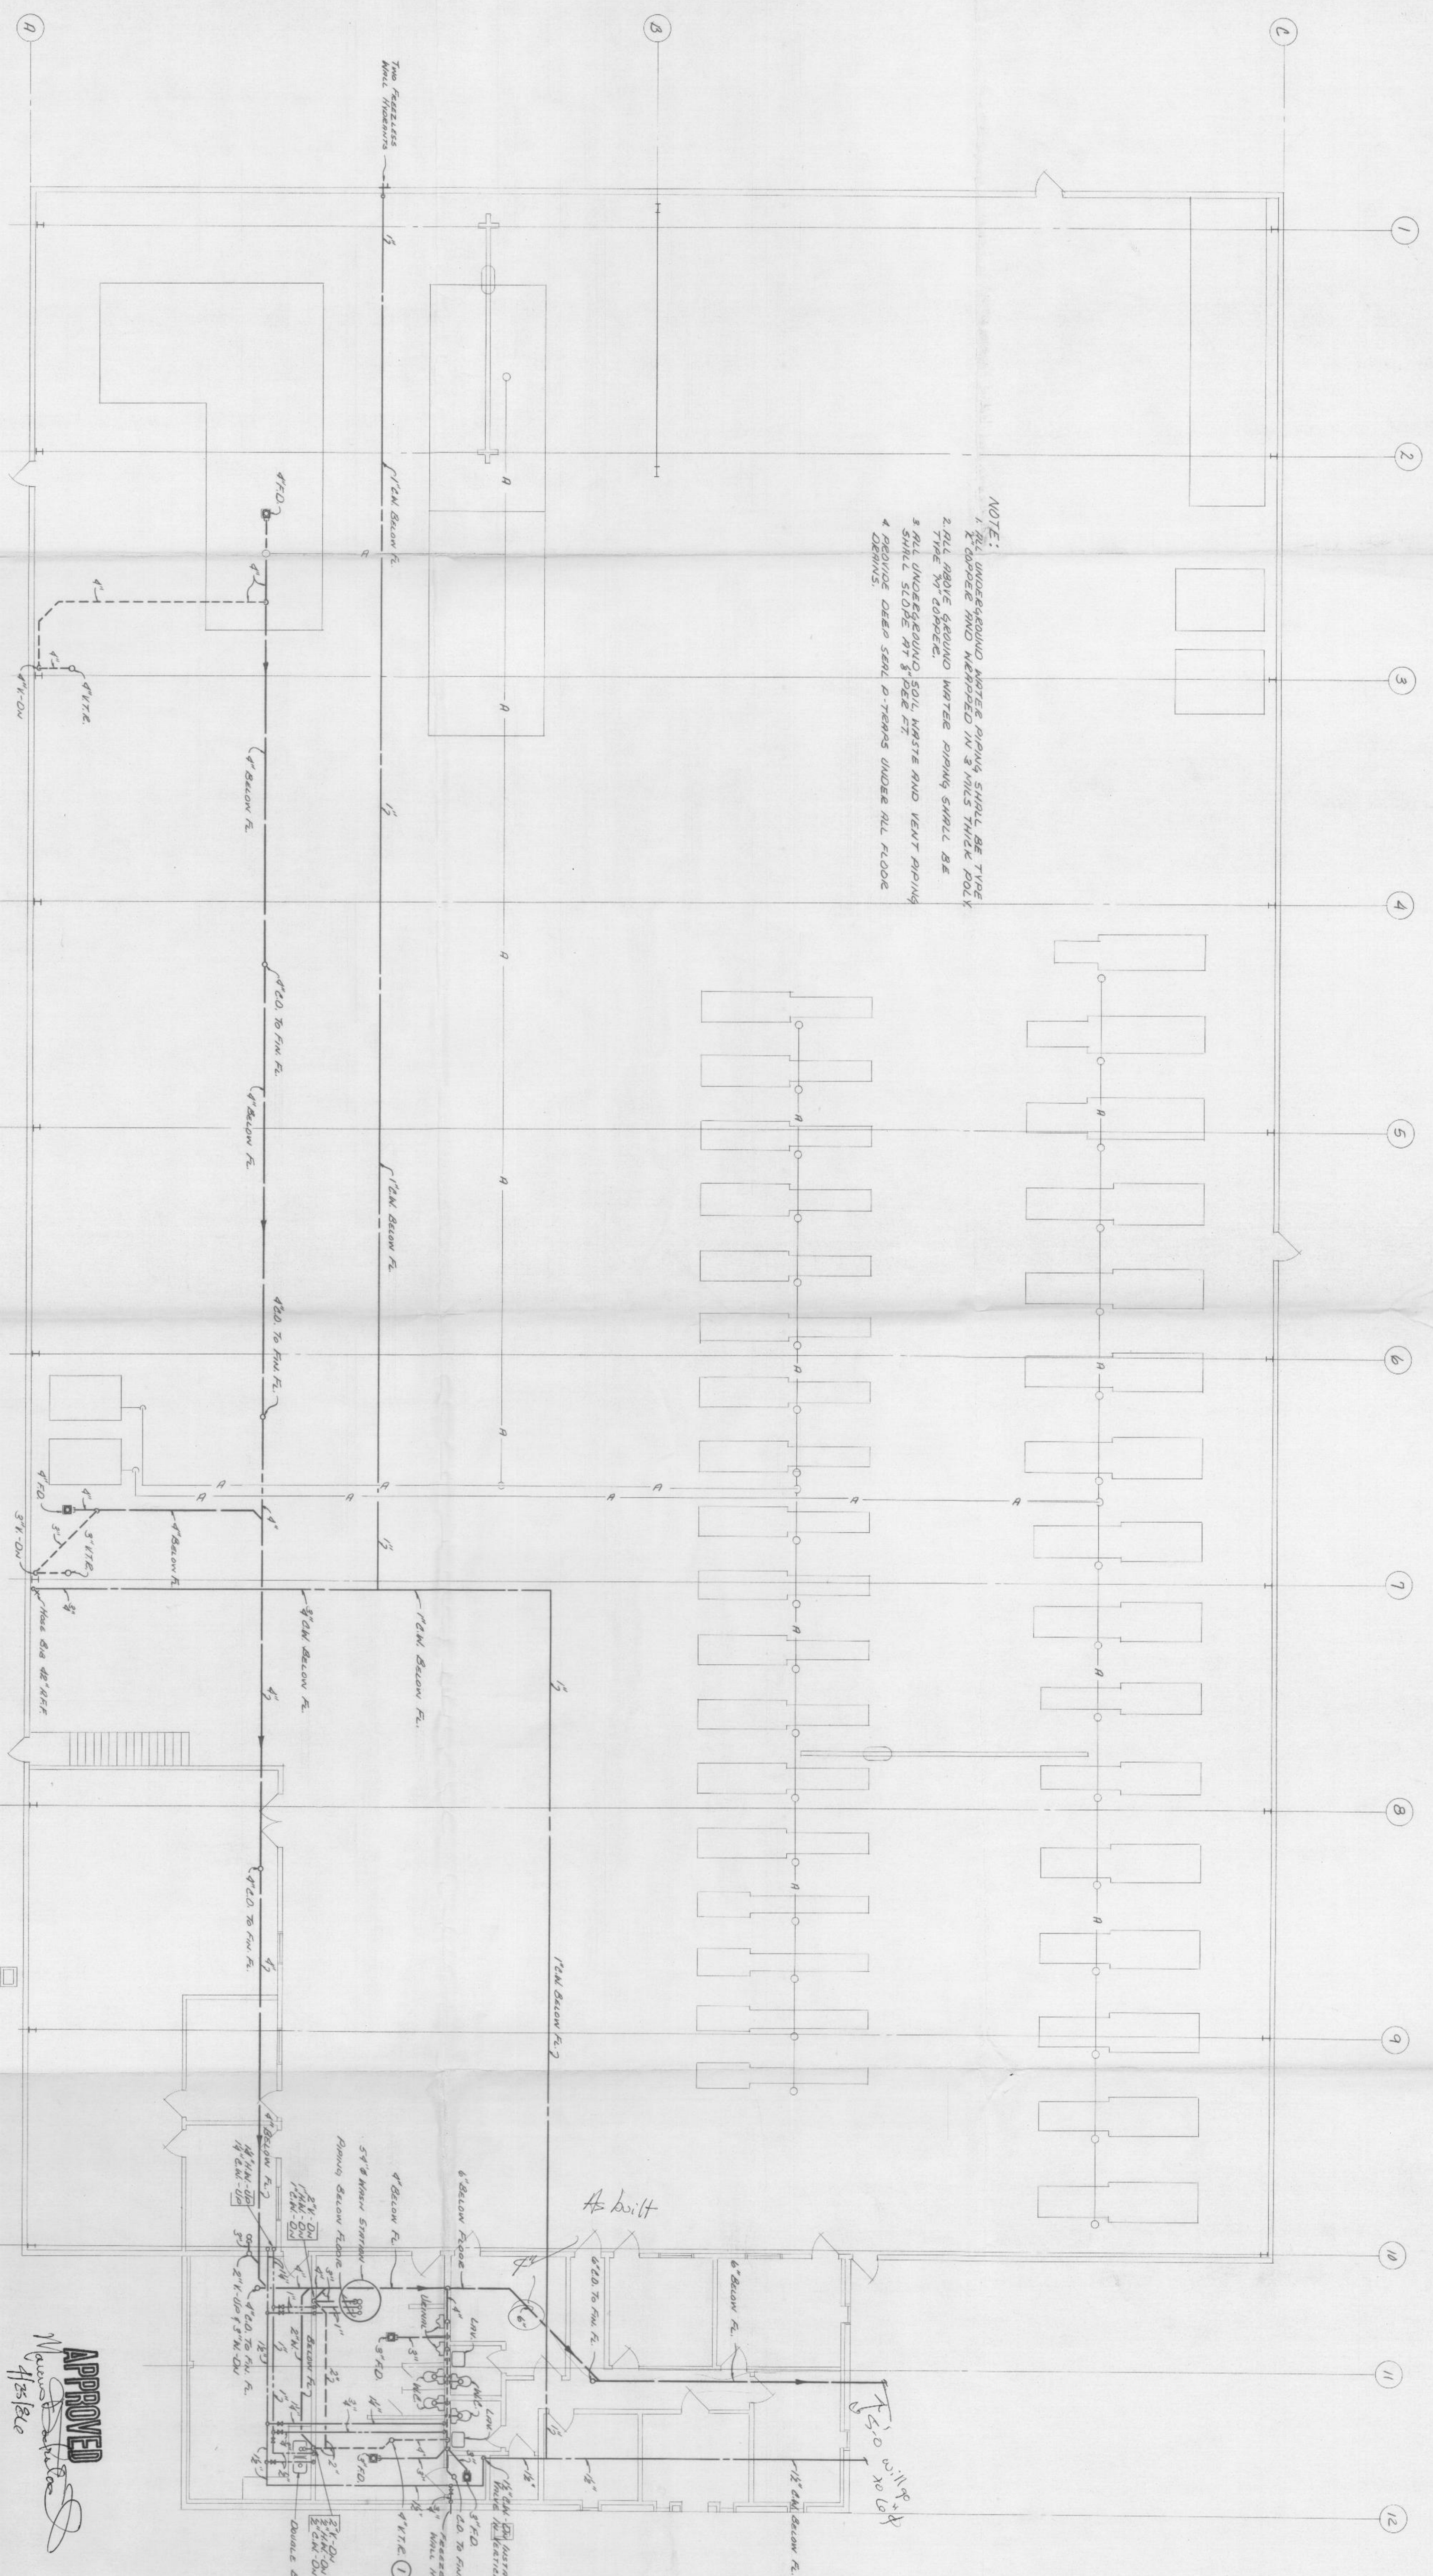


FLOOR PLAN
 SCALE: 1/8" = 1'-0"

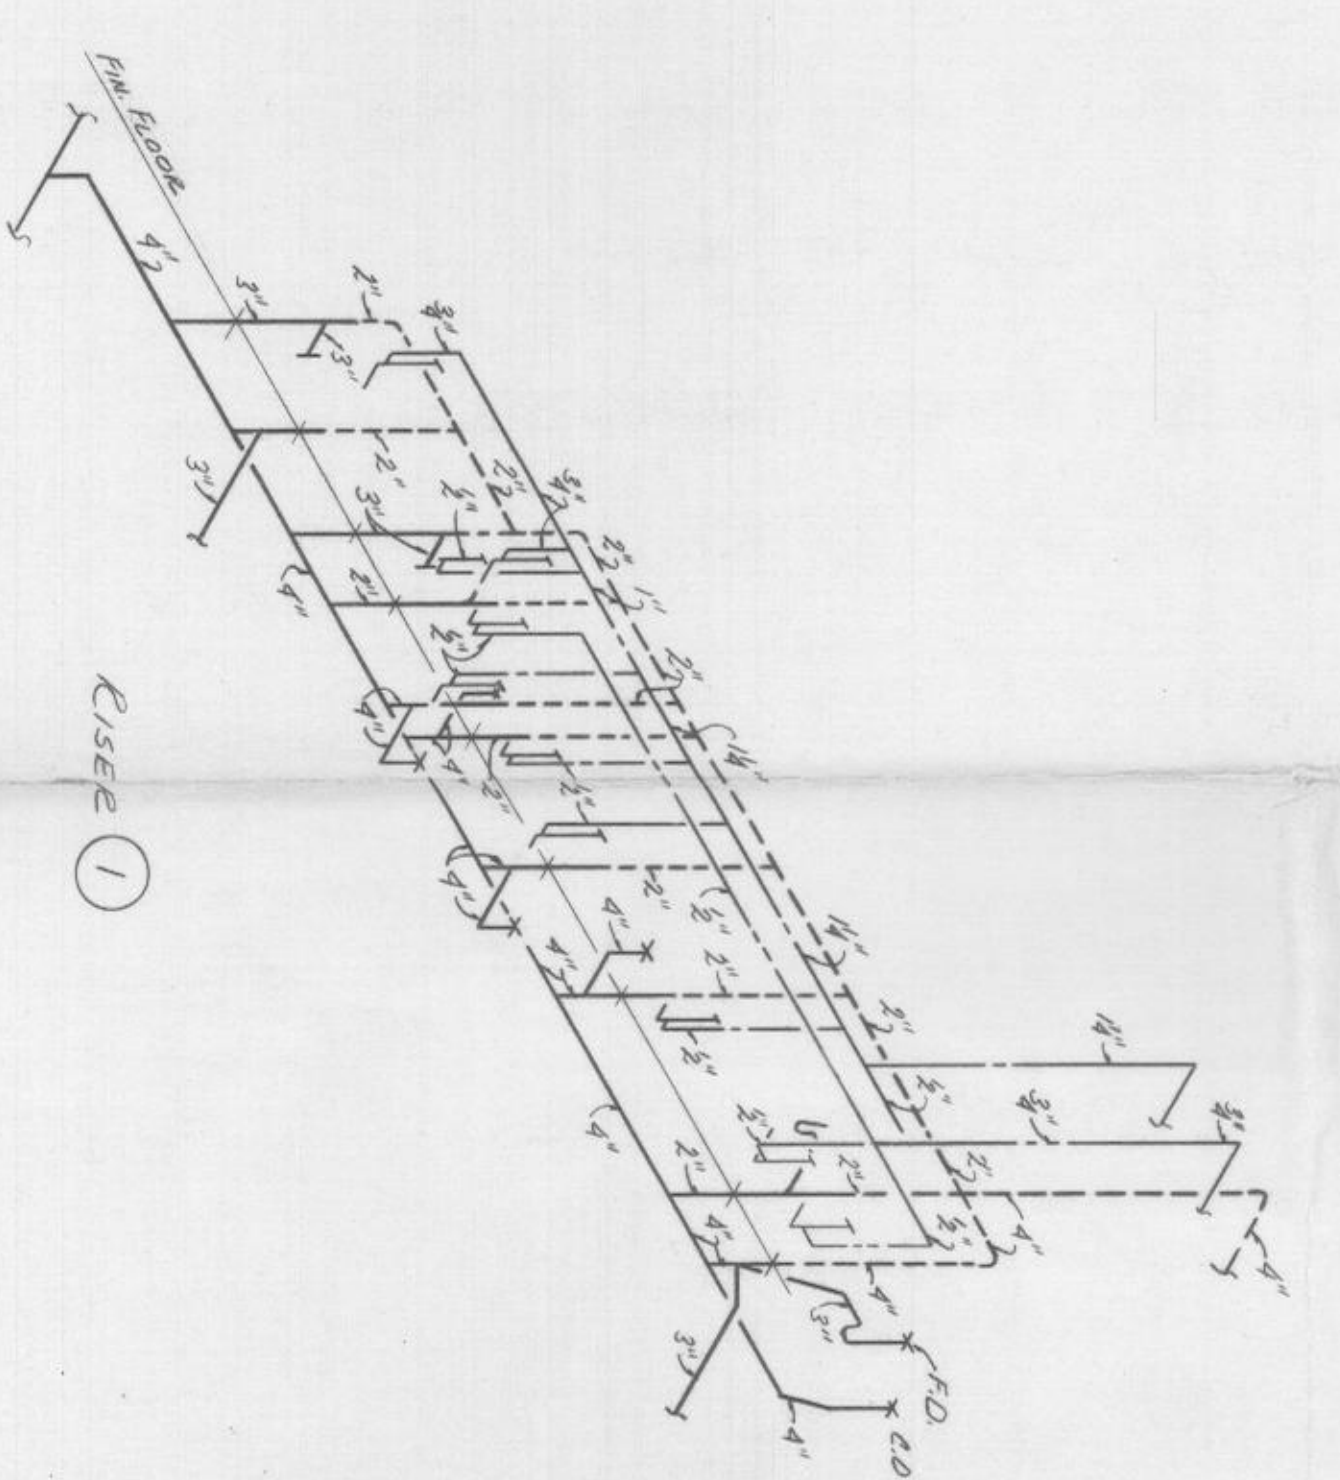

DOMESTIC WATER HEATER DETAIL
 NO SCALE

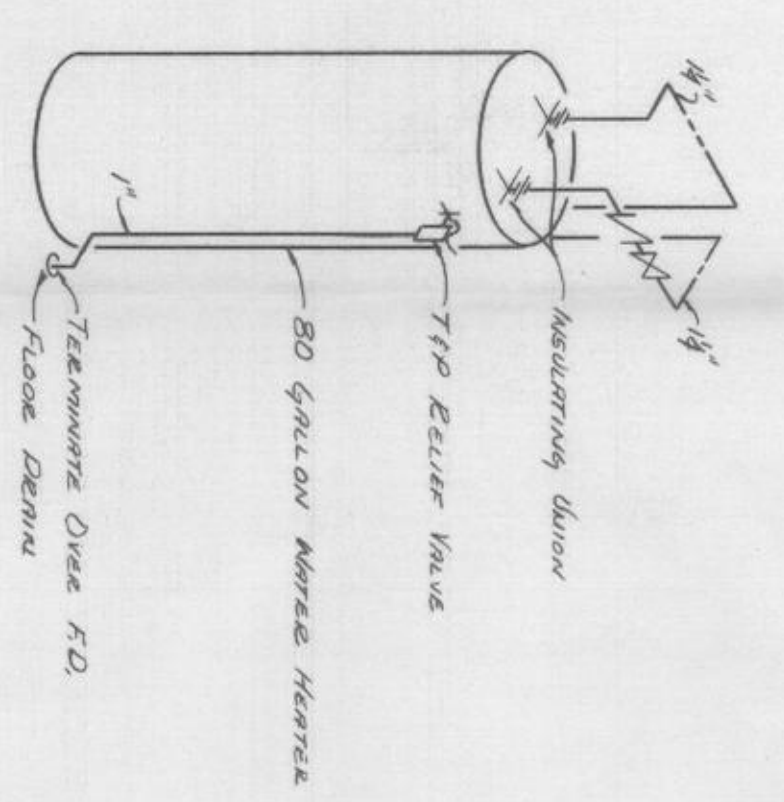

DECK FLOOR PLAN
 SCALE: 1/8" = 1'-0"

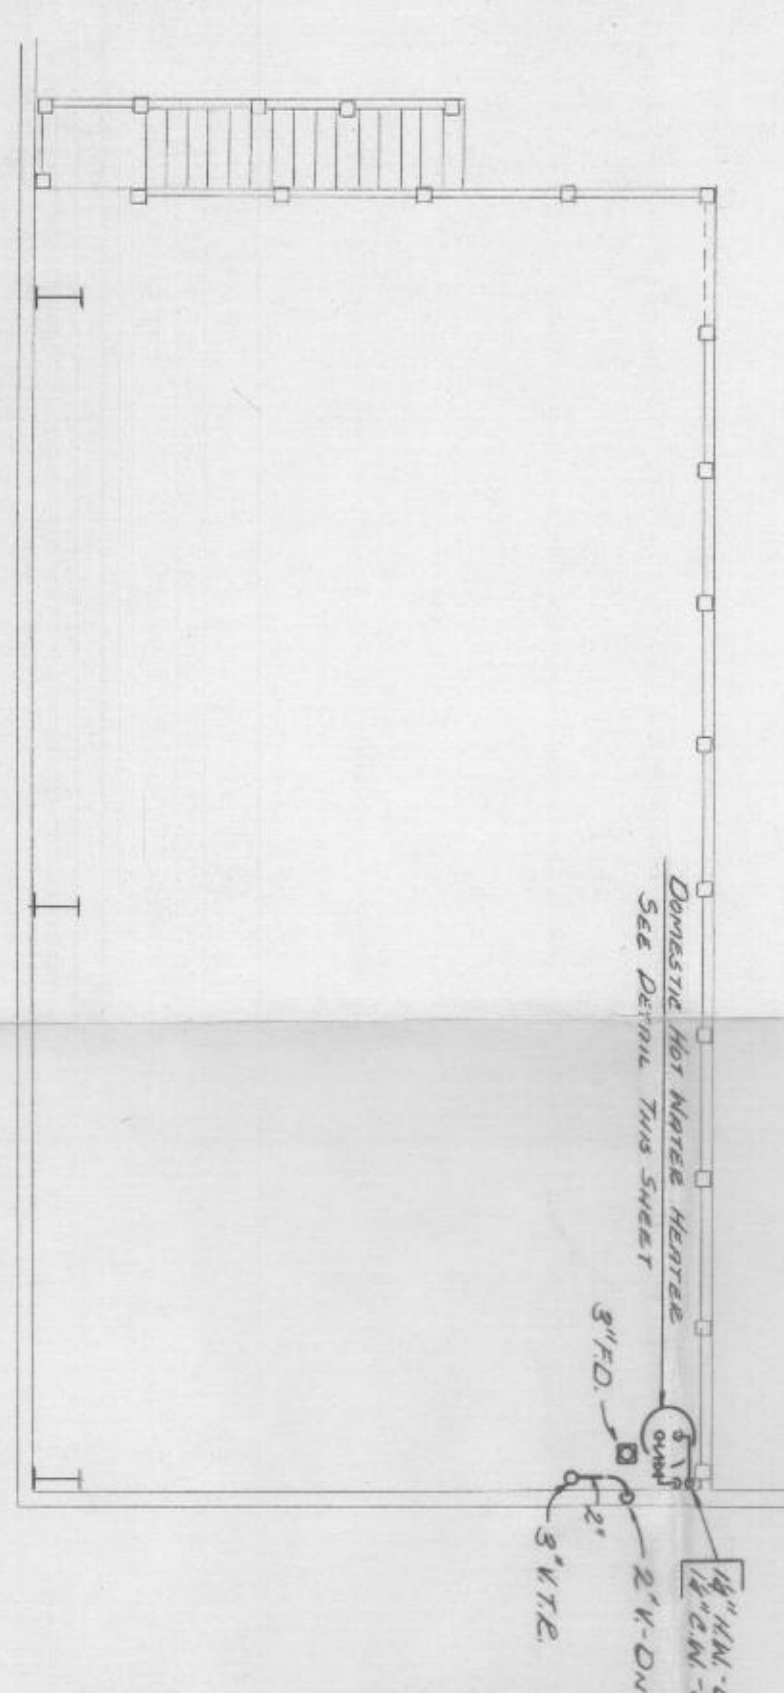

APPROVED
 [Signature]
 4/25/80
 All Plumbing Work Shall
 Meet the Requirements of
 The Basic Plumbing Code.

THESE DRAWINGS ARE HEREBY
 APPROVED FOR PERMIT AND
 ANNOTATED AS NEEDED TO
 MEET THE REQUIREMENTS
 OF THE CITY OF
 [Signature] CBA
 SHEETS 111 OF
 DATE OF PLANS 4/10/80

FILE

H&K MACHINE SERVICE PLUMBING FL. PLAN
 DRAWN FOR **HOSAK & SONS PLUMBING CO.**

	THE PACE ENGINEERING 412 S. BROADWAY ST. LOUIS, MISSOURI 63101	Consulting Civil Mechanical Electrical 314/587-2-8800	JOB NO. 8832 DATE 4-10-80 DWG. BY BDH CHK. BY SHEET NO.
	P-1		