


NORTH SANITARY PLAN
SCALE: 1"=30'

ROCK BACKFILL NOTE:
ROCK BACKFILL IS REQUIRED TO ALL STORM AND SANITARY SEWERS WITHIN 10' OF THE EDGE OF PAVEMENT AND THAT LIE WITHIN THE 1:1 SHEAR PLANE OF THE ROAD.

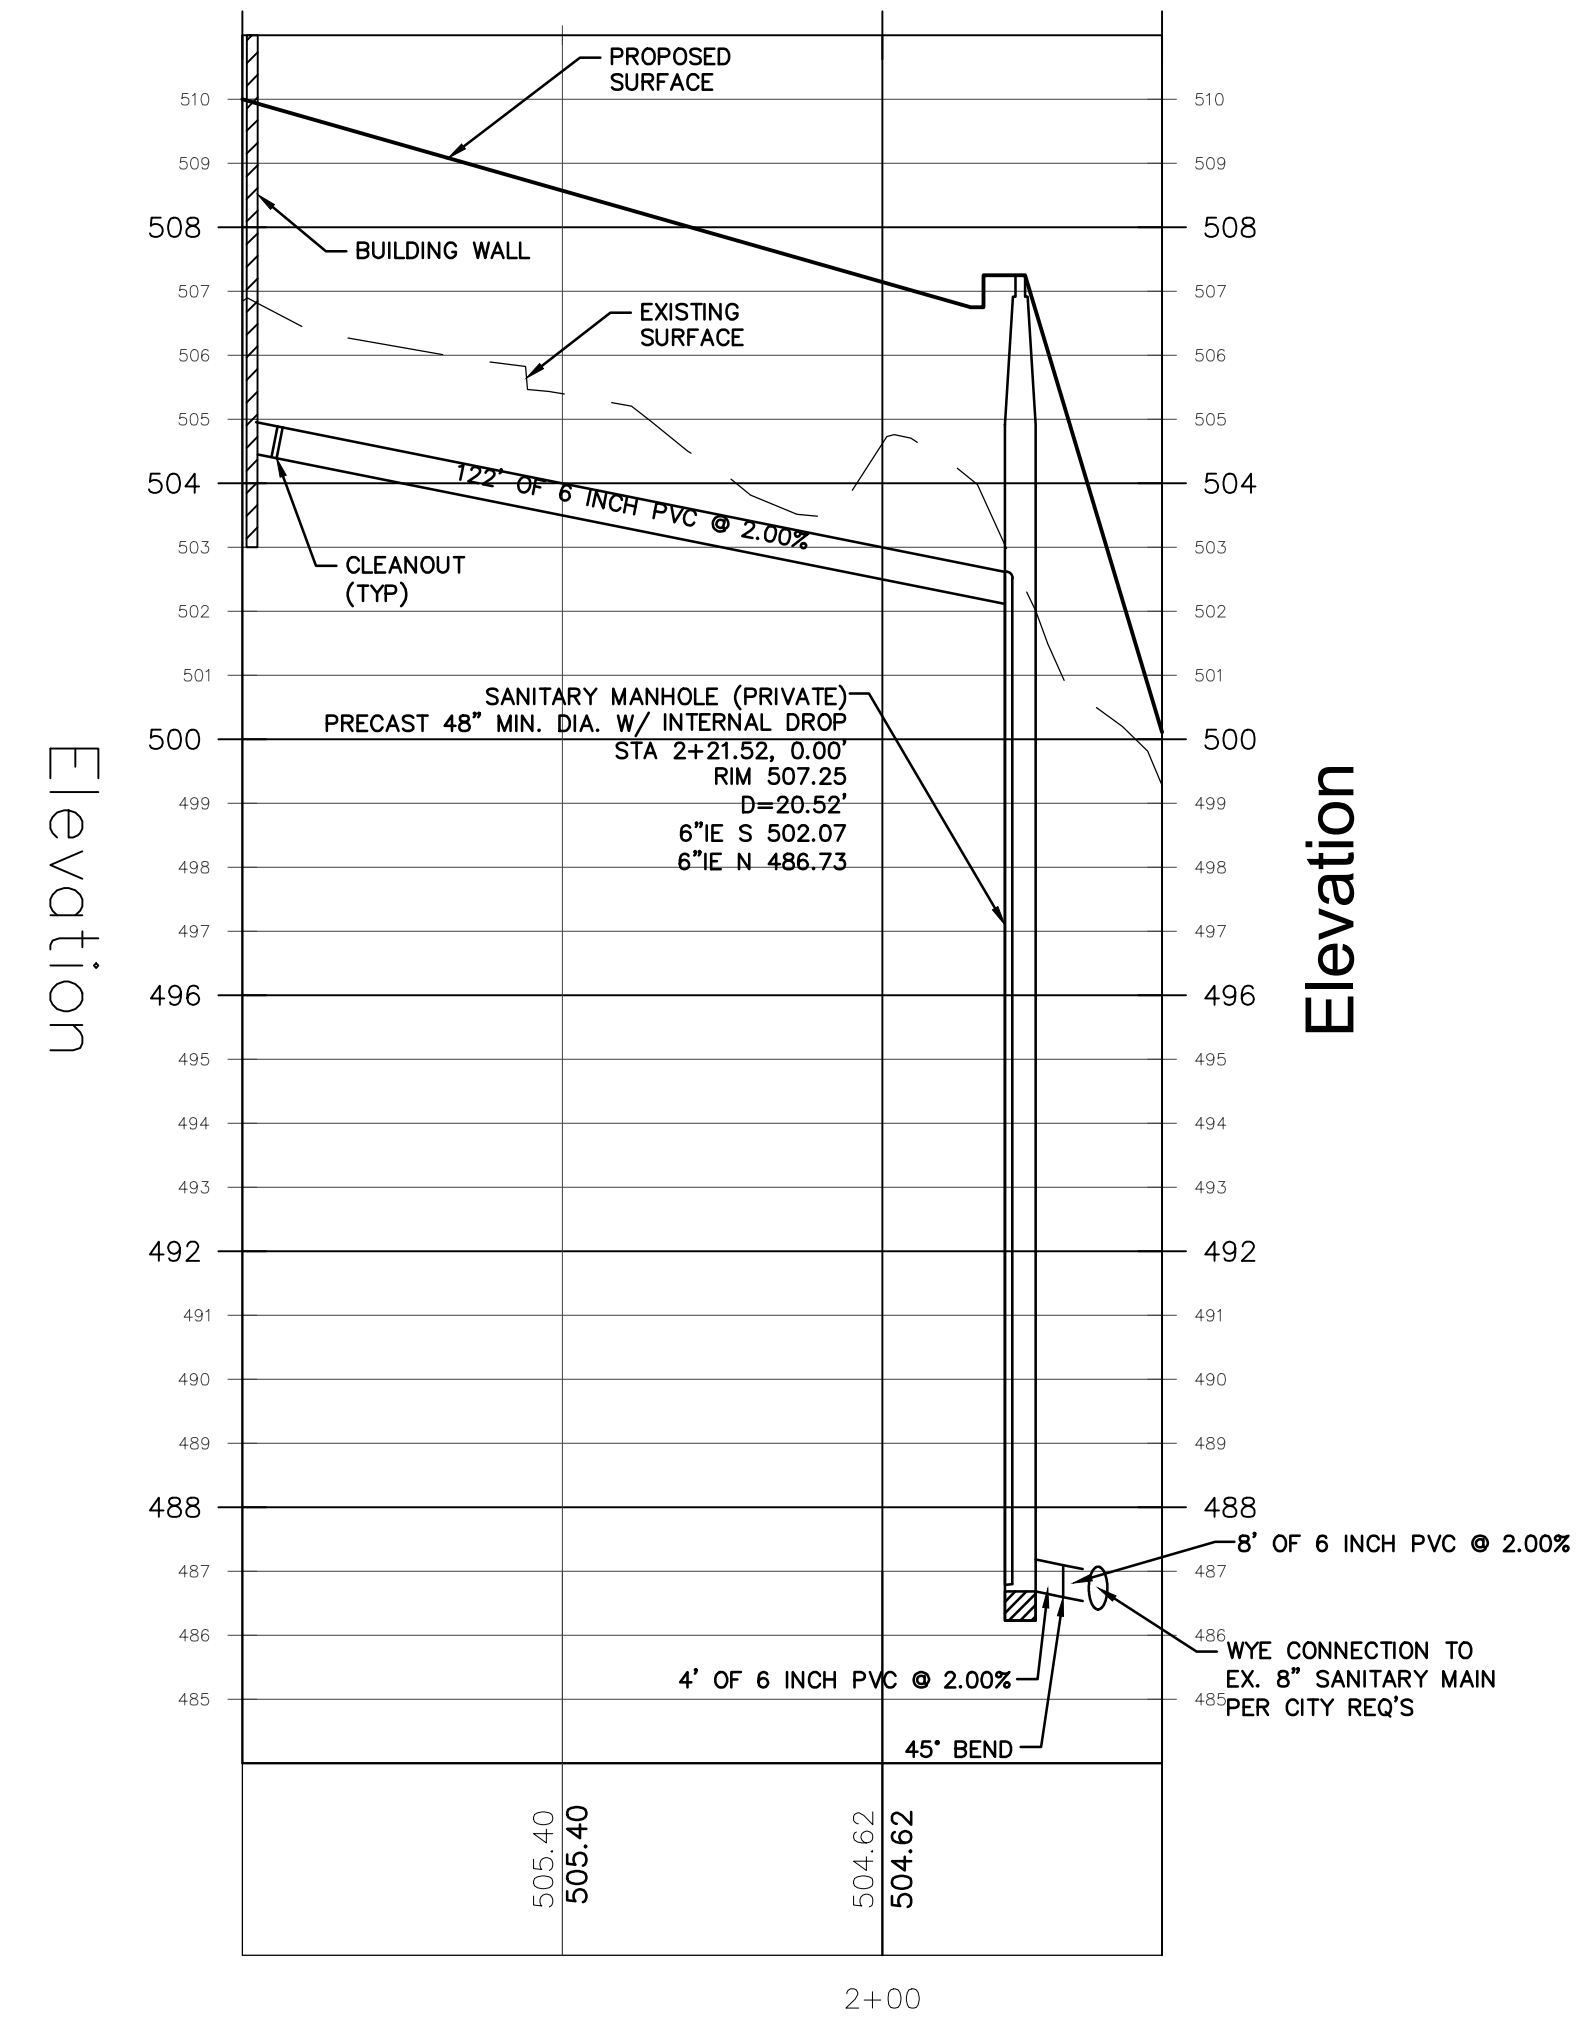


SANITARY PROFILE
SCALE: HORIZONTAL: 1"=30'
VERTICAL: 1"=3'

SANITARY SEWER NOTE:
ALL SANITARY SEWERS ON SITE TO BE PRIVATE

P+Z No. 16-000086
Approval Date: Jan 7, 2016
City No.: CSP-16-0000001



SANITARY PLAN & PROFILE

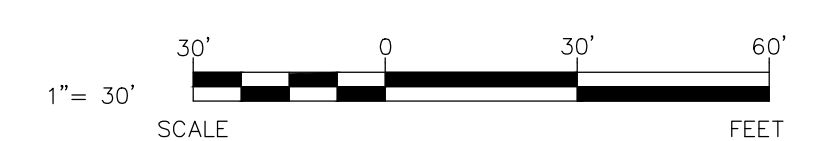

PRELIMINARY DRAWING - NOT FOR CONSTRUCTION

OWNER:
W.D.S. CONSTRUCTION, INC.
111 ROWELL STREET
BEAVER DAM, WI 53916

PROJECT:
BIOLIFE PLASMA CENTER
BRAMBLET CROSSING (LOT A)
O'FALLON, MO 63368

PRELIMINARY SHEET DATES:
DECEMBER 4, 2015
FEBRUARY 16, 2016

JOB NUMBER:
1514400
SHEET

C2.0

2015 © EXCEL ENGINEERING, INC.