


CITY OF O'FALLON, MISSOURI BIOTOWER COMPLEX MEDIA REPLACEMENT

CONTRACT NO. 07-006

JANUARY 2008

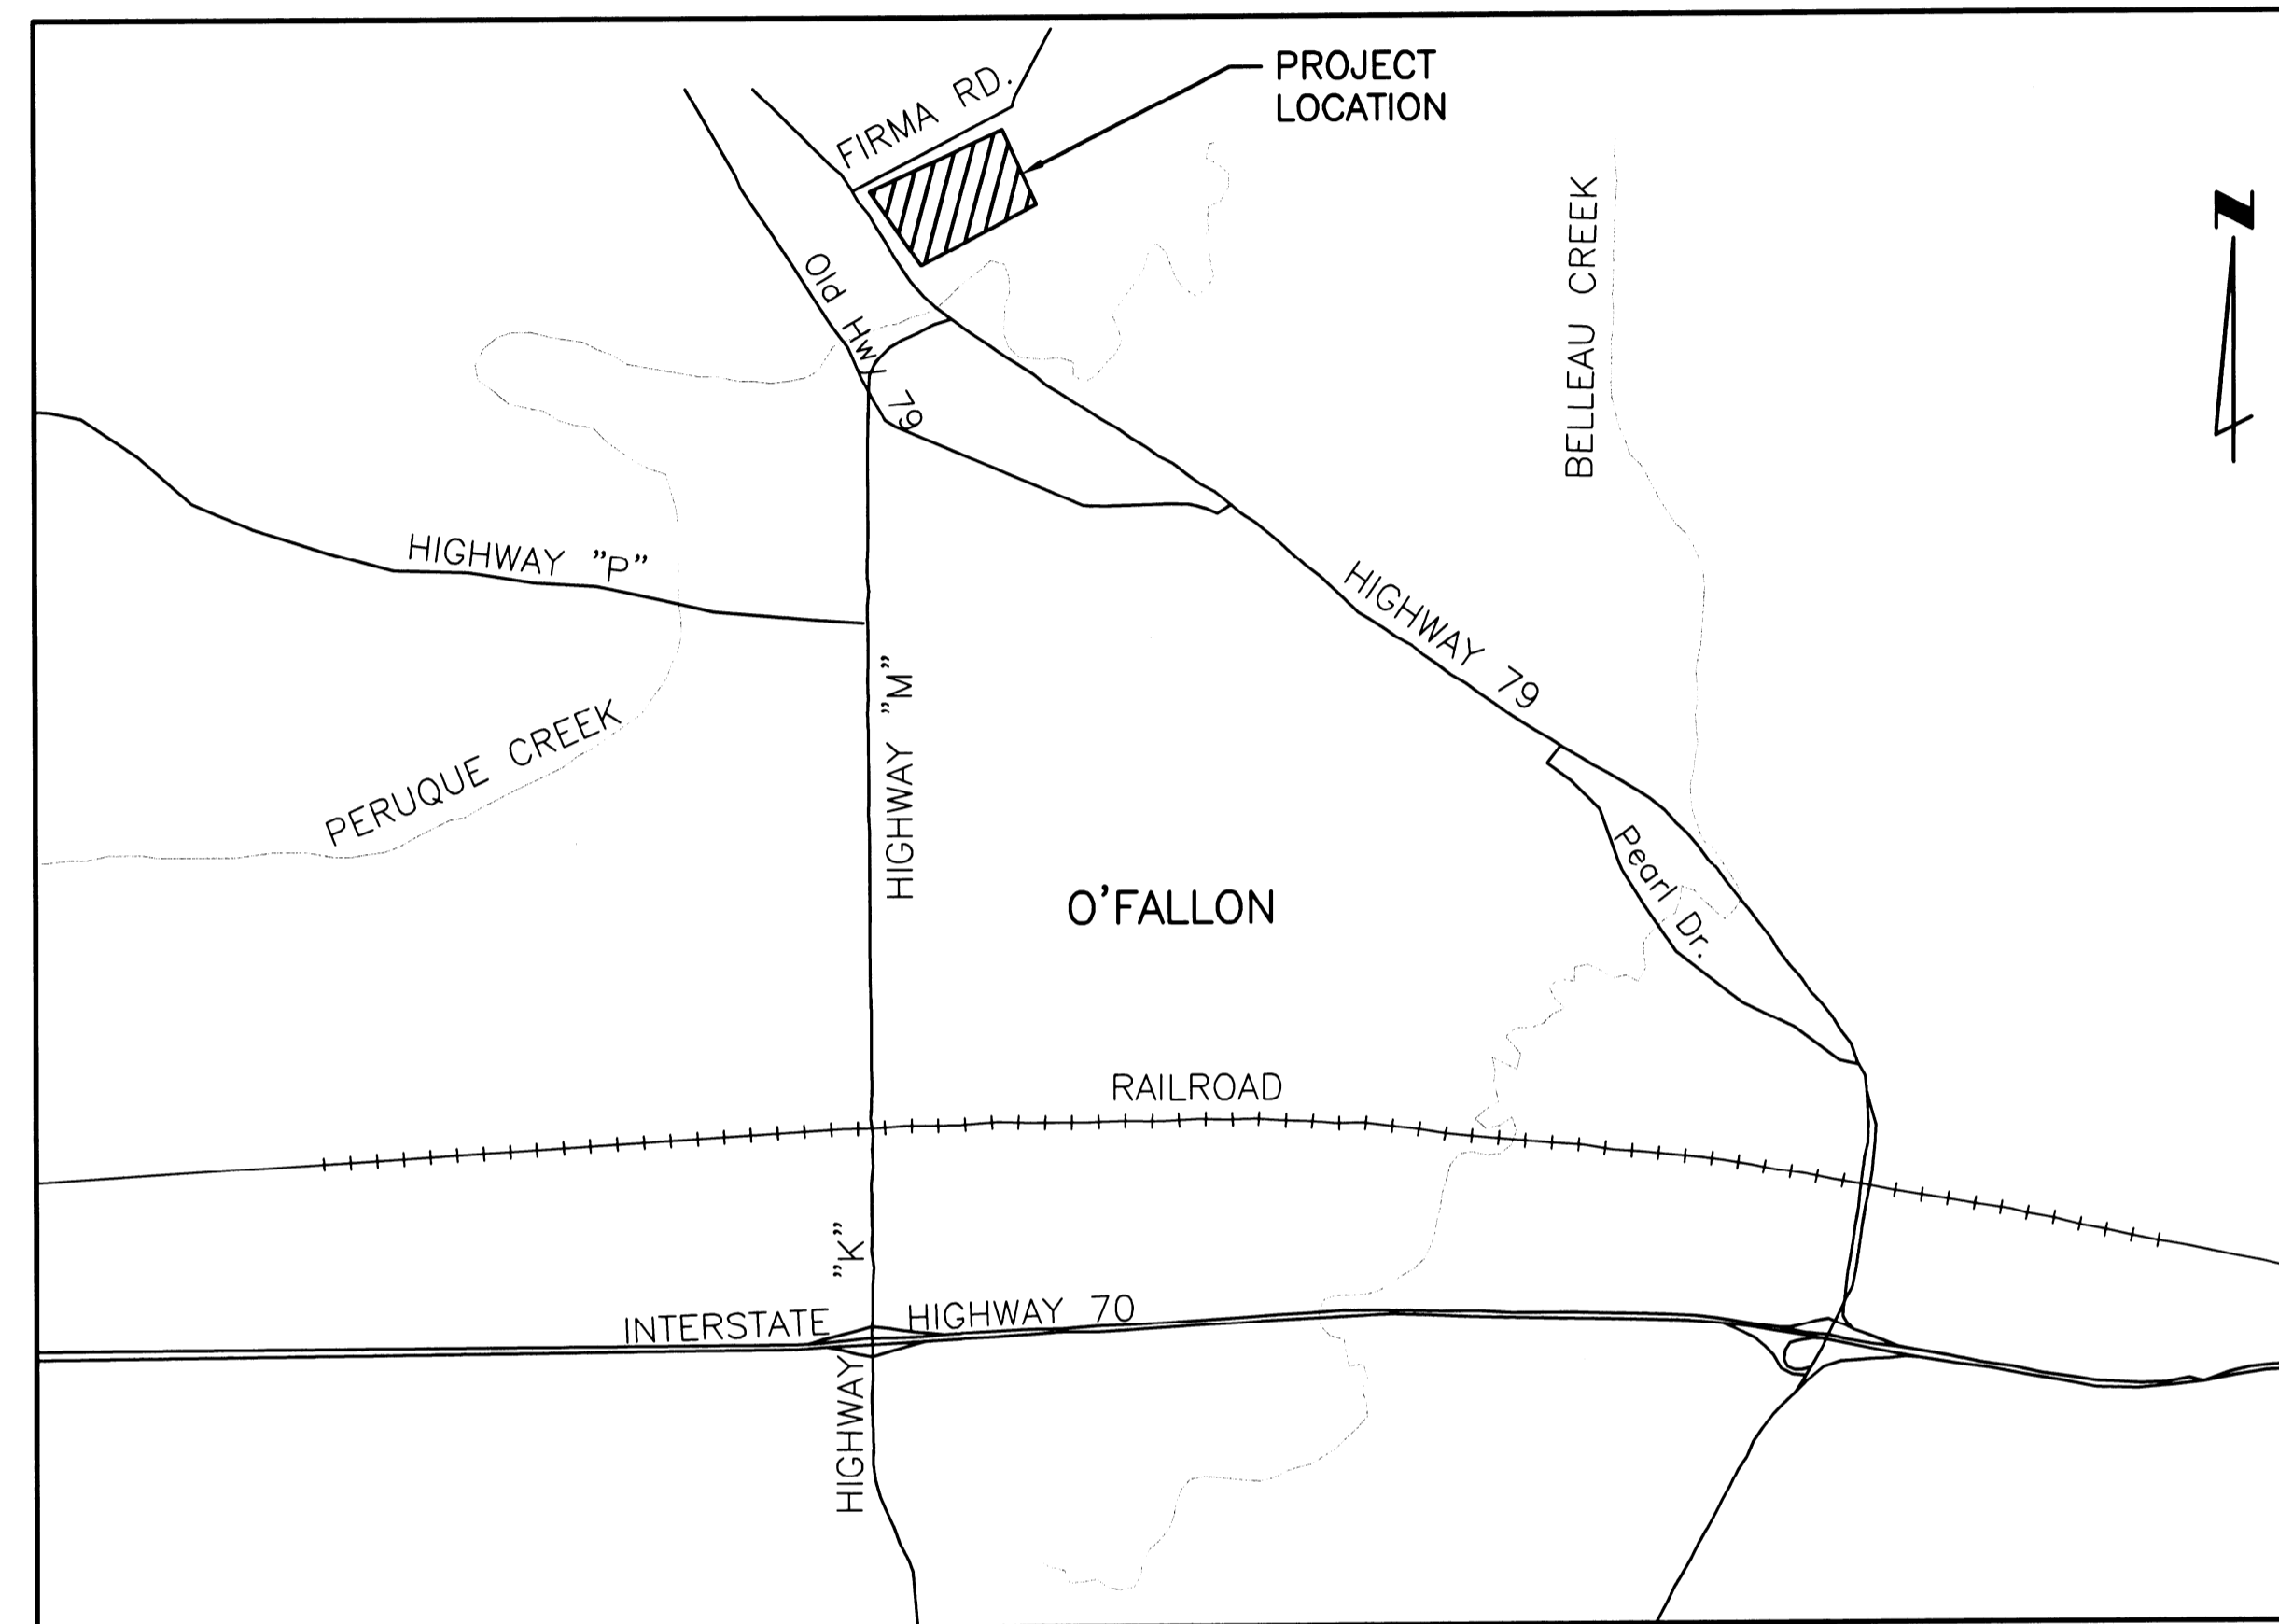

PROJECT LOCATION MAP

N.T.S.

SHEET LIST TABLE		
Sheet Number	Sheet Discipline Number	Sheet Description
1	G1	COVER SHEET
2	C1	SITE PLAN
3	D1	DEMOLITION AND REHABILITATION PLAN AND SECTIONS
4	D2	DEMOLITION AND REHABILITATION PLAN, SECTIONS AND DETAILS
5	D3	DEMOLITION AND REHABILITATION PLAN, SECTIONS, AND DETAILS
6	S1	BIOTOWER MEDIA, MEDIA SUPPORT, AND CONCRETE REHABILITATION PLAN, SECTIONS AND DETAILS
7	P1	DISTRIBUTION SYSTEM IMPROVEMENTS PLAN AND DETAILS
8	P2	BIOTOWER MEDIA PLAN, SECTION, AND DETAILS
9	M1	VENTILATION IMPROVEMENTS SECTIONS AND DETAILS
10	M2	VENTILATION IMPROVEMENTS SECTIONS AND DETAILS
11	E1	BIO-FILTER COMPLEX ELECTRICAL LAYOUT
12	R1	REFERENCE DRAWINGS FROM GBA WWTP EXPANSION, 1981 (26 TOTAL SHEETS)

LEGEND:
 (TR) TO REMAIN
 (TBR) TO BE REMOVED
 DIP DUCTILE IRON PIPE
 (TBR&R) TO BE REMOVED AND REPLACED
 EX. EXISTING
 (TYP.) TYPICAL
 S.S. STAINLESS STEEL

CITY OFFICIALS

MAYOR - DONNA MORROW

ALDERMEN

DANIEL CHRISTOFF - WARD 1
 BILL GARDNER - WARD 1
 PIERCE CONLEY - WARD 2
 RICK LUCAS - WARD 2
 JOHN HARMAN, JR. - WARD 3
 JEFF YELICH - WARD 3
 BILL HENNESSY - WARD 4
 JEFF SCHWENTKER - WARD 4

OFFICIALS

CITY ADMINISTRATOR - BOB LOWERY, JR.
 CITY CLERK - PAM SMITH
 MANAGING DIRECTOR OF COMMUNITY DEVELOPMENT - JACK STRICK

OPERATORS

ALLIANCE WATER RESOURCES
 PRESIDENT - GARY ANGER
 DIVISION MANAGER - GARY JOHNSON
 UTILITY MANAGER - DAN SCHERER
 WWTP SUPERVISOR - RICK STEPHAN

BID SET



**HORNER &
SHIFRIN, INC.**
ENGINEERS

5200 OAKLAND AVE. • ST. LOUIS, MO 63110-1490
 314-531-4321 • FAX 314-531-6966
 www.HornerShifrin.com