



OPERATING FLOOR PLAN
Scale: 1/4" = 1'-0"

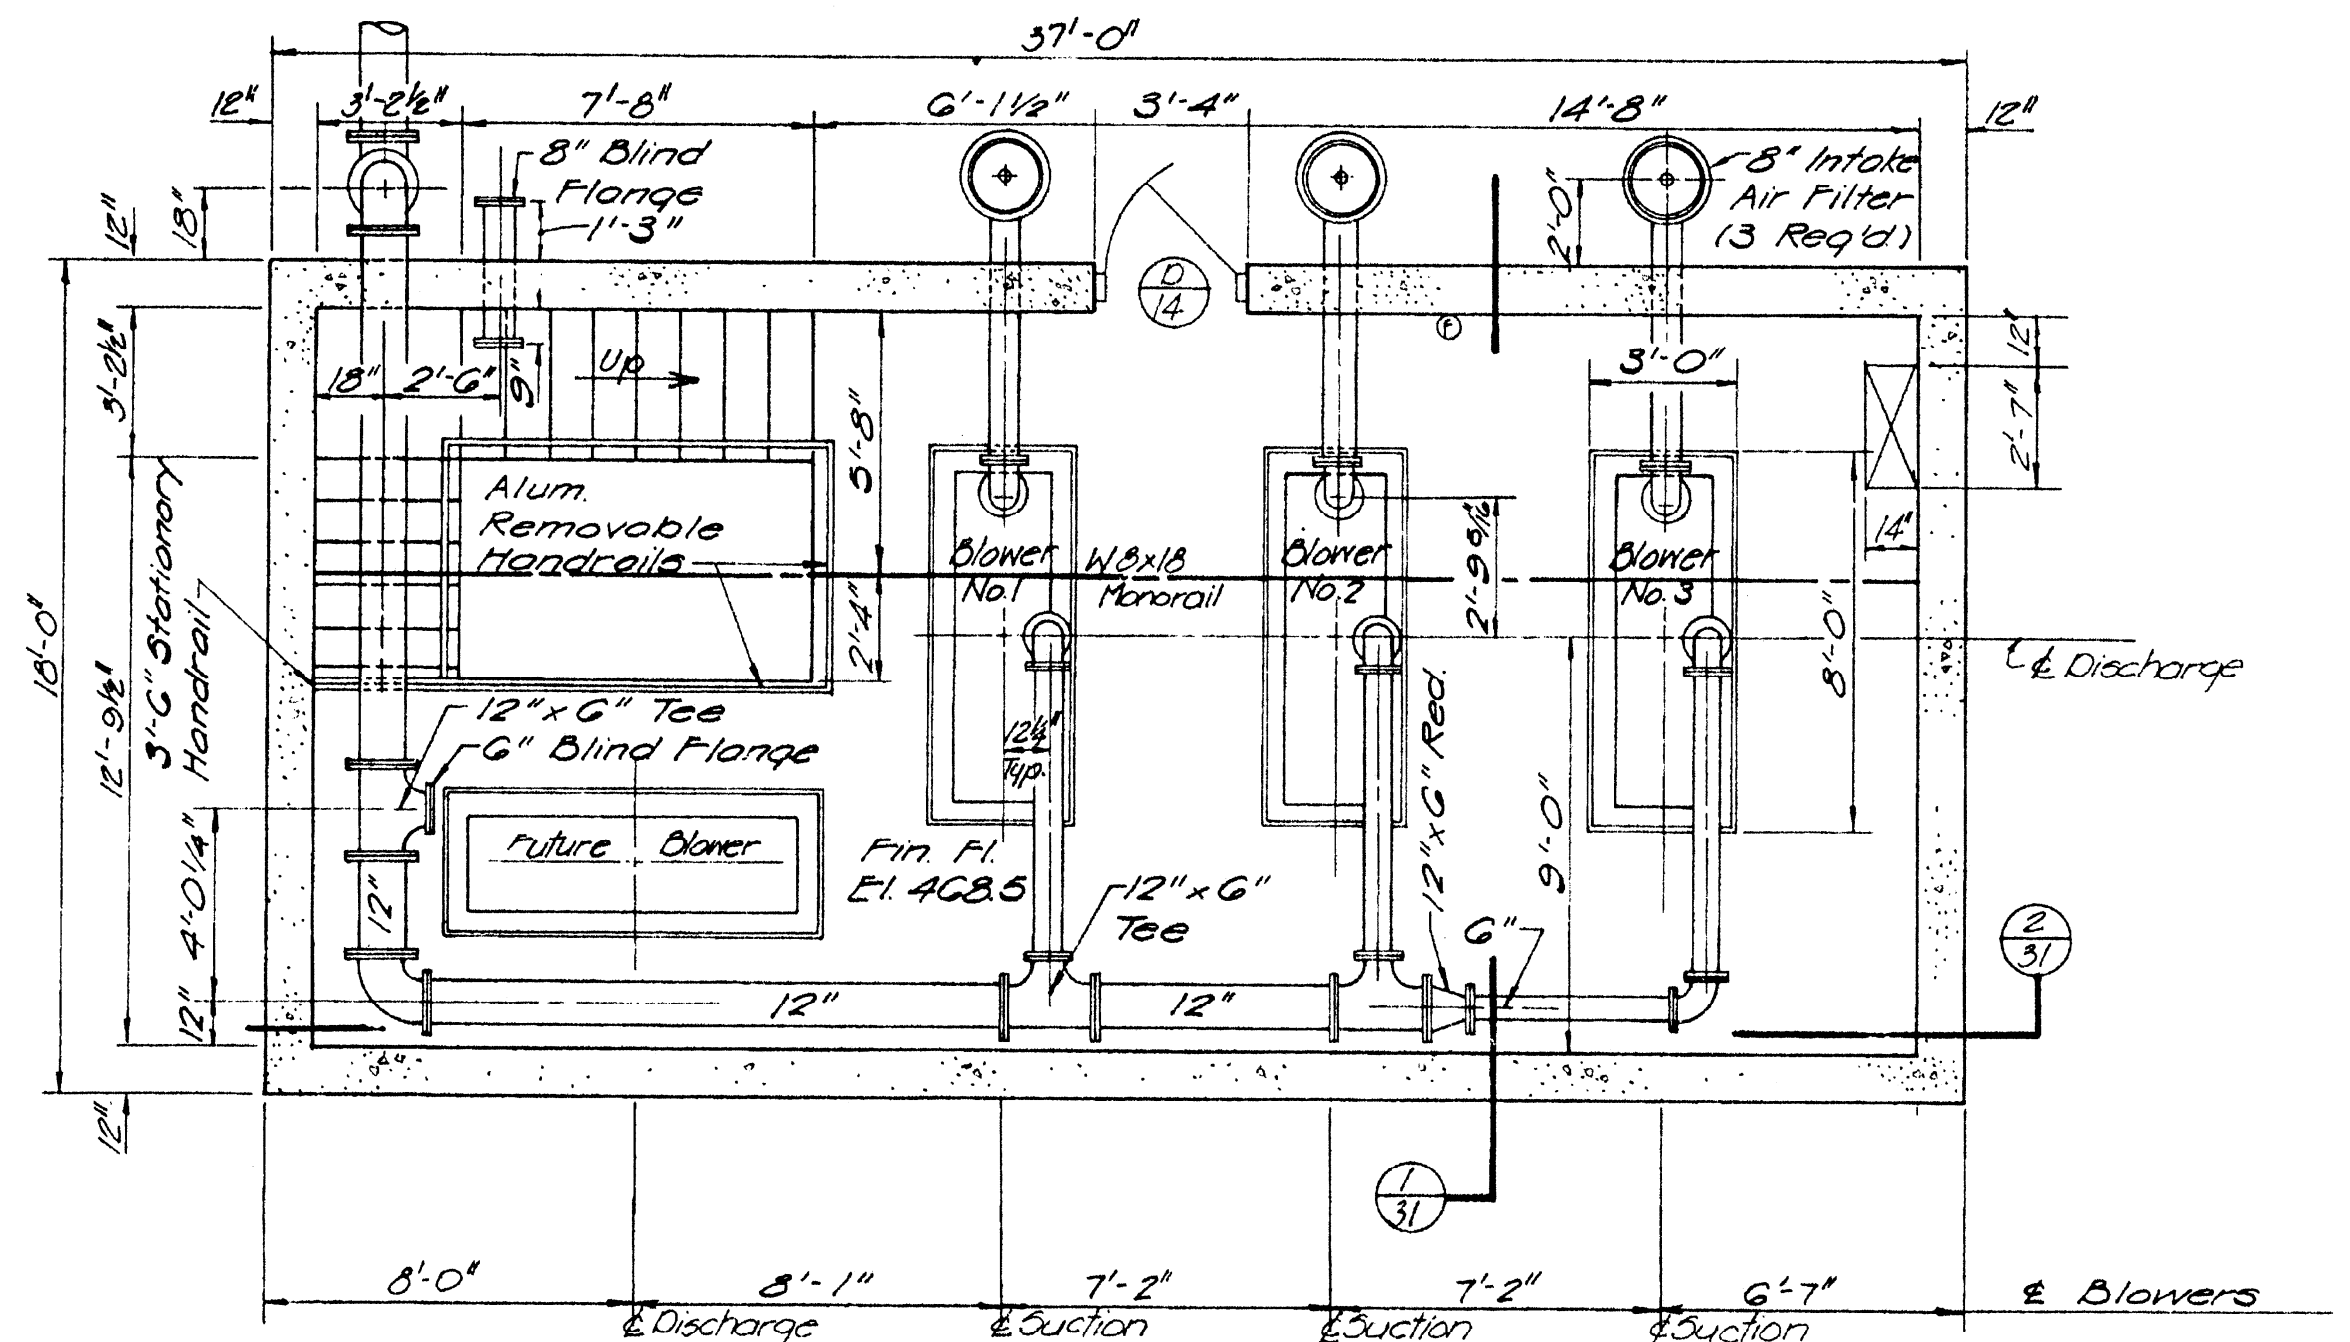

BLOWER FLOOR PLAN
Scale: 1/4" = 1'-0"

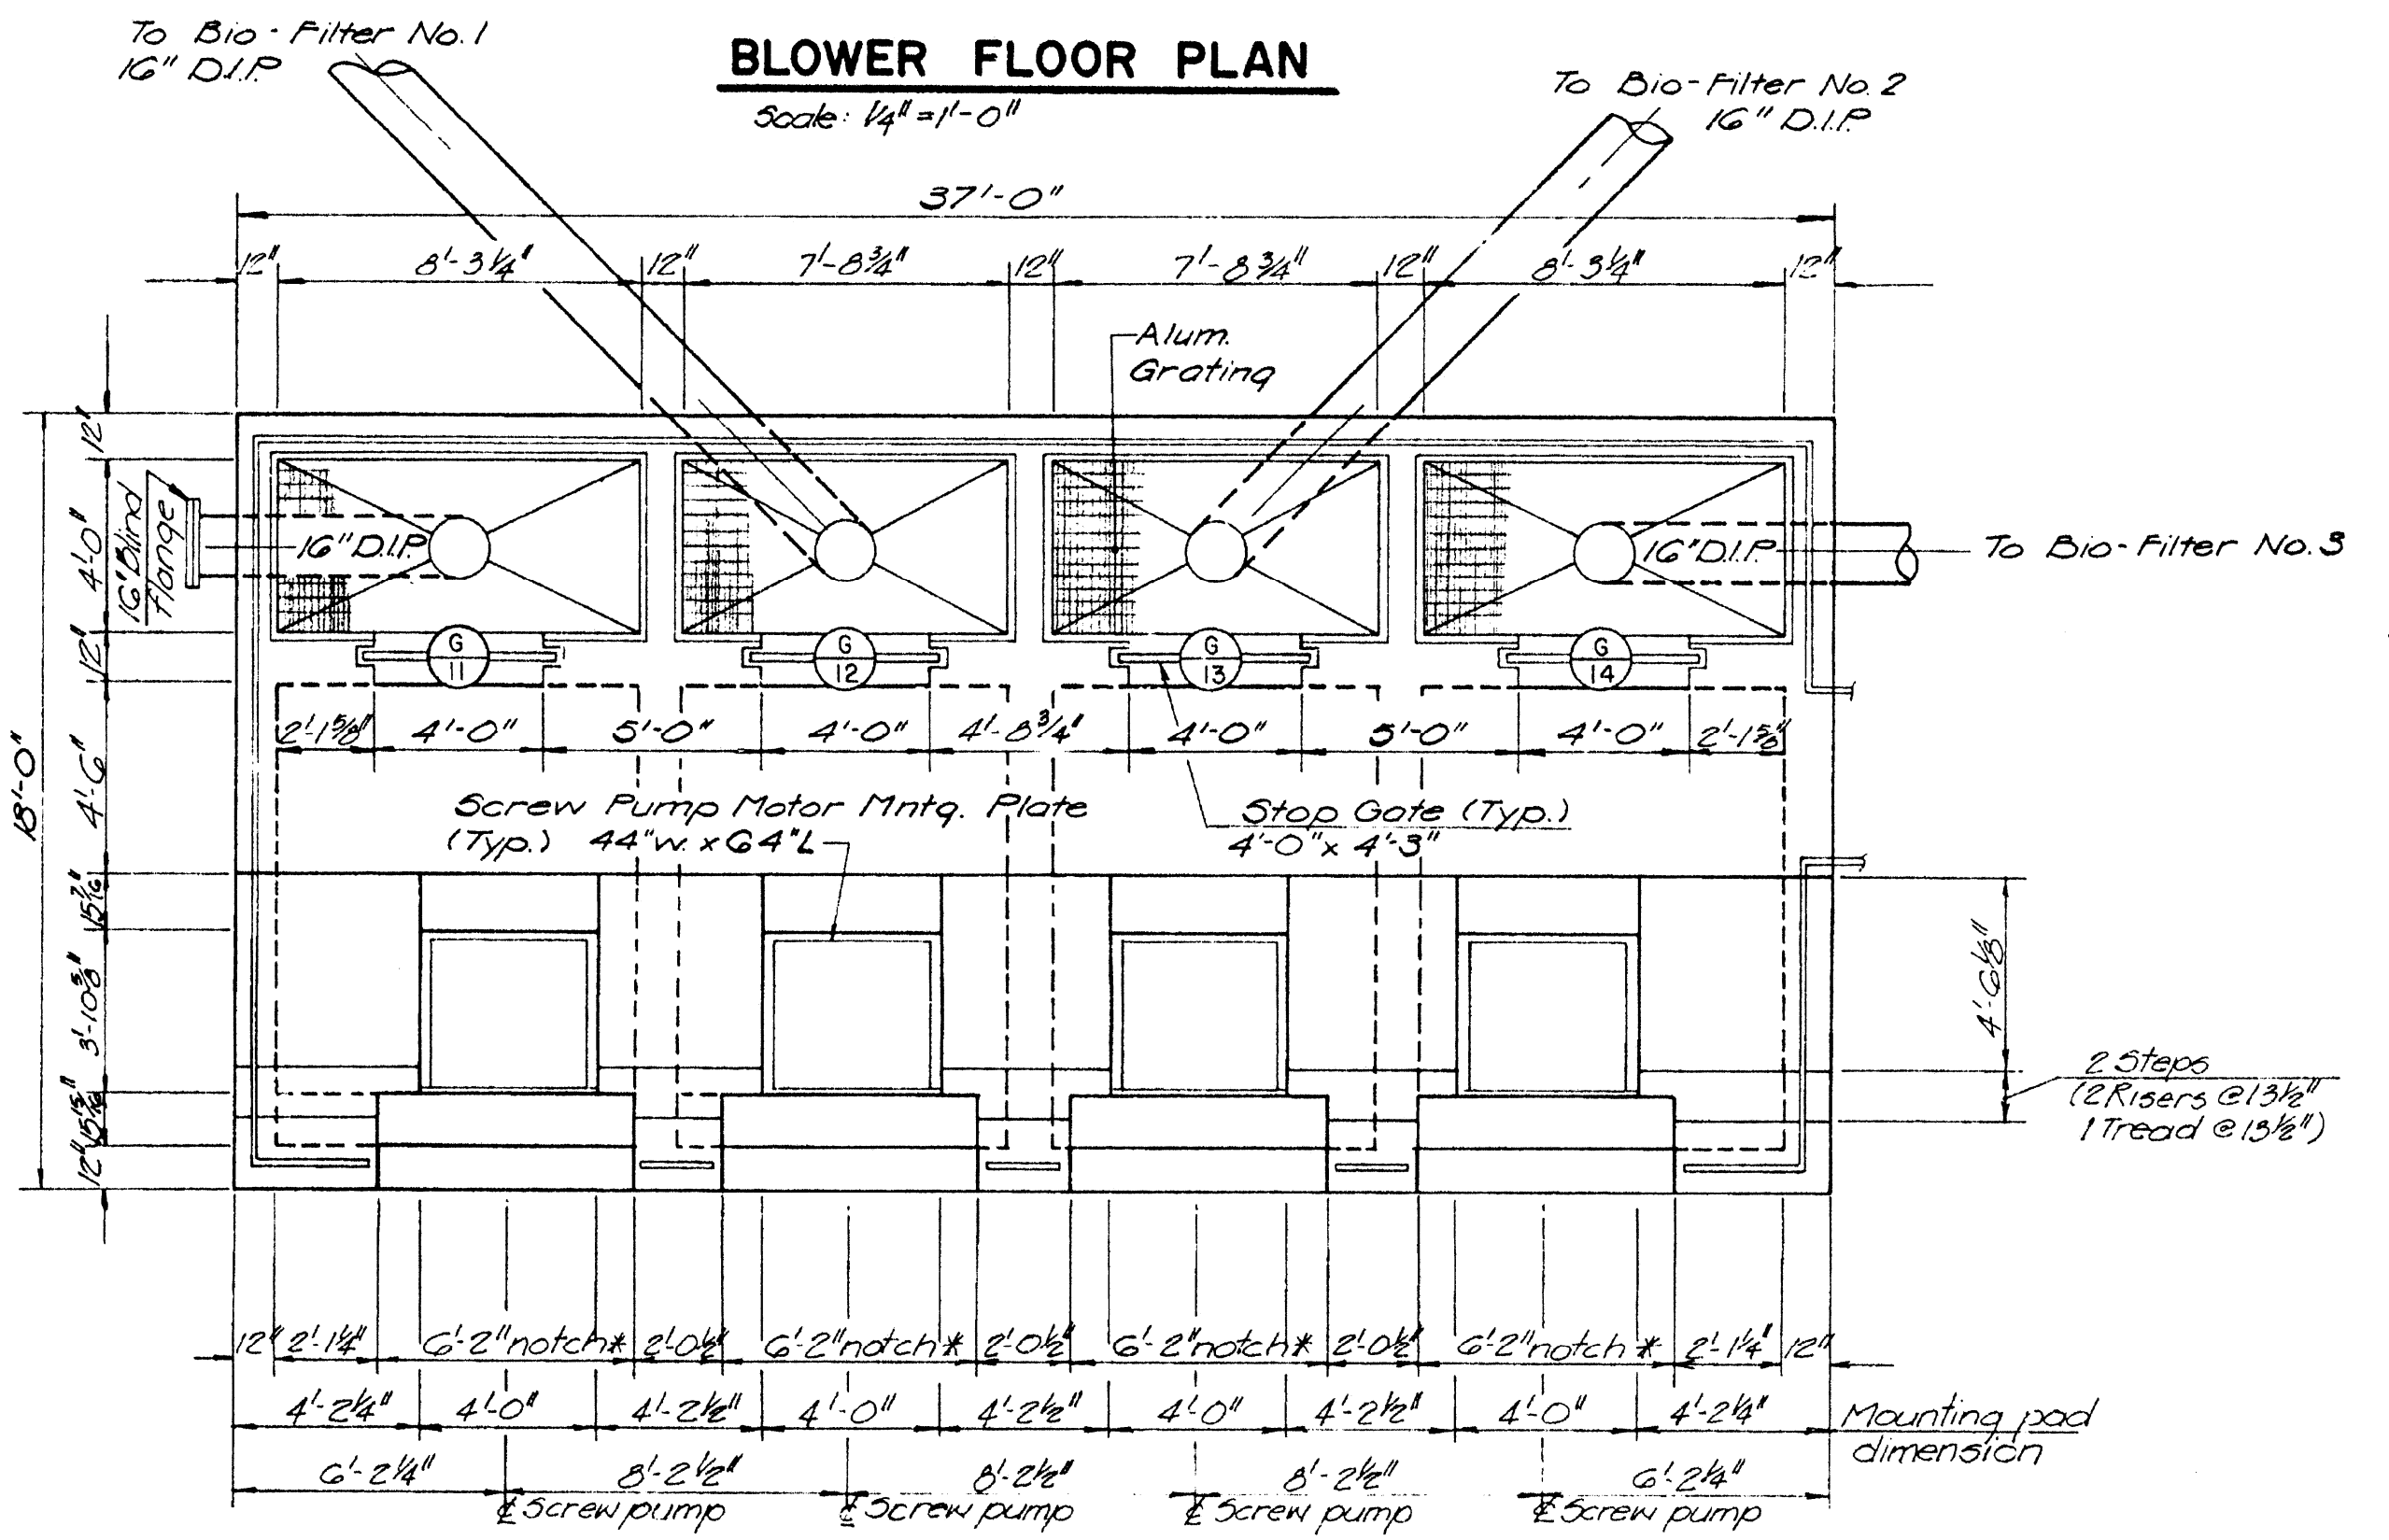

UPPER LEVEL PLAN
Scale: 1/4" = 1'-0"

* Notch on wall - Depth to be determined by equipment purchased.

© Fire Extinguisher

Note 1) Eyebolt and Eyebolt assembly shall be capable of sustaining a 3000 lbs working load.

EPA PROJECT NO. C291090

GBA
GEORGE BUTLER ASSOCIATES
CONSULTING ENGINEERS/ARCHITECTS
LANDSCAPE ARCHITECTS/PLANNERS

OFFICE:
SUITE 305A FAIRWAY OFFICE CENTER
4210 JOHNSON DRIVE / SHAWNEE MISSION / KANSAS 66205
1100 CITY CENTER SQUARE
1100 MAIN / KANSAS CITY / MISSOURI 64105
SUITE 134 LANESIDE PLAZA II
6700 CORPORATE DRIVE / KANSAS CITY / MISSOURI 64120

WASTEWATER TREATMENT
PLANT EXPANSION
**BIO-FILTER COMPLEX-UPPER,
BLOWER & OPERATING FLOOR PLANS**
CITY OF O'FALLON, MISSOURI

JOB NO 79-2065
DATE July 30, 1981
SCALE As Shown
SHEET NO 19 of 88

DESIGNED BY W.C.C. DRAWN BY C. Raja CHECKED BY W.A.C.