


HVAC FIRST FLOOR PLAN - SOUTH WING
SCALE: 1/8" = 1'-0"

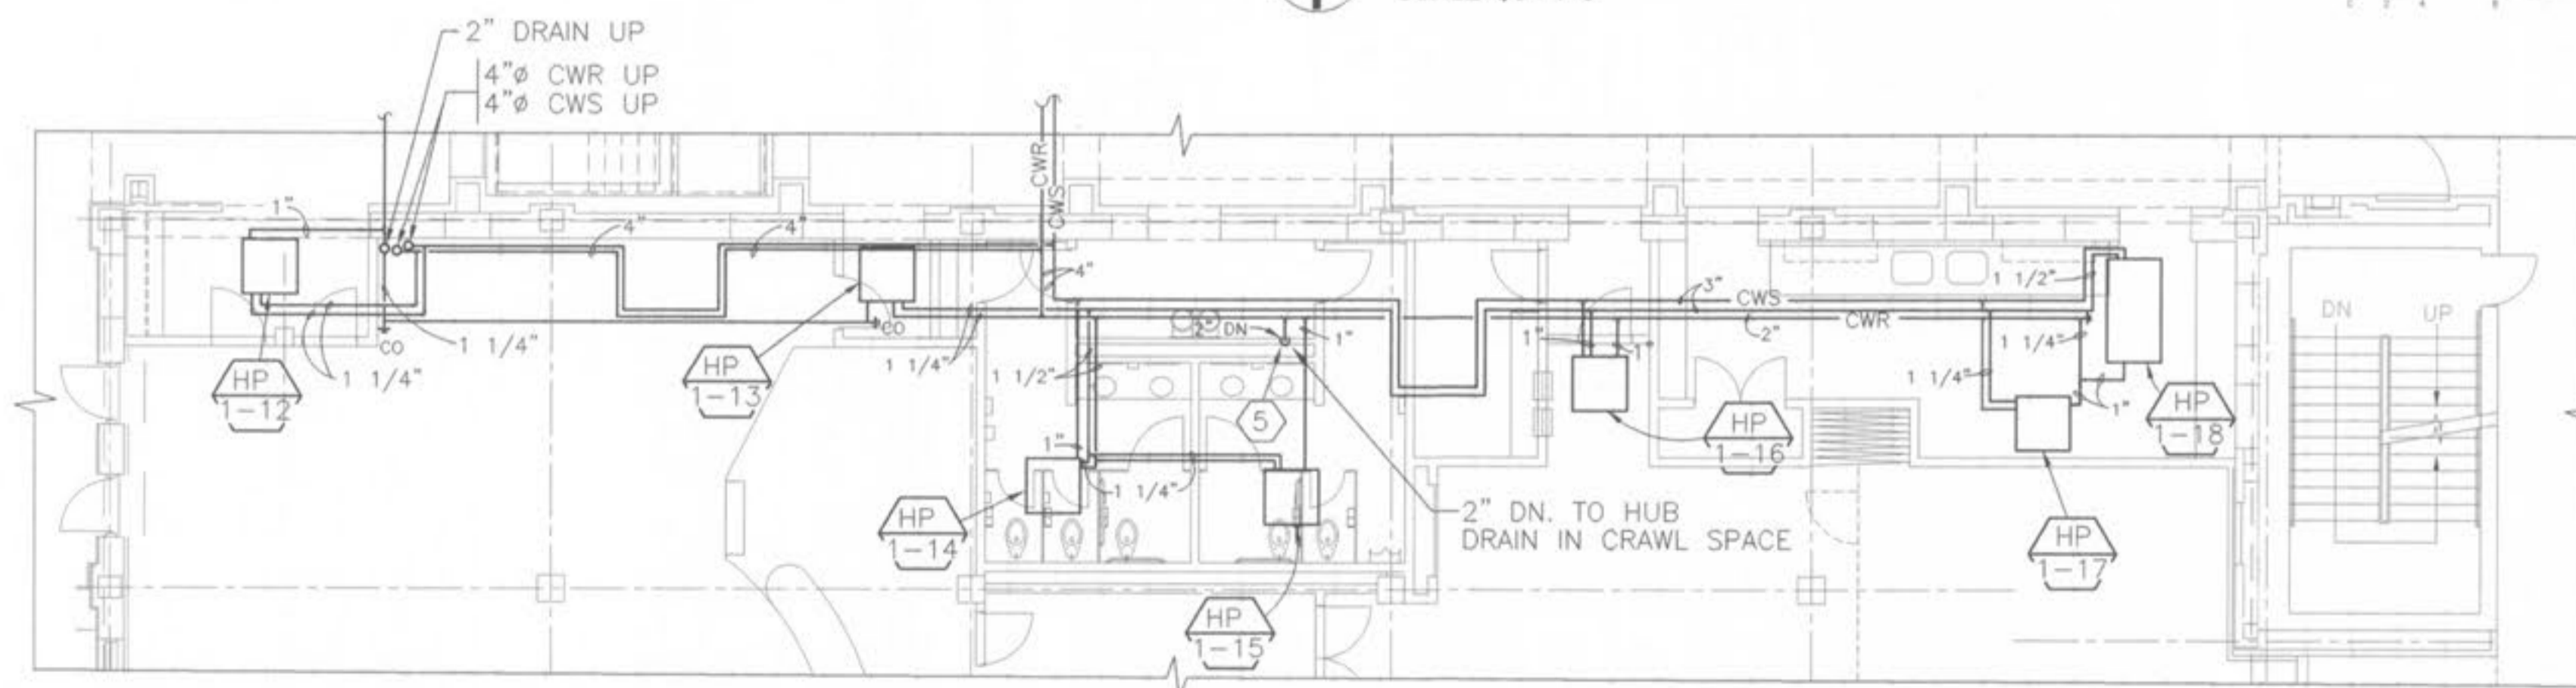

PARTIAL FIRST FLOOR PIPING PLAN - SOUTH WING
SCALE: 1/8" = 1'-0"

NOTE: FOR CLARITY CWS, CWR AND CONDENSATE PIPING FOR HEAT PUMPS WAS SHOWN HERE. SEE PLAN ABOVE FOR CONTINUATION.

KEYED NOTES (This sheet only)

- ① FOR CONTINUATION SEE SHEETS H-2.
- ② SOUND TRAP 22x10 IN RETURN PLENUM.
- ③ 24" POUND DUCT IN CRAWL SPACE. INSULATE WITH 2" EXTERNAL FIBERGLASS INSULATION PROVIDE WEATHER PROTECTSEAL JACKET.
- ④ THIS AREA IS USED AS A RETURN AIR PLENUM SEAL AIRTIGHT ALL AROUND.
- ⑤ 2" CONDENSATE DRAIN DOWN TO HUB DRAIN IN UTILITY SPACE.

Revisions

CONSTRUCTION ISSUE	DECEMBER 5, 1997
CHANGE ORDER NO. 1	JANUARY 27, 1998

Project No.	96036
Date	SEPT. 4, 1997
Designed	
Drawn	
Drawing No.	H-8