



LUMINAIRE SCHEDULE							
Symbol	Label	Qty	Catalog Number	Description	Lamp	File	Lumens LFP Watts
■	A	8	GSM-XX-250-MH-XX-SL-FG	MEDIUM ARCHITECTURAL AREA LUMINAIRE - SPILL LIGHT ELIMINATOR	250-WATT MH CLEAR ED-28	GSM-XX-250-MH-XX-SL-FGIES	20600 1.00 250

STATISTICS					
Description	Symbol	Avg	Max	Min	Max/Min Avg/Min
Spill Lighting	■	0.39 fc	6.09 fc	0.00 fc	N/A N/A
Site Lighting	□	2.4 fc	7.3 fc	0.1 fc	73.0:1 24.0:1

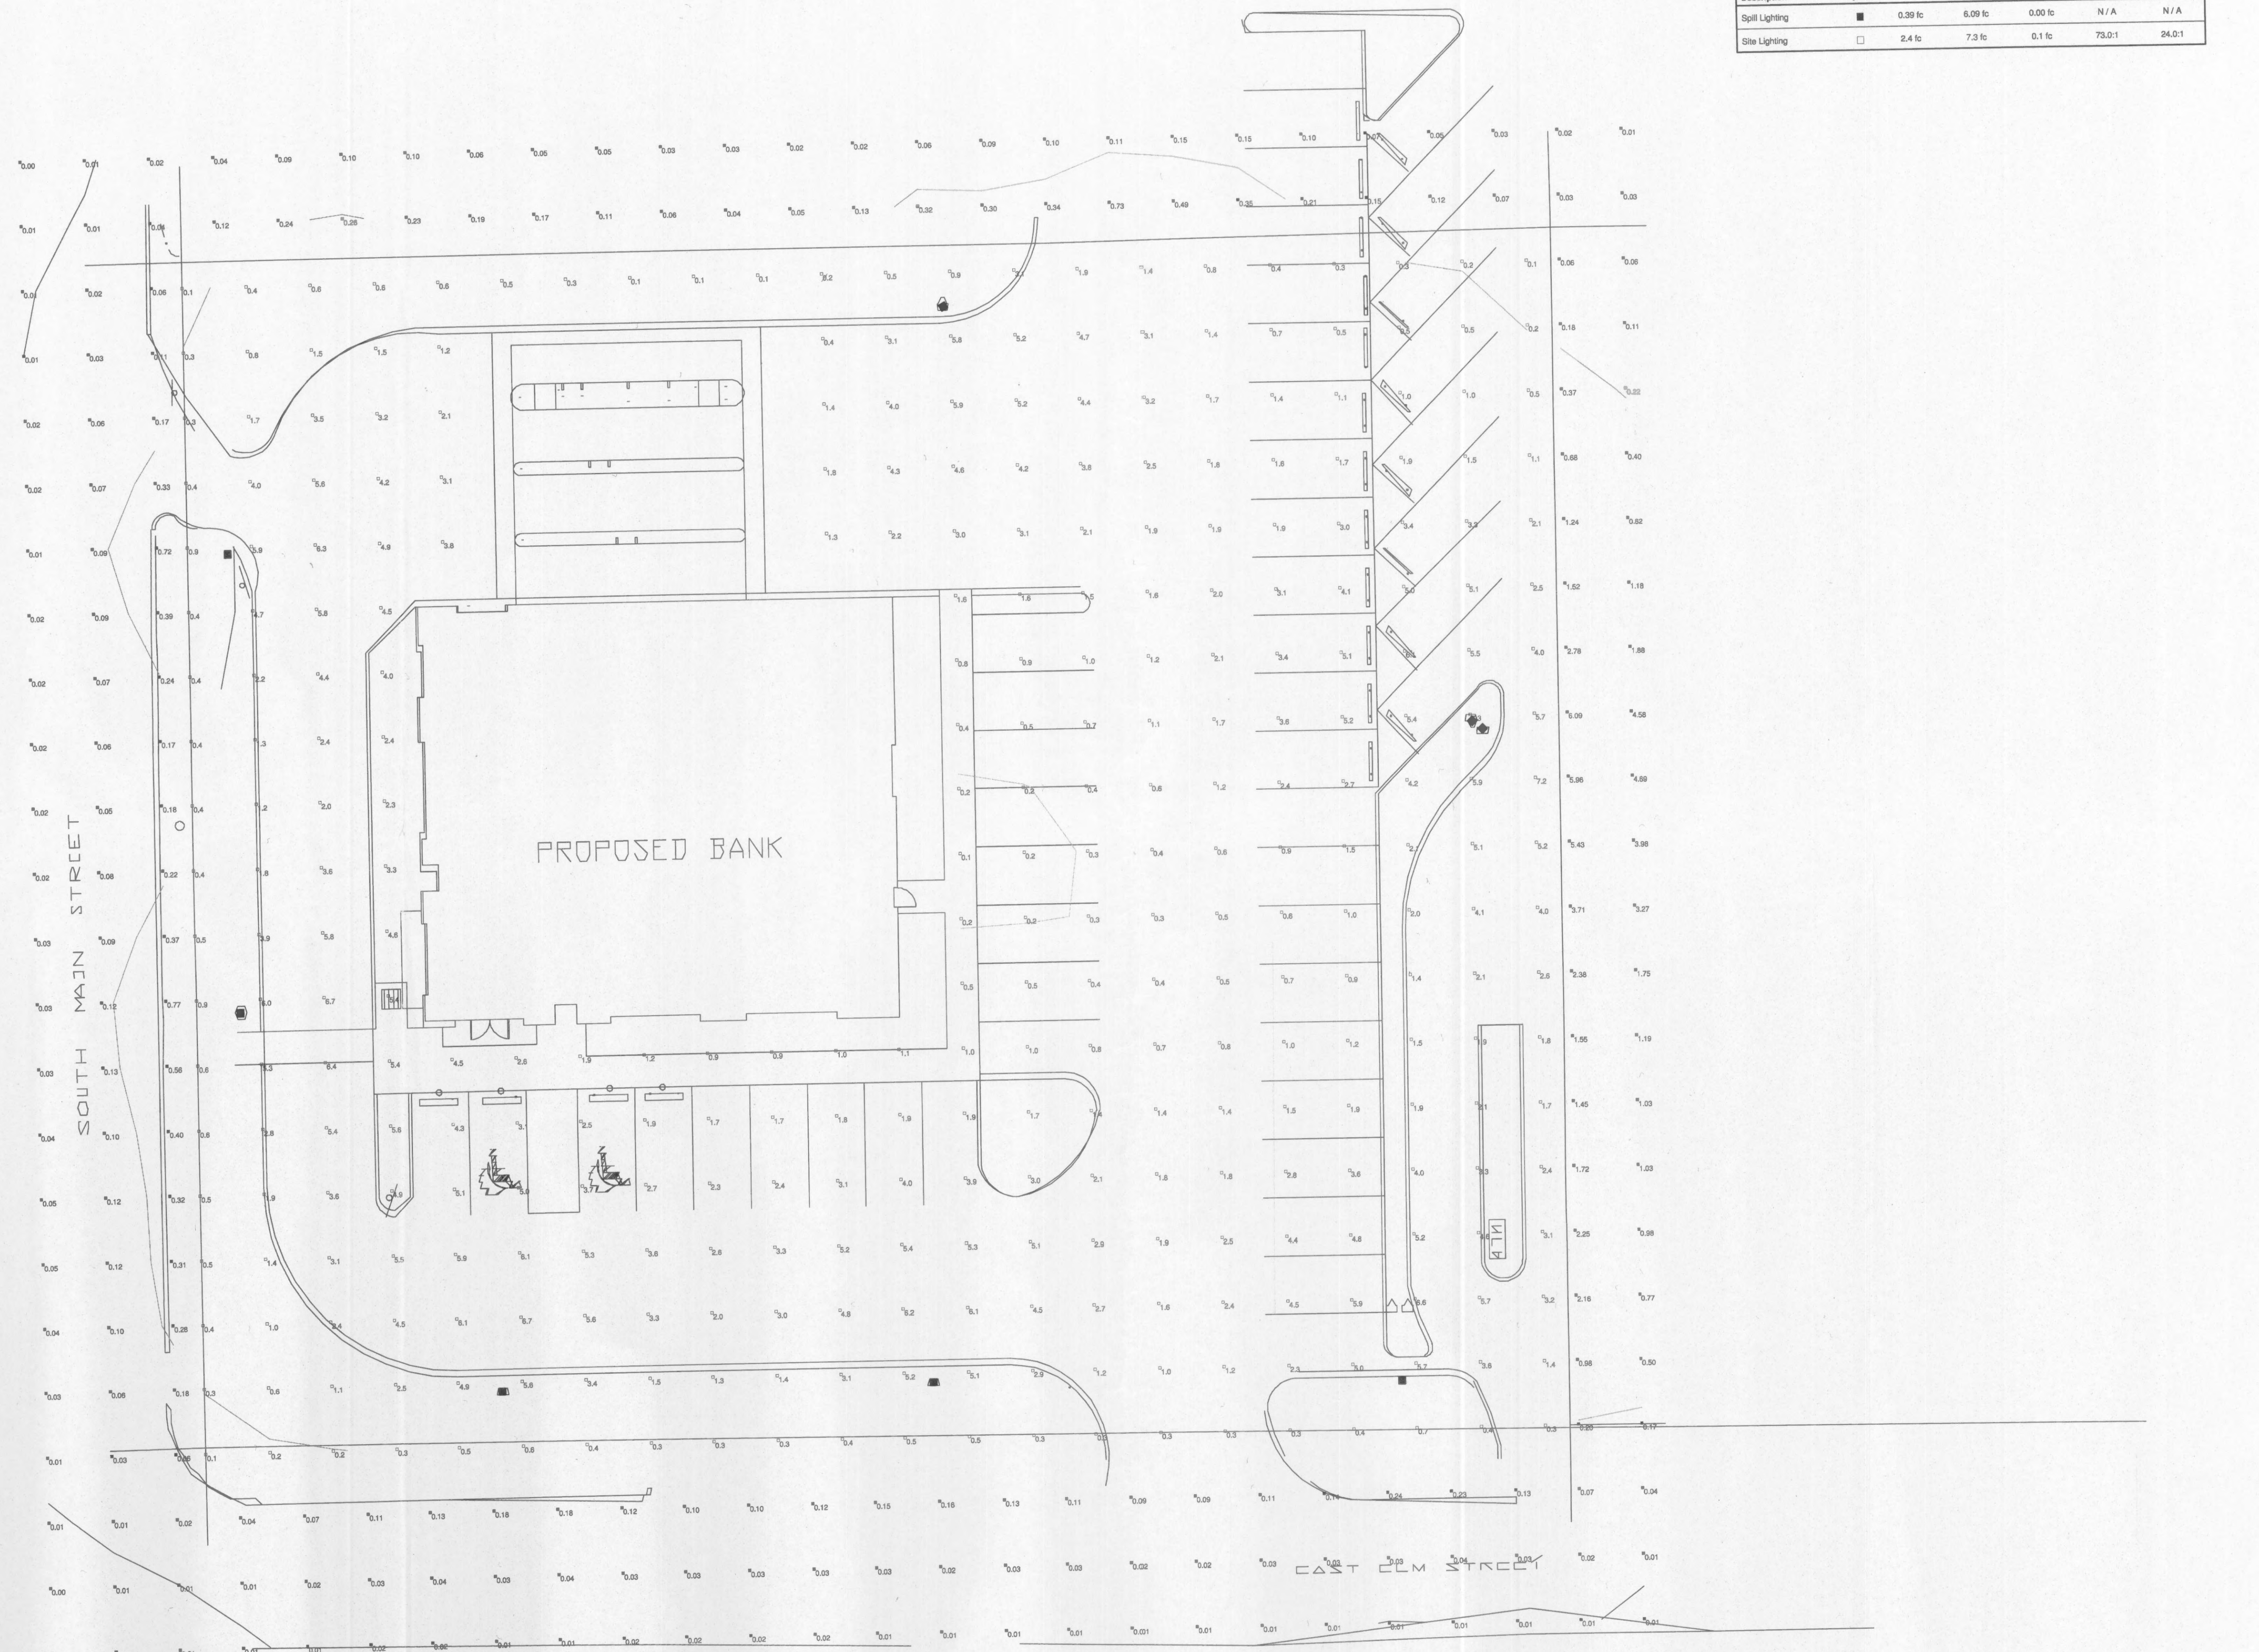

Photometric Plan
Scale: N.T.S.

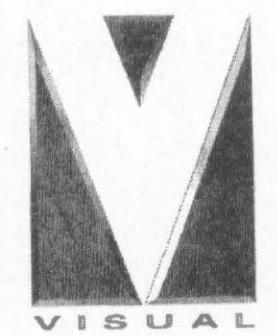

COMMERCE BANK O'FALLON, MO
PHOTOMETRIC PLAN

Designer
RJM
Date
1-18-2008
Scale
N.T.S.
Drawing No.