





MEP Engineers, Inc.
10777 Sunset Office Drive
Corporate Suite 100
St. Louis, Mo. 63127
Phone: 314.966.0100
Fax: 314.966.1010

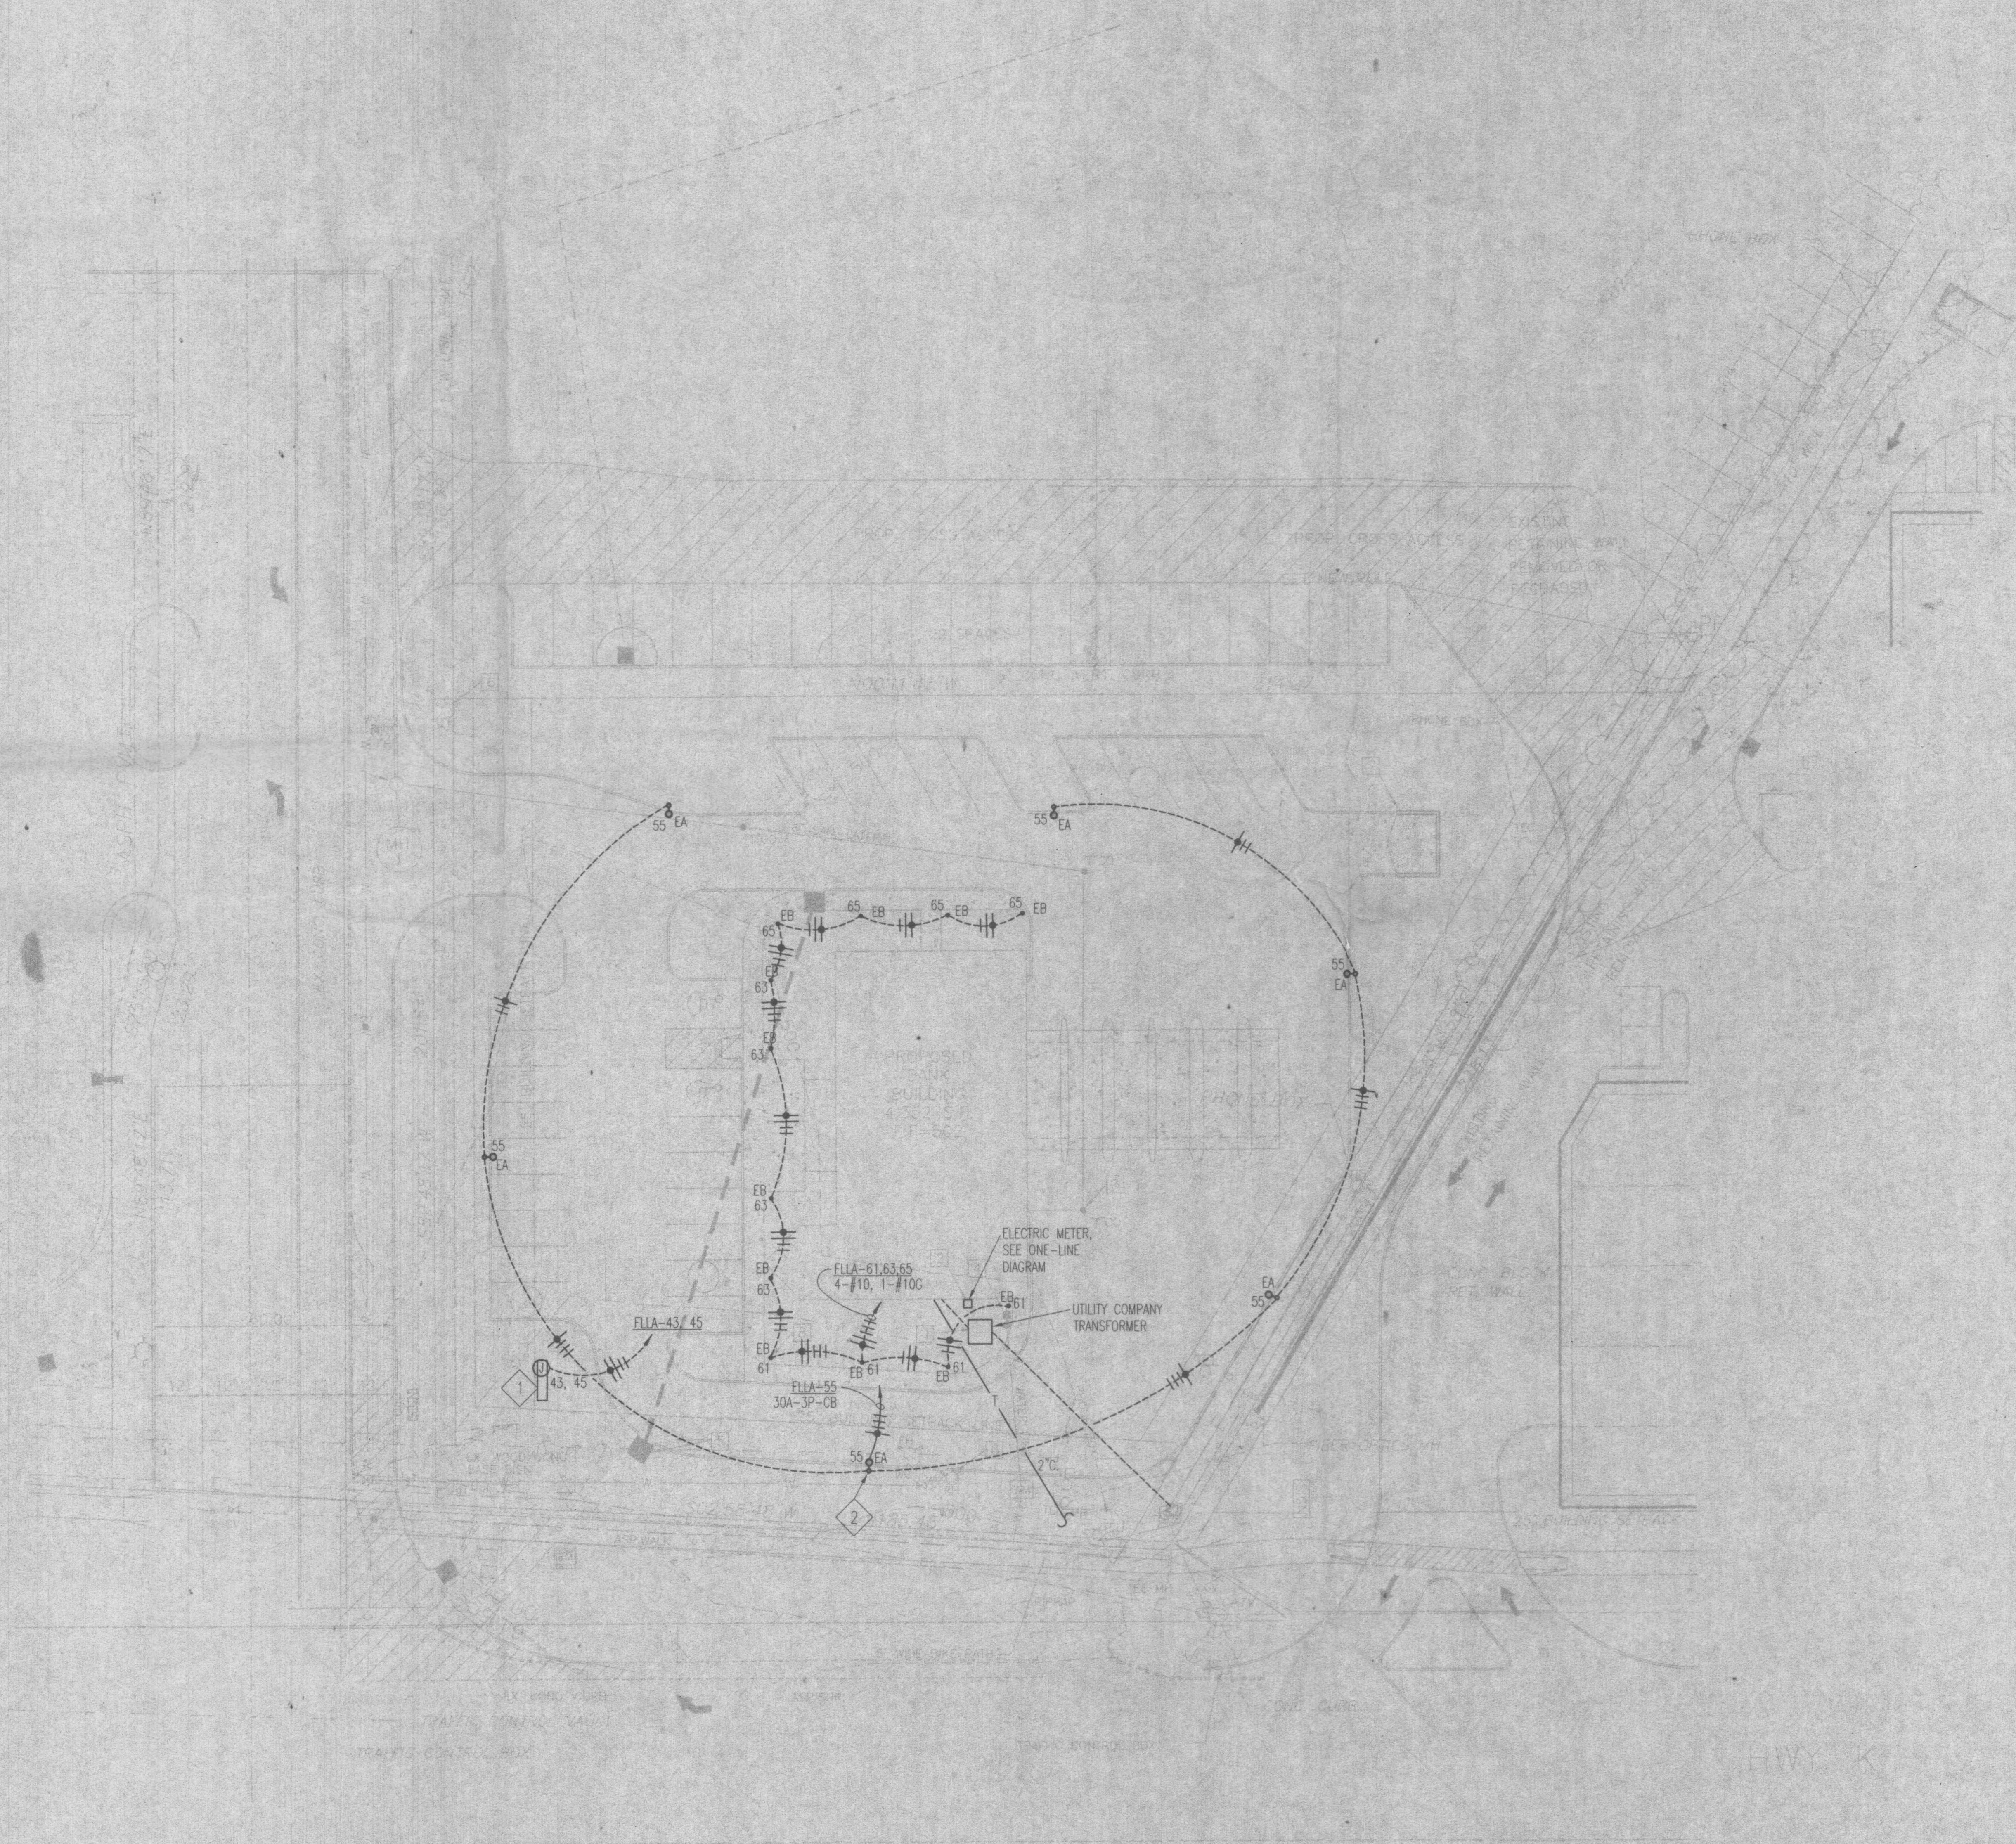

KEYED NOTES:

- 1 POWER CONNECTION TO SIGN BY ELECTRICAL CONTRACTOR. SIGN PROVIDED BY OWNER.
- 2 SEE LIGHTING FIXTURE SCHEDULE AND DETAILS ON DRAWING E6.1

Construction Documents For:
COMMERCE BANK
Outlot #5 Deer Creek Crossing
O'Fallon, Missouri

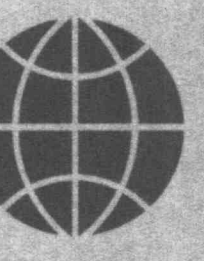

gray
Interiors + Architecture + Planning

PROJECT NAME: Commerce Bank, O'Fallon
SCALE: 1"=20'-0"
REVISION DATE: 02-02-01
REVISION TIME: 12:55