



KITCHEN PLAN NOTES


- 1 FLOOR OUTLETS - WALKER 850 FLOOR BOX, 803GC RECEPTACLE FITTING
- 2 VERIFY ROUGH-IN LOCATIONS, POWER REQUIREMENTS, CIRCUITS, CONNECTIONS OF ALL KITCHEN EQUIPMENT WITH KITCHEN EQUIPMENT SUPPLIER

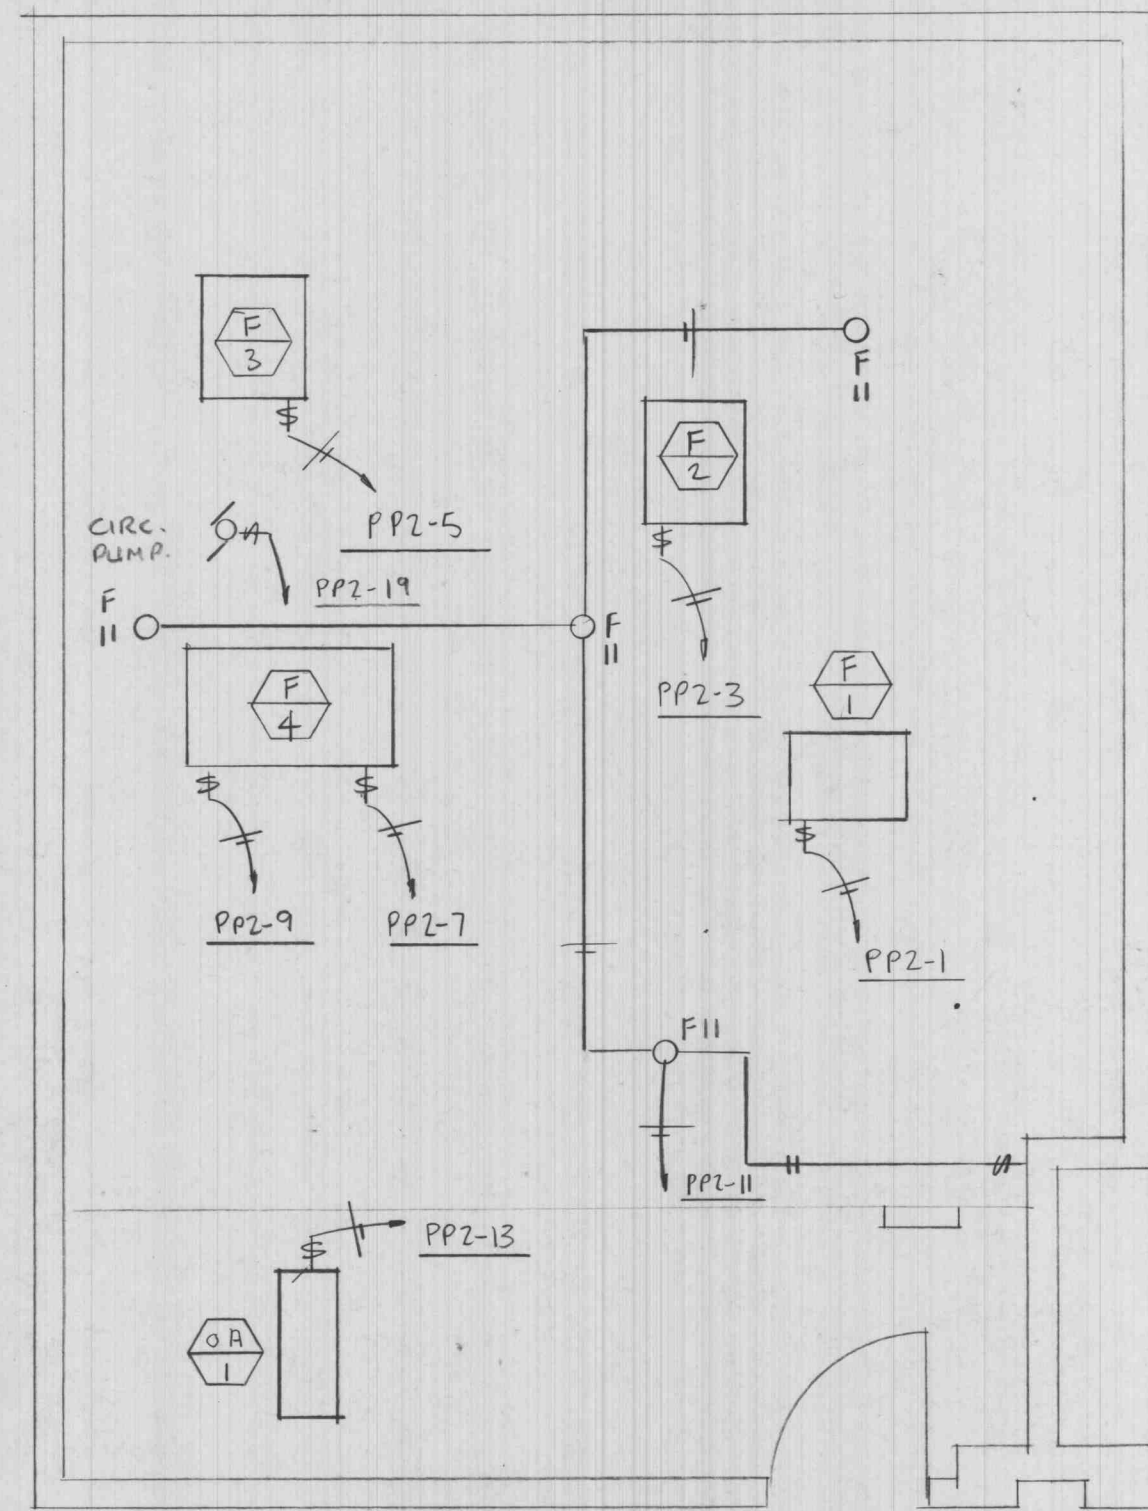


MEZZANINE PLAN
SCALE: 1/4" = 1'-0"

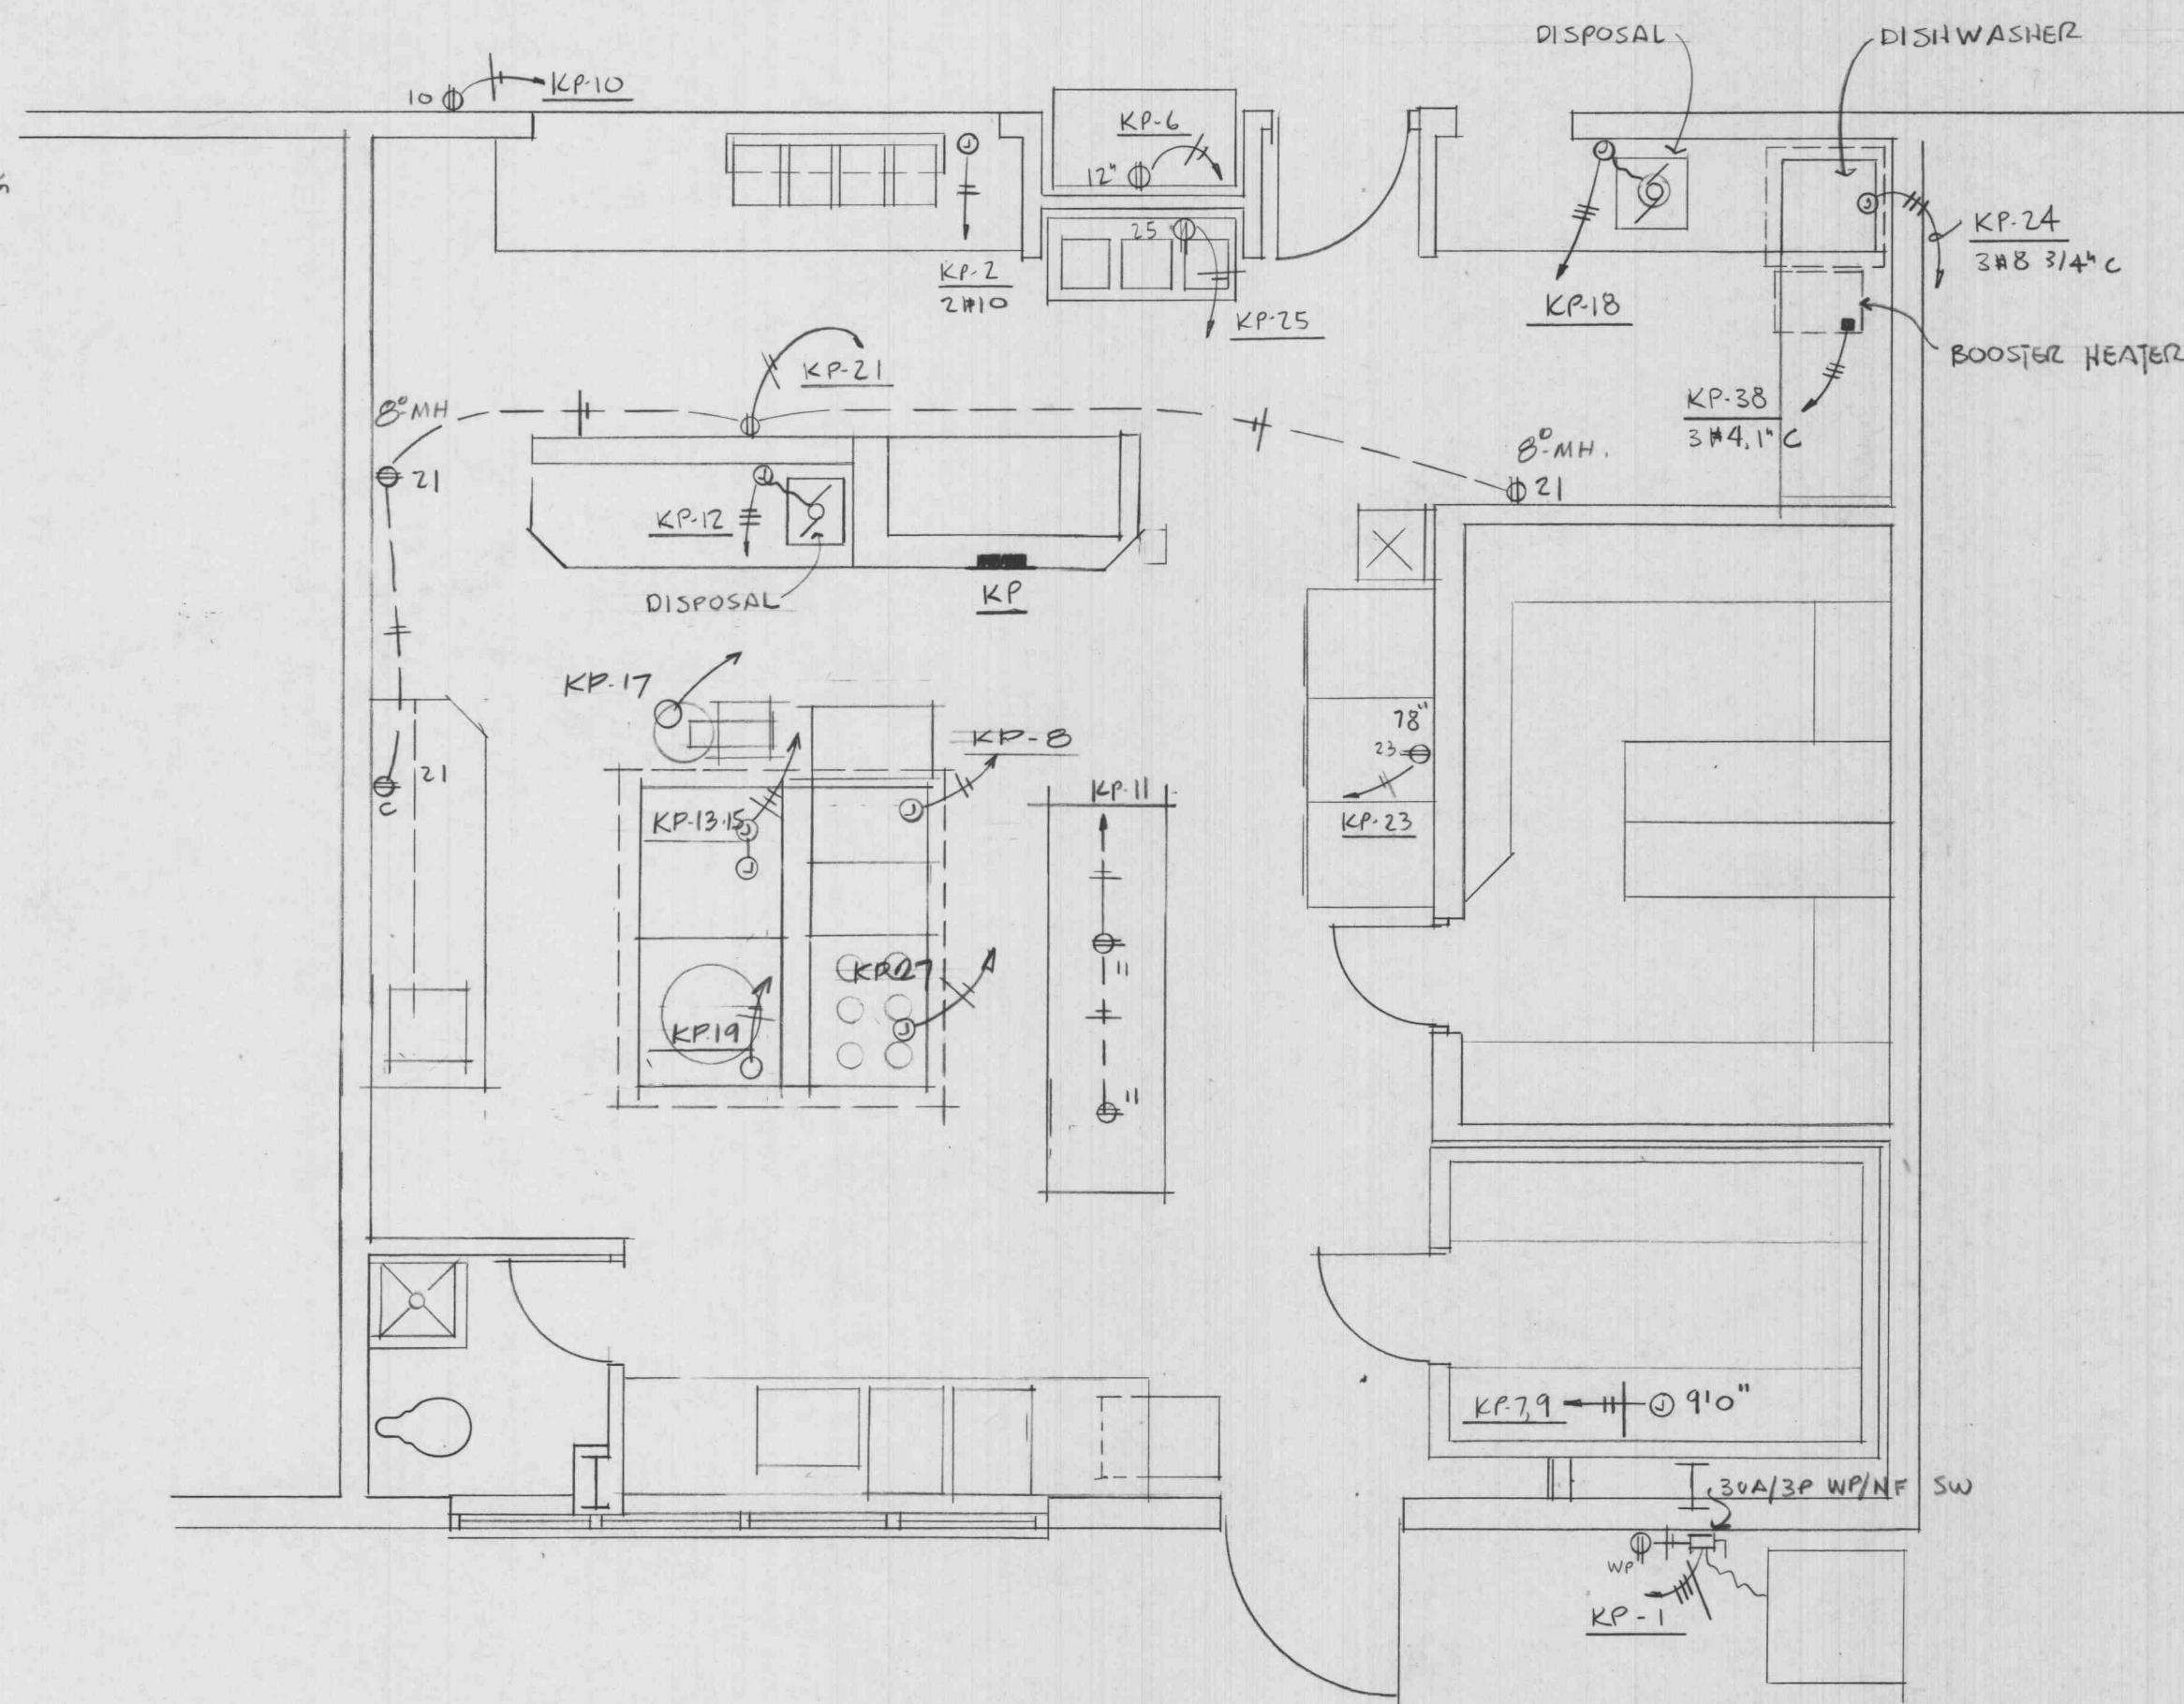

KITCHEN PLAN
SCALE: 1/4" = 1'-0"

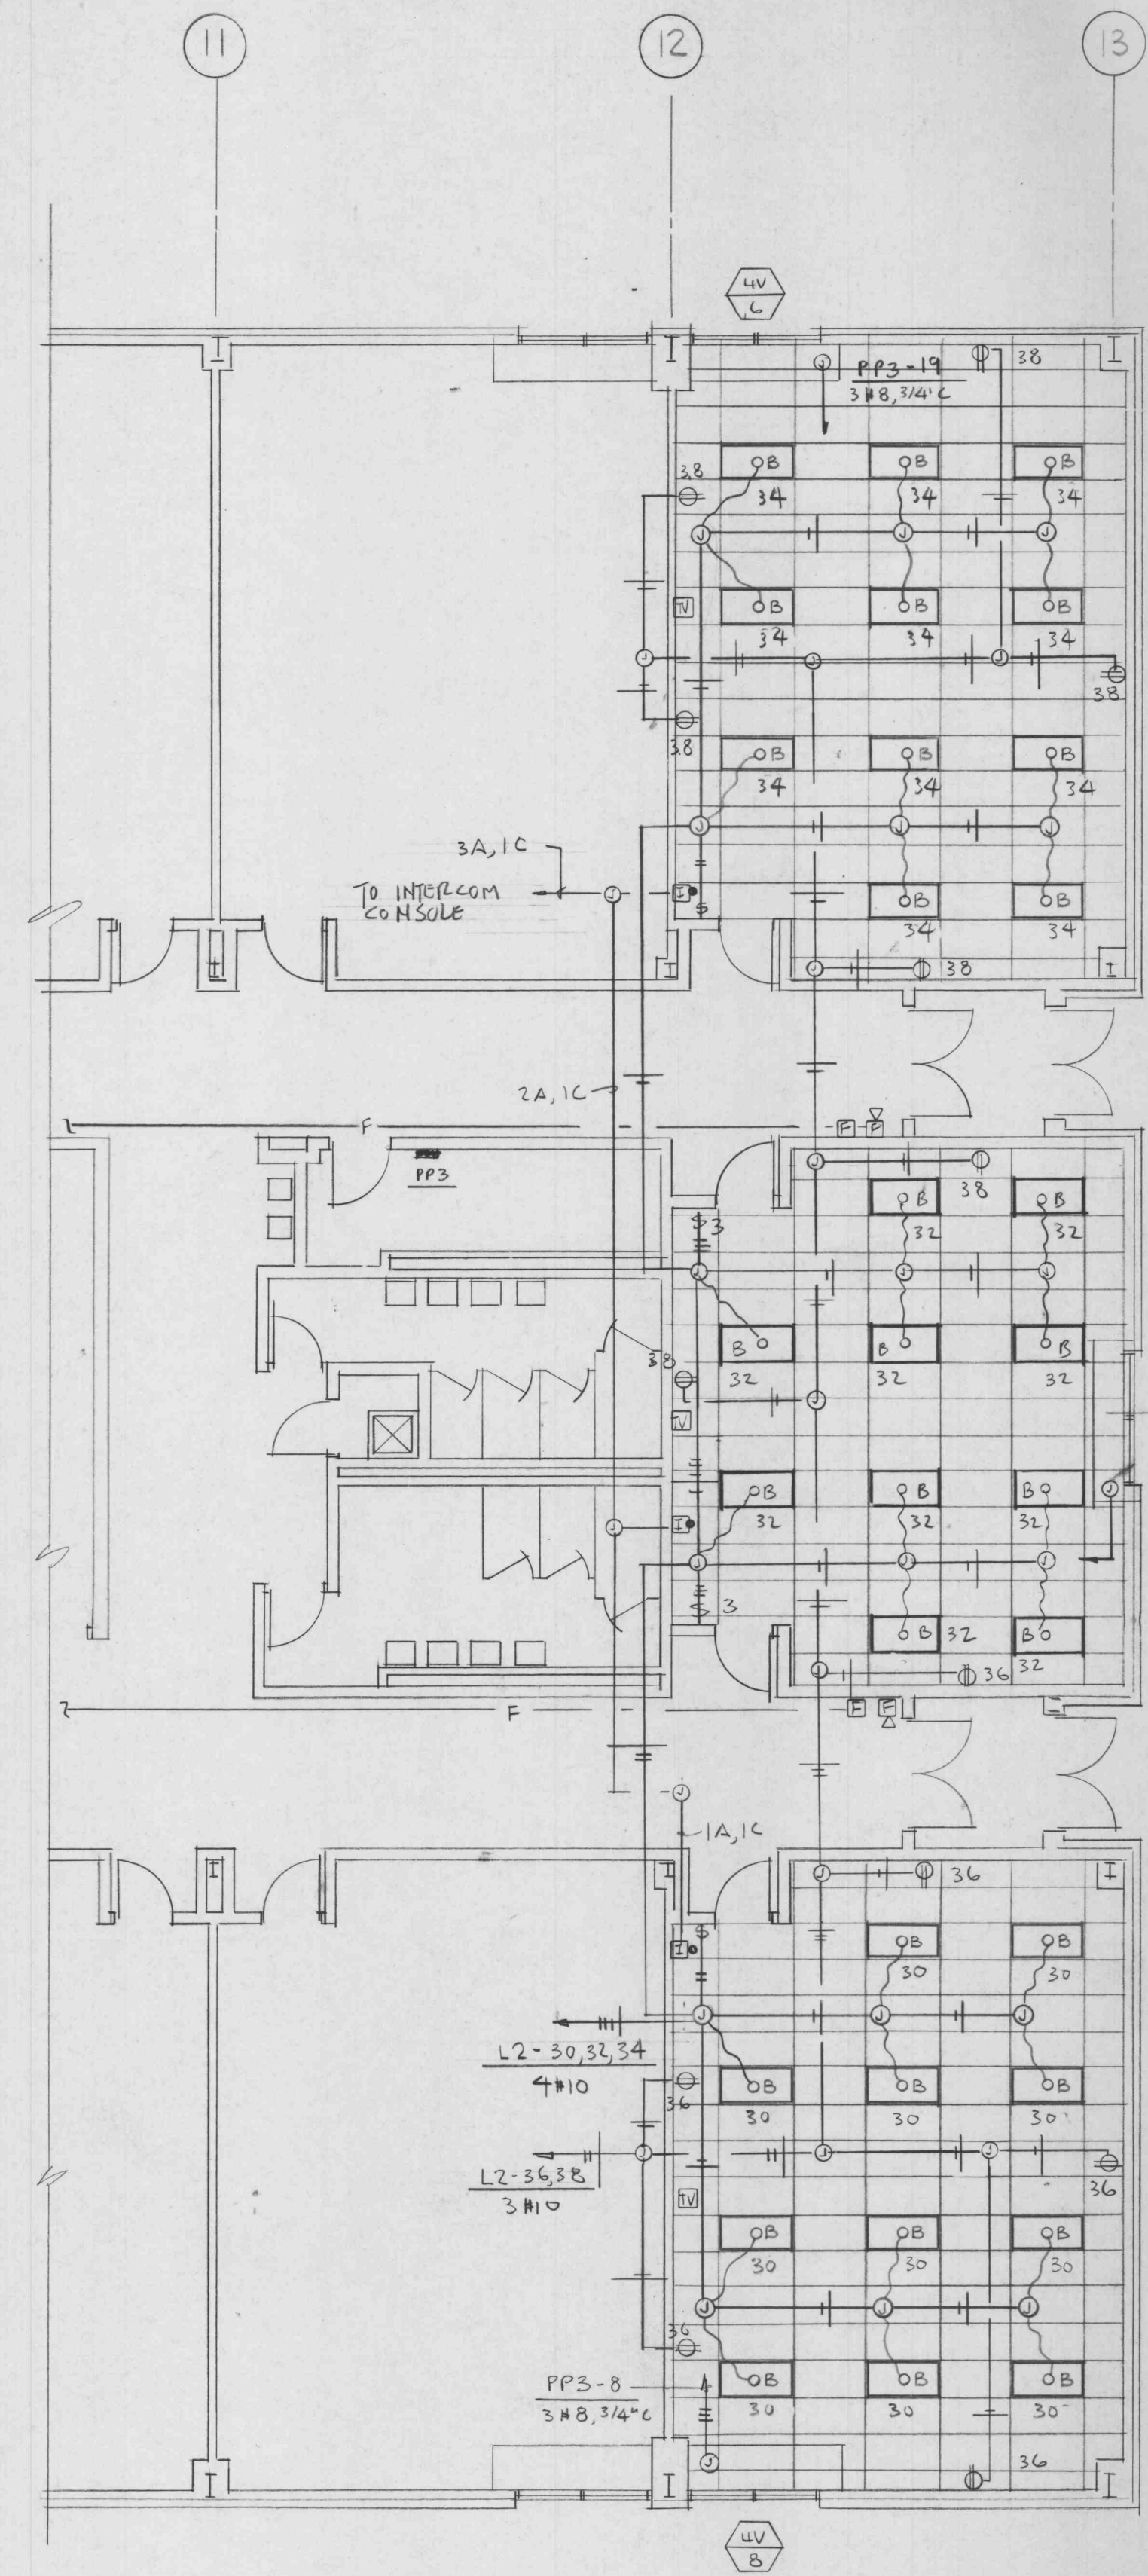

ALTERNATE BID #1
LIGHTING FLOOR PLAN
SCALE: 1/8" = 1'-0"

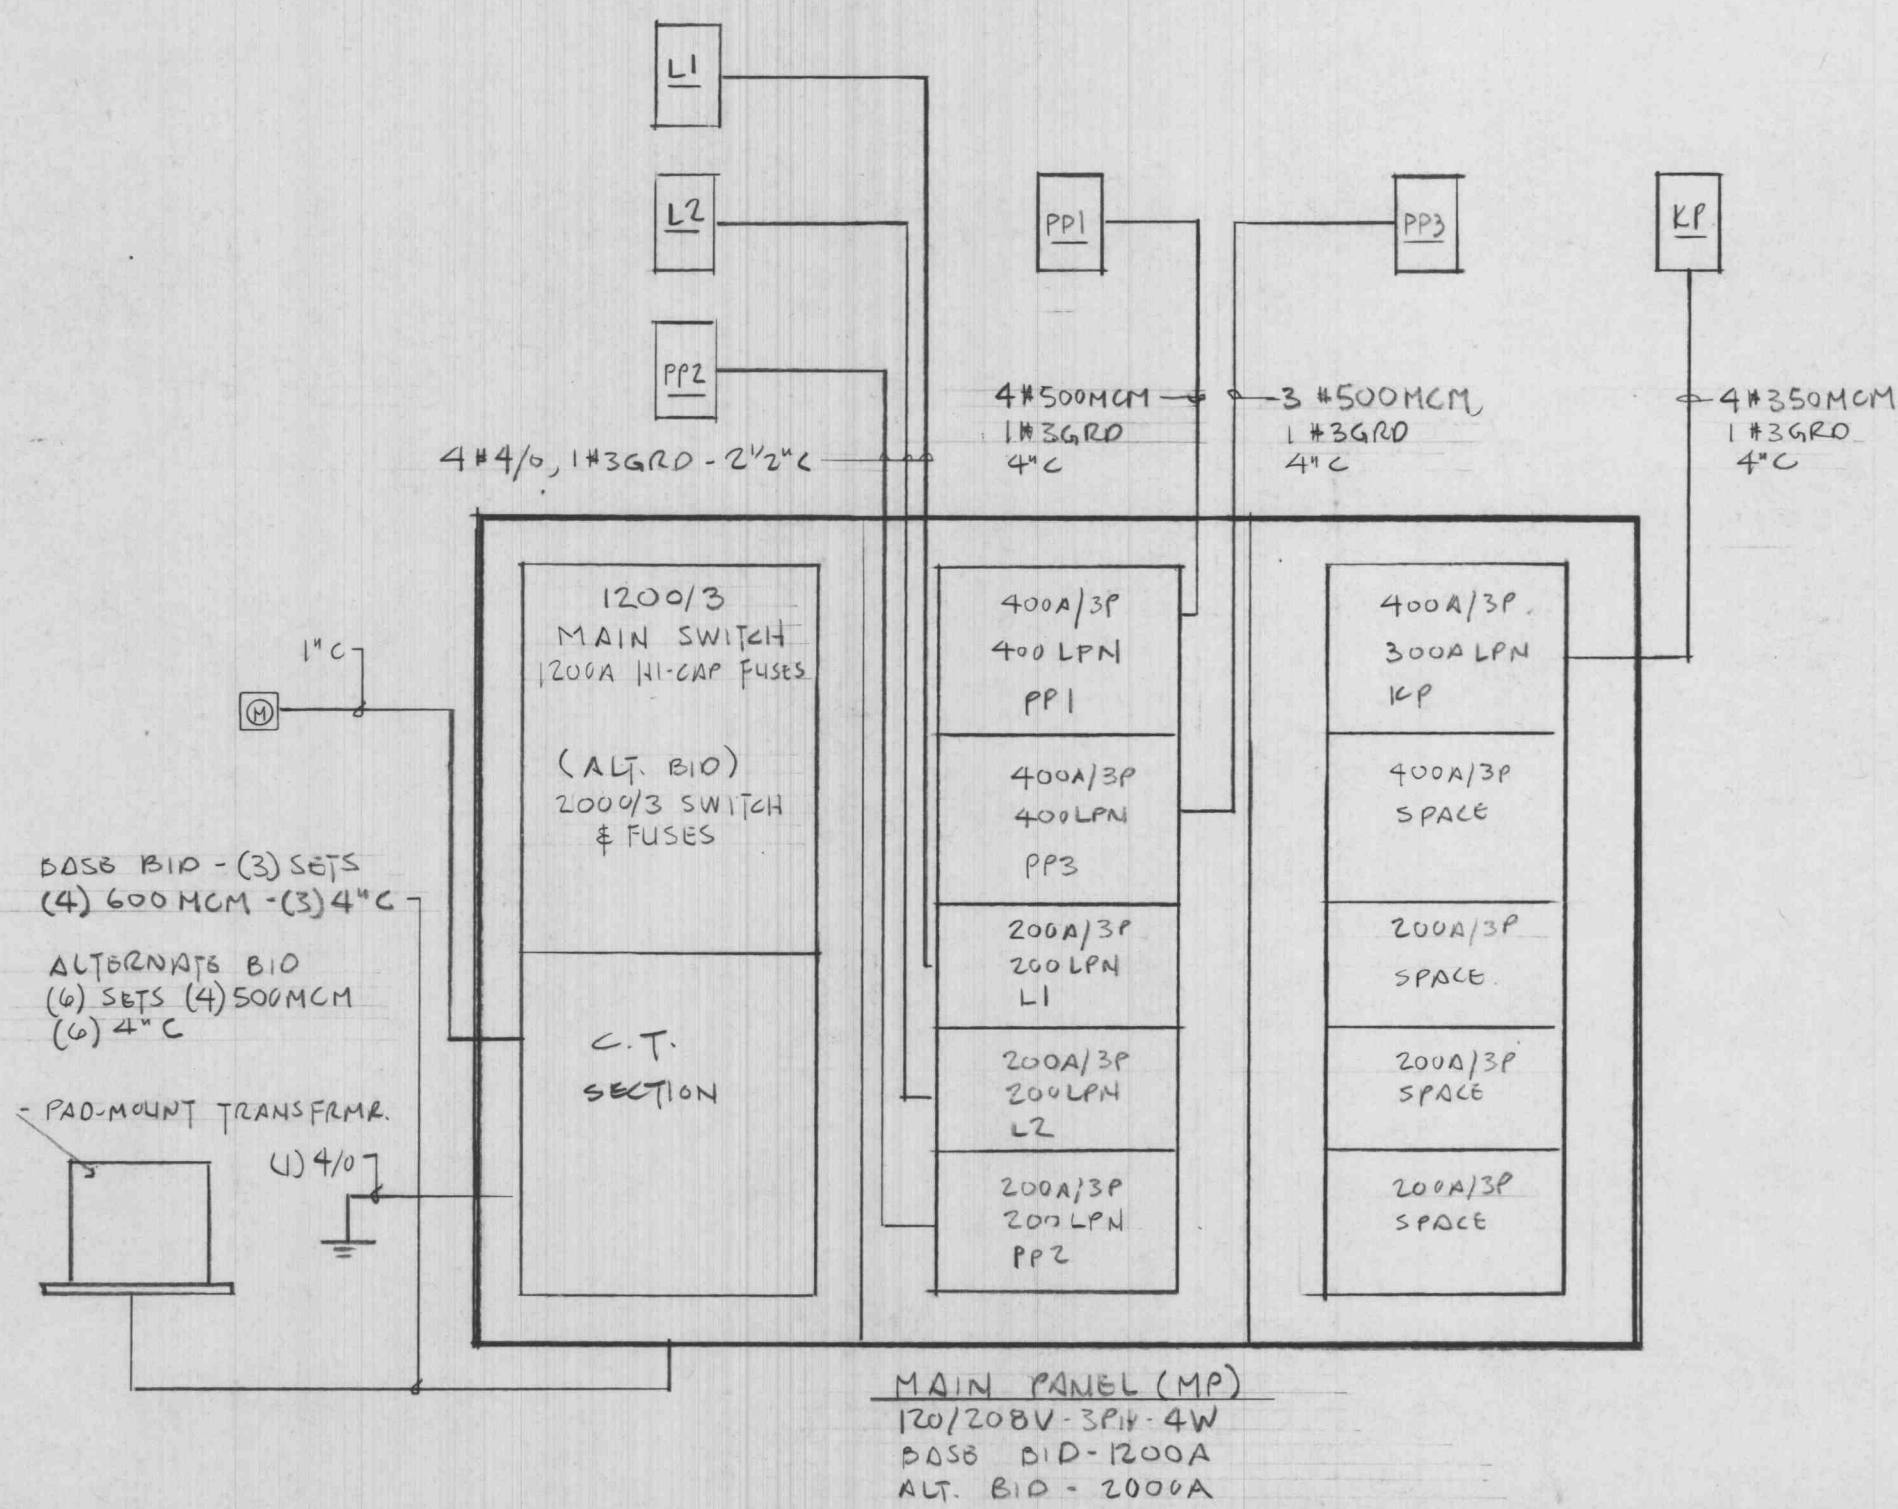


MAIN PANEL (MP)
120/208V-3P4-W
DASE DID-1200A
ALT. BID-2000A

PANEL KP 120/208V-3P4-W 400A MLO SURFACE		SERVES		VA	PHASE	VA	SERVES	NO. POLES	BKR. SIZE	CKT. NO.
1	24	3	FREEZER COND UNIT	2050	A	4000	HOT FOOD WELL	2	30	2
2	24	3			B			2	30	4
3	24	3			C	800	RECEP. MILK COOLER	1	20	6
4	24	3			A	800	HOOD LIGHTS	1	20	8
5	24	3			B	500	CASH REGISTER	1	20	10
6	24	3			C	2700	DISPOSAL	3	20	12
7	24	3	FREEZER LIS/HTC	900	A	900		1	20	14
8	24	3			B	900		1	20	16
9	24	3			A	900		1	20	18
10	24	3			B	900		1	20	20
11	24	3	FLOOR OUTLETS	400	C	2700	DISPOSAL	3	20	22
12	24	3			A	900		1	20	24
13	24	3	CONV. OVEN	900	B	900		1	20	26
14	24	3			A	900		1	20	28
15	24	3	MIXER	1000	C	6000	DISPOSAL	3	20	30
16	24	3			A	500		1	20	32
17	24	3	KETTLE	500	B	500		1	20	34
18	24	3	RECEP.	800	C	2700	DISPOSAL	3	20	36
19	24	3	REFRIG.	1500	A	8000	DISHWASHER	3	40	38
20	24	3			B	500		1	20	40
21	24	3	MILK COOLER	1000	C	6000		3	20	42
22	24	3			A	4320	MU-1	3	30	44
23	24	3			B			1	20	46
24	24	3			C			1	20	48
25	24	3			A	18000	BOOSTER HEATER	3	70	50
26	24	3			B			1	20	52
27	24	3			C			1	20	54
28	24	3			A			1	20	56
29	24	3			B			1	20	58
30	24	3			C			1	20	60
31	24	3			A			1	20	62
32	24	3			B			1	20	64
33	24	3			C			1	20	66
34	24	3			A			1	20	68
35	24	3			B			1	20	70
36	24	3			C			1	20	72
37	24	3			A			1	20	74
38	24	3			B			1	20	76
39	24	3			C			1	20	78
40	24	3			A			1	20	80
41	24	3			B			1	20	82
42	24	3			C			1	20	84

TOTAL CONNECTED LOAD = 57000VA (158A)

PICKETT RAY & SILVER civil engineers
SOIL CONSULTANTS INC soil engineers
L. WEINTRAUB & ASSOC structural engineers
THOMAS BERKELEY mechanical engineers

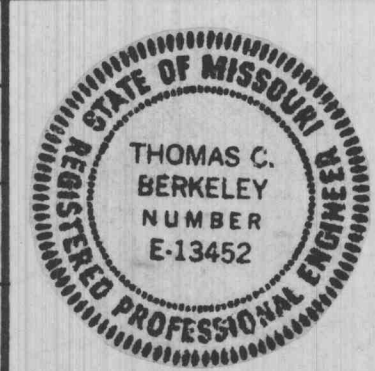

the DMA corporation
Design & Management Associates
314-946-2060 202 Transit Street St. Charles, Mo. 63301

NEW ELEMENTARY SCHOOL
ft. zumwalt school district
ofallon missouri

ALTERNATE #1
LIGHTING FLOOR
PLAN, KITCHEN
PLAN

Revisions:

△		△
△		△
△		△
△		△