


MISSOURI HIGHWAY 'N'

Asphalt Shoulder

A5
Area North of Property Line
Illuminance Values(Fc)
Average =0.14
Maximum =0.4
Minimum =0.0
Avg/Min Ratio=0.00

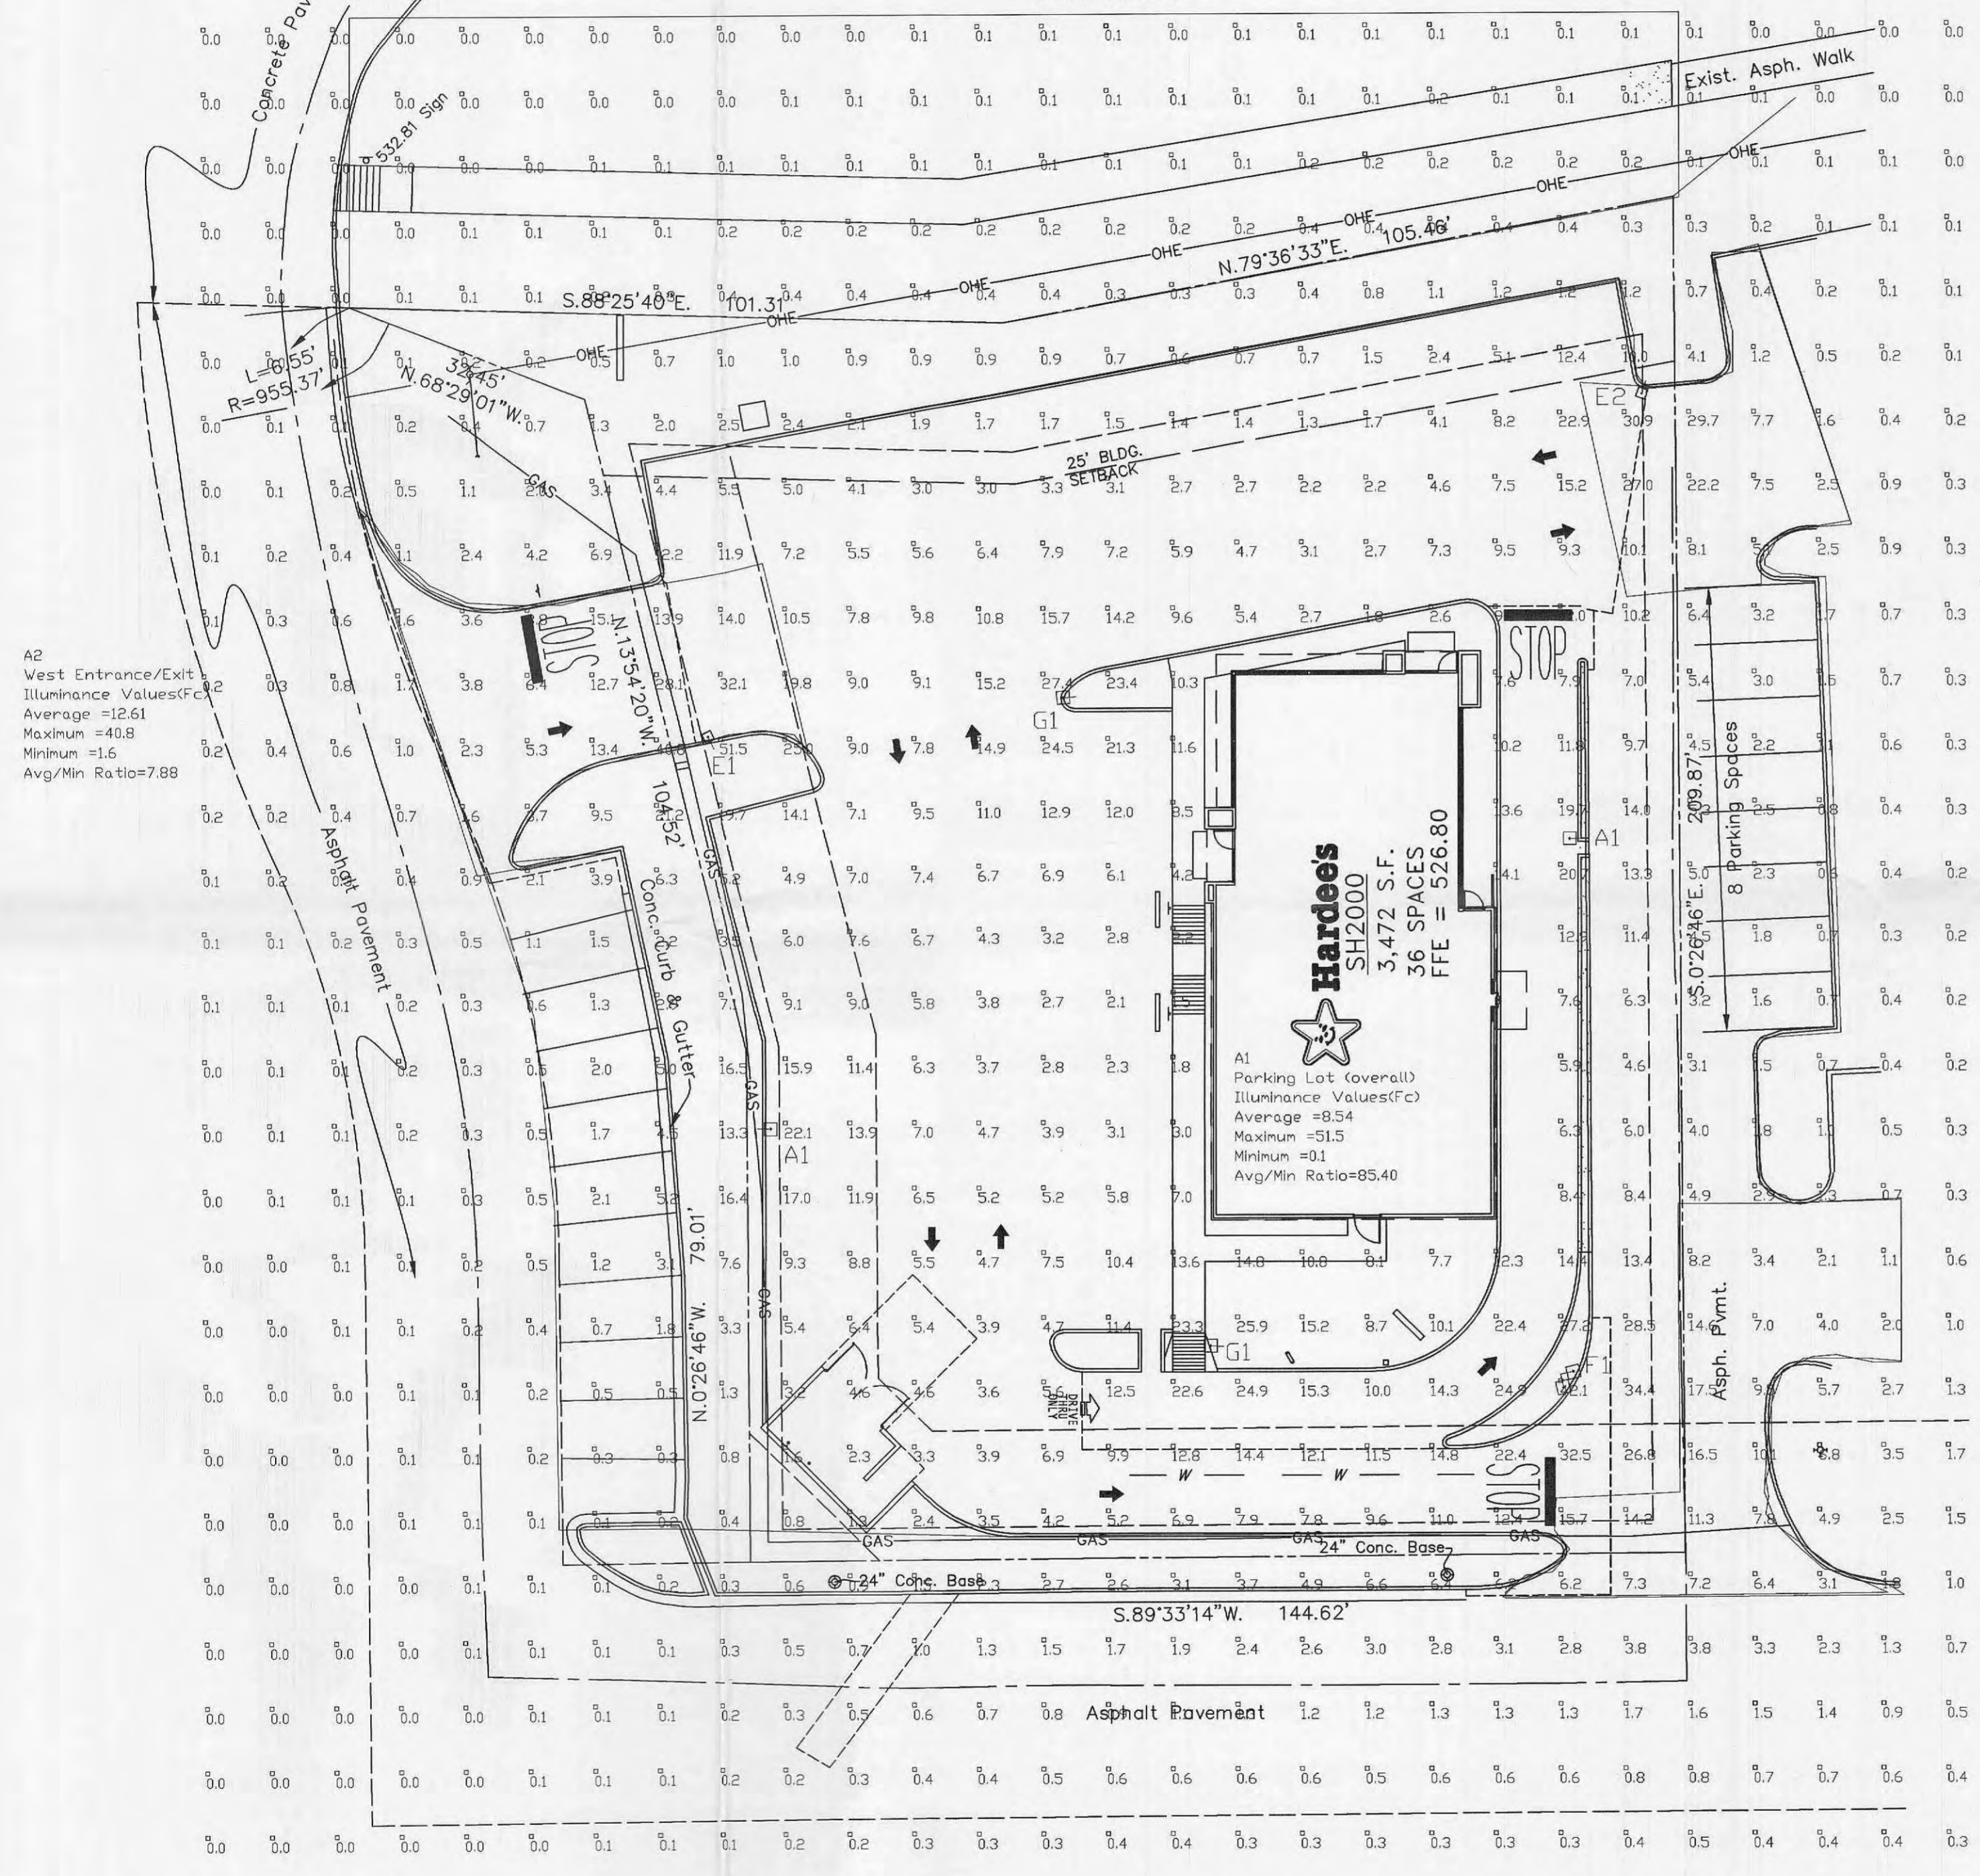

Numeric Summary

Project: All Projects

Label	CalcType	# Pts	Units	Avg	Max	Min
Grid 1	Illuminance	771	Fc	4.01	51.5	0.0

Statistical Area Summary

Project: All Projects

Label	Description	CalcType	# Pts	Units	Avg	Max	Min	Avg/Min
A1	Parking Lot (overall)	Illuminance	330	Fc	8.54	51.5	0.1	85.40
A4	Southwest Entrances/Exits	Illuminance	21	Fc	8.34	17.5	1.1	7.58
A3	Northeast Entrance/Exit	Illuminance	12	Fc	12.70	30.9	0.4	31.75
A2	West Entrance/Exit	Illuminance	18	Fc	12.61	40.8	1.6	7.88
A5	Area North of Property Line	Illuminance	92	Fc	0.14	0.4	0.0	0.00

Luminaire Schedule

Project: All Prjcts

Symbol	Qty	Label	Arrangement	Lumens	LLF	Description	Filename
+	2	A1	SINGLE	107800	0.720	CEII-M1000-III	L4454.ies
+	1	E1	SINGLE	107800	0.720	CEII-M1000-IV	L5006.ies
+	1	F1	2 @ 90 DEGREES	107800	0.720	CEII-M1000-IV (2 @ 90)	L4454.ies
+	2	G1	SINGLE	107800	0.720	CEII-M1000-VS	L3035.ies
+	1	E2	SINGLE	107800	0.720	CEII-M1000-IV-CS	L5072.ies

BUD-1629

RECEIVED
OCT 29 2002

SITE LIGHTING FOR:
HARDEE'S, O'FALLON, MO

SPAULDING LIGHTING INC.

SCALE	DATE	DRAWN BY	DESIGN BY	DWG. NO.
1" = 20'	10-28-02	JSG	JSG	SP-14-R1