 




GRAPHIC SCALE

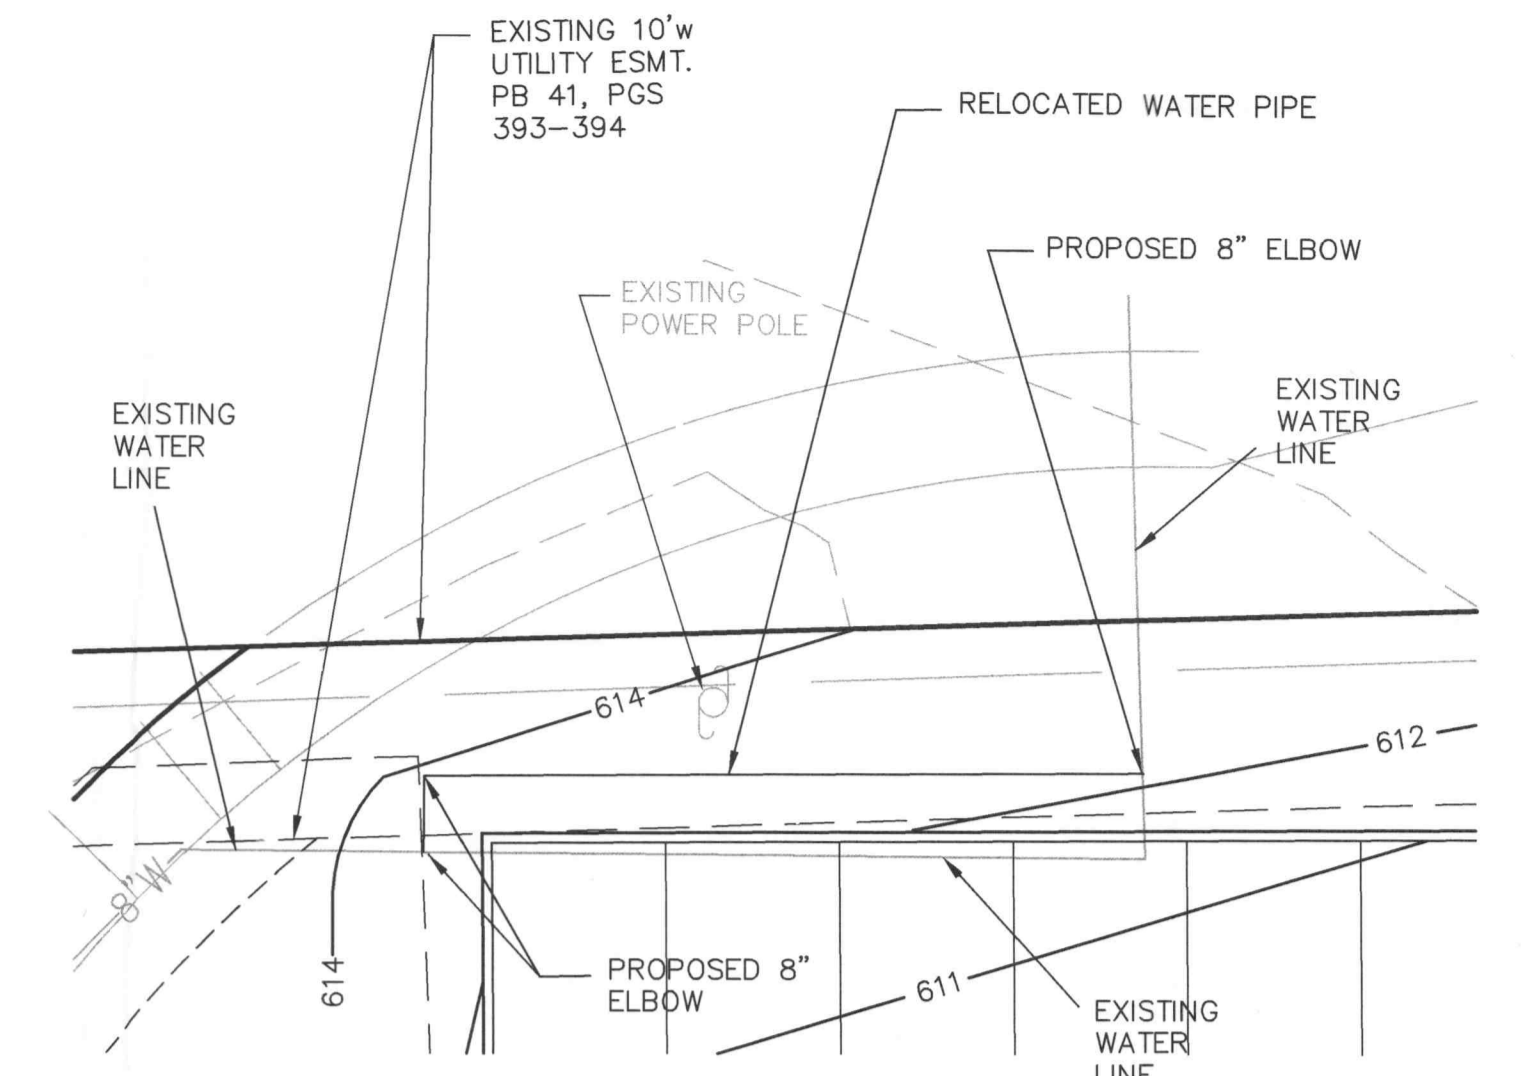


(IN FEET)
1 inch = 20 ft.

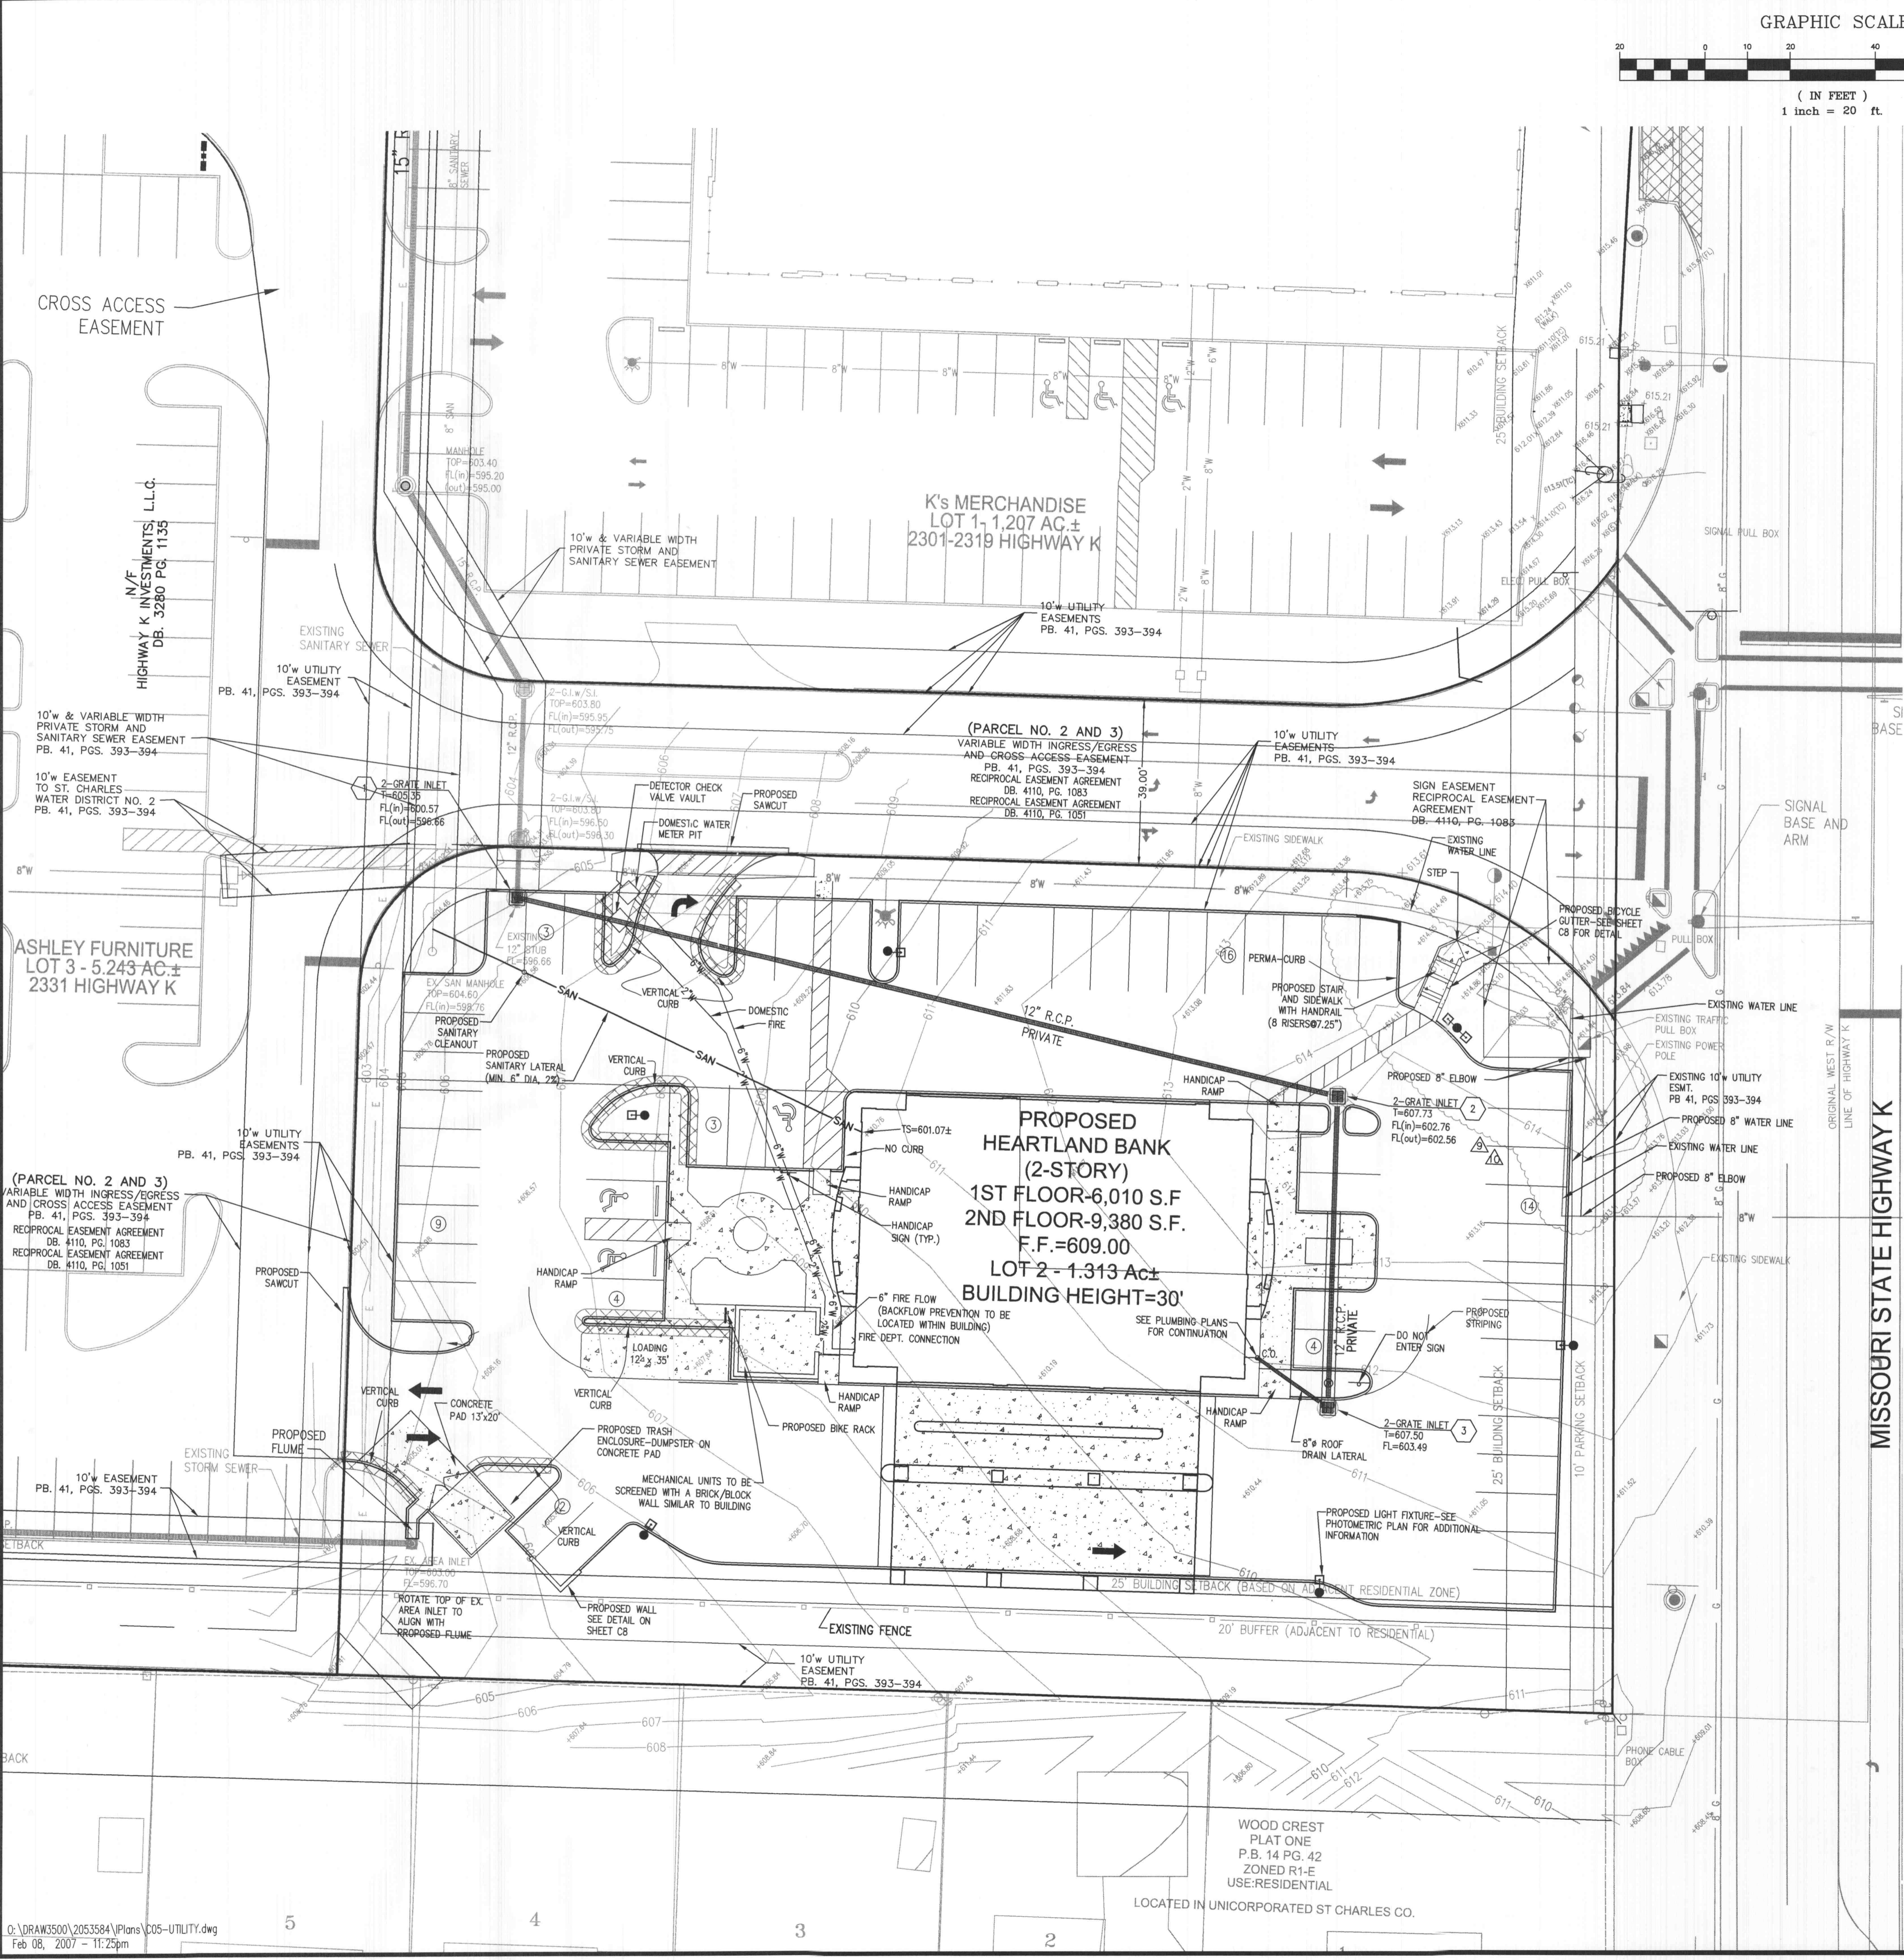

WATER LINE ELEVATION

SCALE H 1"=10'
V 1"=5'

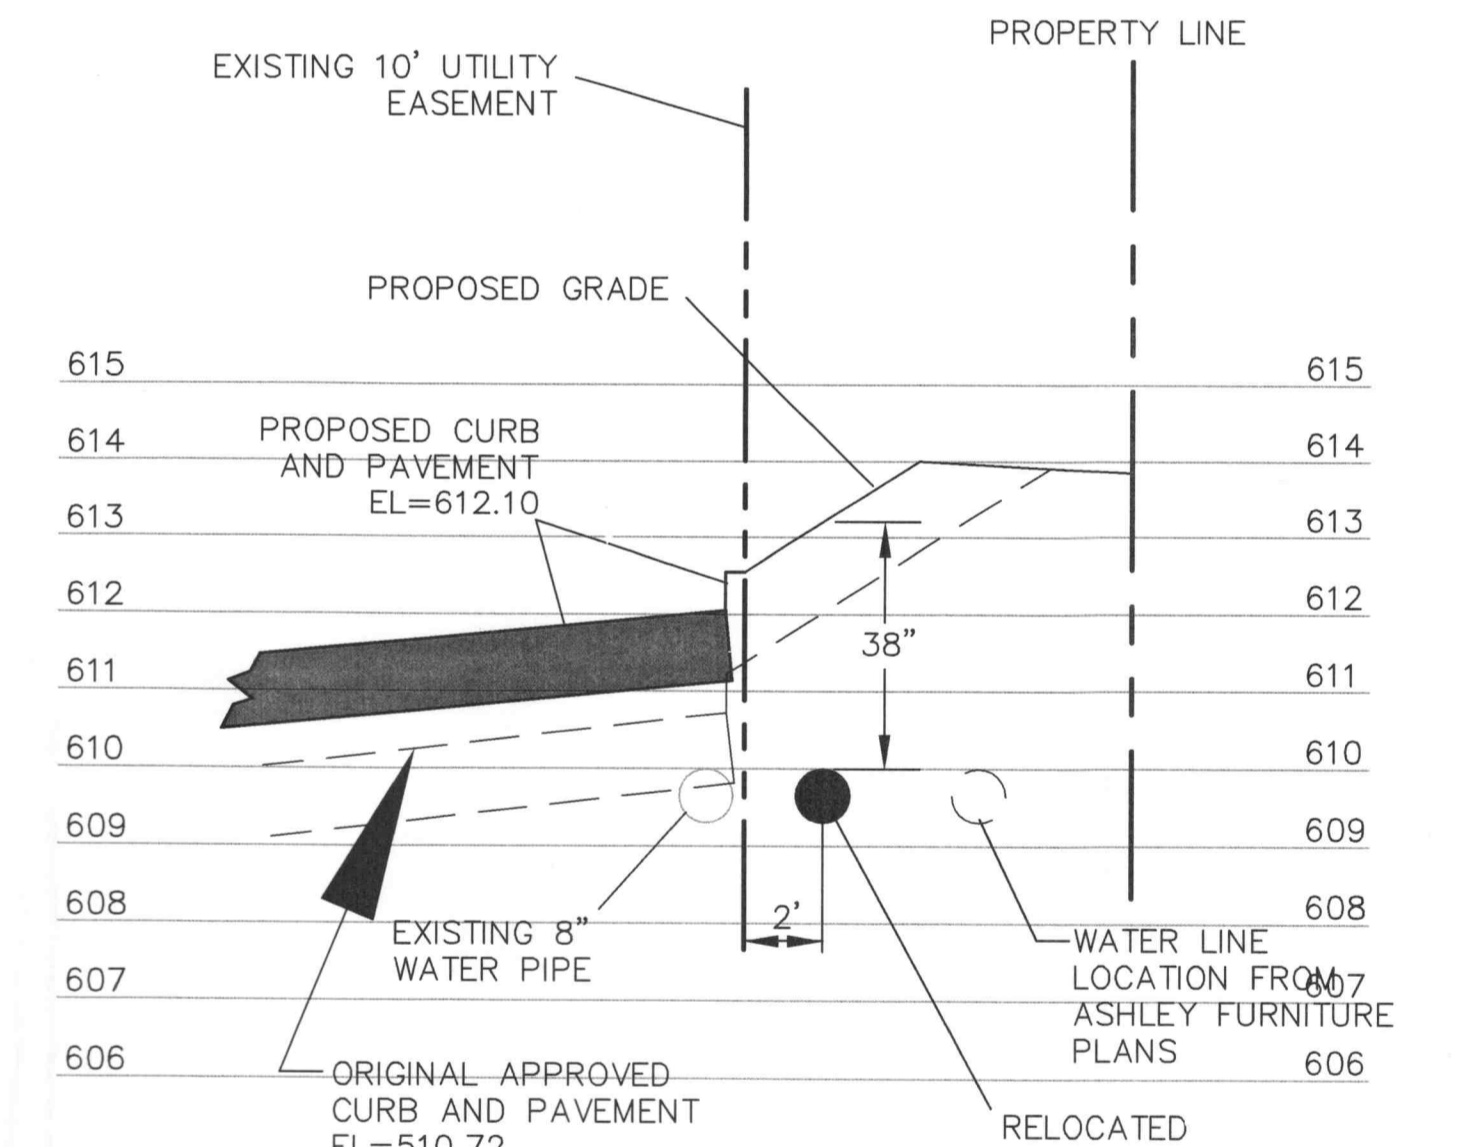

WATER LINE DETAIL


SCALE H 1"=5'
V 1"=2.5'

- △ 02-08-07 ADDED WATER LINE EXHIBITS TO SHEET C5
- △ 01-22-07 REVISED GRADES AND WATER LINE AT NORTHEAST CORNER
- △ 10-09-06 RELOCATED LIGHT FIXTURES
- △ 06-28-06 REVISED PER CITY COMMENTS DATED 6-15-06
- △ 05-31-06 REVISED PER CITY COMMENTS FROM PLANNING AND ZONING MEETING ON 5-18-06
- △ 03-16-06 REVISED PER CITY COMMENTS-ADDED PEDESTRIAN ACCESS WALK/STAIR NEAR MONUMENT SIGN
- △ 02-09-06 ADDENDUM #1 COORDINATION-REVISED WATER LINE, ROOF DRAIN, SPOT ELEVATIONS
- △ 02-06-06 BID SET
- △ 01-23-06 REVISED BUILDING FOOTPRINT PER ARCHITECT
- △ 11-18-05 REVISED PER CITY COMMENT LETTER DATED 10-19-05

UTILITY PLAN

TERRA RETAIL DEVELOPMENT/HEARTLAND BANK

P&Z NOS: 98-126.06

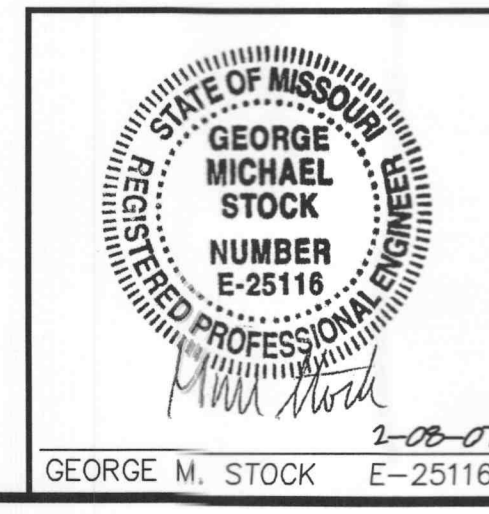

STOCK & ASSOCIATES
Consulting Engineers, Inc.

257 Chesterfield Business Parkway
St. Louis, MO 63005
PH. (636) 530-9100
FAX (636) 530-9130
e-mail: general@stockassoc.com
Web: www.stockassoc.com

DRAWN BY: J.P.P. DATE: 9/27/05 CHECKED BY: G.M.S. DATE: 9/27/05 JOB NUMBER: 205-3584 SHEET: C5 of 12