




LUMINAIRE SCHEDULE									
Symbol	Label	Qty	Catalog Number	Description	Lamp	File	Lumens	LLF	Watts
□	EA	30	KVF 1000M ASYFL EHS	SQUARE AREA LIGHT, ASYMMETRIC DISTRIBUTION, FLAT LENS, HOUSE SIDE SHIELD.	ONE 1000-WATT CLEAR BT-37 METAL HALIDE, VERTICAL BASE UP POS.	Lt19397.ies	110000	0.74	1080
□	EB	4	KVF 1000M SYMFL	SQUARE AREA LIGHT, SYMMETRIC DISTRIBUTION, FLAT LENS.	ONE 1000-WATT CLEAR BT-37 METAL HALIDE, VERTICAL BASE UP POS.	Lt19418.ies	110000	0.74	2160
□	EC	2	KVF 1000M ASYFL	SQUARE AREA LIGHT, ASYMMETRIC DISTRIBUTION, FLAT LENS.	ONE 1000-WATT CLEAR BT-37 METAL HALIDE, VERTICAL BASE UP POS.	Lt19395.ies	110000	0.74	1080
○	ED	0	KBR8 100M R5	8 IN ROUND BOLLARD	100 WATT CLEAR METAL HALIDE	94033002.ies	8500	0.74	125

STATISTICS					
Description	Avg	Max	Min	Max/Min	Avg/Min
new site	2.9 fc	12.3 fc	0.0 fc	N/A	N/A

NOTES
 1. THE FOOTCANDLE LEVELS INDICATED REFLECTS THE VALUES OF THE POLED LUMINAIRES "TYPES EA, EB & EC" (THE PRIMARY SITE LIGHTING SOURCES) ONLY. NOT REFLECTING THE LIGHTING VALUES FROM THE BOLLARDS "TYPE ED".

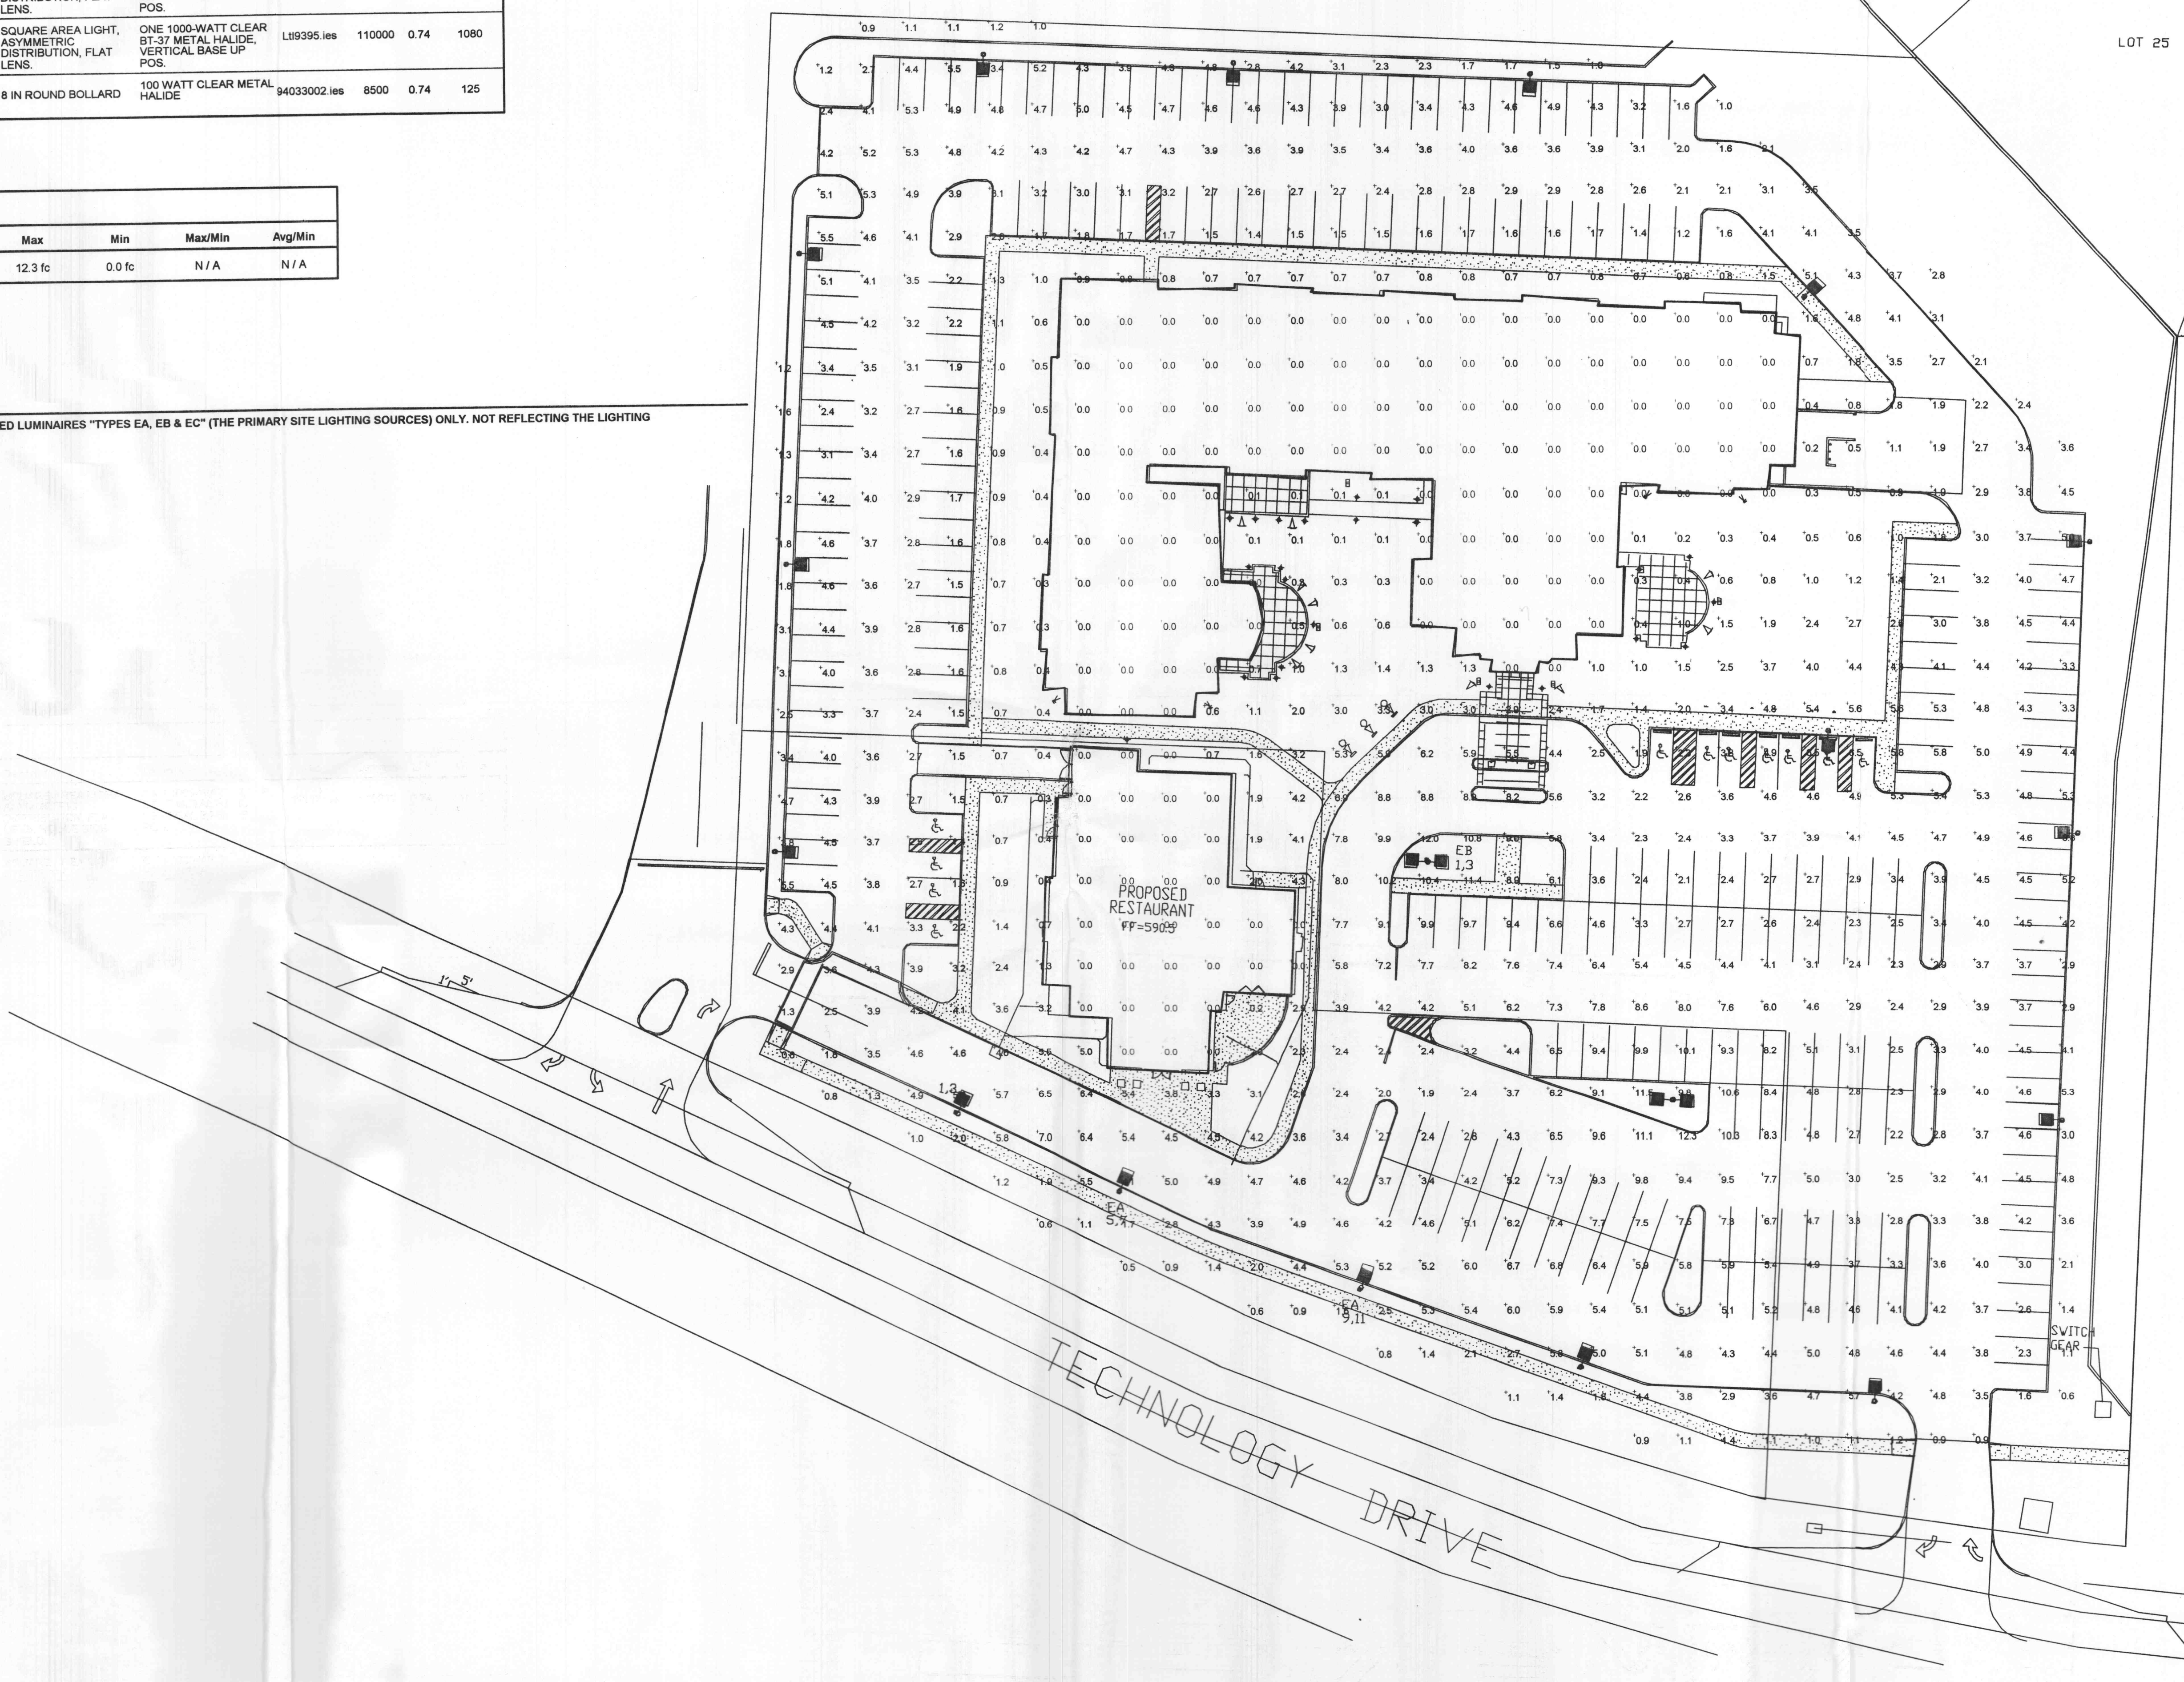

Plan View
 Scale 1" = 30'

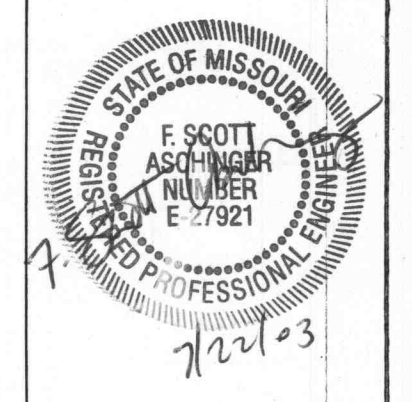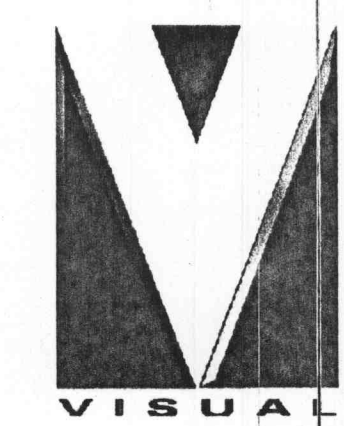

HILTON - WINGHAVEN
 OF FALLON, MO.

Designer
 JN
 Date
 MAY 22, 2003
 Scale
 1"=30'
 Drawing No.
 AEC-SITE 1