



**MASTERCARD PARKING LOT E  
APPLICATION SITE PLAN - LAYOUT**

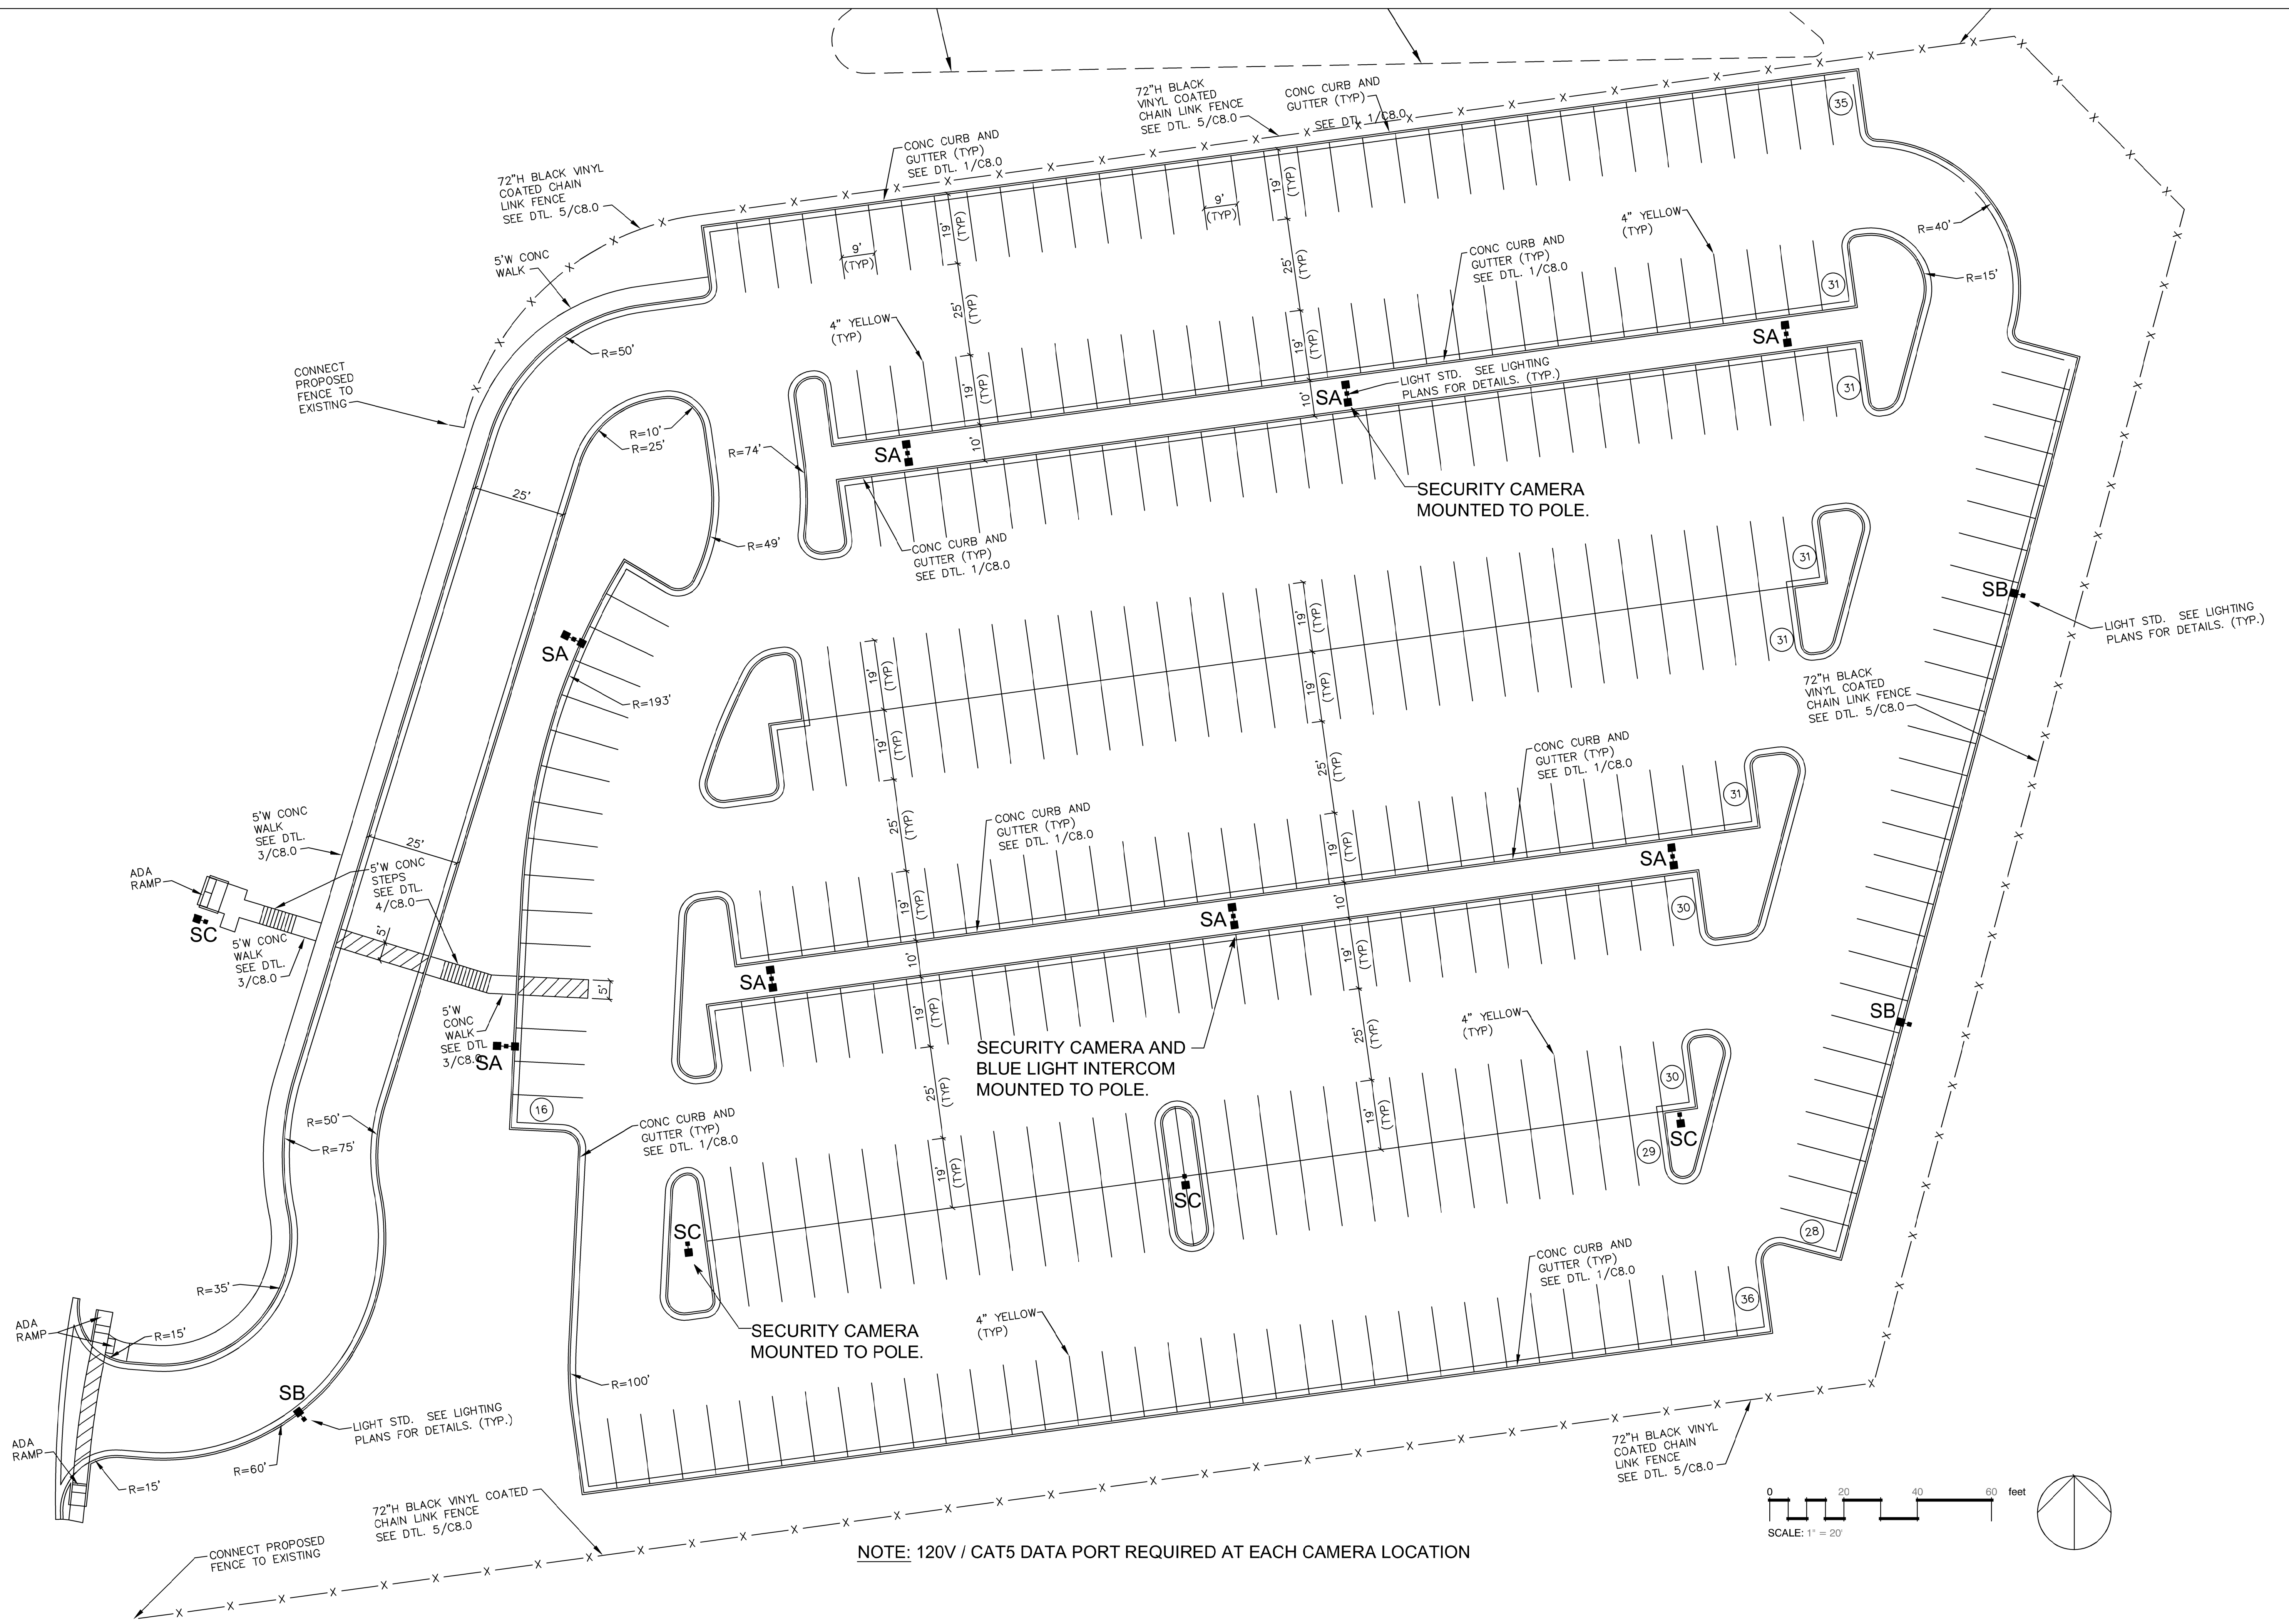

**NOTE: 120V / CAT5 DATA PORT REQUIRED AT EACH CAMERA LOCATION**

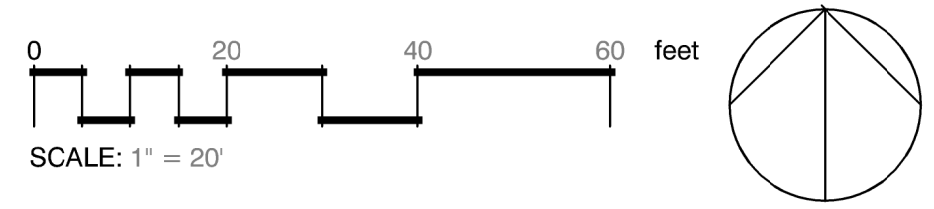

PROJ #:	18716
DATE:	2018.10.01
Issued for Bid	
REV:	10.18.18 REV 1
11.21.18 City Comments	
12.20.18 City Submittal	
SCALE:	As Noted
DRAWING NO.:	