


| Symbol | Qty | Label | Arrangement | Total Lamp Lumens | LLF   | Description             |
|--------|-----|-------|-------------|-------------------|-------|-------------------------|
| SA     | 8   | SA    | BACK-BACK   | N.A.              | 1.000 | PRV-A40-D-UNV-T3-BZ     |
| SB     | 3   | SB    | SINGLE      | N.A.              | 1.000 | PRV-A40-D-UNV-T3-BZ-HSS |
| SC     | 4   | SC    | SINGLE      | N.A.              | 1.000 | PRV-A40-D-UNV-T3-BZ-HSS |

| Label              | CalcType    | Units | Avg  | Max | Min | Avg/Min | Max/Min |
|--------------------|-------------|-------|------|-----|-----|---------|---------|
| Parking Plane Top  | Illuminance | Fc    | 2.00 | 6.2 | 0.3 | 6.67    | 20.67   |
| Property Line Calc | Illuminance | Fc    | 0.16 | 0.6 | 0.0 | N.A.    | N.A.    |

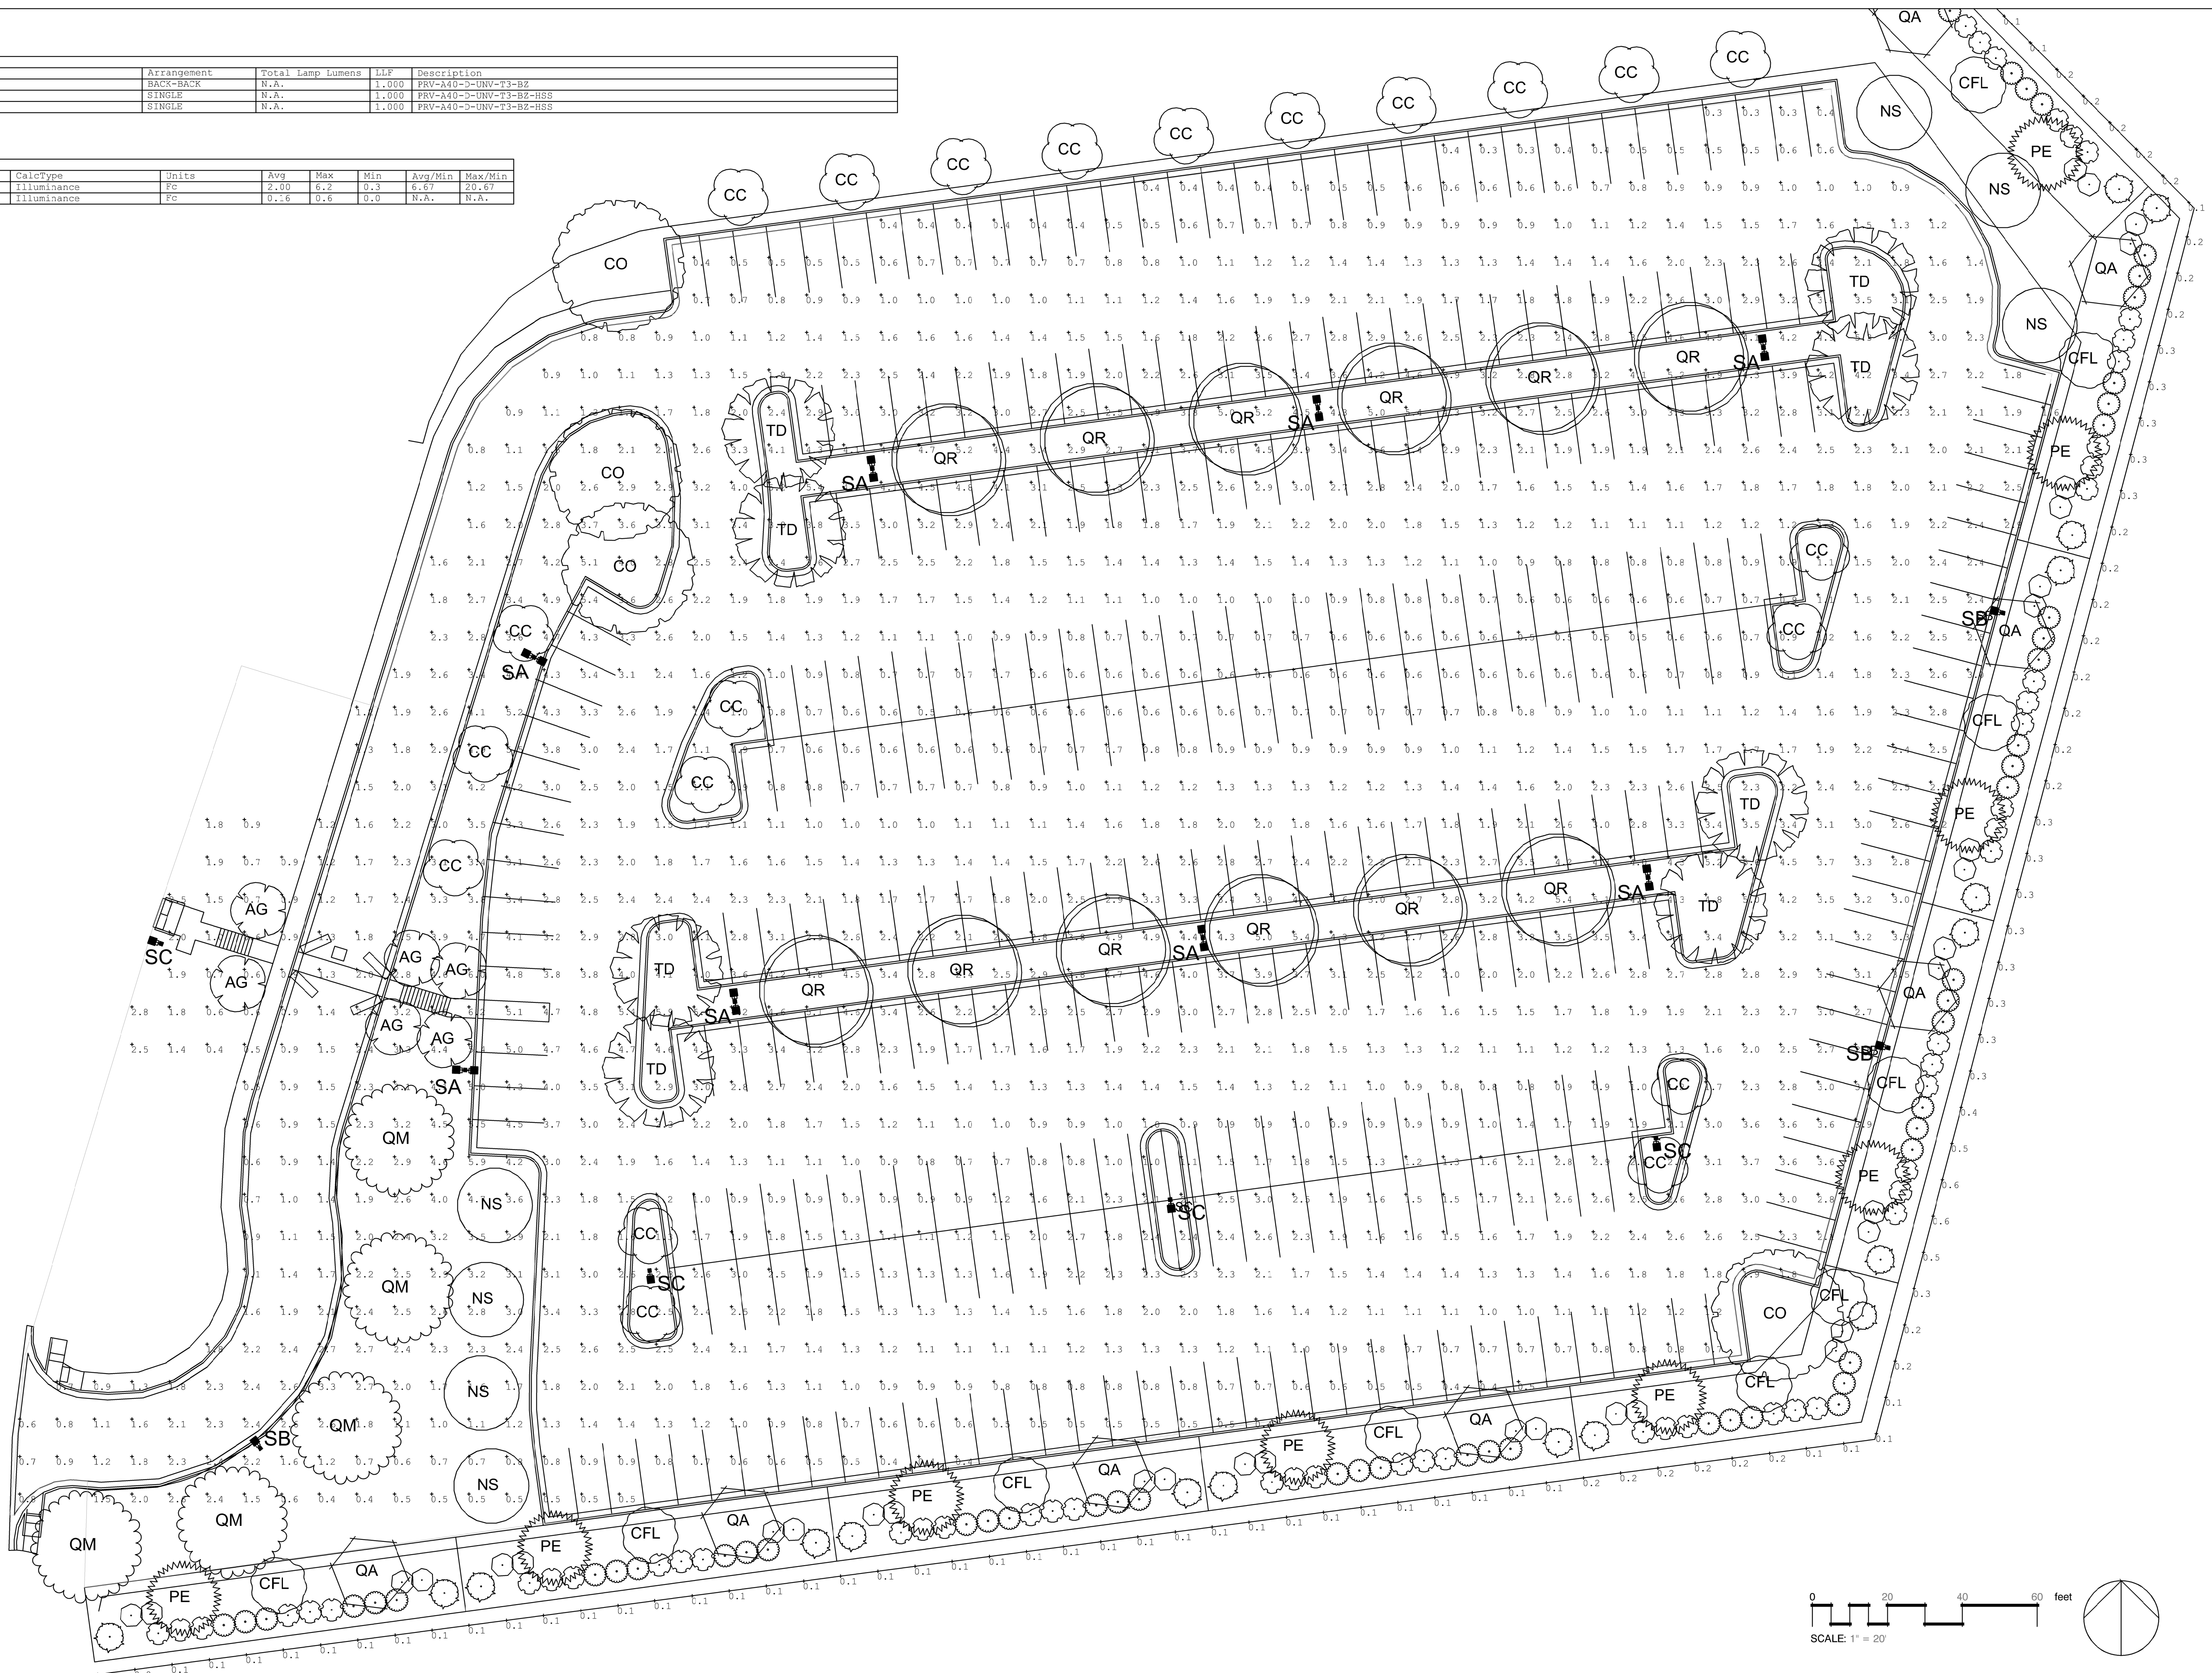


**RANDY BURKETT LIGHTING DESIGN**  
 Randy Burkett Lighting Design, Inc.  
 609 East Lockwood Avenue  
 Suite 201  
 St. Louis, MO 63119  
 Tel: (314) 961-6650  
 Fax: (314) 961-7640  
 www.rbltd.com

**MASTERCARD PARKING LOT E  
 APPLICATION SITE PLAN - CALCULATION**

PROJ #: 18716  
 DATE: 2018.10.01  
 Issued for Bid  
 REV: 10.18.18 REV 1  
 11.21.18 City Comments  
 12.20.18 City Submittal

SCALE: As Noted  
 DRAWING NO:

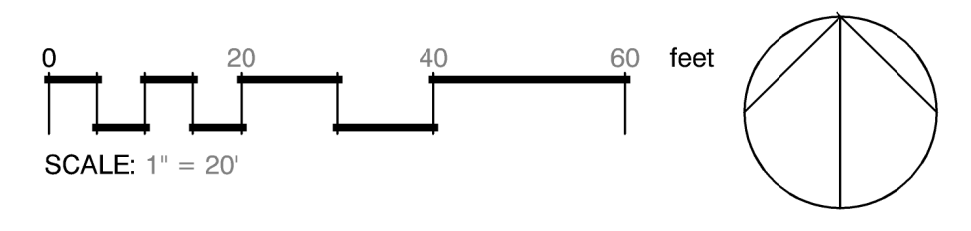

**L-2**