


Luminaire Schedule

Symbol	Qty	Label	Lumens	LLF	Description
⊕	2	A	36000	0.590	MCL3400MA
⊕	1	B	36000	0.590	MCL4400MA

Numeric Summary

Label	Units	Avg	Max	Min	Avg/Min	Max/Min
FC at Grade	Fc	1.33	13.9	0.0	0.00	0.00
FC at Property Line	Fc	0.07	0.4	0.0	0.00	0.00
FC @ Floor Parking Area	Fc	0.00	0.0	0.0	0.00	0.00

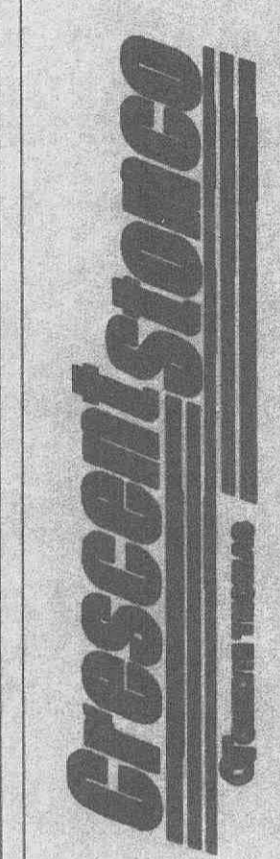

applications engineering  
2345 VAUXHALL ROAD UNION, NJ 07083 908-964-7000

SCALE: 1" = 30' - 0"  
DRAWN BY: F. GARZA  
DATE: JULY 7, 2003

Photometric data used in this design is based on industry procedures and tested in laboratory conditions. Field performance may differ from predicted values. Installation and electrical supply, equipment tolerances and/or obstructions within the lighted area and are not the responsibility of Crescent/Stonco or the GentryThomas Group.  
Light Loss Factor is based on Lamp Lumen Depreciation times Luminaire Dirt Depreciation.  
All Values are in Footcandles.

PROPOSED ILLUMINATION PLAN FOR:  
MIDWAY AGENCY  
PARKING LOT  
SITE LIGHTING PLAN

DRAWING NO.  
AP03168.AGI