




(IN FEET)
1 inch = 100 ft.

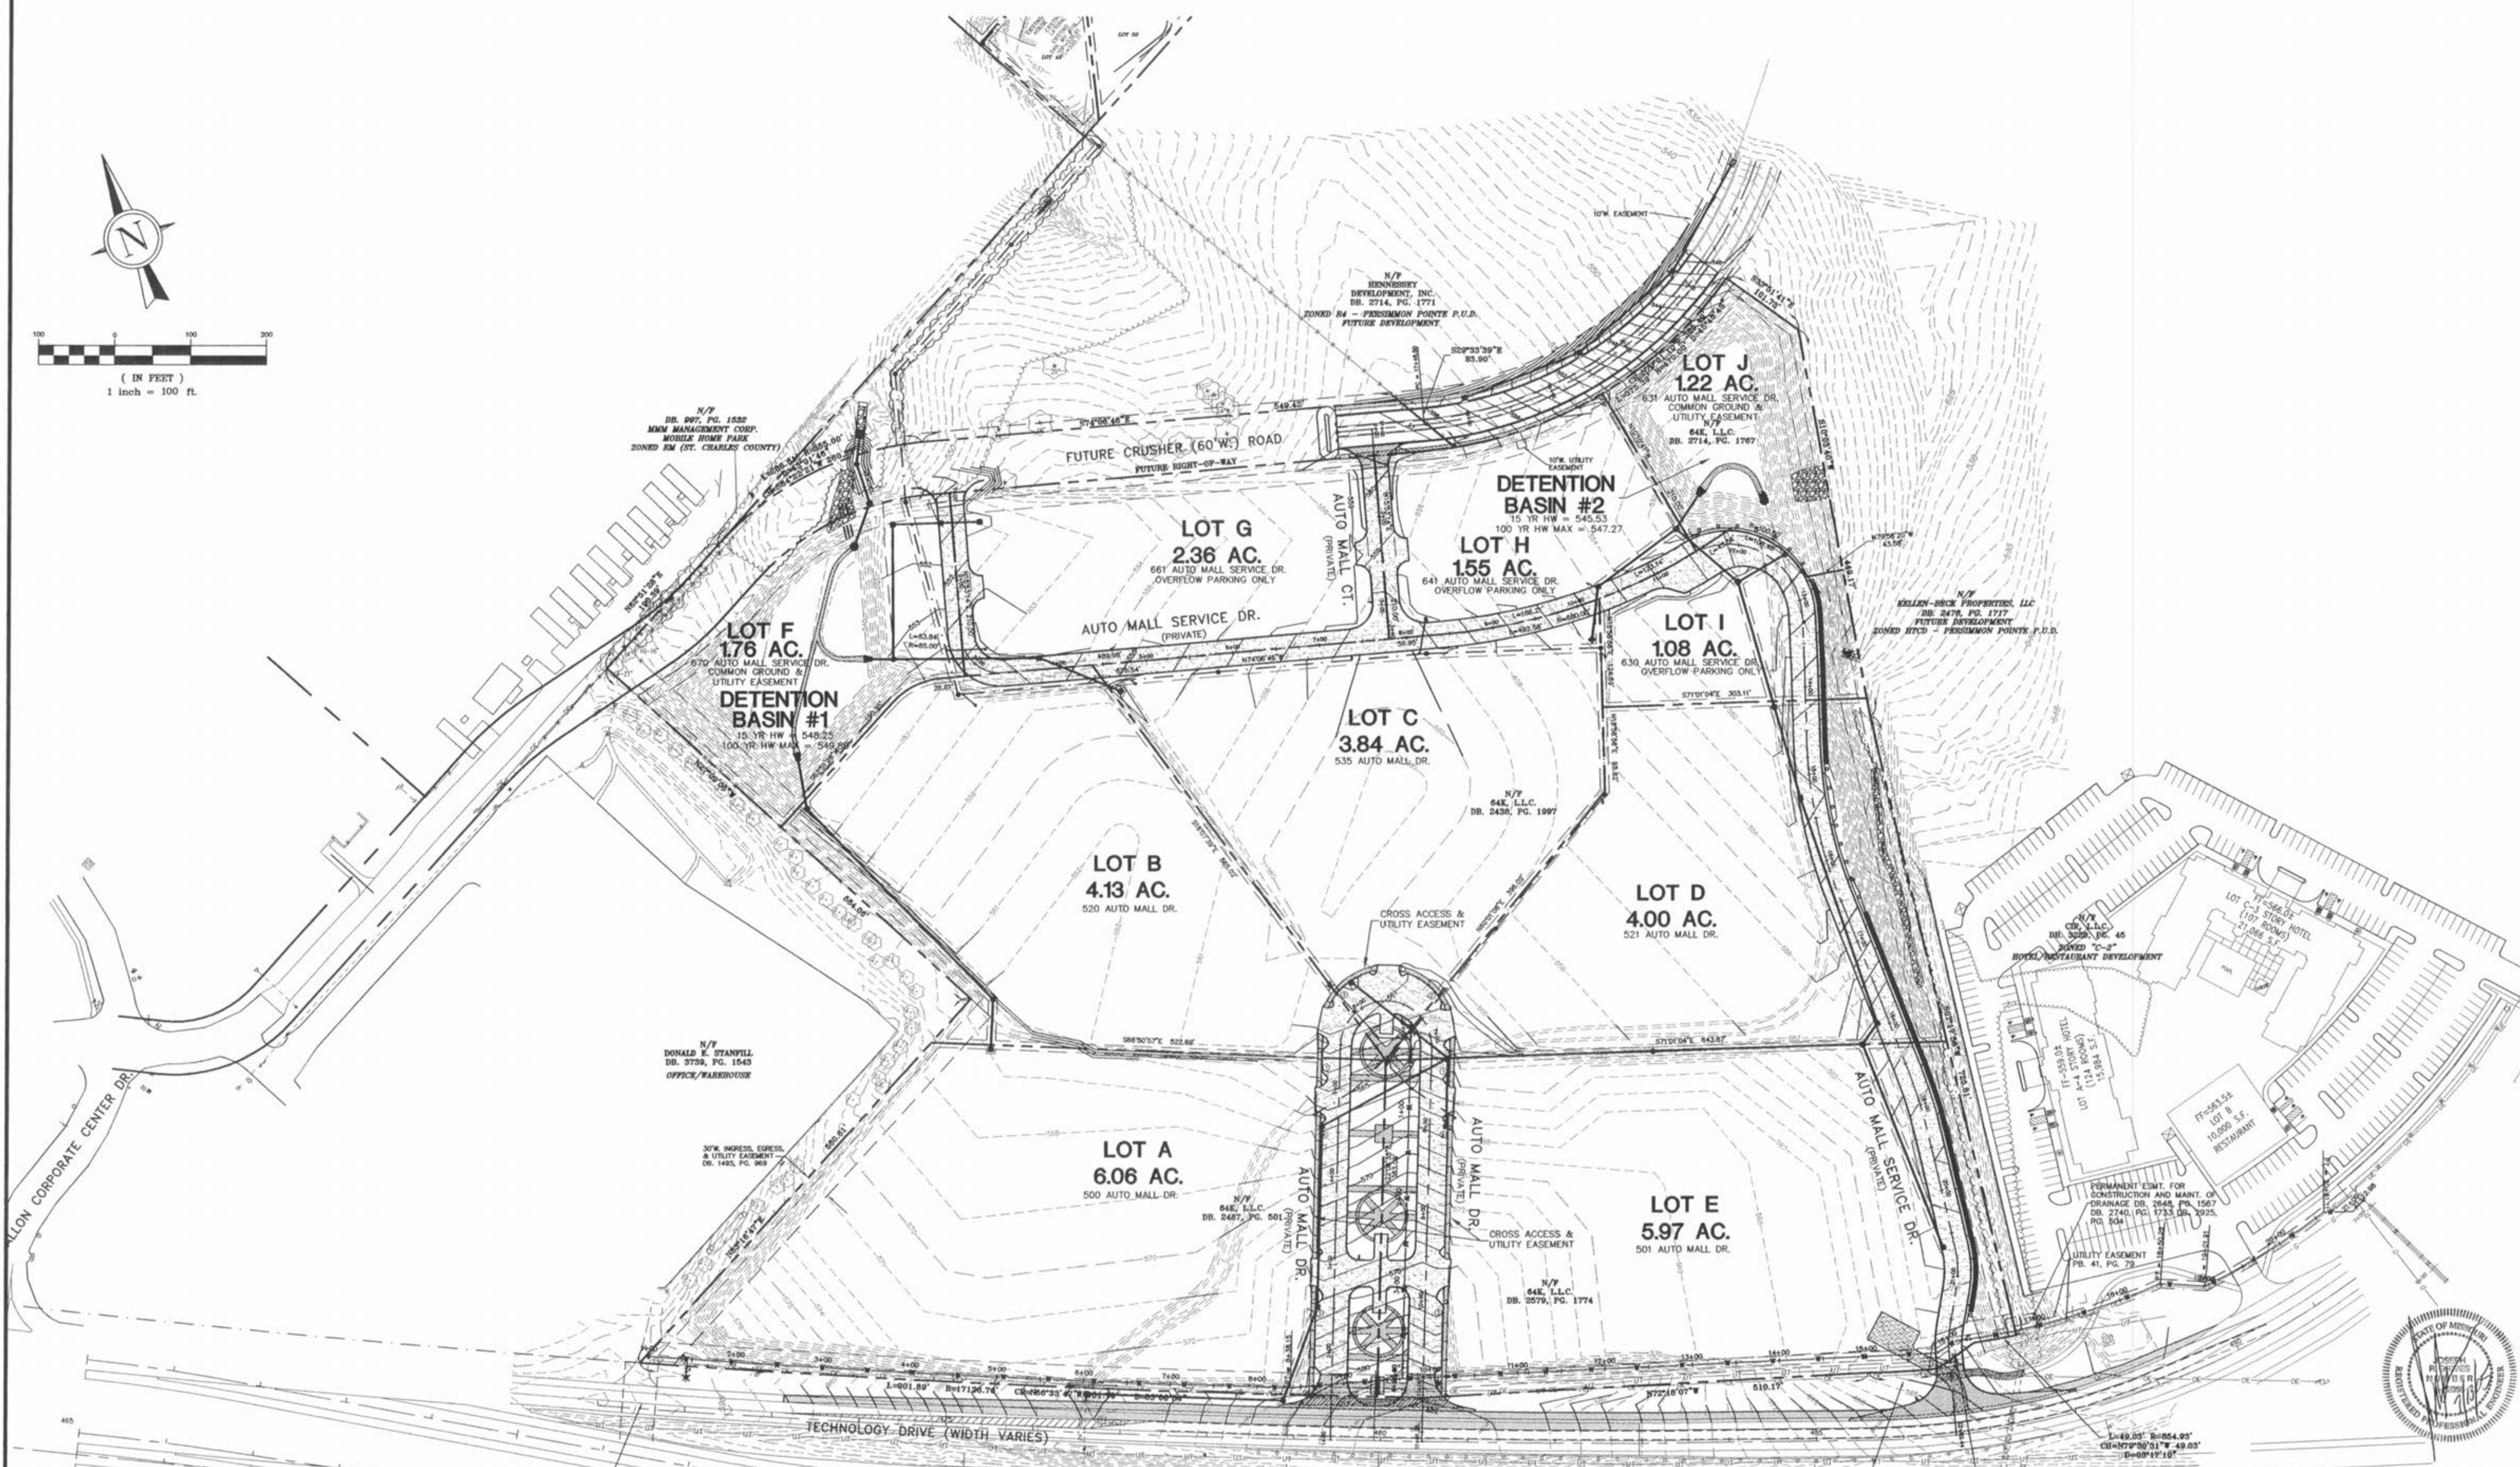

CAUTION:
BEWARE OF OVERHEAD &
UNDERGROUND UTILITIES

NOTES:

- 1) SEE SHEETS C4-5 FOR THE SITE PLAN
- 2) SEE SHEETS C6-7 FOR GRADING PLANS
- 3) SEE SHEETS C8-9 FOR GEOMETRICS PLANS
- 4) SEE SHEETS C10-11 FOR SANITARY PLAN AND PROFILES
- 5) SEE SHEETS C12-14 FOR STORM SEWER PROFILES
- 6) SEE SHEETS C15-16 FOR WATER PLAN AND PROFILES

05/23/05 PER CITY, WATER & SANITARY COMMENTS
 07/13/05 PER WATER DISTRICT COMMENTS
 06/30/05 PER CITY & MODOC COMMENTS

O'FALLON AUTO MALL			
OVERALL PLAN			
J. R. GRIMES		CONSULTING ENGINEERS, INC.	
DRAWN BY: JLW DATE: 04/08/05 CHECKED BY: LJM DATE: 04/08/05 JOB NUMBER: 675N SHEET: C3	12300 OLD TESSON ROAD SUITE 3000 ST. LOUIS, MO. 63128 PH. (314) 849-6100 FAX (314) 849-6010		

PREPARED FOR:
 BRINKMANN CONSTRUCTORS
 CONTACT: KEVIN JACOBMEYER
 16650 CHESTERFIELD GROVE RD, SUITE 100
 CHESTERFIELD, MO 63005
 PH: (636) 537-9700
 FAX: (636) 537-9880

P&Z FILE # 3101.05.03