

**OMNIPPOINT COMMUNICATIONS INC.**  
 2004 WESTPORT CENTER DRIVE  
 ST. LOUIS, MO 63146  
 OFFICE: (314) 812-3600  
 FAX: (314) 812-3692

**MIDWEST WIRELESS**  
 690 CANTON STREET  
 WESTWOOD, MA 02090  
 OFFICE: (718) 461-6840  
 FAX: (718) 461-6841

**SDS STRATA DESIGN SERVICES**  
 10190 Old Katy Road, Suite 340  
 Houston, Texas U.S.A.  
 Phone 713 . 463 . 6099  
 Fax 713 . 463 . 8731  
 Email drawings@stratagroup.net  
 SDS Job No: 0290

**APPROVALS**

OMNIPPOINT \_\_\_\_\_  
 LANDLORD \_\_\_\_\_  
 LEASING \_\_\_\_\_  
 R.F. \_\_\_\_\_  
 ZONING \_\_\_\_\_  
 CONSTRUCTION \_\_\_\_\_  
 A & E \_\_\_\_\_

PROJECT NO: MO-05-212 D  
 DRAWN BY: KH  
 CHECKED BY: R. PACHECO

**SUBMITTALS**

DATE	DESCRIPTION	REV
05-02-00	ZONING REVIEW	A
05-05-00	GENERAL REVISION	B
06-26-00	FINAL ZONING	C
06-30-00	CONSTRUCTION REVIEW	C
08-18-00	ISSUE FOR CONSTRUCTION	1

THE INFORMATION CONTAINED IN THIS SET OF DOCUMENTS IS PROPRIETARY BY NATURE. ANY USE OR DISCLOSURE OTHER THAN THAT WHICH RELATES TO OMNIPPOINT COMMUNICATIONS INC. IS STRICTLY PROHIBITED.


SITE NAME  
 MO-05-212 D  
 NORTH ST. PETERS

SHEET TITLE  
 ELECTRICAL SITE PLAN


SHEET NUMBER  
 E-1  
 SHEET 9 of 16 SHEETS

**LEGEND**

—x—x—x—x—x—x—x— CHAIN-LINK FENCE  
 - - - - - PROPERTY LINE  
 —OH— OVERHEAD TELEPHONE AND/OR OVERHEAD POWER  
 —UG— UNDERGROUND UTILITY LINES  
 - - - - - UTILITY EASEMENT

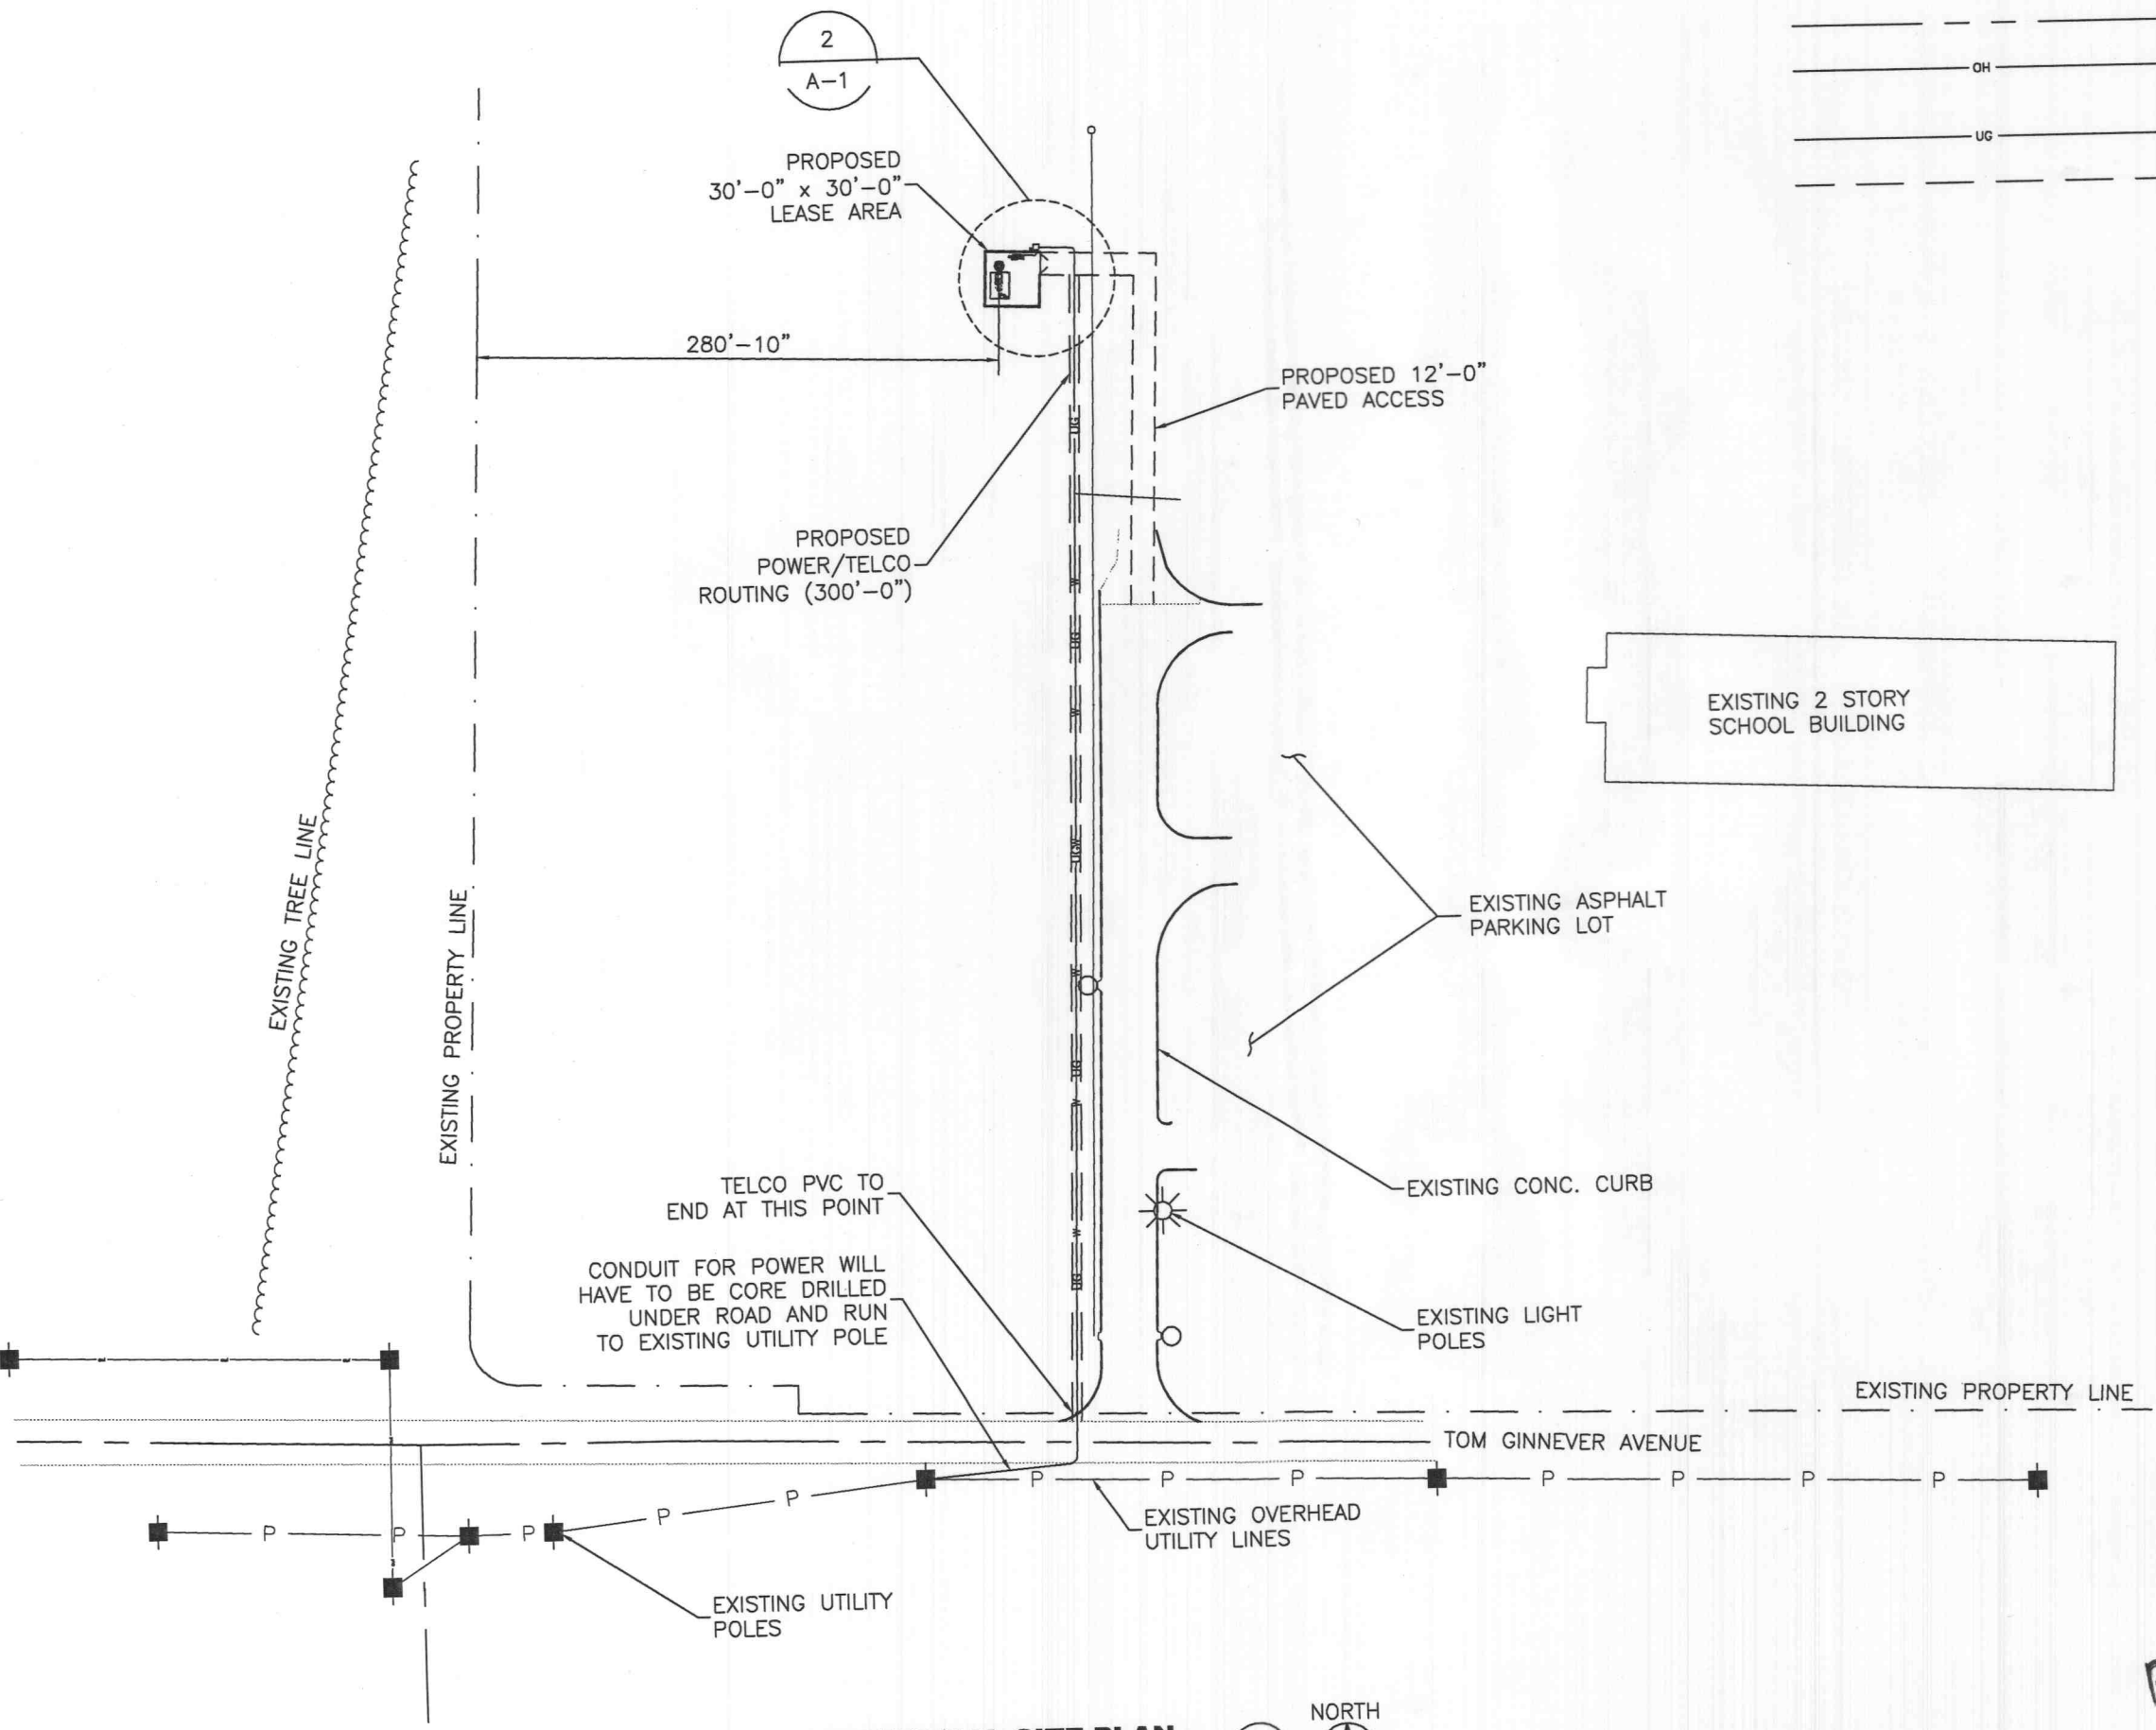

 **ELECTRICAL SITE PLAN**  
 11x17 SCALE: 1"=50'-0"  
 24x36 SCALE: 1"=100'-0"



DATE SIGNED: 09-14-00