


1 GYP. BD. CEILING DETAIL
A3.1 SCALE: 1 1/2" = 1'-0"

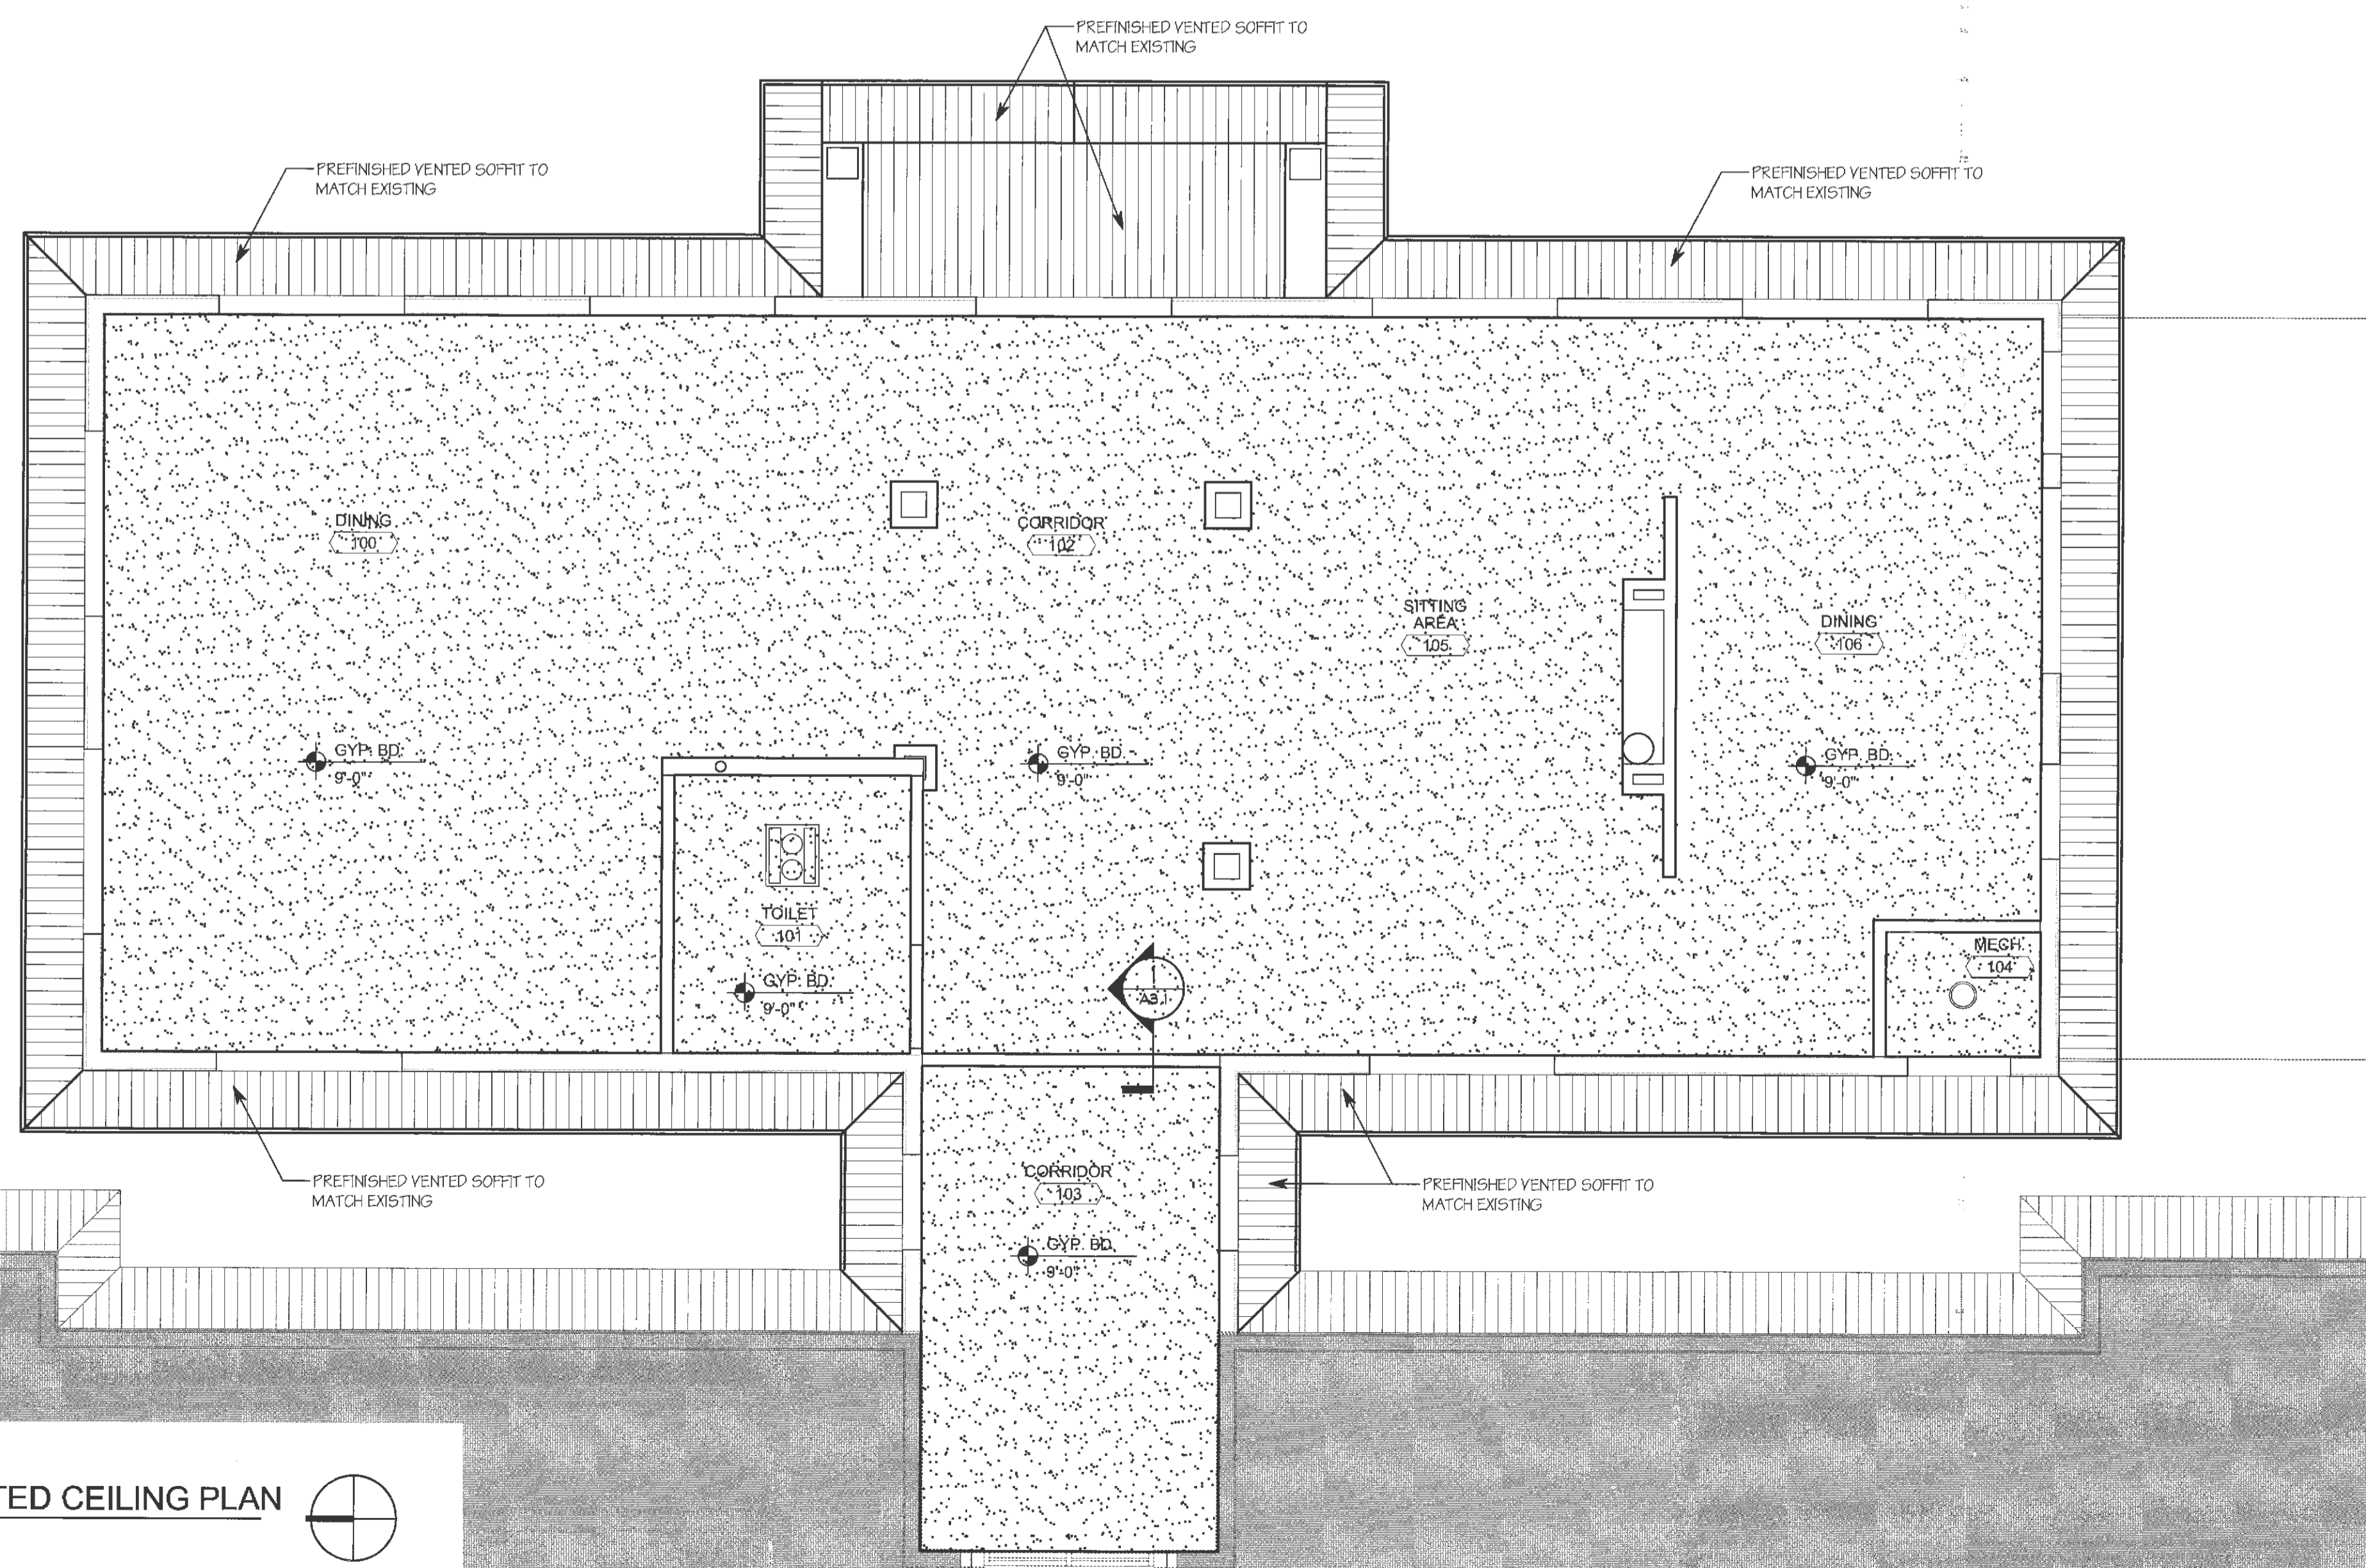

LEGEND GENERAL NOTES

- VERIFY EXACT LOCATION OF ALL CEILING MOUNTED EQUIPMENT WITH USER PRIOR TO INSTALLATION AND COORDINATE WITH ELECTRICAL DRAWINGS.
- ITEMS IN LEGEND ARE NOT TO SCALE. (DO NOT SCALE)
- UNITS/ APARTMENTS' CEILING HEIGHTS ARE TO UNDERSIDE OF GYP CEILING, UNLESS MAINTAIN REQUIRED U.L. ROOF RATING.

LEGEND

GYPSUM WALL BOARD


2 REFLECTED CEILING PLAN
A3.1 SCALE: 1/4" = 1'-0"

ELECTRICAL: TBD
FIRE PROTECTION: TBD
CONSULTING ENGINEERS
RUFF CONSULTING ENGINEERS
1000 S. GARDNER SUITE 100
ST. LOUIS, MO. 63101
P. 314.535.0262

CONTRACTOR
ARCO
CONSTRUCTION
THE DESIGN BUILD PEOPLE
800 NORTH ROCK HILL ROAD
ST. LOUIS, MO. 63101

ARCHITECT
CMA
ARCHITECTS
800 NORTH ROCK HILL ROAD
ST. LOUIS, MO. 63101

A BUILDING ADDITION FOR:
Park Place

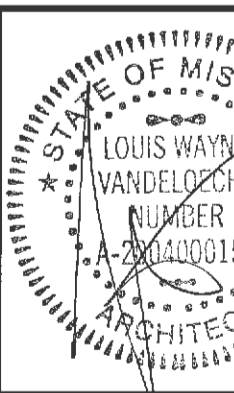

JOB NO: SJ1408
PA: RJR
PERMIT SET: 07-21

REVISIONS

SHEET NUMBER
A3.1
REFLECTED CEILING