




DISCLAIMER OF RESPONSIBILITY
 I hereby specify that the documents intended to be authorized by my seal are limited to this sheet, and I hereby disclaim any responsibility for all other Drawings, Specifications, Estimates, Reports or other documents or instruments relating to or intended to be used for any part or parts of the architectural or engineering project or survey.

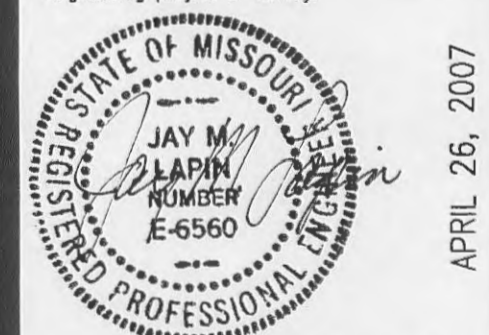

APRIL 26, 2007


EXPIRES DEC. 31, 2007		
NO.	DATE	
1	3/19/07	CITY RESUBMITTAL
2	4/26/07	CITY RESUBMITTAL

PROJECT NO. 980324	CONTRACT NO. 0011
DRAWN DGN	CHECKED JML
DATE 1/16/07	


DETENTION FACILITY DETAILS

SHEET **3** OF **5**


C2

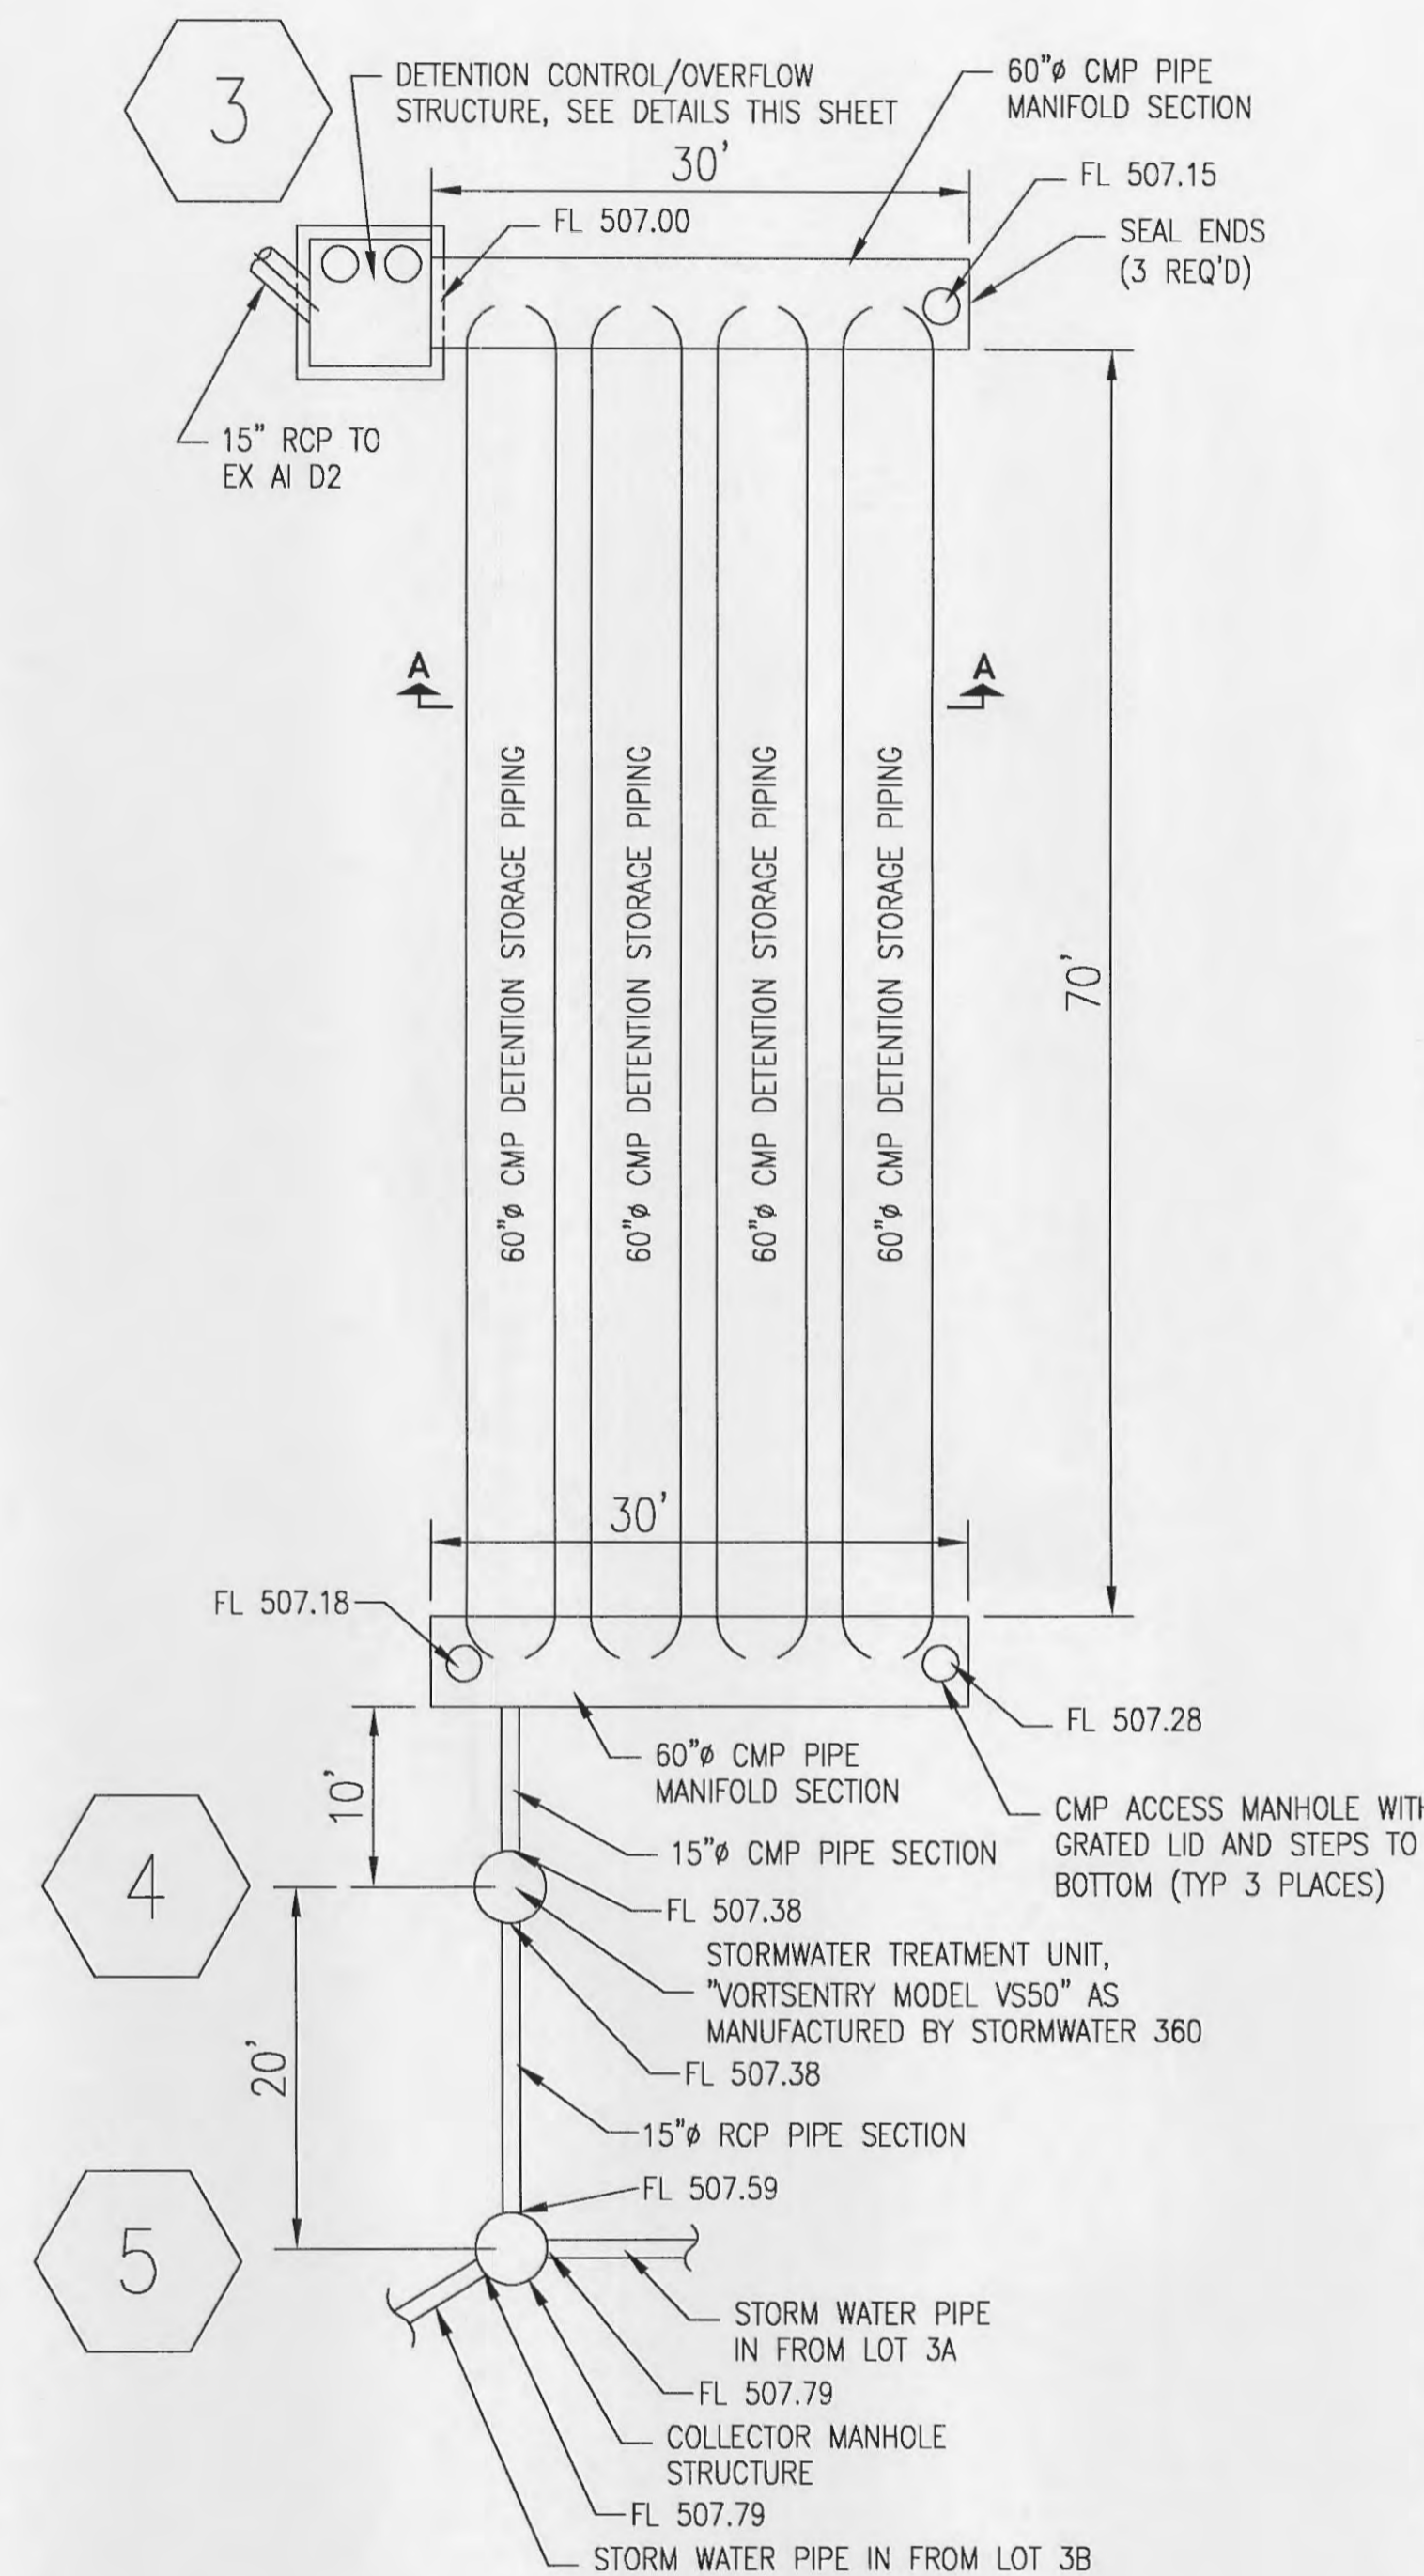


DETENTION PIPING LAYOUT DETAIL
 SCALE: 1"=10'

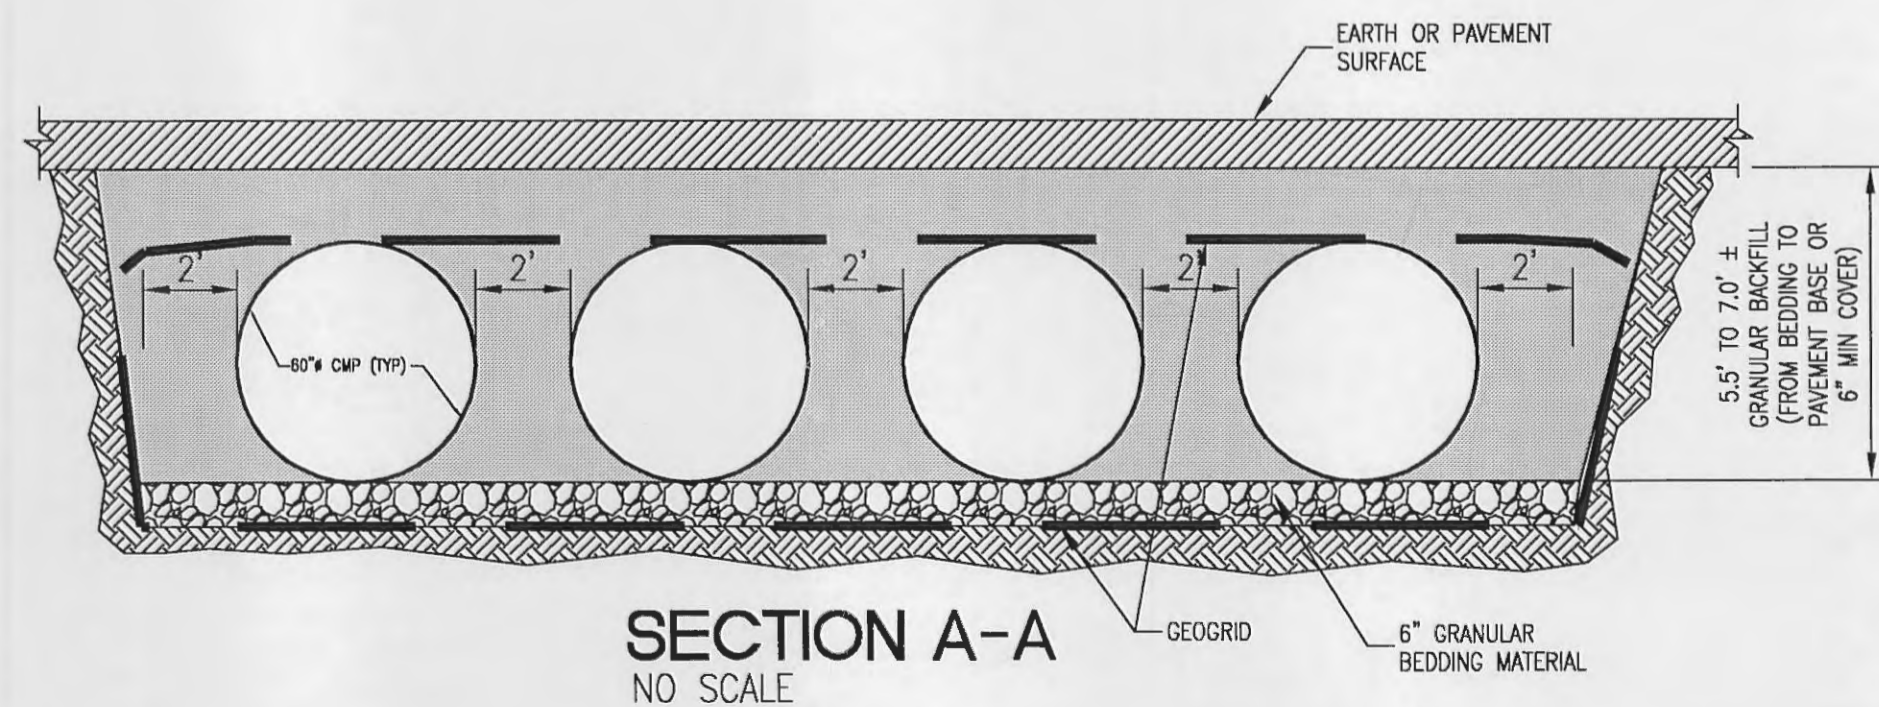


SECTION A-A
 NO SCALE

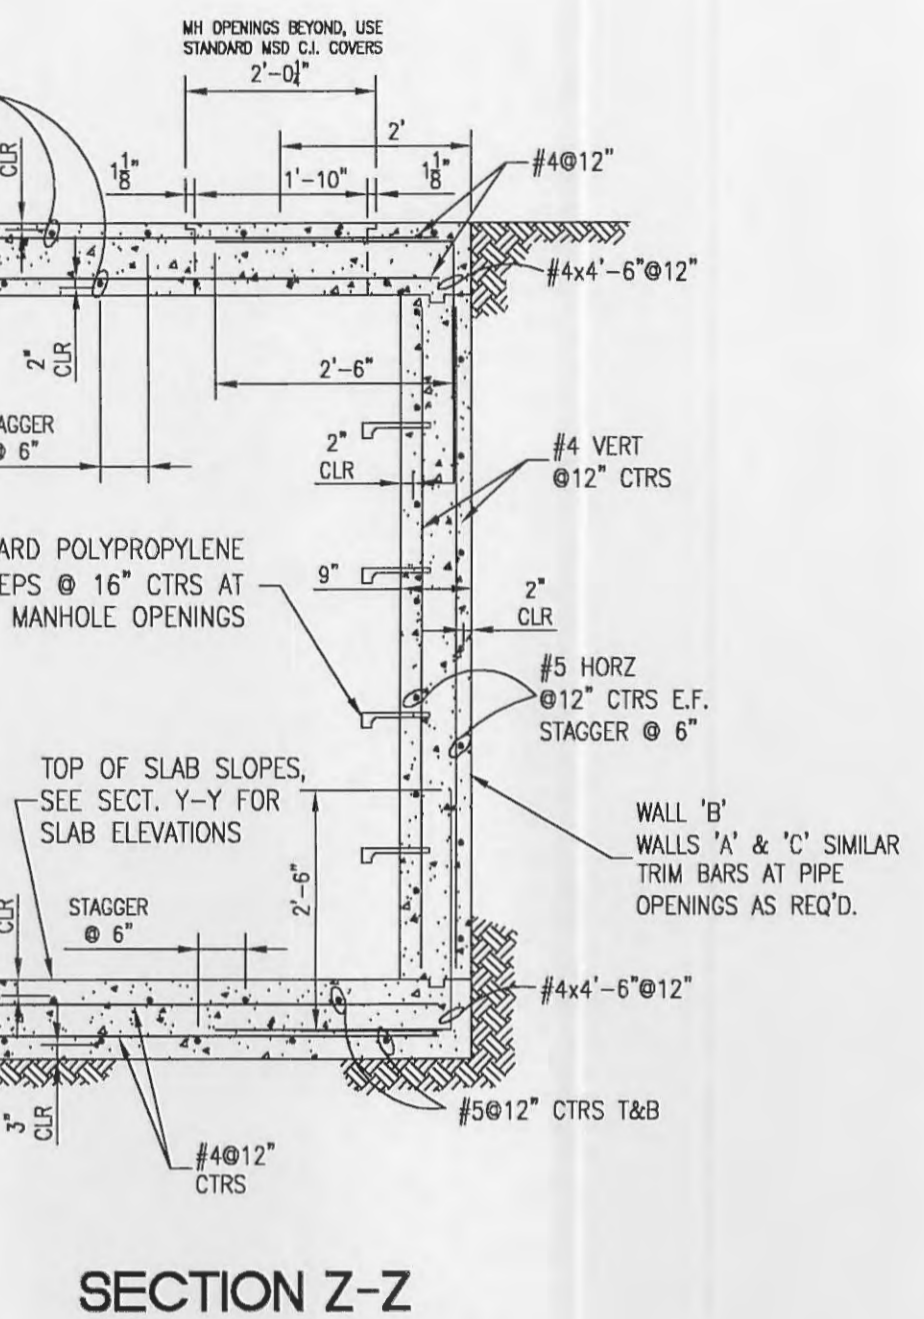


SECTION Z-Z

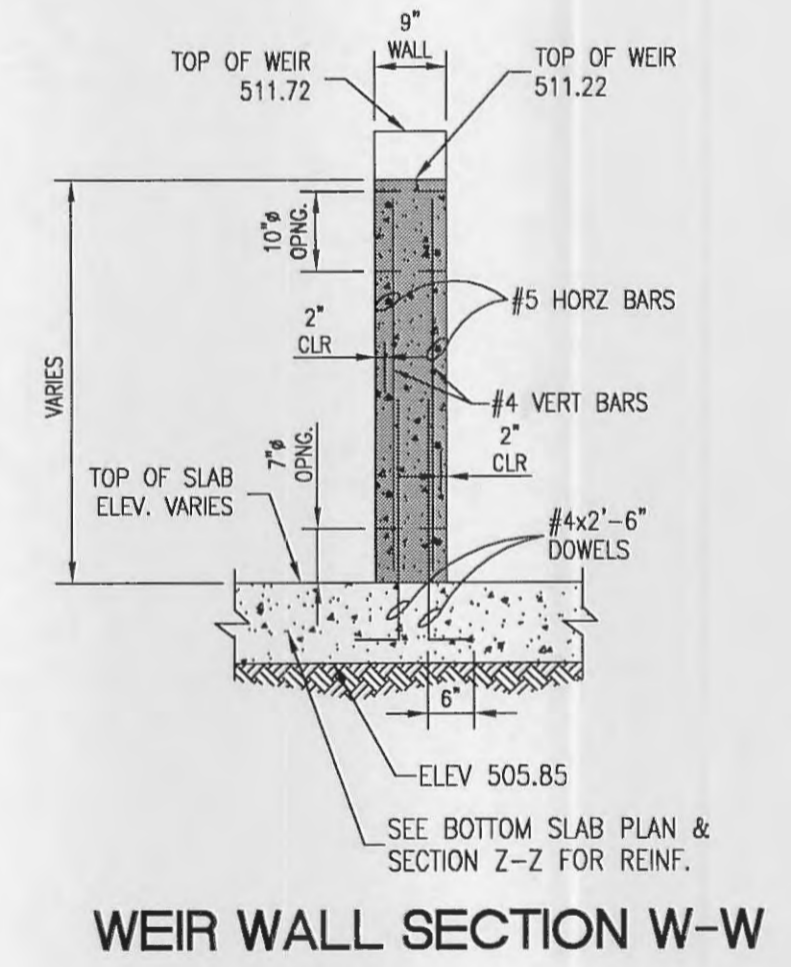


WEIR WALL SECTION W-W

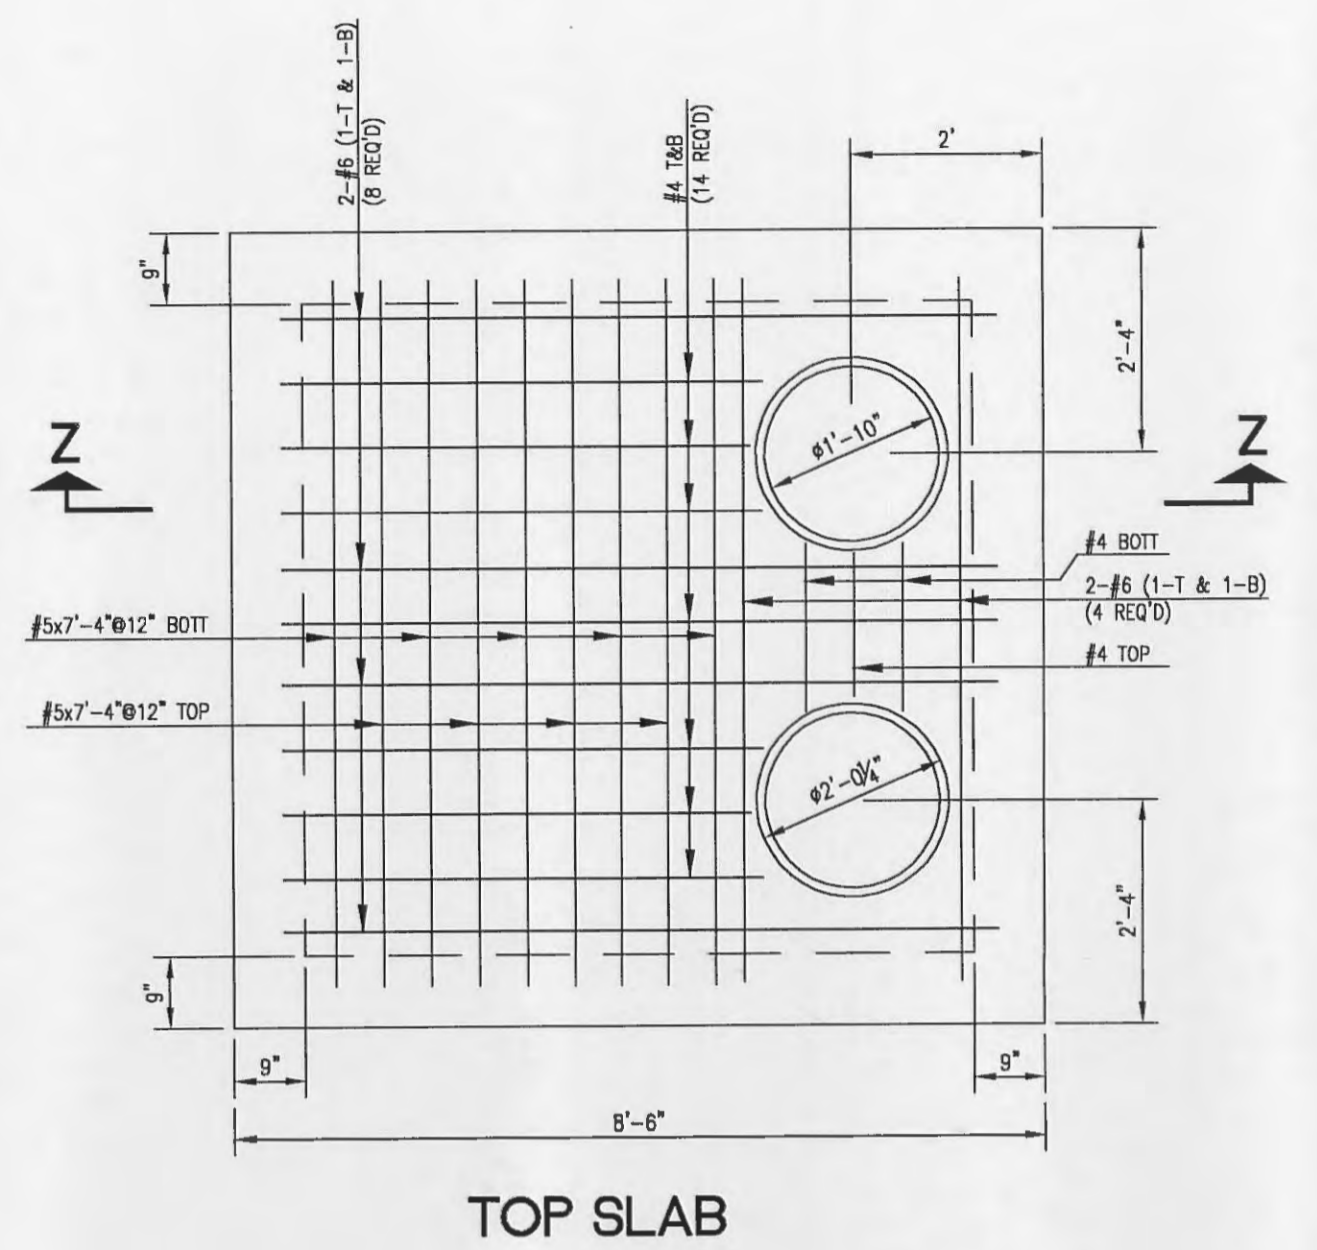


TOP SLAB

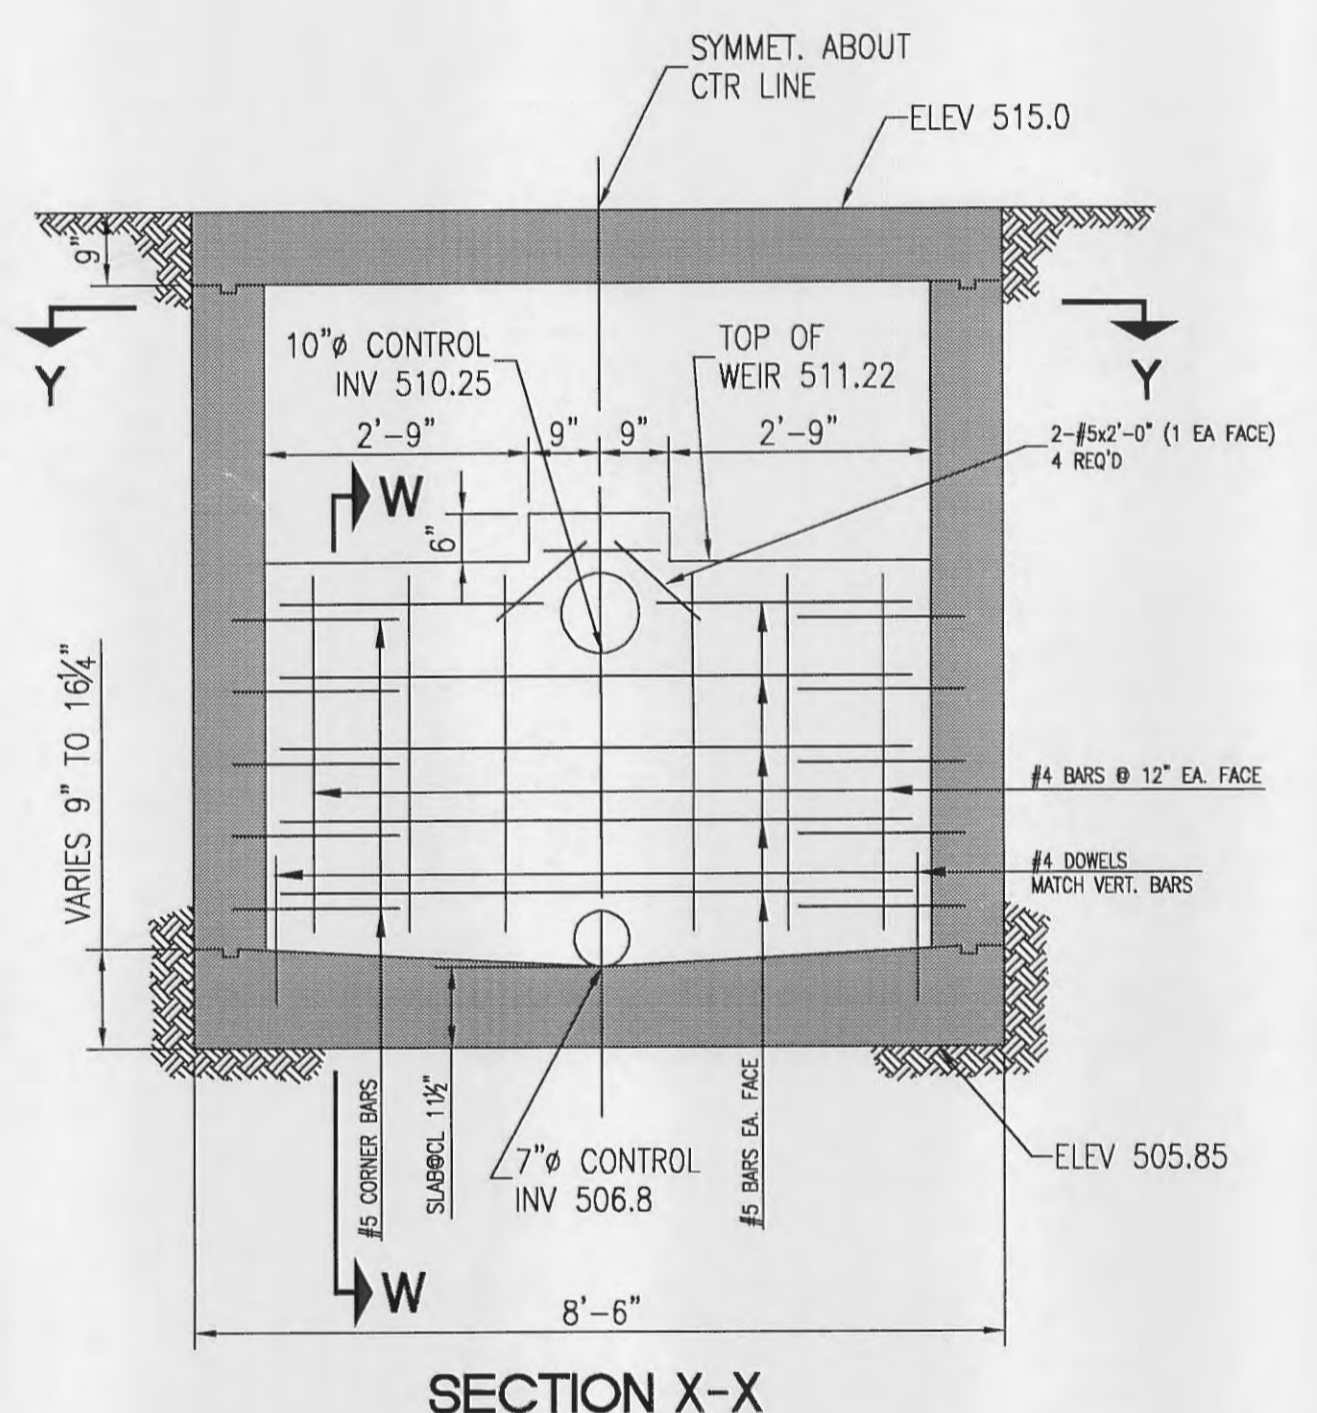

SECTION X-X

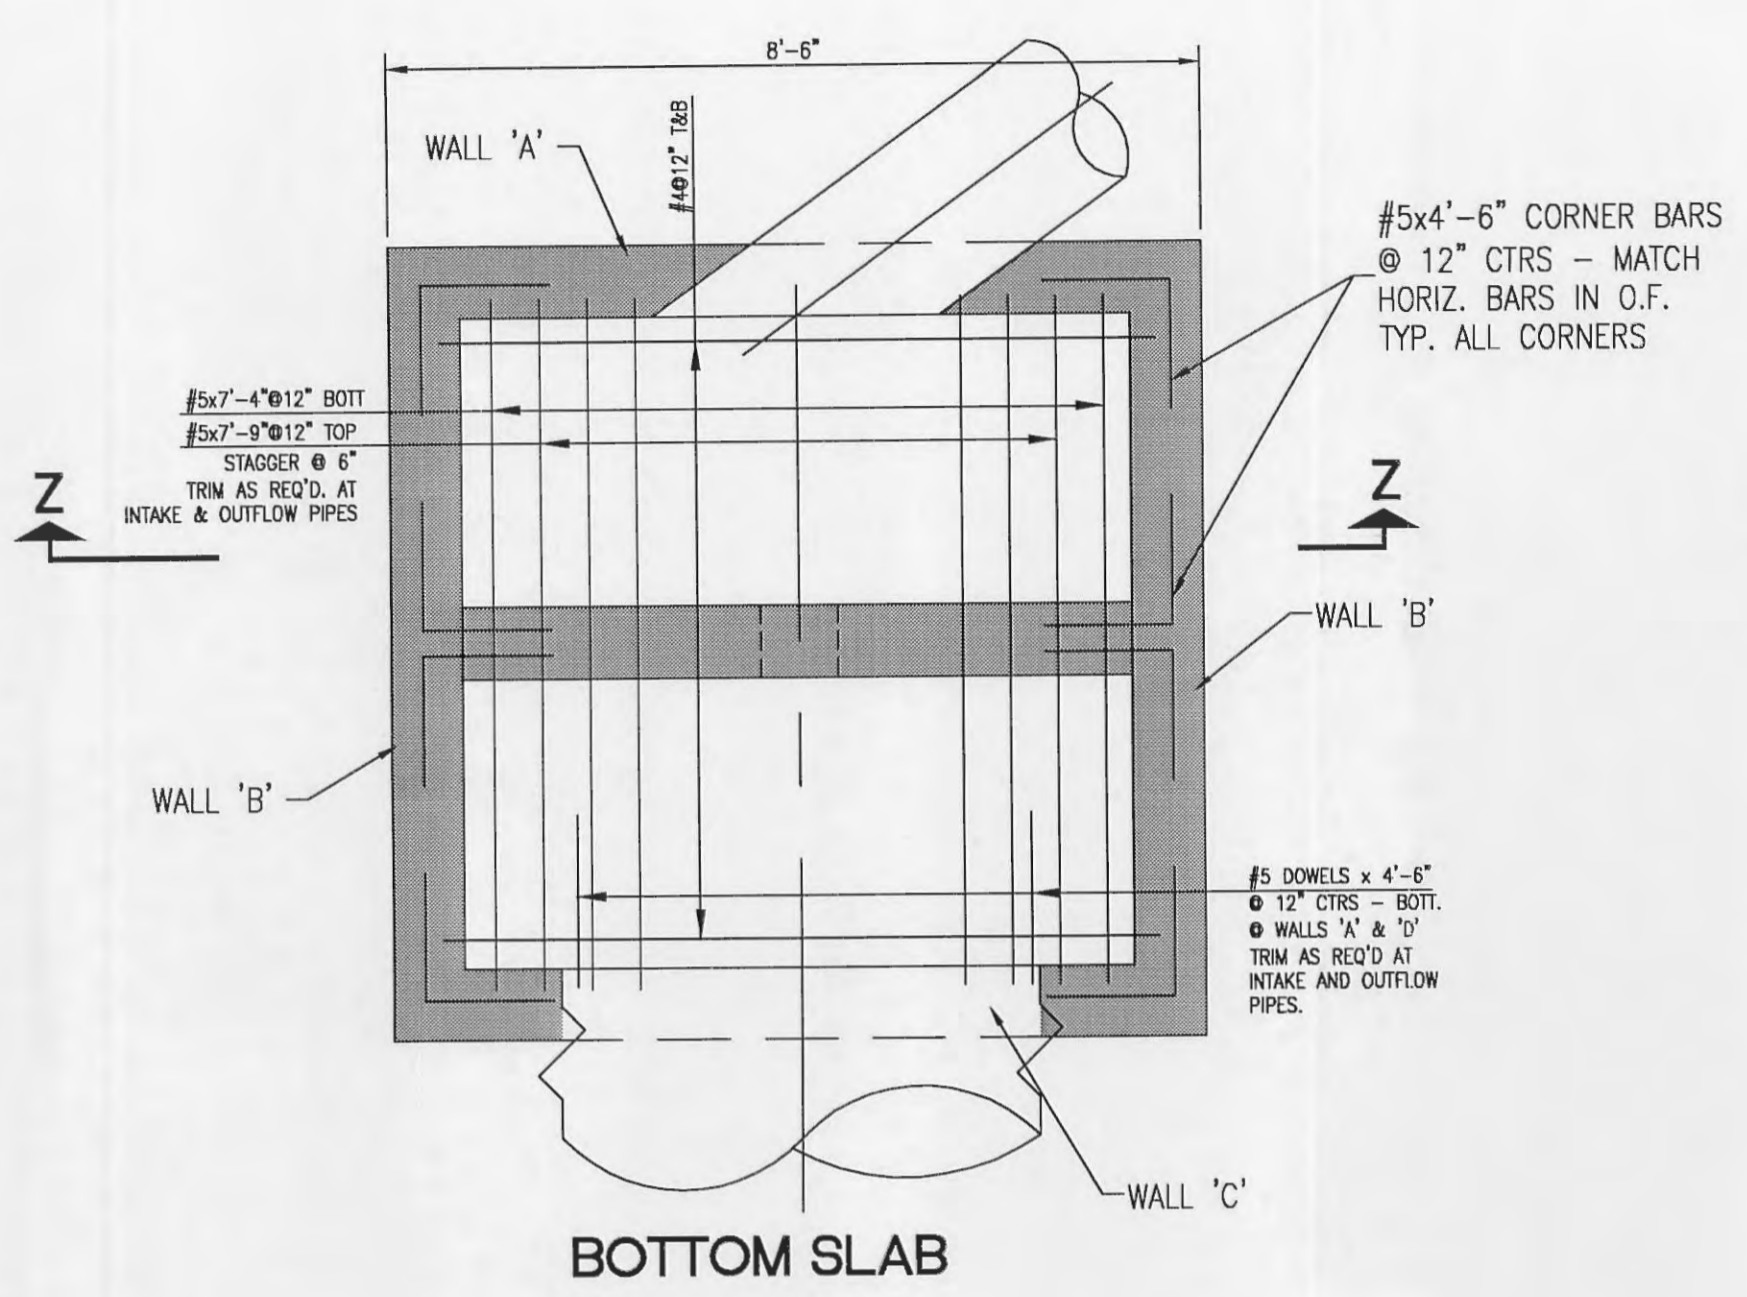

BOTTOM SLAB

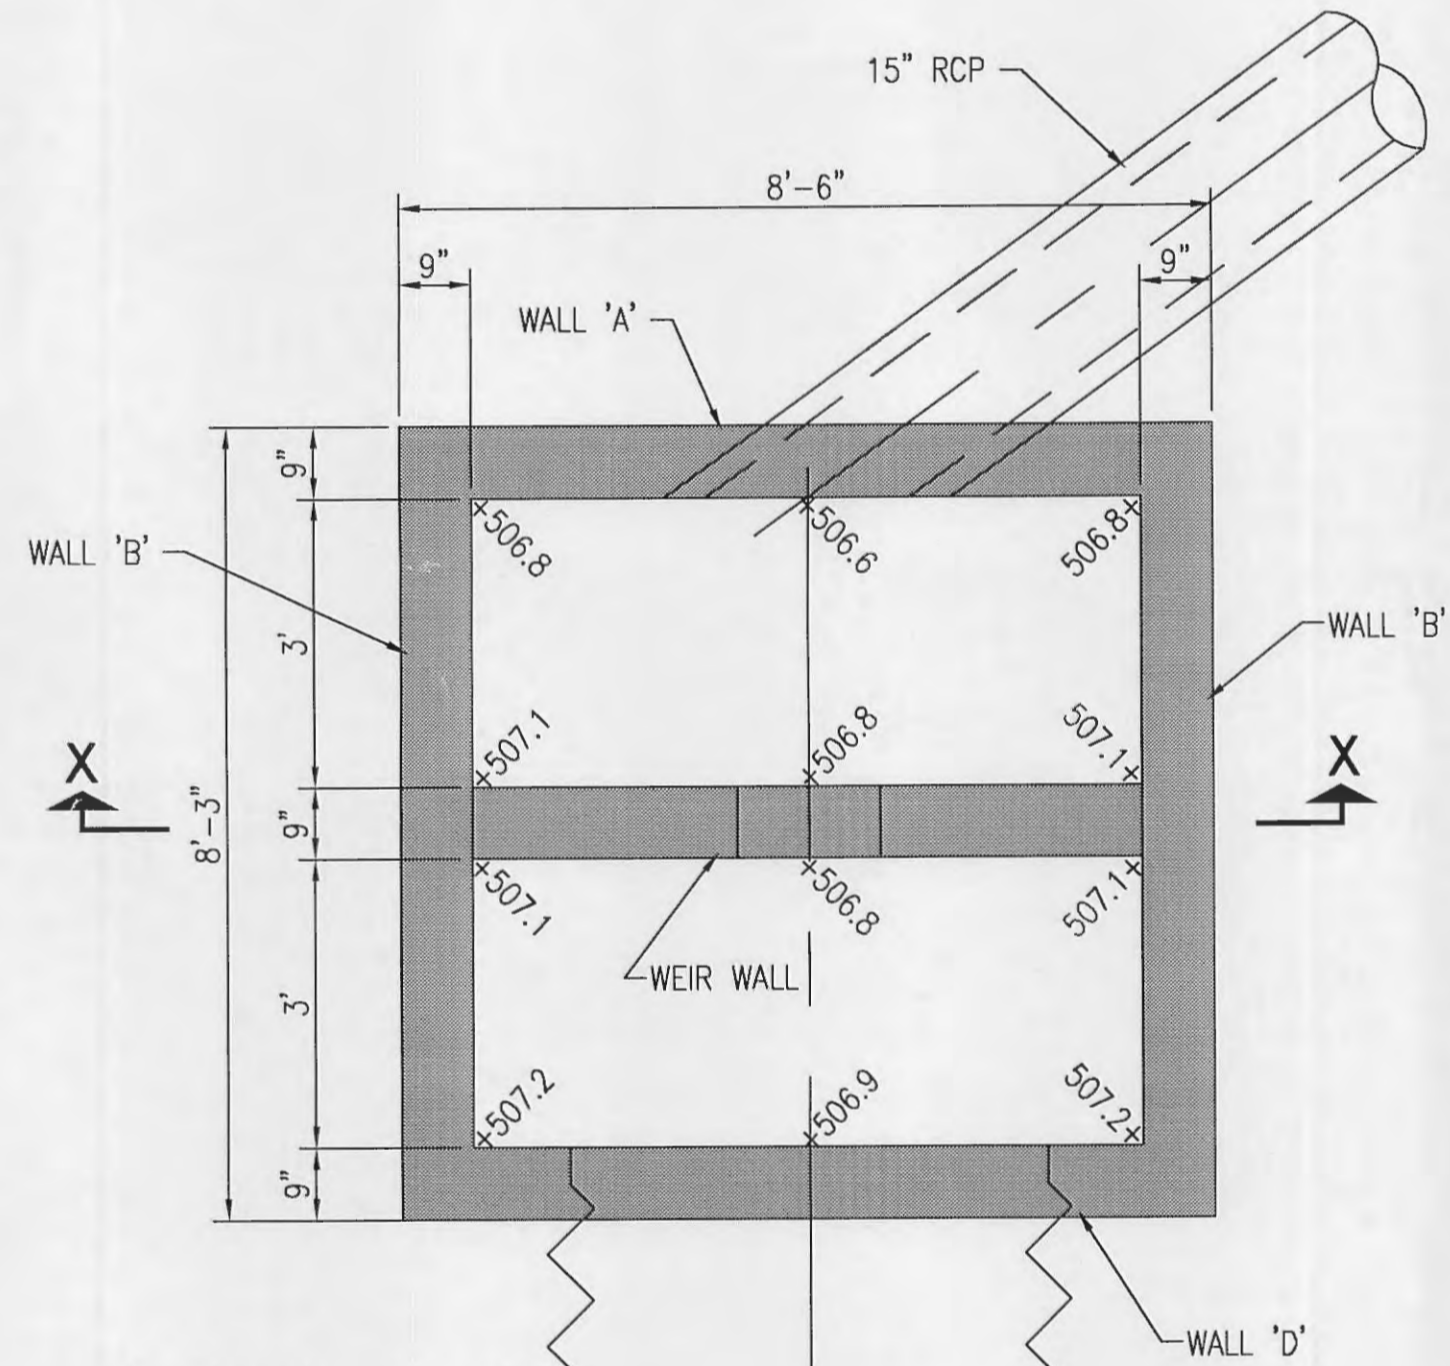

SECTION Y-Y

DETENTION CONTROL/OVERFLOW STRUCTURE DETAILS
 SCALE: 1/2"=1'