


GRAPHIC SCALE



( IN FEET )  
1 inch = 60 ft.

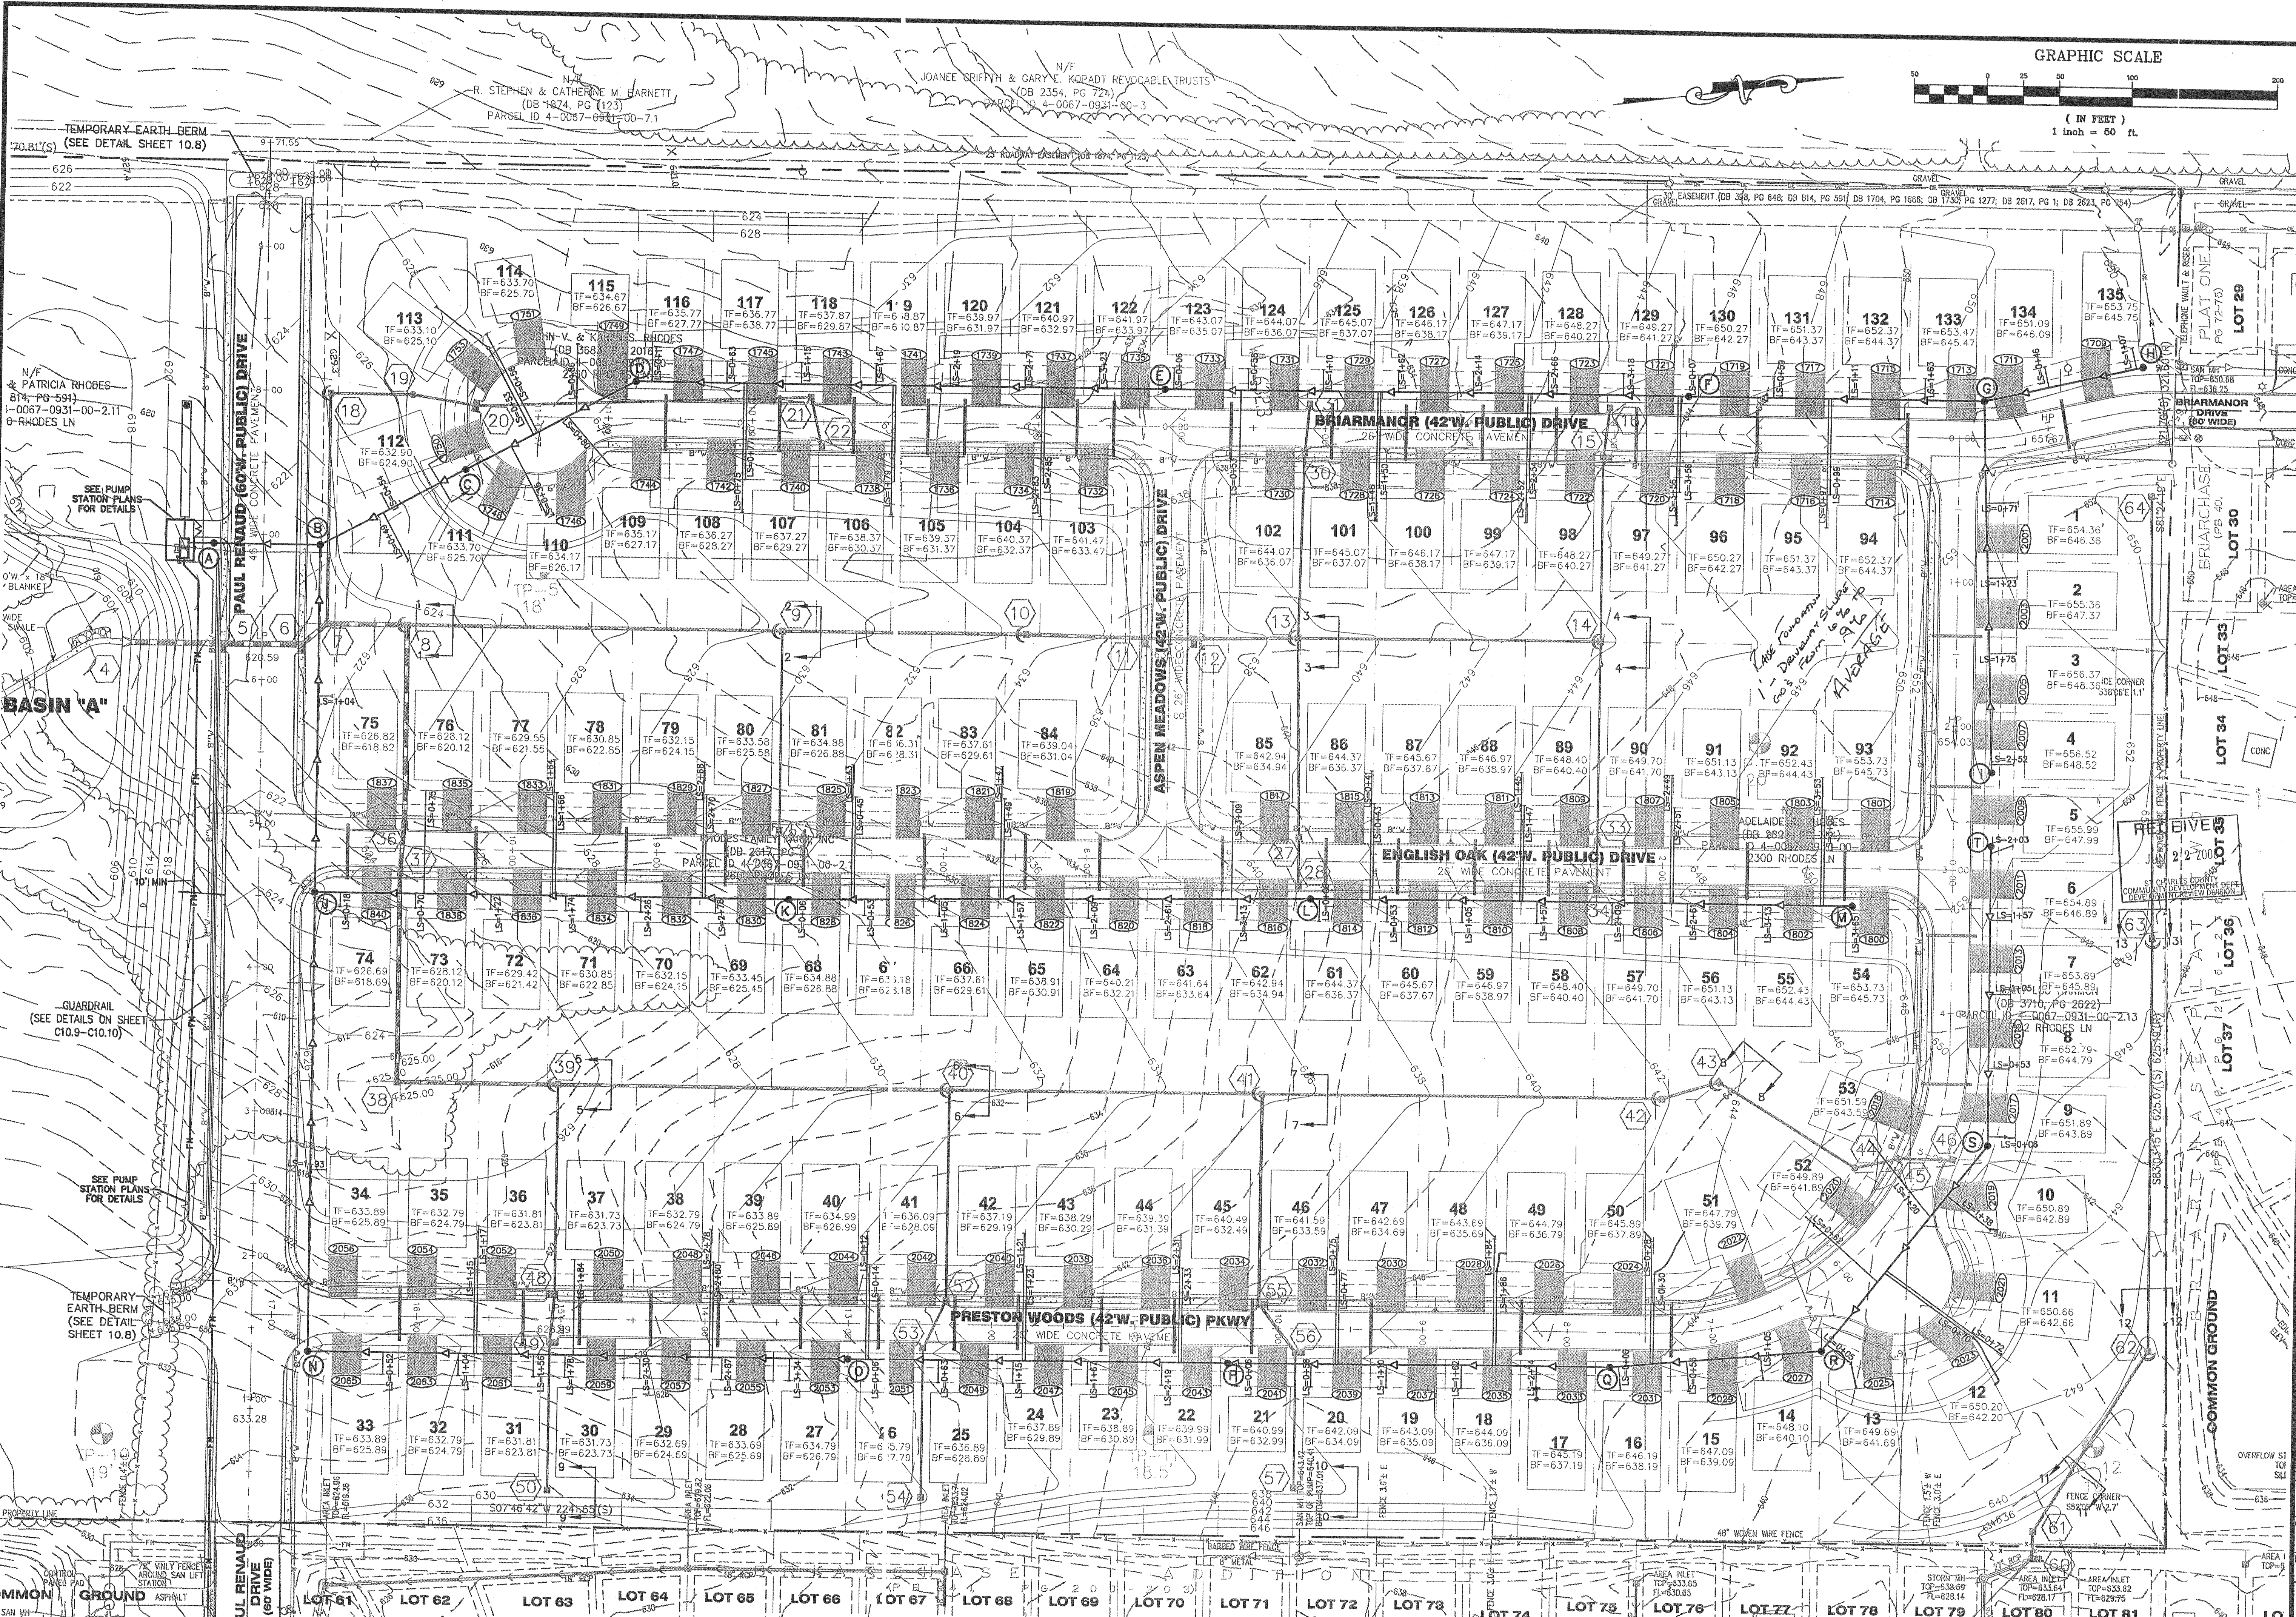


USER: kwright TAB: C5.4  
DATE: Jun 21, 2006 1:31pm  
DRAWING: S:\055\Job2005\CG-340\LD5\_05-340\PHASE IMPROVEMENT PLANS\O\_PLAN\_C5.3 SANITARY PLAN.dwg

REVISIONS

DATE	BY	REVISION
4/29/06	ST. CHARLES CO. REVIEW COMMENTS	
5/19/06	ST. CHARLES CO. REVIEW COMMENTS	
6/9/06	BUCKET CREEK SAN DIST COMMENTS	
6/21/06	PHASE #2 REVIEW COMMENTS	
6/21/06	COURTY COMMENTS	

DEVELOPER/OWNER:  
**THE JONES COMPANY HOMES, L.L.C.**  
16640 CHESTERFIELD GROVE, SUITE 160  
CHESTERFIELD, MO 63005  
PHONE: (636) 537-7192

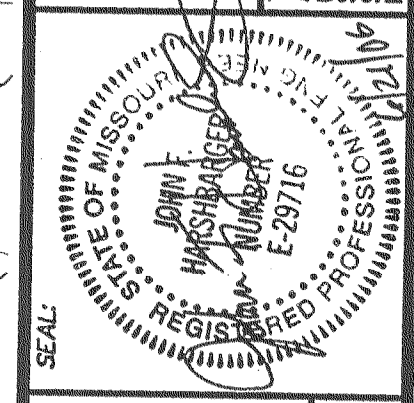

DESIGNED BY: **JKW**  
DRAWN BY: **BJ**  
CHECKED BY: **JFH**  
DATE: **2/2/06**

planning • engineering • surveying • landscape architecture  
**Cole and Associates Incorporated**  
10777 sunset office dr. suite 10  
saint louis, missouri 63127  
p. 314 984 8887 f. 314 984 0587

DESIGNED BY: **JKW**  
DRAWN BY: **BJ**  
CHECKED BY: **JFH**  
DATE: **2/2/06**  
Job Number: **05-340**  
Sheet Number: **C5.4**

SEE SHEET 10.14 FOR CROSS SECTIONS