
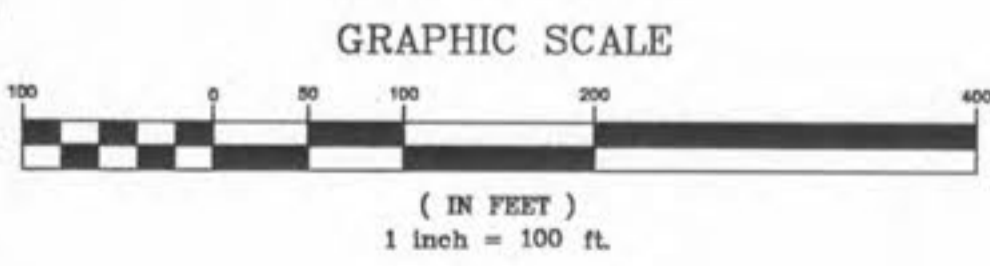


USER: Wilson TAB: C5.3
 DATE: Aug 12, 2008 - 7:46am
 DRAWING: S:\V085\woods2008\08-0003\plan_C05.3 SANITARY PLAN.dwg

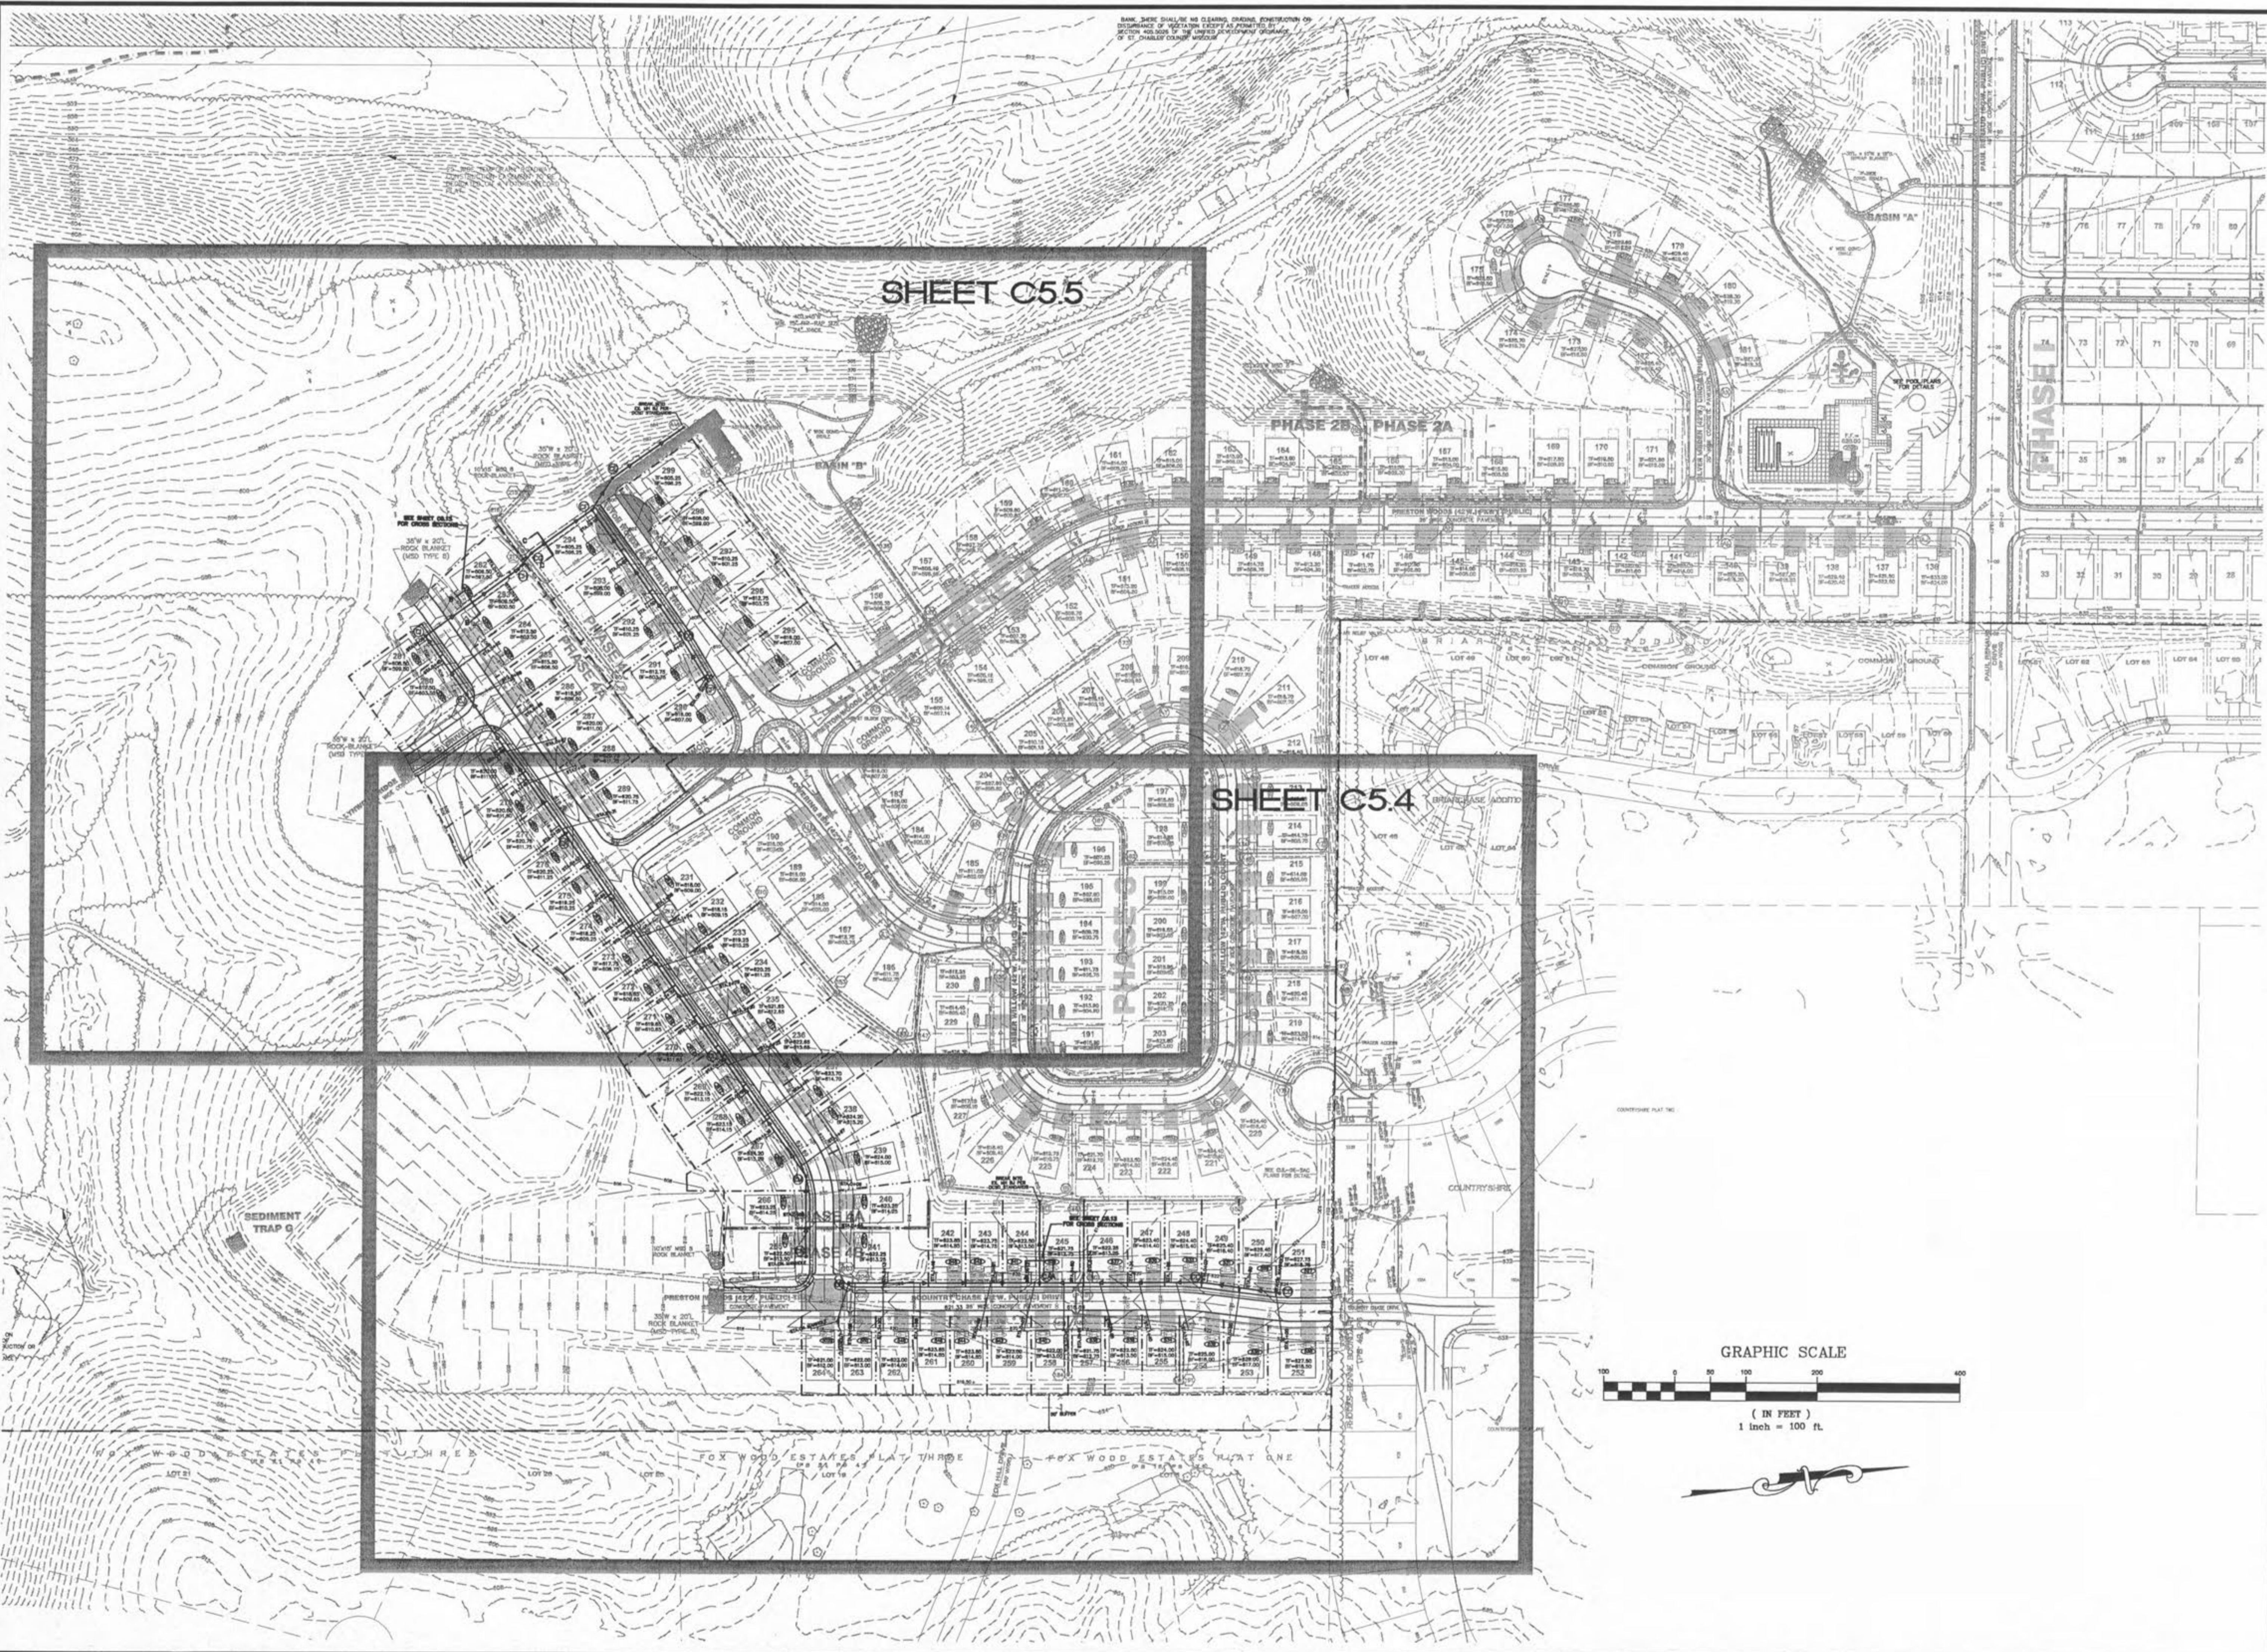

REVISIONS

DATE	BY	DESCRIPTION
8/12/08	JKW	ISSUED FOR PERMITS
7/10/08	JKW	ISSUED FOR PERMITS

DEVELOPER/OWNER:
 THE JONES COMPANY HOMES, L.L.C.
 16640 CHESTERFIELD GROVE, SUITE 200
 CHESTERFIELD, MO 63005
 PHONE: (636) 537-7192



PRESTON WOODS - PHASE 4
 IMPROVEMENT PLANS
 PRESTON WOODS LANE
 OF FALLON, MO. 63366
 SANITARY SEWER PLAN INDEX

planning • engineering • surveying • landscape architecture
Cole
 and ASSOCIATES
 INCORPORATED
 10777 sunset office dr.
 saint louis, missouri 63127
 p. 314 984 9887 f. 314 984 0587

DESIGNED BY: JKW
 DRAWN BY: JKW
 CHECKED BY: JFH
 DATE: 4/9/08
 Job Number: 08-0033
 Sheet Number: C5.3