

GEORGE M. STOCK E-25116
Civil Engineer

STOCK & ASSOCIATES
CONSULTING ENGINEERS, INC.

425 NORTH NEW BALLAS ROAD
SUITE 165
ST. LOUIS, MO. 63141
PH (314) 432-5100
FAX (314) 432-8171
e-mail: general@stockassoc.com

- Architect
- Structural Engineer
- Fire Protection Engineer
- Plumbing Engineer
- Mechanical Engineer
- Electrical Engineer



CLAYCO CONSTRUCTION COMPANY
2199 Innerbelt Business Center Dr.
St. Louis, MO 63114
Ph 314.429.5100 Fx 314.429.3165



TRISTAR BUSINESS COMMUNITIES
13397 Lakefront Drive
St. Louis, MO 63045
Ph 314.291.0814

Progress Point

O'Fallon, MO


Rev. No.	Description	Date
1	ISSUED	11-05-01
2	CITY & DUCKETT CREEK	12-28-01
3	CITY & DUCKETT CREEK	02-08-02
4	CITY COMMENTS	03-18-02
5	CITY COMMENTS	04-18-02
6	CITY COMMENTS	04-18-02
7	REV. CNSTR. SEQUENCE	05-23-02
8	CITY COMMENTS	07-15-02
9	FIELD COORD.	07-23-02
10	NEW LIGHTING PLAN	08-02-02

The Professional Engineer's seal affixed to this sheet indicates that the normal Engineer has prepared or directed the preparation of the material shown only on this sheet. Other drawings and documents not exhibiting this seal shall not be considered prepared by or the responsibility of the undersigned.

Drawing Title
OVERALL SITE PLAN

Drawing No.
C5

Scale 1"=150'
Dwg By: PKB
Checked: 1-101-031
Date: 200-2180.2

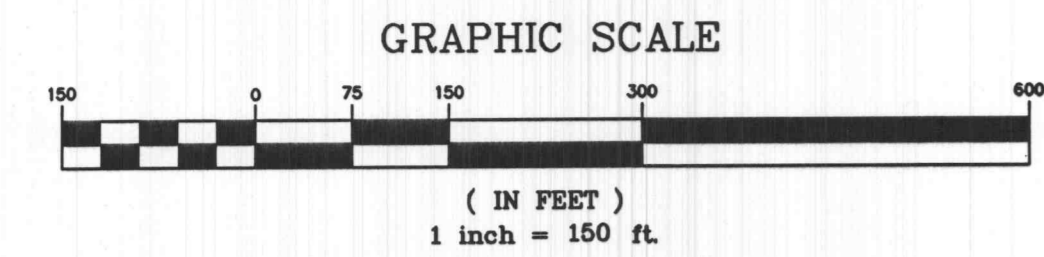

F:\D:\aw-12k\1paw2\001\PLANS\005-09\FALL.dwg Tue Nov 19 08:29:29 2002 Jroth Stock & Assoc.