


Numeric Summary							
Project: All Projects							
Label	CalcType	Units	Avg	Max	Min	Avg/Min	Max/Min
PARKING LOT	Illuminance	Fc	2.14	8.1	0.2	10.70	40.50
SPILL LIGHT	Illuminance	Fc	0.07	1.0	0.0	0.00	0.00

Luminaire Schedule						
Project: All Projects						
Symbol	Qty	Label	Arrangement	Lumens	LLF	Description
□	3	A	SINGLE	36000	1.000	ICM-400-MH-MT-SL

FIXTURES MOUNTED AT 20'

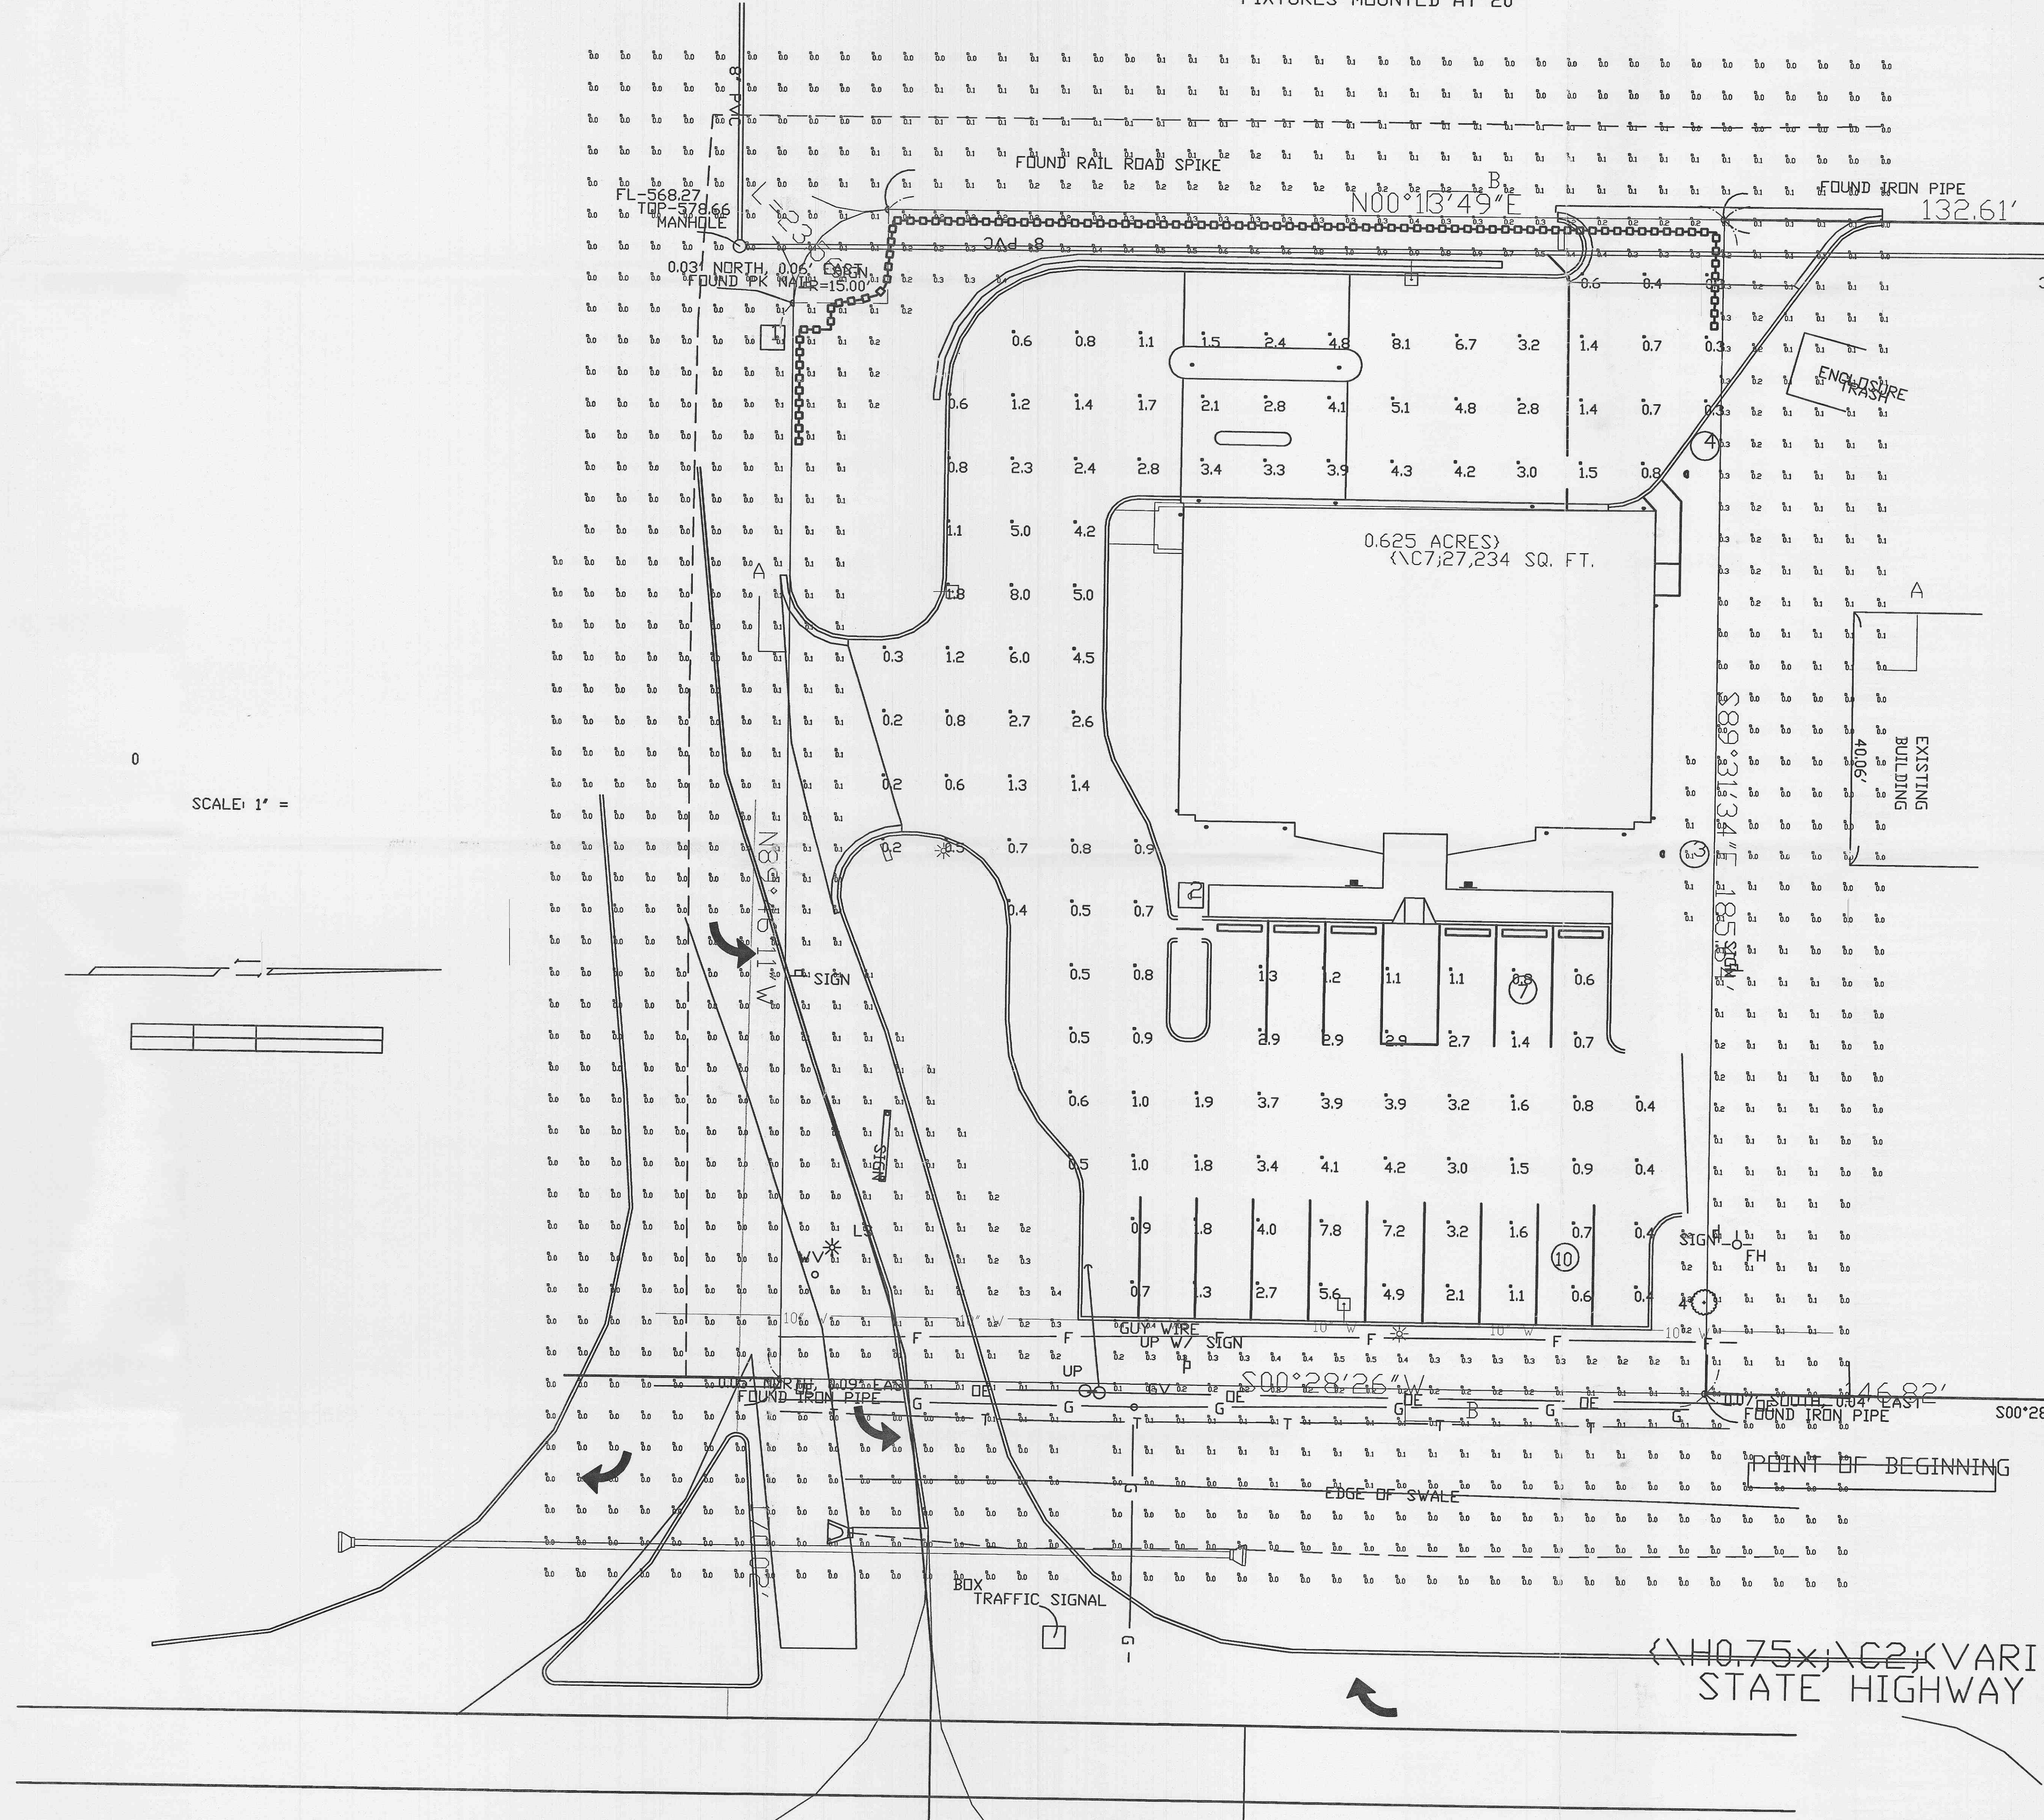

SCALE: 1" =

PHOTOMETRICS PLAN
SCALE: 1" = 10'

Chadwin
ARCHITECTURE / INTERIOR DESIGN / GRAPHICS
700 Corporate Park Drive / Suite 225 / St. Louis, Missouri 63105
314.752.5527 / Fax: 314.752.5541

THE ARCHITECT EXPRESSLY RESERVES HIS COMMON LAW AND STATUTORY LAW COPYRIGHTS AND OTHER PROPERTY RIGHTS FOR THESE "ARCHITECTURAL WORKS" AND "TECHNICAL DOCUMENTS" AND ANY DERIVATIVES THEREOF. THESE DRAWINGS AND DOCUMENTS ARE NOT TO BE REPRODUCED, CHANGED OR COPIED IN ANY FORM OR MANNER WHATSOEVER FOR ANY USE WITHOUT FIRST OBTAINING THE EXPRESS WRITTEN CONSENT OF LOUIS E. CHADWIN, CHADWIN ASSOCIATES, AND ARE TO BE ASSIGNED TO ANY PARTY WITHOUT FIRST OBTAINING WRITTEN PERMISSION AND CONSENT.

© COPYRIGHT FEEBING

RELIANCE BANK
MISSOURI STATE HIGHWAY K & WOODCREST BOULEVARD
CITY OF FALLON
ST. CHARLES COUNTY, MISSOURI

REVISIONS:

STATE OF MISSOURI
LOUIS E. CHADWIN
REGISTERED ARCHITECT

PROJECT: 2003.034
DATE: 06.17.04
DRAWN:

SUBMITTAL - 06.17.04 - NOT FOR CONSTRUCTION