

NOTES:


1. FOR SYMBOLS, ABBREVIATIONS AND GENERAL NOTES, SEE DRAWING E001.
2. FOR EXACT LOCATION OF INTERIOR AND EXTERIOR WALL MOUNTED FIXTURES, SEE BUILDING SECTIONS AND ELEVATIONS ON ARCHITECTURAL DRAWINGS.
3. FURNISH AND INSTALL COLUMN CHASE AT EXPOSED COLUMN. SEE ARCHITECTURAL DRAWINGS FOR LOCATION AND LENGTH OF CHASE. FLUSH MOUNT BOX FOR DEVICE OR FIXTURE IN CONCH OF COLUMN CHASE AT INDICATED MOUNTING HEIGHTS. ROUTE CONDUIT CONCEALED INSIDE CHASE, DOWN INSIDE BLOCK WALL AND UNDERNEATH FLOOR SLAB TO RESPECTIVE DESTINATION.
4. ROUTE CONDUIT FOR TYPE "G" FIXTURES ALONG ROOF DECK AND TURN DOWN INTO CHASE ON NORTH SIDE OF ELEVATOR TO RESPECTIVE DESTINATION. MOUNT REMOTE BALLAST AT ROOF DECK AND PAINT TO MATCH ADJACENT FINISHES.
5. 277V LIGHTING CIRCUITS IN GYMNASIUM ARE FED FROM PANEL LP21 LOCATED ON MEZZANINE LEVEL IN WORKROOM 204. SEE PARTIAL MEZZANINE LEVEL LIGHTING PLAN, THIS DRAWING, FOR HOMERUNS.
6. EXTENT OF ALTERNATE ELECTRICAL WORK IS DEPICTED BY DIVISION LINE. WORK ON "BACK" SIDE OF LINE IS SHOWN ON DRAWING INDICATED. ELECTRICAL WORK FOR ALTERNATE IS SHOWN ON THIS DRAWING ON "ALTERNATE" SIDE OF LINE.
7. FURNISH LAST TWO ROWS OF TYPE "G" FIXTURES IN GYMNASIUM WITH 3'-0" STEMS.

Revision	Date	By	Description
1	12/9/02	DAM	ISSUED FOR BID




12/13/2002


RENAUD SPIRIT CENTER
For the City of O'Fallon - Missouri

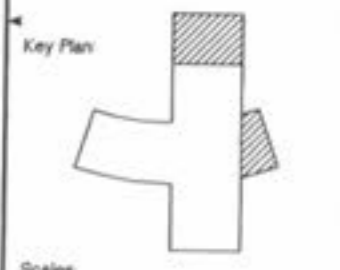

Jacobs Project No: F0W43600
Drawing Title: ELECTRICAL ALTERNATE FIRST FLOOR AND MEZZANINE LEVEL LIGHTING PLANS
Date: DECEMBER 9, 2002
Designed By: D. MENINGER | Drawing No:
Drawn By: D. MENINGER | Drawing No:
Checked By: D. GIBSON | Drawing No: E301.A

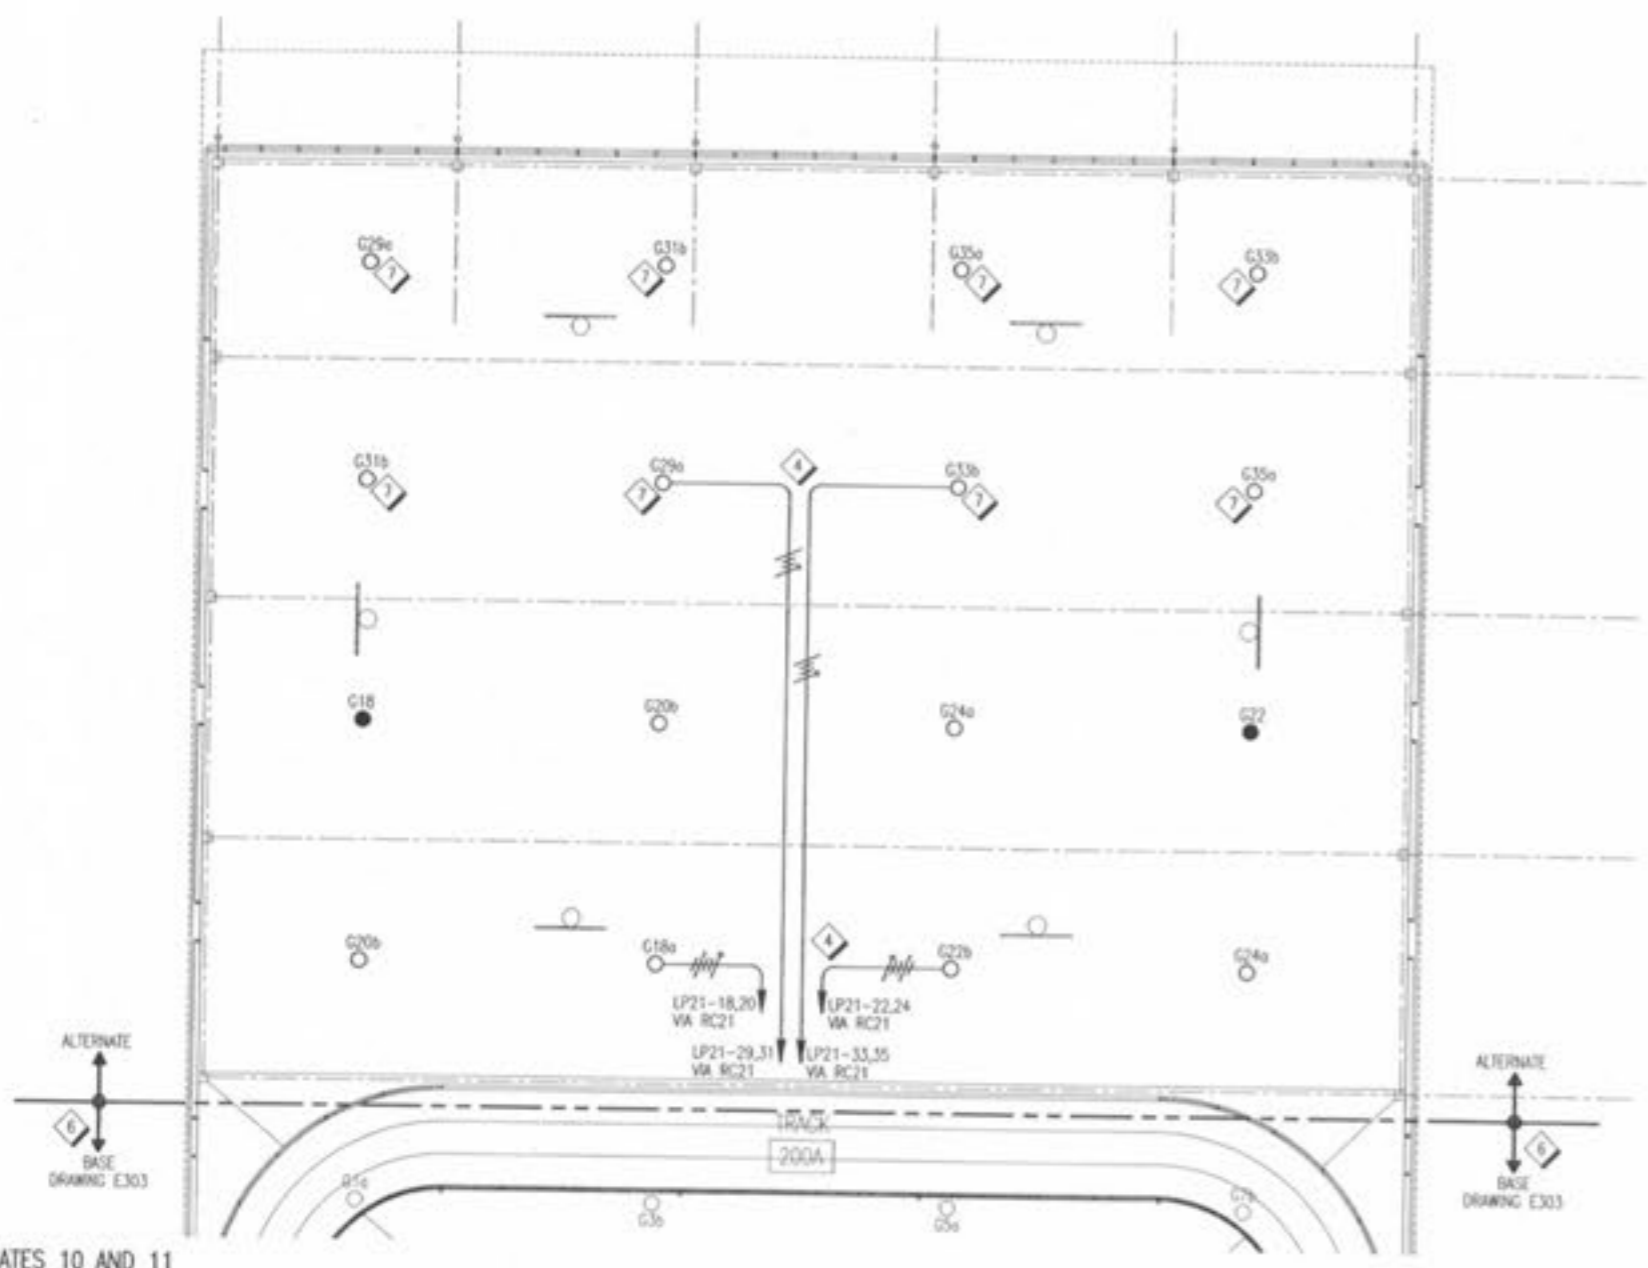

ALTERNATES 10 AND 11
C1 PARTIAL MEZZANINE LEVEL LIGHTING PLAN
E301.A 1/8" = 1'-0"

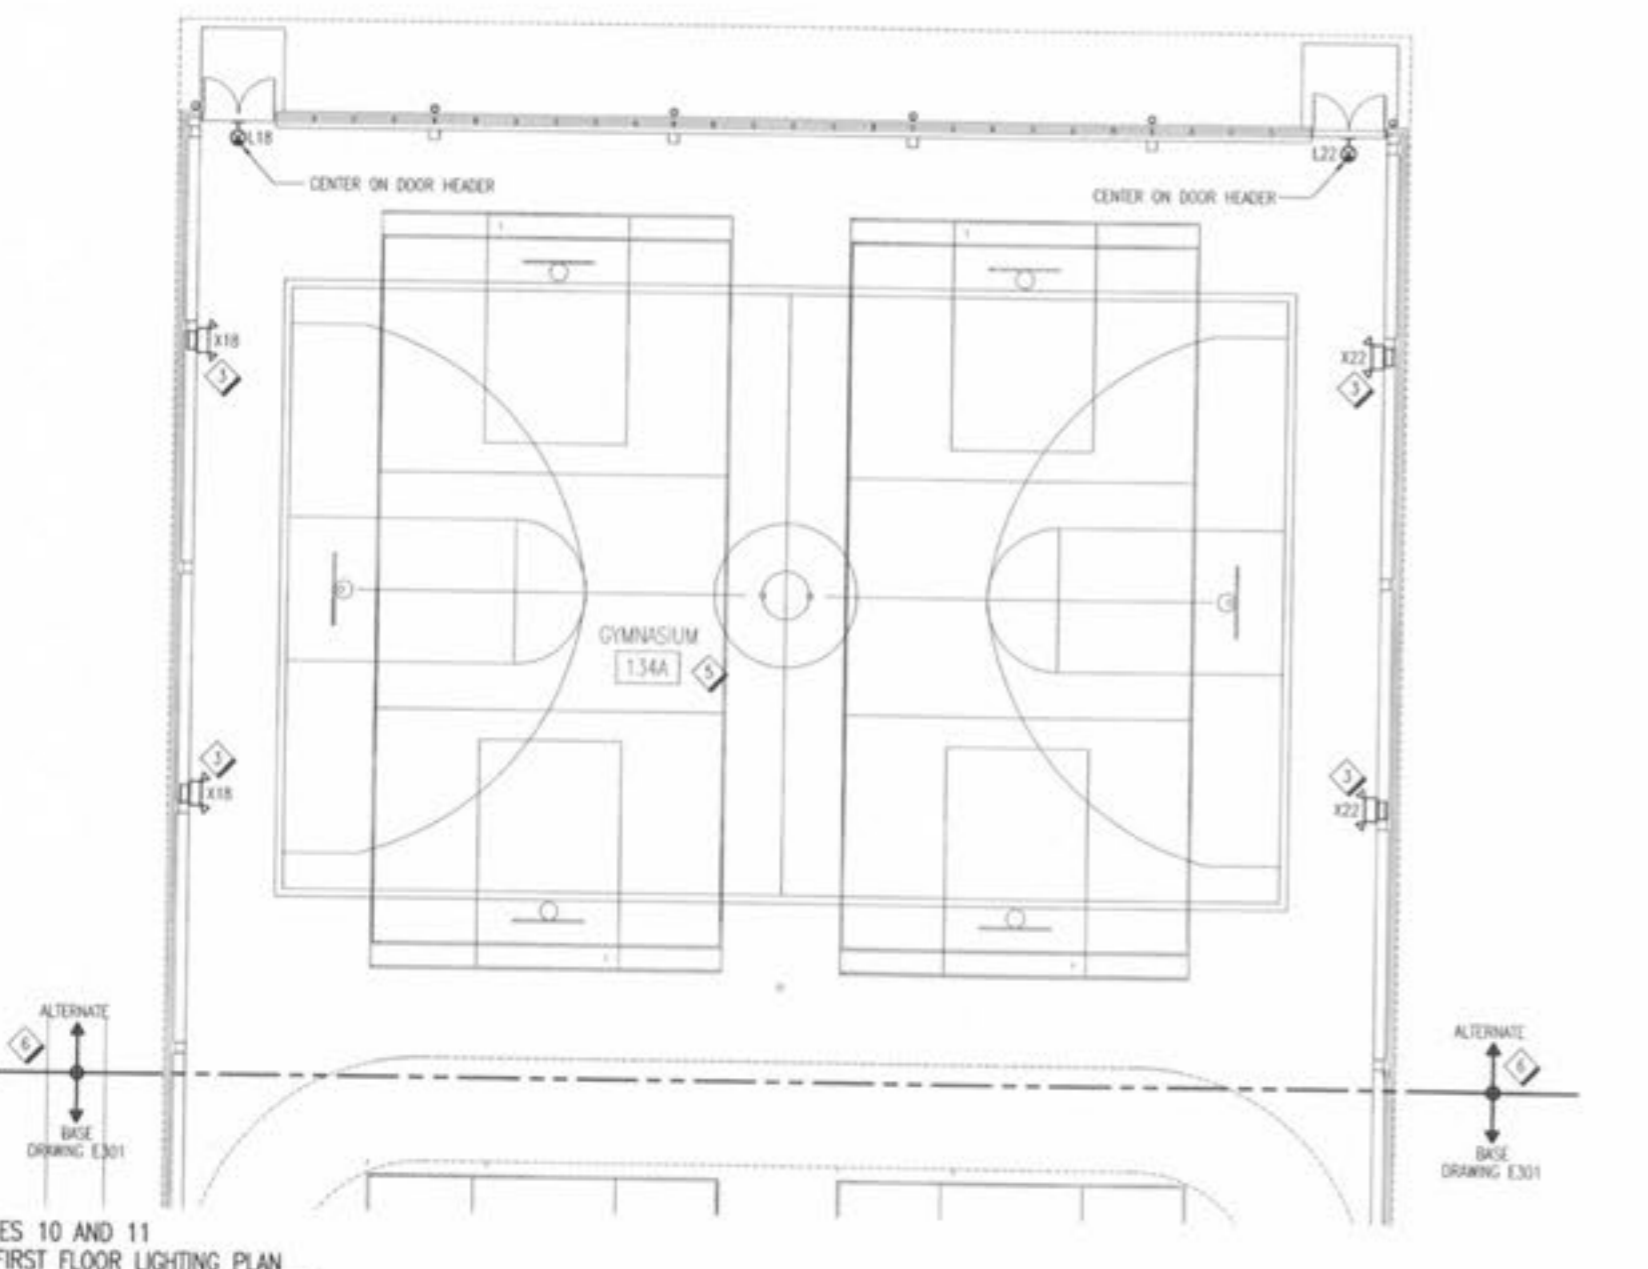

ALTERNATES 10 AND 11
A1 PARTIAL FIRST FLOOR LIGHTING PLAN
E301.A 1/8" = 1'-0"



ALTERNATE 11
A4 PARTIAL MEZZANINE LEVEL LIGHTING PLAN
E301.A 1/8" = 1'-0"