

NOTES:


1. FOR SYMBOLS, ABBREVIATIONS AND GENERAL NOTES, SEE DRAWING E001.
2. FOR EXACT LOCATION OF INTERIOR AND EXTERIOR WALL MOUNTED FIXTURES, SEE BUILDING SECTIONS AND ELEVATIONS ON ARCHITECTURAL DRAWINGS.
3. 277V LIGHTING CIRCUITS IN NATATORIUM ARE FED FROM PANEL LP21 LOCATED ON MEZZANINE LEVEL IN MECH ROOM 204. SEE DRAWING E304 FOR HOMERUNS NOT SHOWN ON THIS DRAWING.
4. FURNISH AND INSTALL COLUMN CHASE AT EXPOSED COLUMN. SEE ARCHITECTURAL DRAWINGS FOR LOCATION AND LENGTH OF CHASE. FLUSH MOUNT BOX FOR DEVICE OR FIXTURE IN COVER OF COLUMN CHASE AT INDICATED MOUNTING HEIGHTS. ROUTE CONDUIT CONCEALED INSIDE CHASE, DOWN INSIDE BLOCK WALL AND UNDERNEATH FLOOR SLAB TO RESPECTIVE DESTINATION.
5. INSTALL AND CONNECT WET NICHE FIXTURES, SPECIFIED AND FURNISHED UNDER DIVISION 13, PER DETAIL D1 ON THIS DRAWING AND PER NEC ARTICLE 680 FOR POOL INSTALLATIONS. MAXIMUM WATTAPE 500W.

Revision
 Date: 12/9/02
 Description: DAM ISSUED FOR BID



12/13/2002

RENAUD SPIRIT CENTER
 For the City of O'Fallon - Missouri

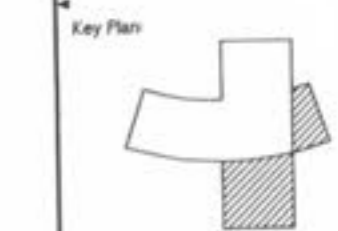


Scale
 0 1' 2' 3' 4' 5' 6' 7' 8' 9' 10' 11' 12'
 1/8" = 1'-0"

Jacobs Project No: F0W43600
 Drawing Title: ELECTRICAL FIRST FLOOR SOUTH-EAST LIGHTING PLAN
 Date: DECEMBER 9, 2002
 Designed By: S. WENIGER | Drawing No:
 Drawn By: S. WENIGER | Checked By: F. HERRIT | E302



D1 WET NICHE FIXTURE MOUNTING DETAIL
 E302 SCALE: NONE

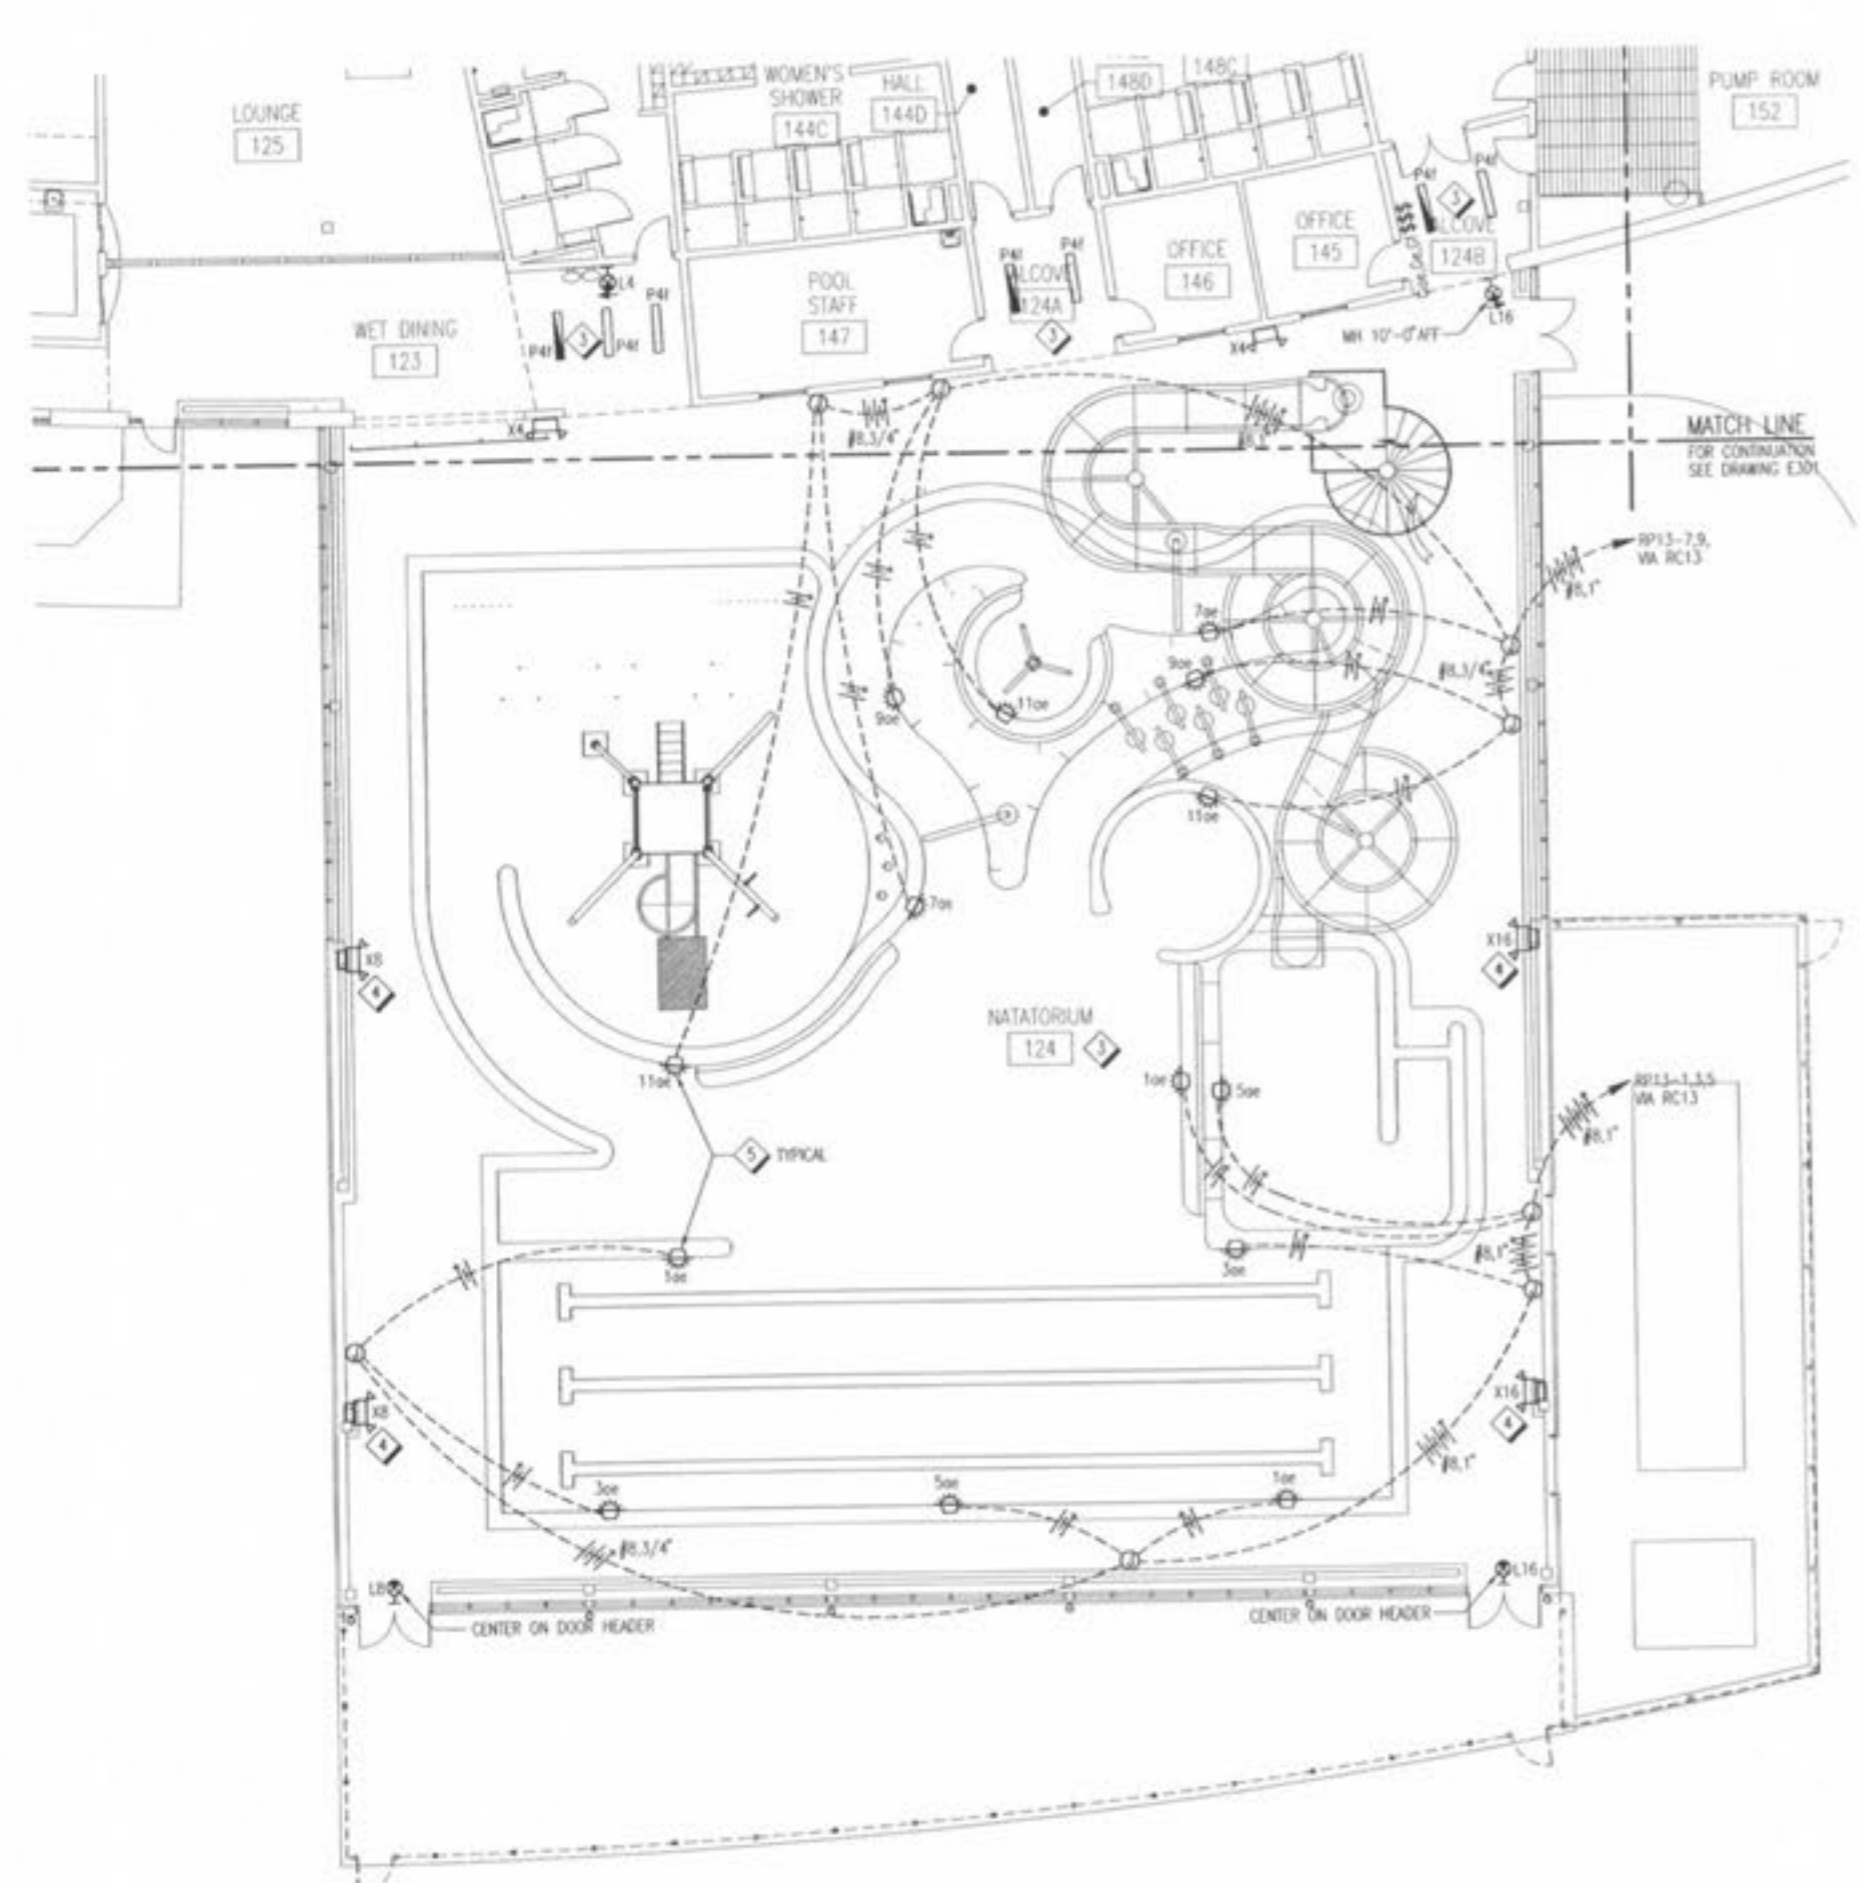

A1 FIRST FLOOR SOUTH LIGHTING PLAN
 E302 1/8" = 1'-0"



A4 FIRST FLOOR EAST LIGHTING PLAN
 E302 1/8" = 1'-0"