


- NOTES:**
1. FOR SYMBOLS, ABBREVIATIONS AND GENERAL NOTES, SEE DRAWING E301.
 2. FOR EXACT LOCATION OF INTERIOR AND EXTERIOR WALL MOUNTED FIXTURES, SEE BUILDING SECTIONS AND ELEVATIONS ON ARCHITECTURAL DRAWINGS.
 3. FURNISH AND INSTALL COLUMN CHASE AT EXPOSED COLUMN. SEE ARCHITECTURAL DRAWINGS FOR LOCATION AND LENGTH OF CHASE. FLOOR MOUNT BOX FOR DEVICE OR FIXTURE IN COVER OF COLUMN CHASE AT INDICATED MOUNTING HEIGHTS. ROUTE CONDUIT CONCEALED INSIDE CHASE, DOWN INSIDE BLOCK WALL AND UNDERNEATH FLOOR SLAB TO RESPECTIVE DESTINATION.
 4. ROUTE CONDUIT FOR TYPE "U" FIXTURES ALONG ROOF DECK AND TURN DOWN INTO CHASE ON NORTH SIDE OF ELEVATOR TO RESPECTIVE DESTINATION. MOUNT REMOTE BALLAST AT ROOF DECK AND PAINT TO MATCH ADJACENT FINISHES.

Revision	Date	Description
1	12/9/02	ISSUED FOR BID




12.13.2002

RENAUD SPIRIT CENTER
For the City of O'Fallon - Missouri

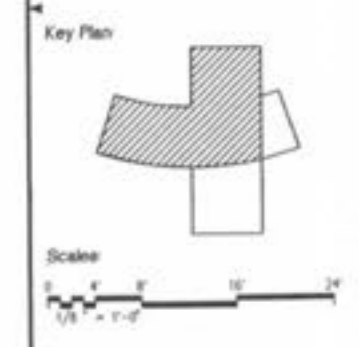

Jacobs Project No: F0W4000
Drawing Title: ELECTRICAL MEZZANINE LEVEL NORTH-WEST LIGHTING PLAN
Date: DECEMBER 9, 2002
Designed By: D. WISNIEWSKI | Drawing No:
Drawn By: D. WISNIEWSKI
Checked By: T. HESTER | **E303**

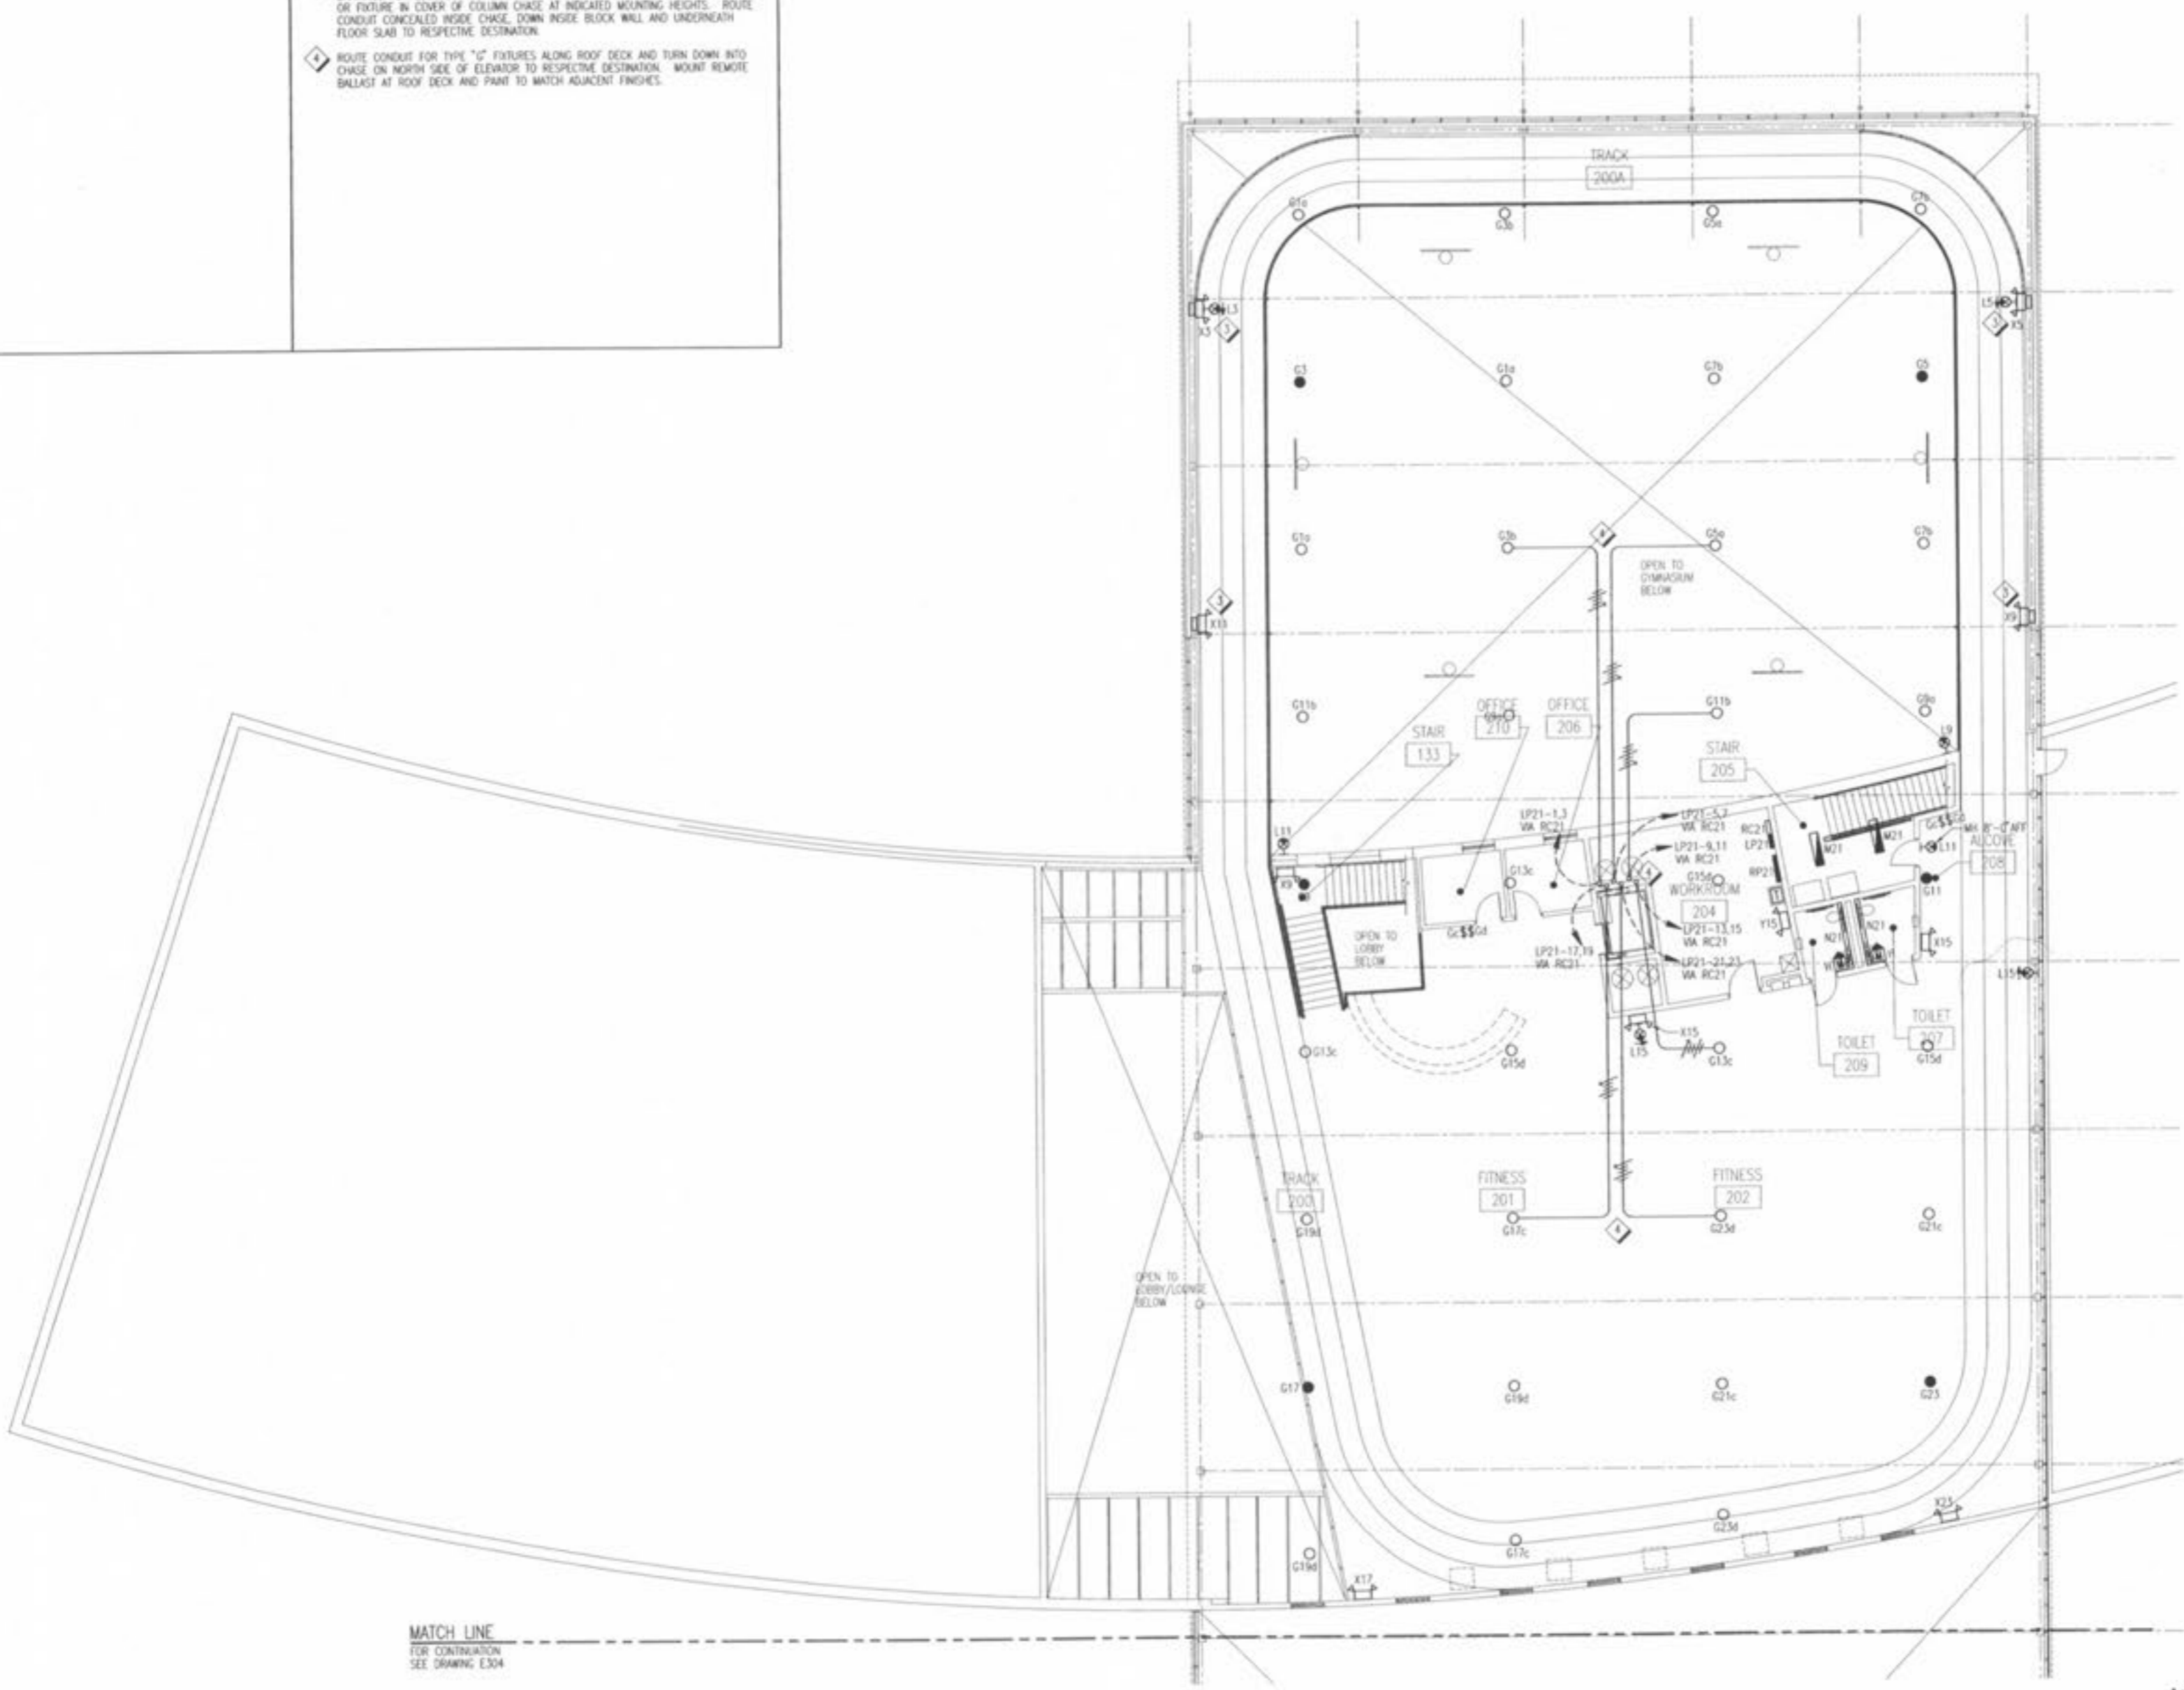

MATCH LINE
FOR CONTINUATION
SEE DRAWING E304