

NOTES:

1. FOR SYMBOLS, ABBREVIATIONS AND GENERAL NOTES, SEE DRAWING E001.
2. FOR EXACT LOCATION OF INTERIOR AND EXTERIOR WALL MOUNTED FIXTURES, SEE BUILDING SECTIONS AND ELEVATIONS ON ARCHITECTURAL DRAWINGS.
3. CONNECT ONE LAMP AND BALLAST IN EACH TYPE "C" FIXTURE TO ONE OF INDICATED CONTROL ZONES, AND CONNECT REMAINING LAMP AND BALLAST TO OTHER CONTROL ZONE, OR IF DESIGNATED AS NIGHT LIGHT, CONNECT REMAINING LAMP AND BALLAST TO UNWITCHED LEG.
4. WHERE CONDUIT CANNOT BE CONCEALED, PROVIDE MANUFACTURED SURFACE RACEWAY, SUCH AS WIREMOLD, OR APPROVED EQUAL, AND ROUTE ALONG WINDOW FRAMING IN AS UNOBSPECIFIC AS POSSIBLE. FINISH OF PAINT EXPOSED RACEWAYS TO MATCH ADJACENT BUILDING CONSTRUCTION.

Revision	Date	By	Description
1	12/9/02	DAM	ISSUED FOR BID



12-13-2002

RENAUD SPIRIT CENTER
For the City of O'Fallon - Missouri



Key Plan




Jacobs Project No. F040600

Drawing Title
**ELECTRICAL
MEZZANINE LEVEL
SOUTH-EAST
LIGHTING PLAN**

Date: **DECEMBER 9, 2002**
Designed By: **D. WOODNER** Drawing No:
Drawn By: **D. WOODNER**
Checked By: **F. HERTZ**

E304

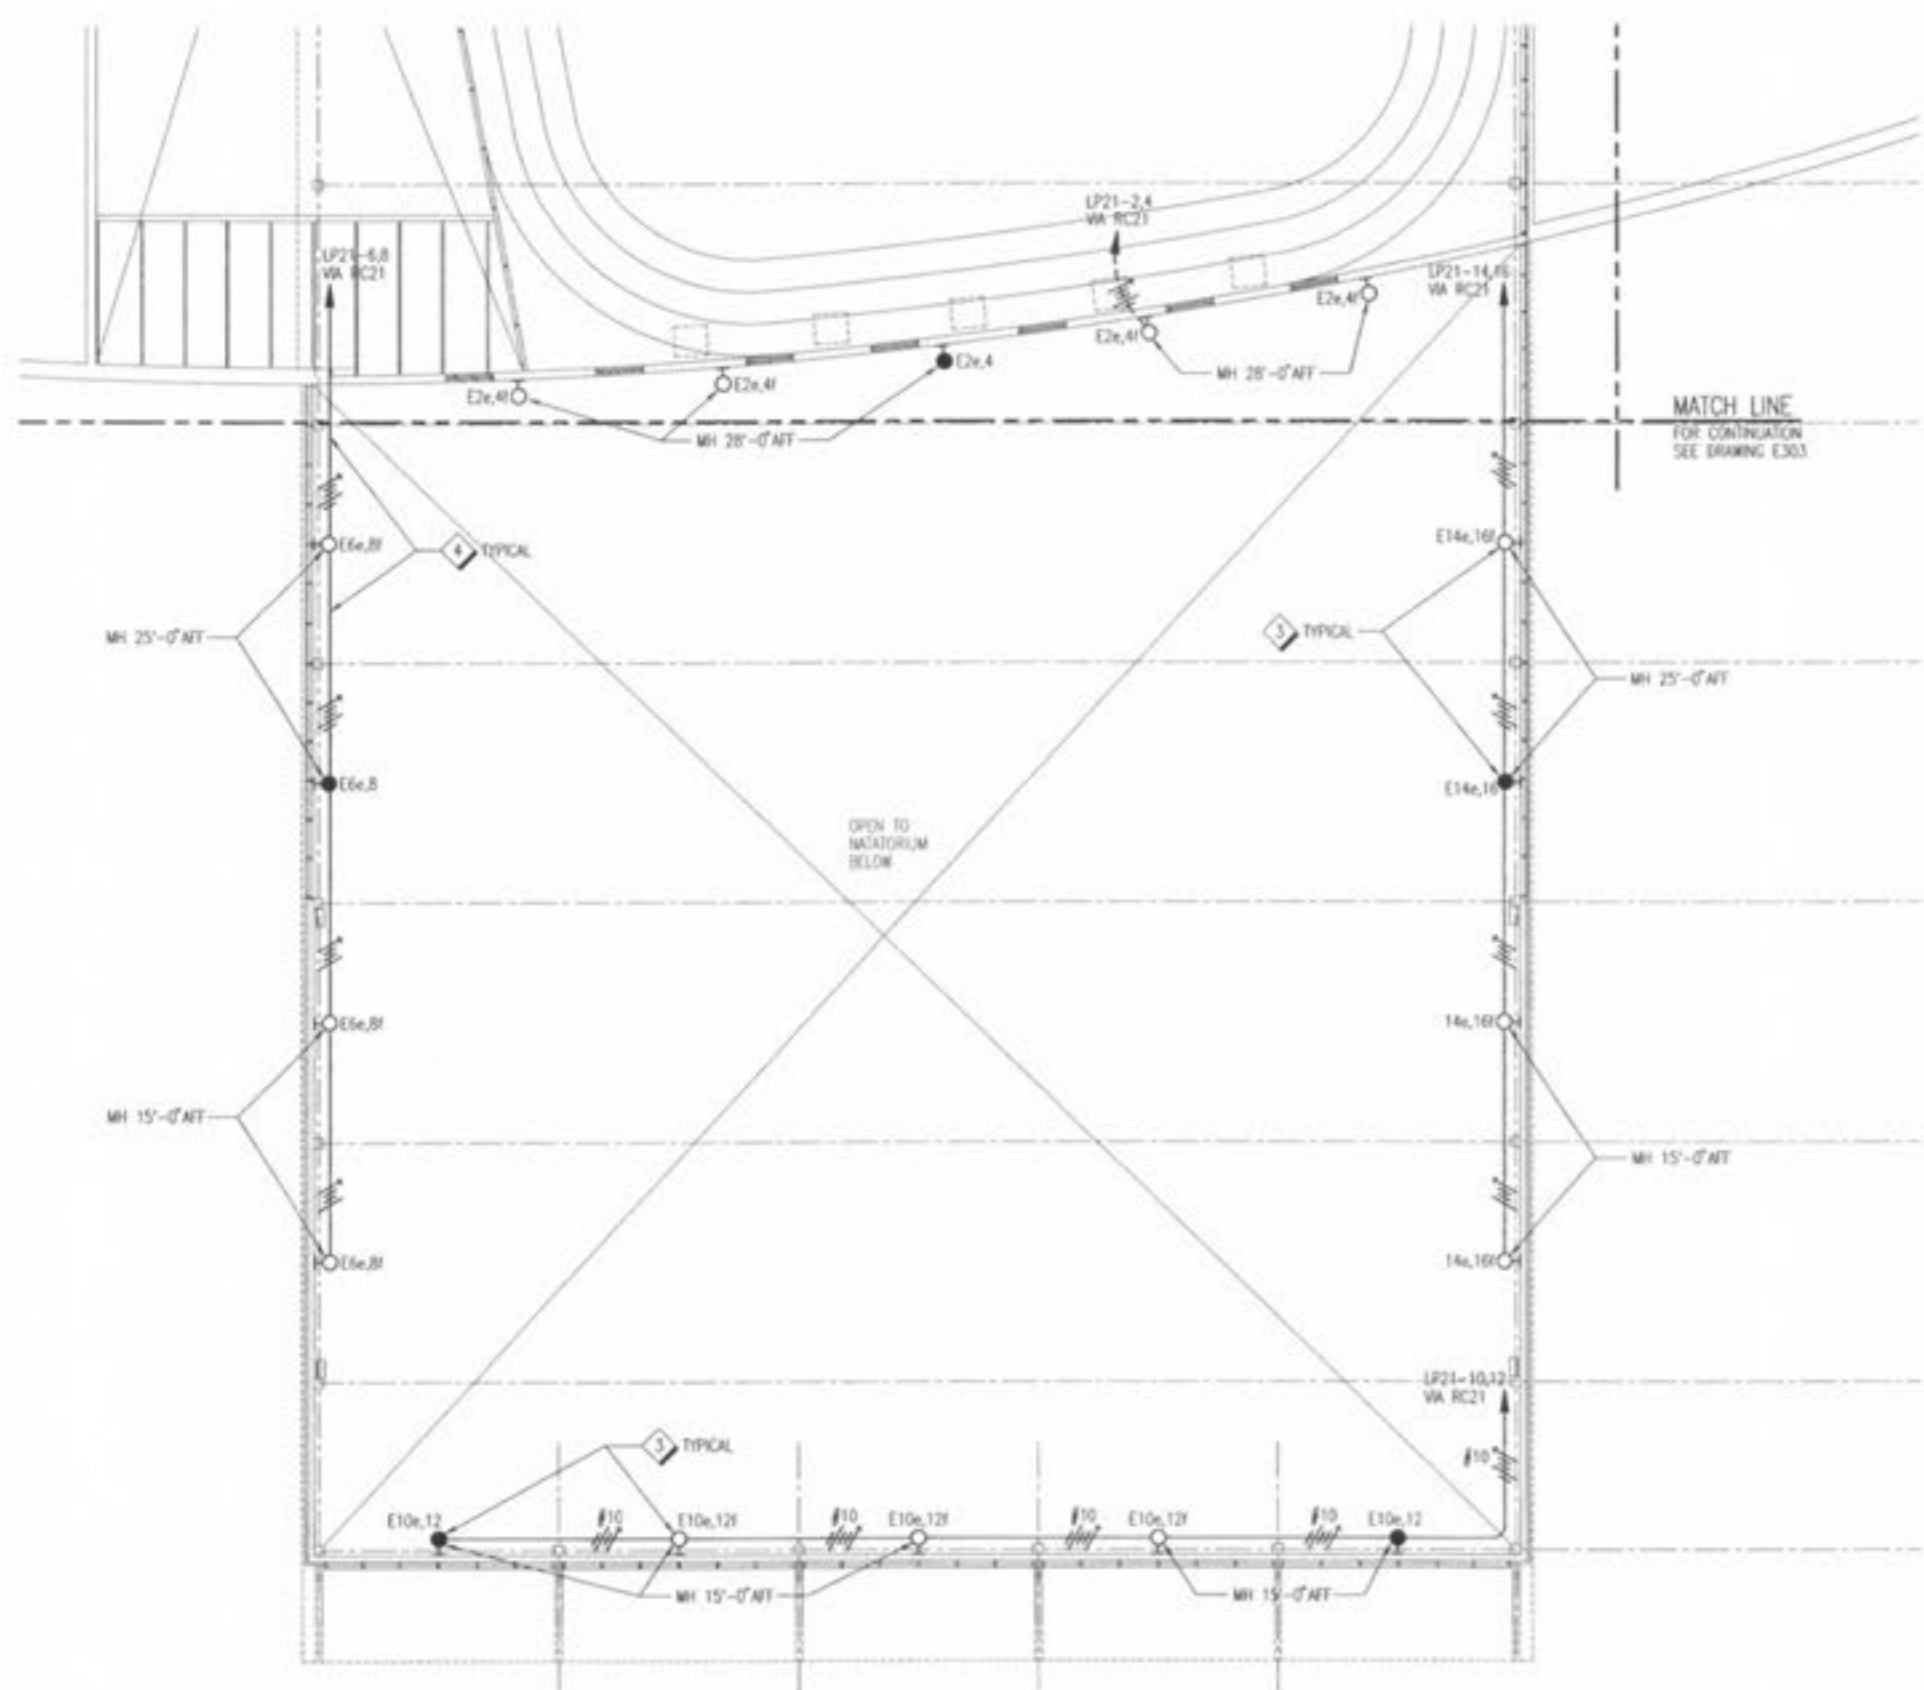

A1 MEZZANINE LEVEL SOUTH LIGHTING PLAN
E304 1/8" = 1'-0"

