



Revision
 Date: 12/9/02 Description: ISSUED FOR BID



RENAUD SPIRIT CENTER
 For the City of O'Fallon - Missouri




Key Plan

Scale

Jacobs Project No: F0842800

Drawing Title: POOL ELECTRICAL SITE PLAN

Date: DECEMBER 6, 2002
 Designed By: JH
 Drawn By: SS
 Checked By: JH
 Drawing No: SPE4.0

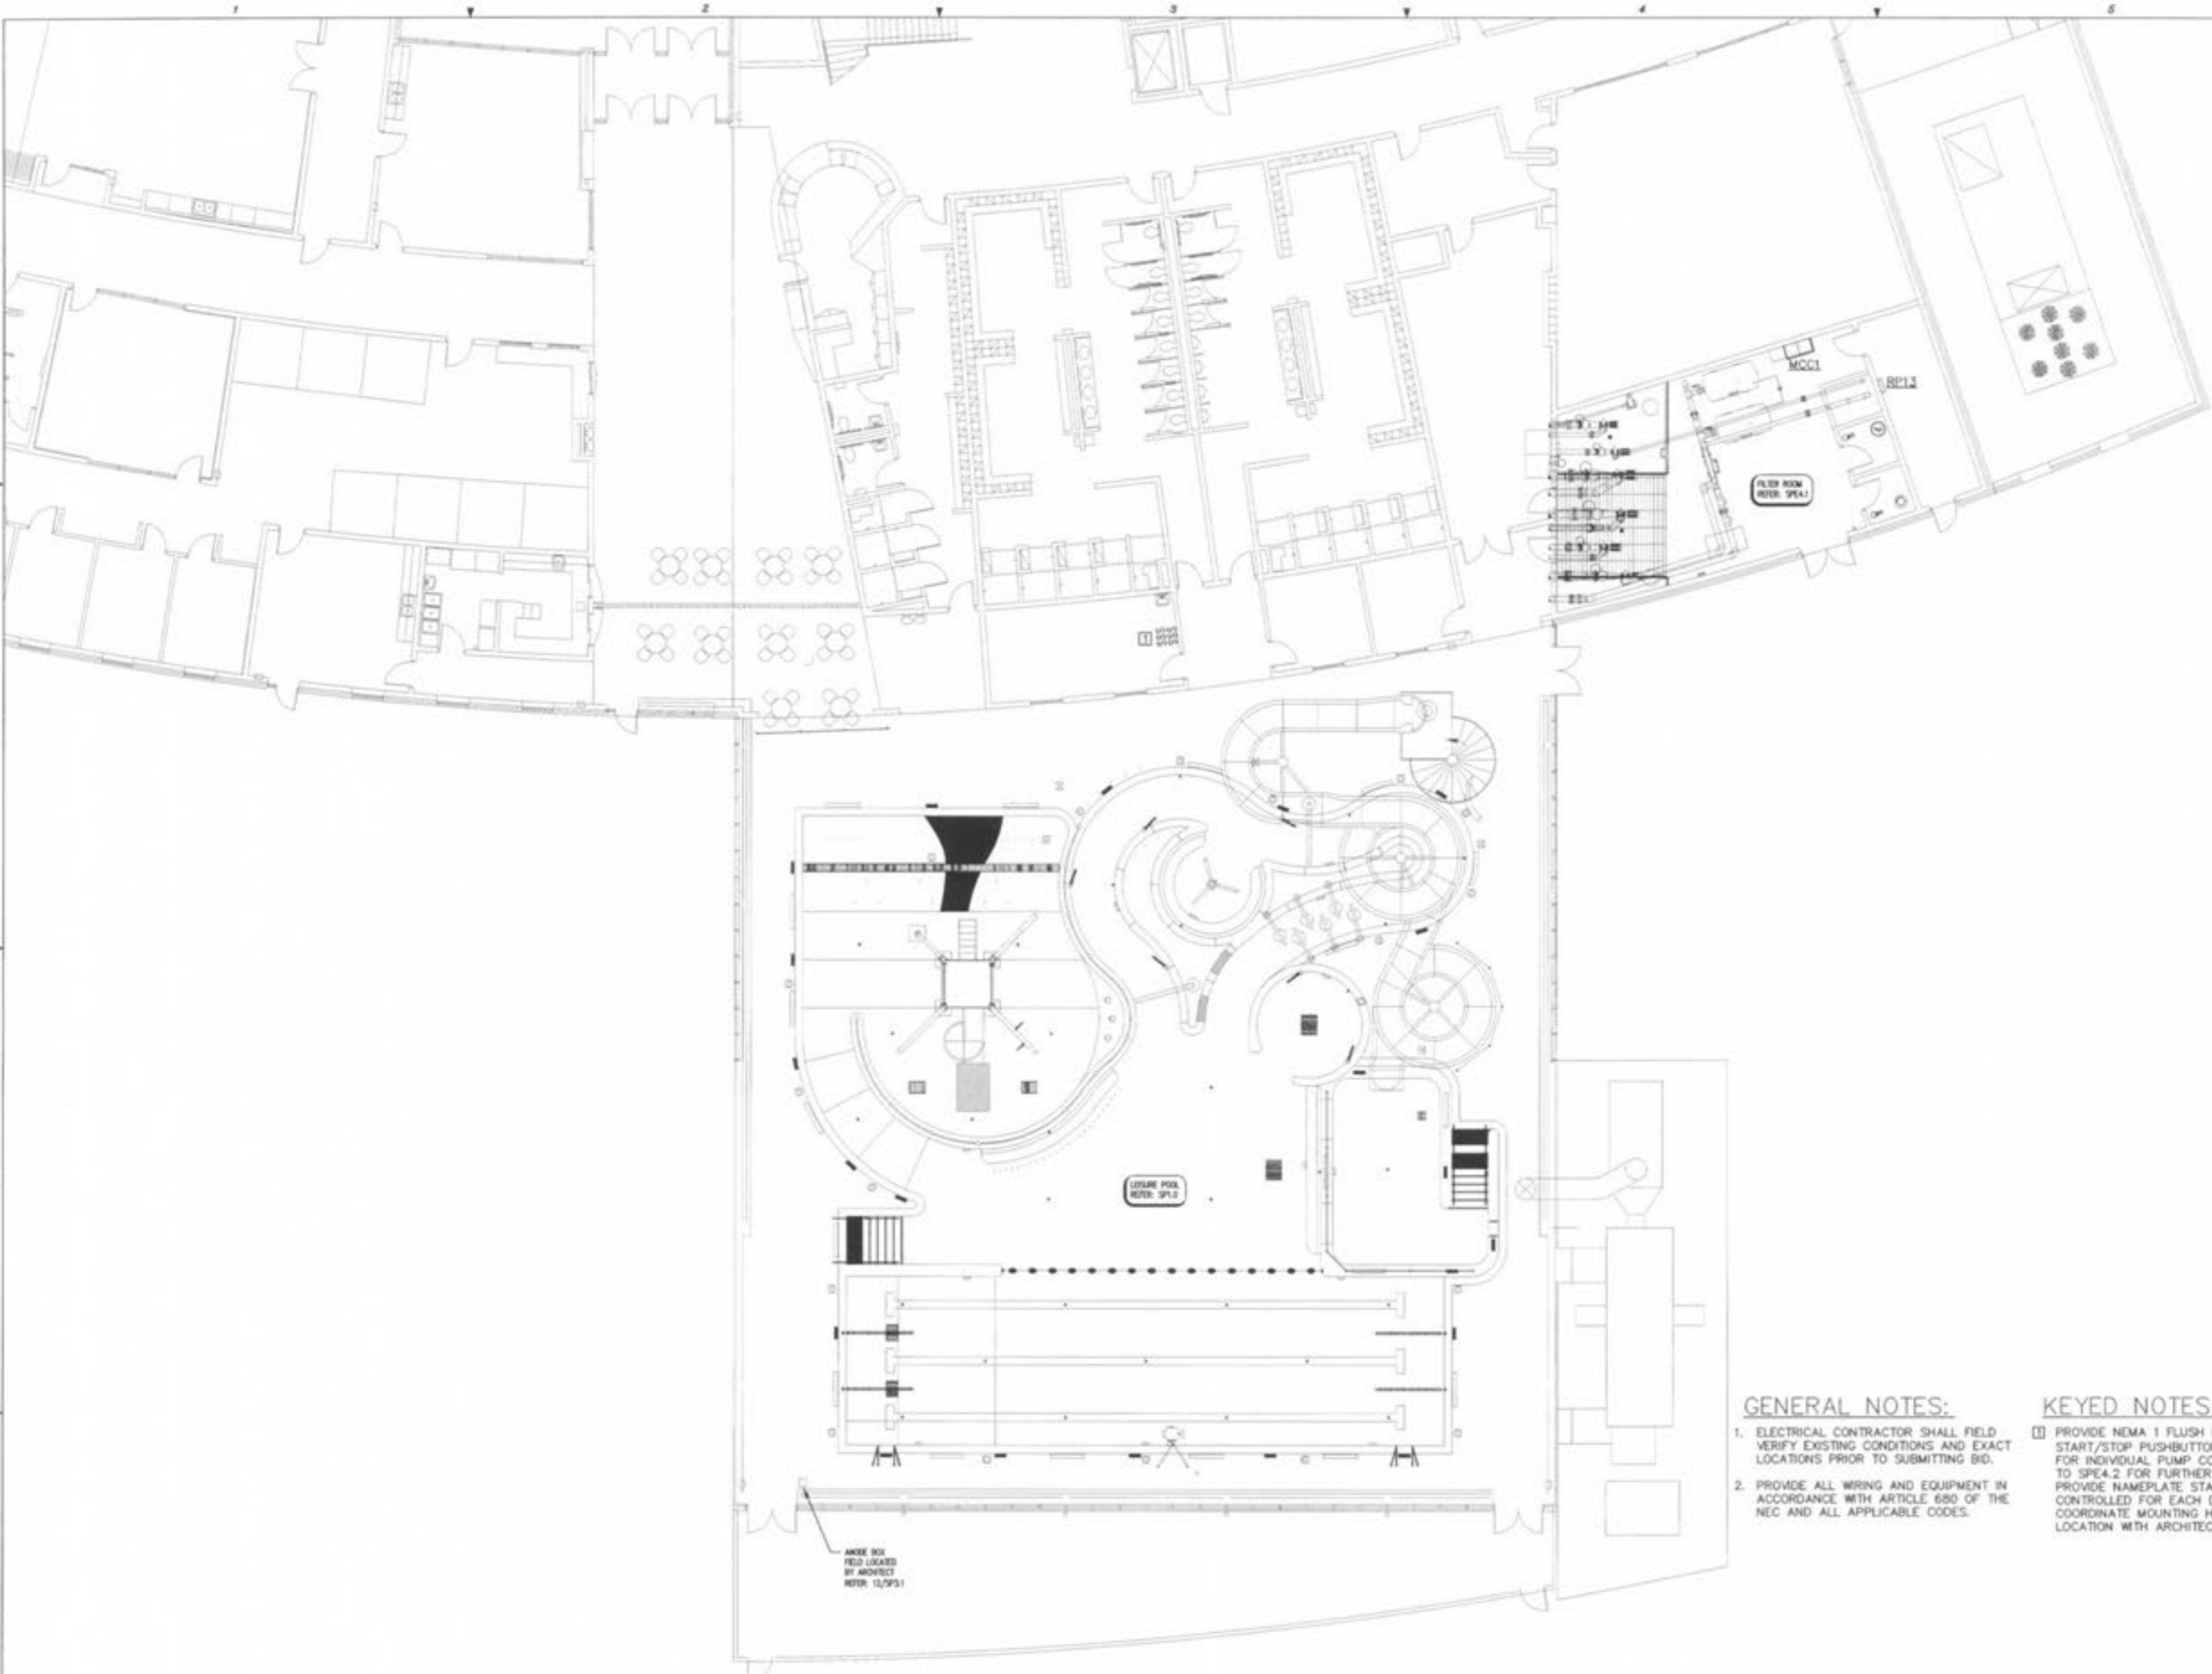

POOL ELECTRICAL SITE PLAN
 1/8" = 1'-0"

GENERAL NOTES:

1. ELECTRICAL CONTRACTOR SHALL FIELD VERIFY EXISTING CONDITIONS AND EXACT LOCATIONS PRIOR TO SUBMITTING BID.
2. PROVIDE ALL WIRING AND EQUIPMENT IN ACCORDANCE WITH ARTICLE 680 OF THE NEC AND ALL APPLICABLE CODES.

KEYED NOTES:

- PROVIDE NEMA 1 FLUSH MOUNTED START/STOP PUSHBUTTON PILOT DEVICES FOR INDIVIDUAL PUMP CONTROL. REFER TO SPE4.2 FOR FURTHER INFORMATION. PROVIDE NAMEPLATE STATING PUMP CONTROLLED FOR EACH DEVICE. COORDINATE MOUNTING HEIGHT AND LOCATION WITH ARCHITECT.

