
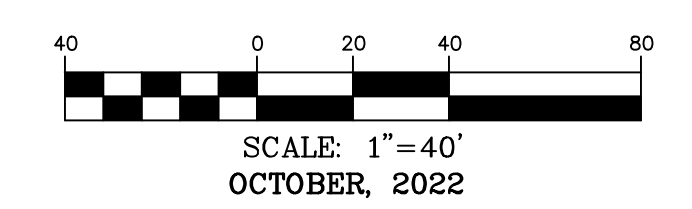


SITE LIGHTING PLAN

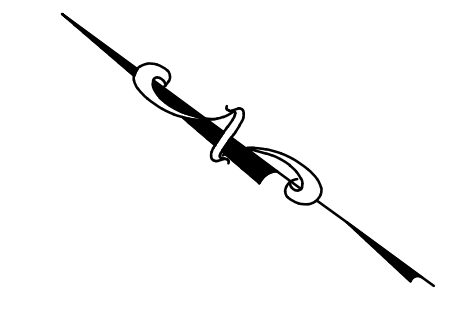

EXISTING		PROPOSED	
	PROPERTY LINE		PROPERTY LINE
	RIGHT-OF-WAY		RIGHT-OF-WAY
	LOT LINE		LOT LINE
	BUILDING SETBACK EASEMENT		BUILDING SETBACK EASEMENT
	AERIAL ELECTRIC		AERIAL ELECTRIC
	UTILITY POLE / GUY WIRE		UTILITY POLE / GUY WIRE
	SANITARY MANHOLE		SANITARY MANHOLE
	INLET		INLET
	GRATED INLET		GRATED INLET
	FIRE HYDRANTS		FIRE HYDRANTS
	STREET LIGHT		STREET LIGHT


636-584-0540 (tel.)
636-584-0512 (fax)
mailto:ochran@ochran.com

COCHRAN
Civil Engineering
Land Surveying
Architecture
Site Development
General Consulting
Master Planning

Missouri State Certificate of Authority Numbers:
Survey: 000380
Engineering: 001655
Architecture: 2002014240


Three working days prior to the start of any excavation, call 1-800-UGC-RTTE for utility location information.

All OSHA rules & regulations apply to these construction projects. Plans shall be strictly followed (ie. trenching, blasting, etc.)

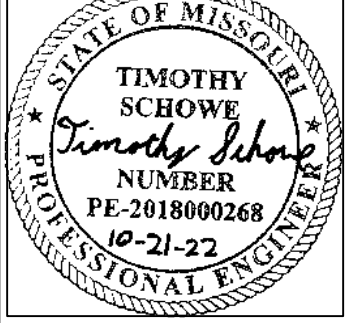

SITE IMPROVEMENTS
SSM HEALTH
O'FALLON, MISSOURI

DATE	BY	APP'D BY
	JMM	ERR
OCT. 21, 2022		
SCALE:		1"=40'
PROJ. NO.:		22-9120
DWG. NO.:		C4

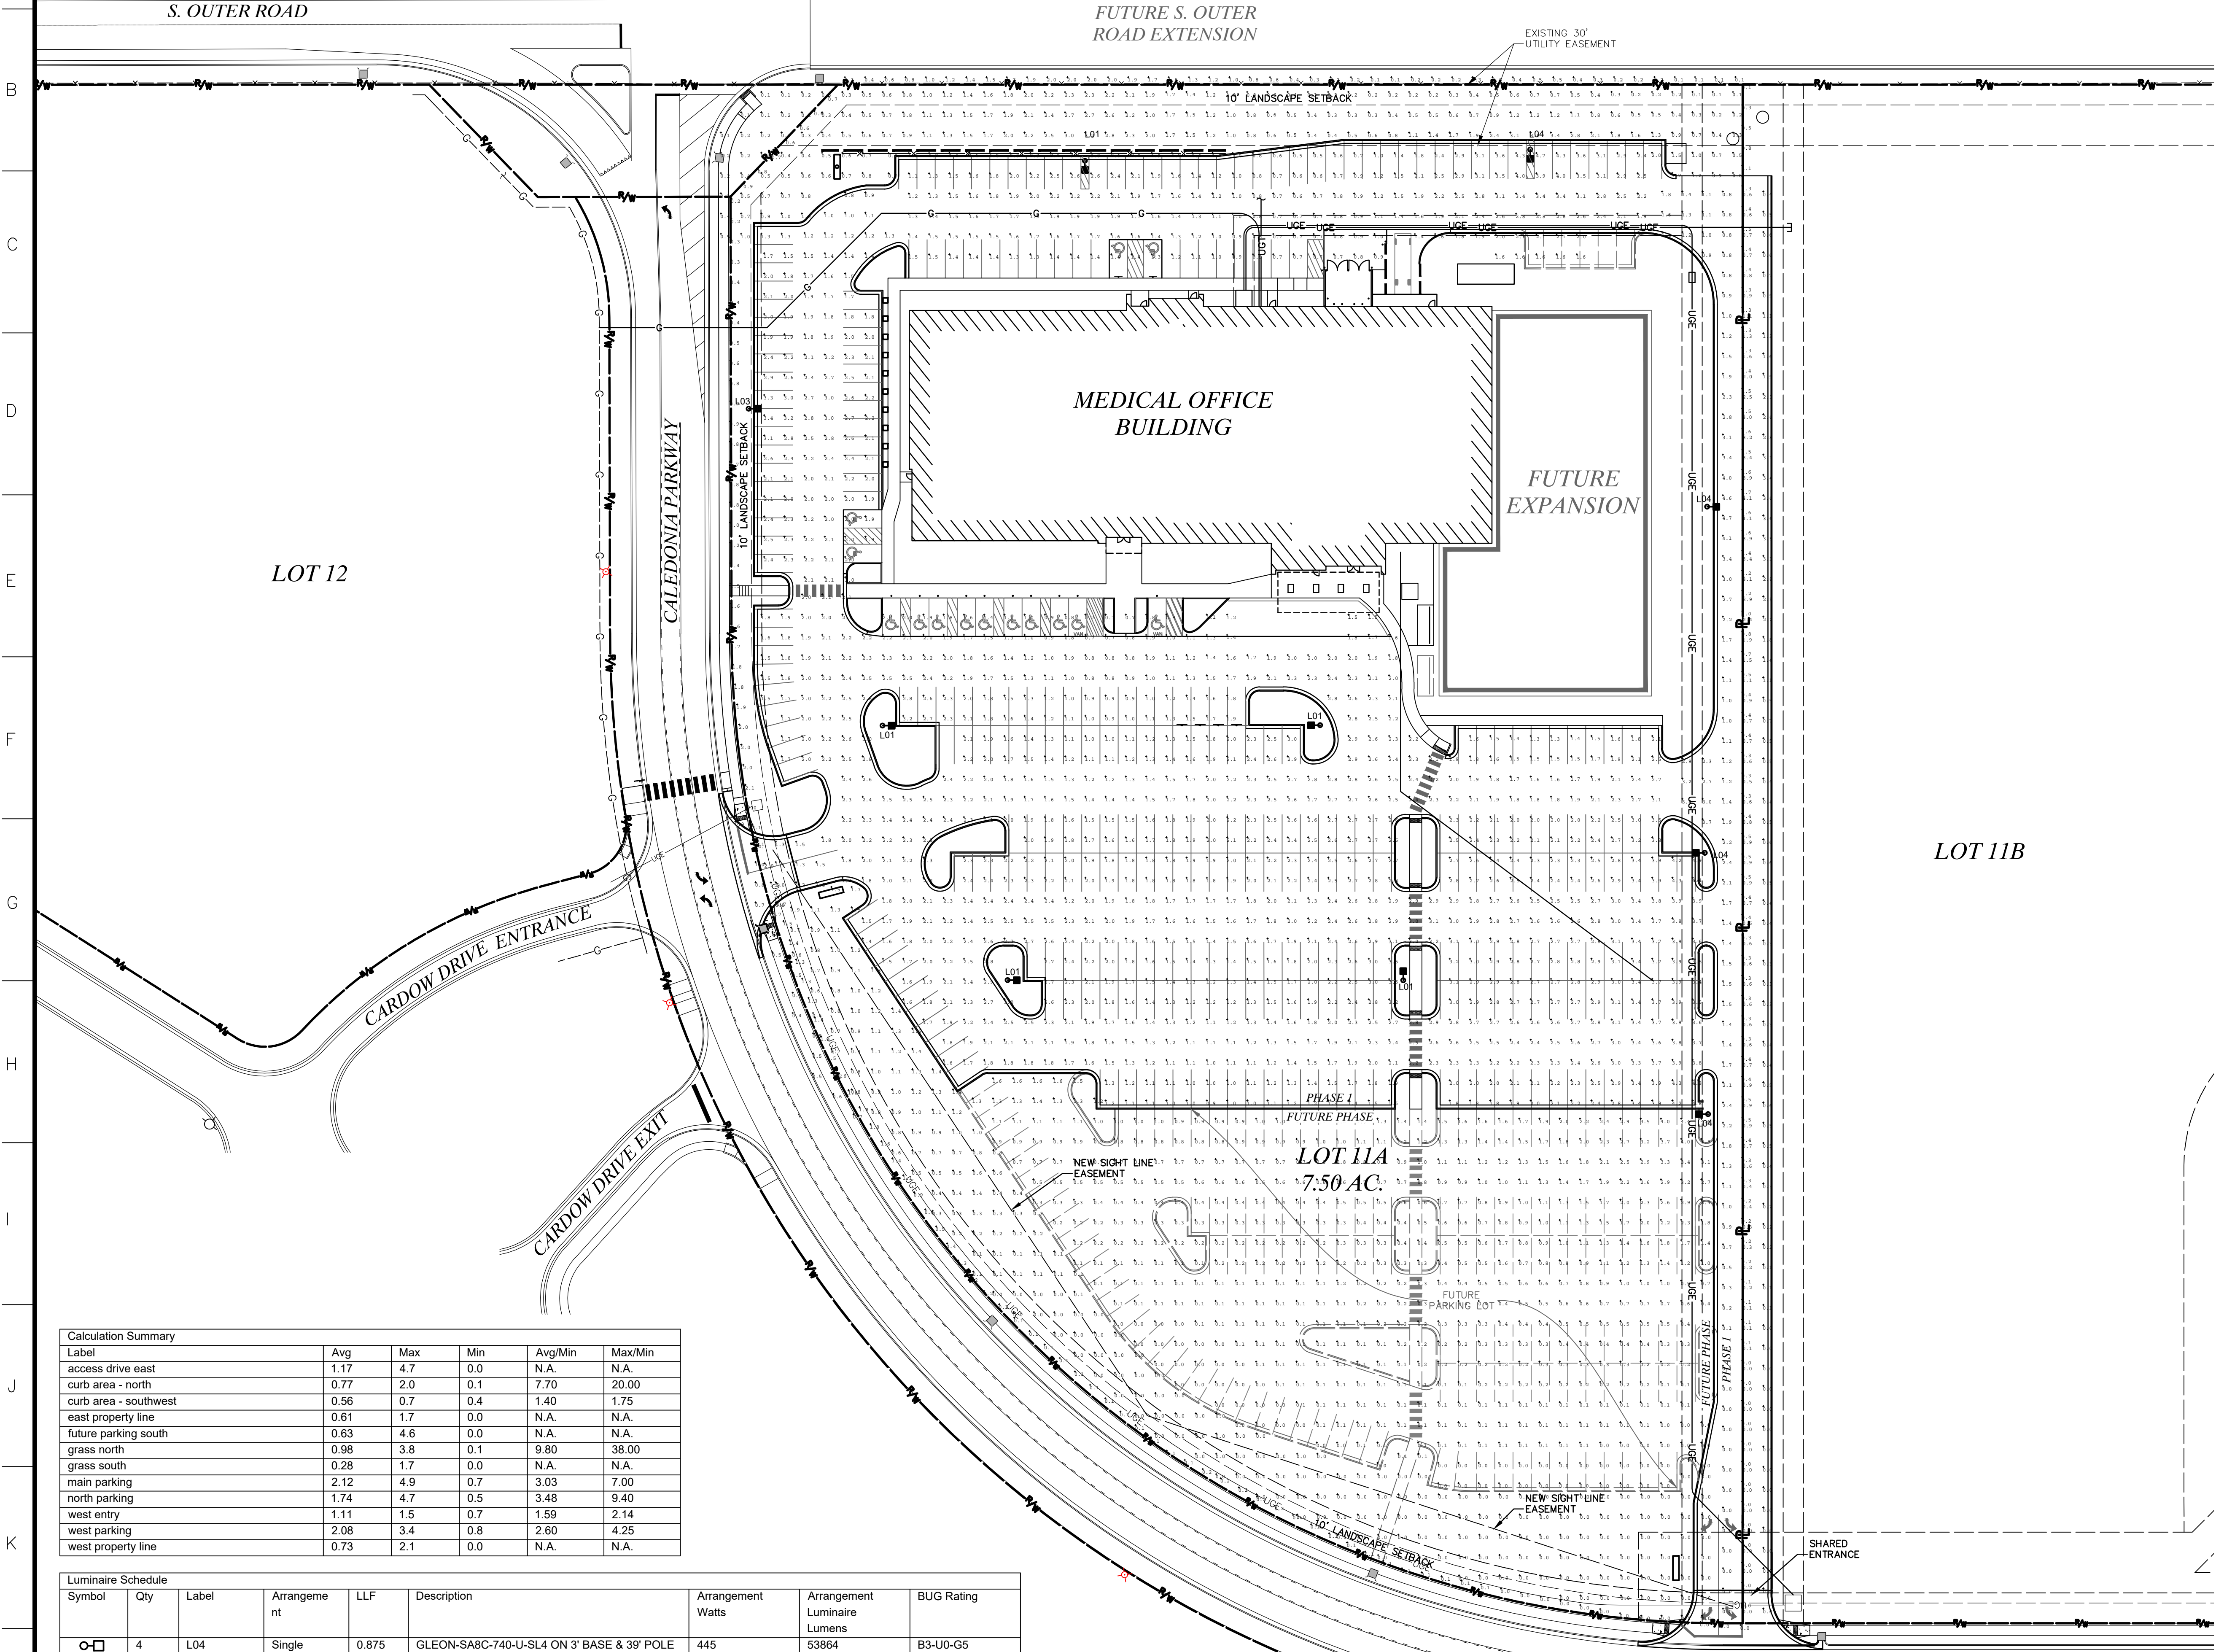

Label	Avg	Max	Min	Avg/Min	Max/Min
access drive east	1.17	4.7	0.0	N.A.	N.A.
curb area - north	0.77	2.0	0.1	7.70	20.00
curb area - southwest	0.56	0.7	0.4	1.40	1.75
east property line	0.61	1.7	0.0	N.A.	N.A.
future parking south	0.63	4.6	0.0	N.A.	N.A.
grass north	0.98	3.8	0.1	9.80	38.00
grass south	0.28	1.7	0.0	N.A.	N.A.
main parking	2.12	4.9	0.7	3.03	7.00
north parking	1.74	4.7	0.5	3.48	9.40
west entry	1.11	1.5	0.7	1.59	2.14
west parking	2.08	3.4	0.8	2.60	4.25
west property line	0.73	2.1	0.0	N.A.	N.A.

Symbol	Qty	Label	Arrangement	LLF	Description	Arrangement Watts	Arrangement Luminaire Lumens	BUG Rating
	4	L04	Single	0.875	GLEON-SA8C-740-U-SL4 ON 3' BASE & 39' POLE	445	53864	B3-U0-G5
	1	L03	Single	0.875	GLEON-SA8C-740-U-T4W ON 3' BASE & 39' POLE	445	56291	B4-U0-G5
	5	L01	Single	0.875	GLEON-SA8C-740-U-SMQ ON 3' BASE & 39' POLE	445	59549	B5-U0-G5

DWG NAME: F:\22-9120 - Professional Design Services for the SSM Medical Building in O'Fallon, MO\AutoCad Drawings\9120 - Plan Sheets\09 - SITE LIGHTING PLAN.dwg LAYOUT TAB - LIGHTING - PLOTTED ON: Dec 21, 2022 - 8:33am PLOTTED BY: jmeyer