

Austin  
Carolins  
Denver  
New York  
St. Louis: 319 North 4th Street  
Suite 1000  
St. Louis, MO 63102  
phone 314/231-5700  
fax 314/231-0818

Project Team:

**G&W**  
Engineering  
Corporation  
138 Webster Parkway  
St. Louis, MO 63143  
(314) 489-3727  
www.gandwengineering.com Project No. 2006-0044

Professional Seal:

The Professional Architect's seal and office to this sheet applies only to the material and work shown on this sheet. All drawings, instruments or other documents not exhibiting this seal shall not be considered approved by the architect, and the architect expressly disclaims any and all responsibility for such plans, drawings or documents not exhibiting this seal.


Project Title:

O'FALLON, MO 63366

BUILDING RENOVATIONS FOR:

**ST. LOUIS LIFE**

ROLLING THUNDER DRIVE

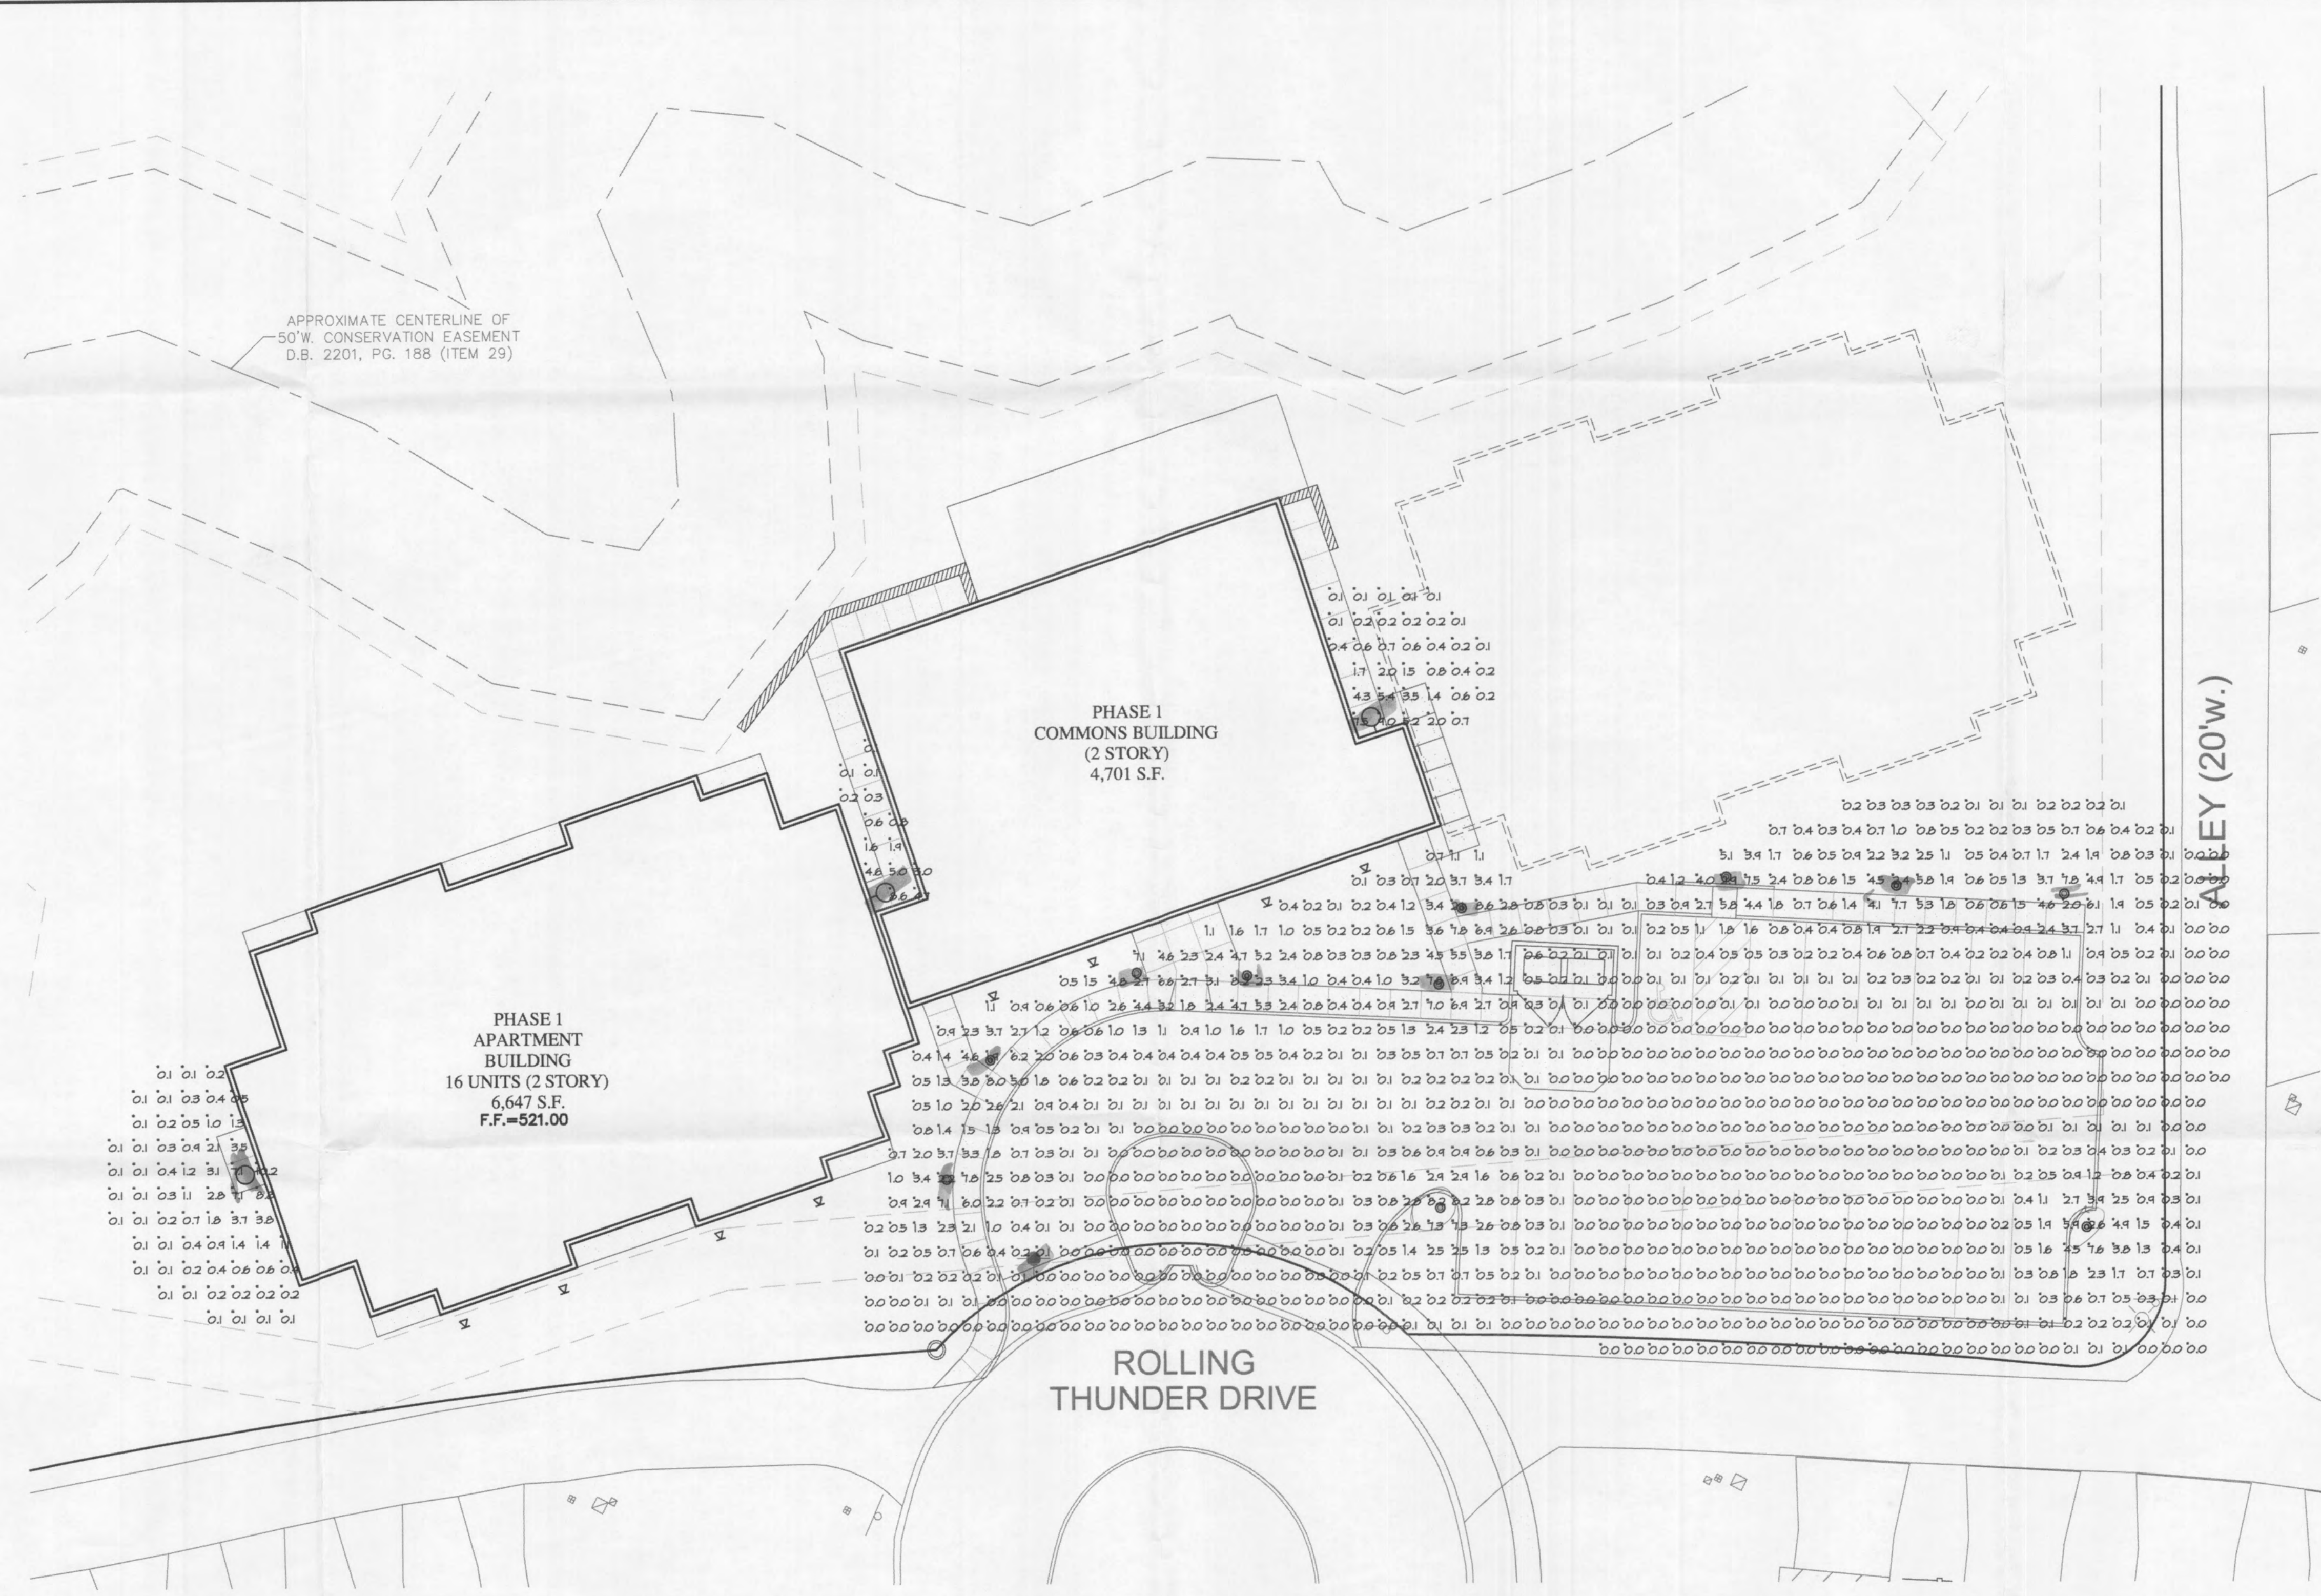

APPROXIMATE CENTERLINE OF  
50' W. CONSERVATION EASEMENT  
D.B. 2201, PG. 188 (ITEM 29)

PHASE 1  
COMMONS BUILDING  
(2 STORY)  
4,701 S.F.

PHASE 1  
APARTMENT  
BUILDING  
16 UNITS (2 STORY)  
6,647 S.F.

ROLLING  
THUNDER DRIVE

ALLEY (20'w.)

**SITE PLAN - PHOTOMETRIC**  
SCALE: 1/16" = 1'-0"

Numeric Summary							
Project: All Projects							
Label	CalcType	Units	Avg	Max	Min	Avg/Min	Max/Min
HALL MOUNT GRID	Illuminance	Fc	1.39	10.2	0.1	19.20	102.00
GRID	Illuminance	Fc	0.11	8.4	0.0	0.00	0.00

Luminaire Schedule						
Project: All Projects						
Symbol	Qty	Label	Arrangement	Lumens	LLF	Description
F1	3	F1	SINGLE	3200	0.810	42W IMPACT
Q	11	F2	SINGLE	3200	0.810	BRC-36-42-CF

Sheet Title:

SITE PLAN -  
PHOTOMETRIC

Project Number: 2006-0044  
Sheet Number: PH1.0  
Drawn By: A.T.E.  
Issue Date: 03-02-2006

RECEIVED  
AUG 14 2006

CITY OF O'FALLON  
COMMUNITY DEVELOPMENT DEPARTMENT  
ACCEPTED FOR CONSTRUCTION  
DATE: 8-14-06  
PROFESSIONAL ENGINEER'S SEAL  
INDICATES RESPONSIBILITY FOR DESIGN

Bldg. Inspector