




NOTE: FOR ALTERNATE AIR SYSTEM, (H-1)
PIPE CONNECTORS IN CORRIDOR 201
& TOILET 207 FROM RISER FOR ZONE 2

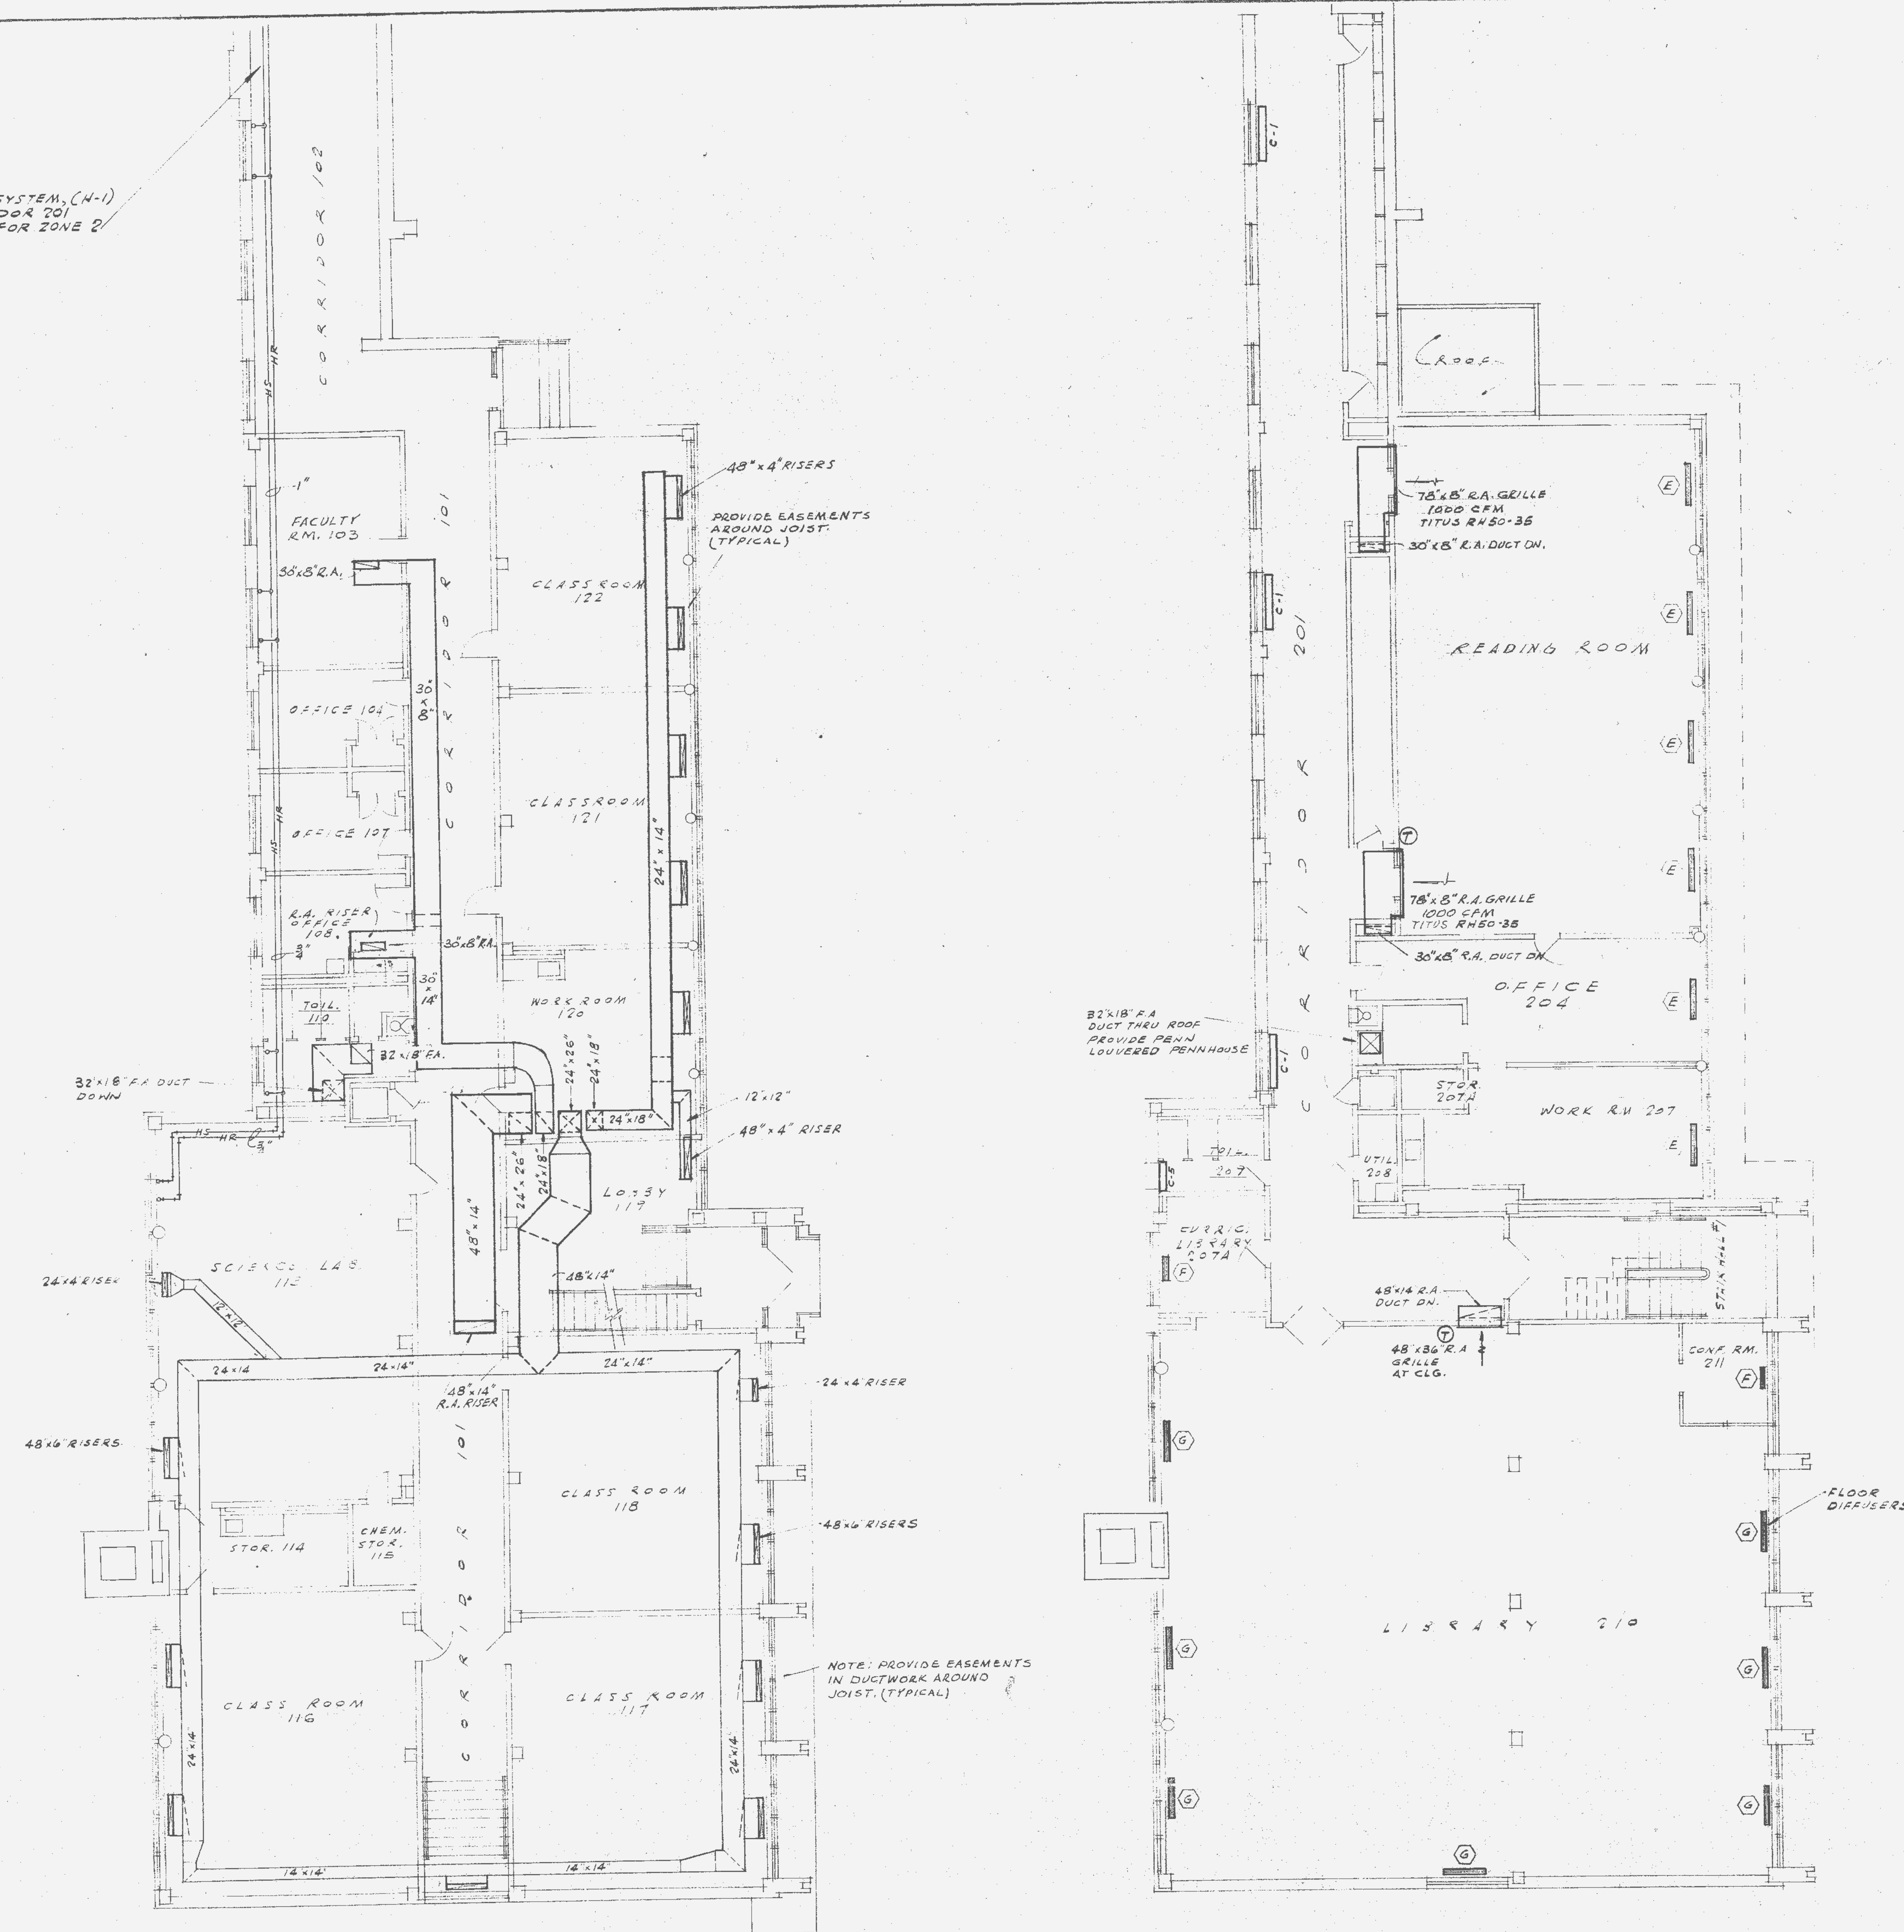

FIRST FLOOR PLAN
SCALE 1/8"=1'-0"

SECOND FLOOR PLAN
SCALE 1/8"=1'-0"

ALTERNATE H-1
PLANS SHOWING ALTERNATE AIR SYSTEM
FOR READING ROOM 203, OFFICE 204,
WORK ROOM 207, & LIBRARY 210 & 207A

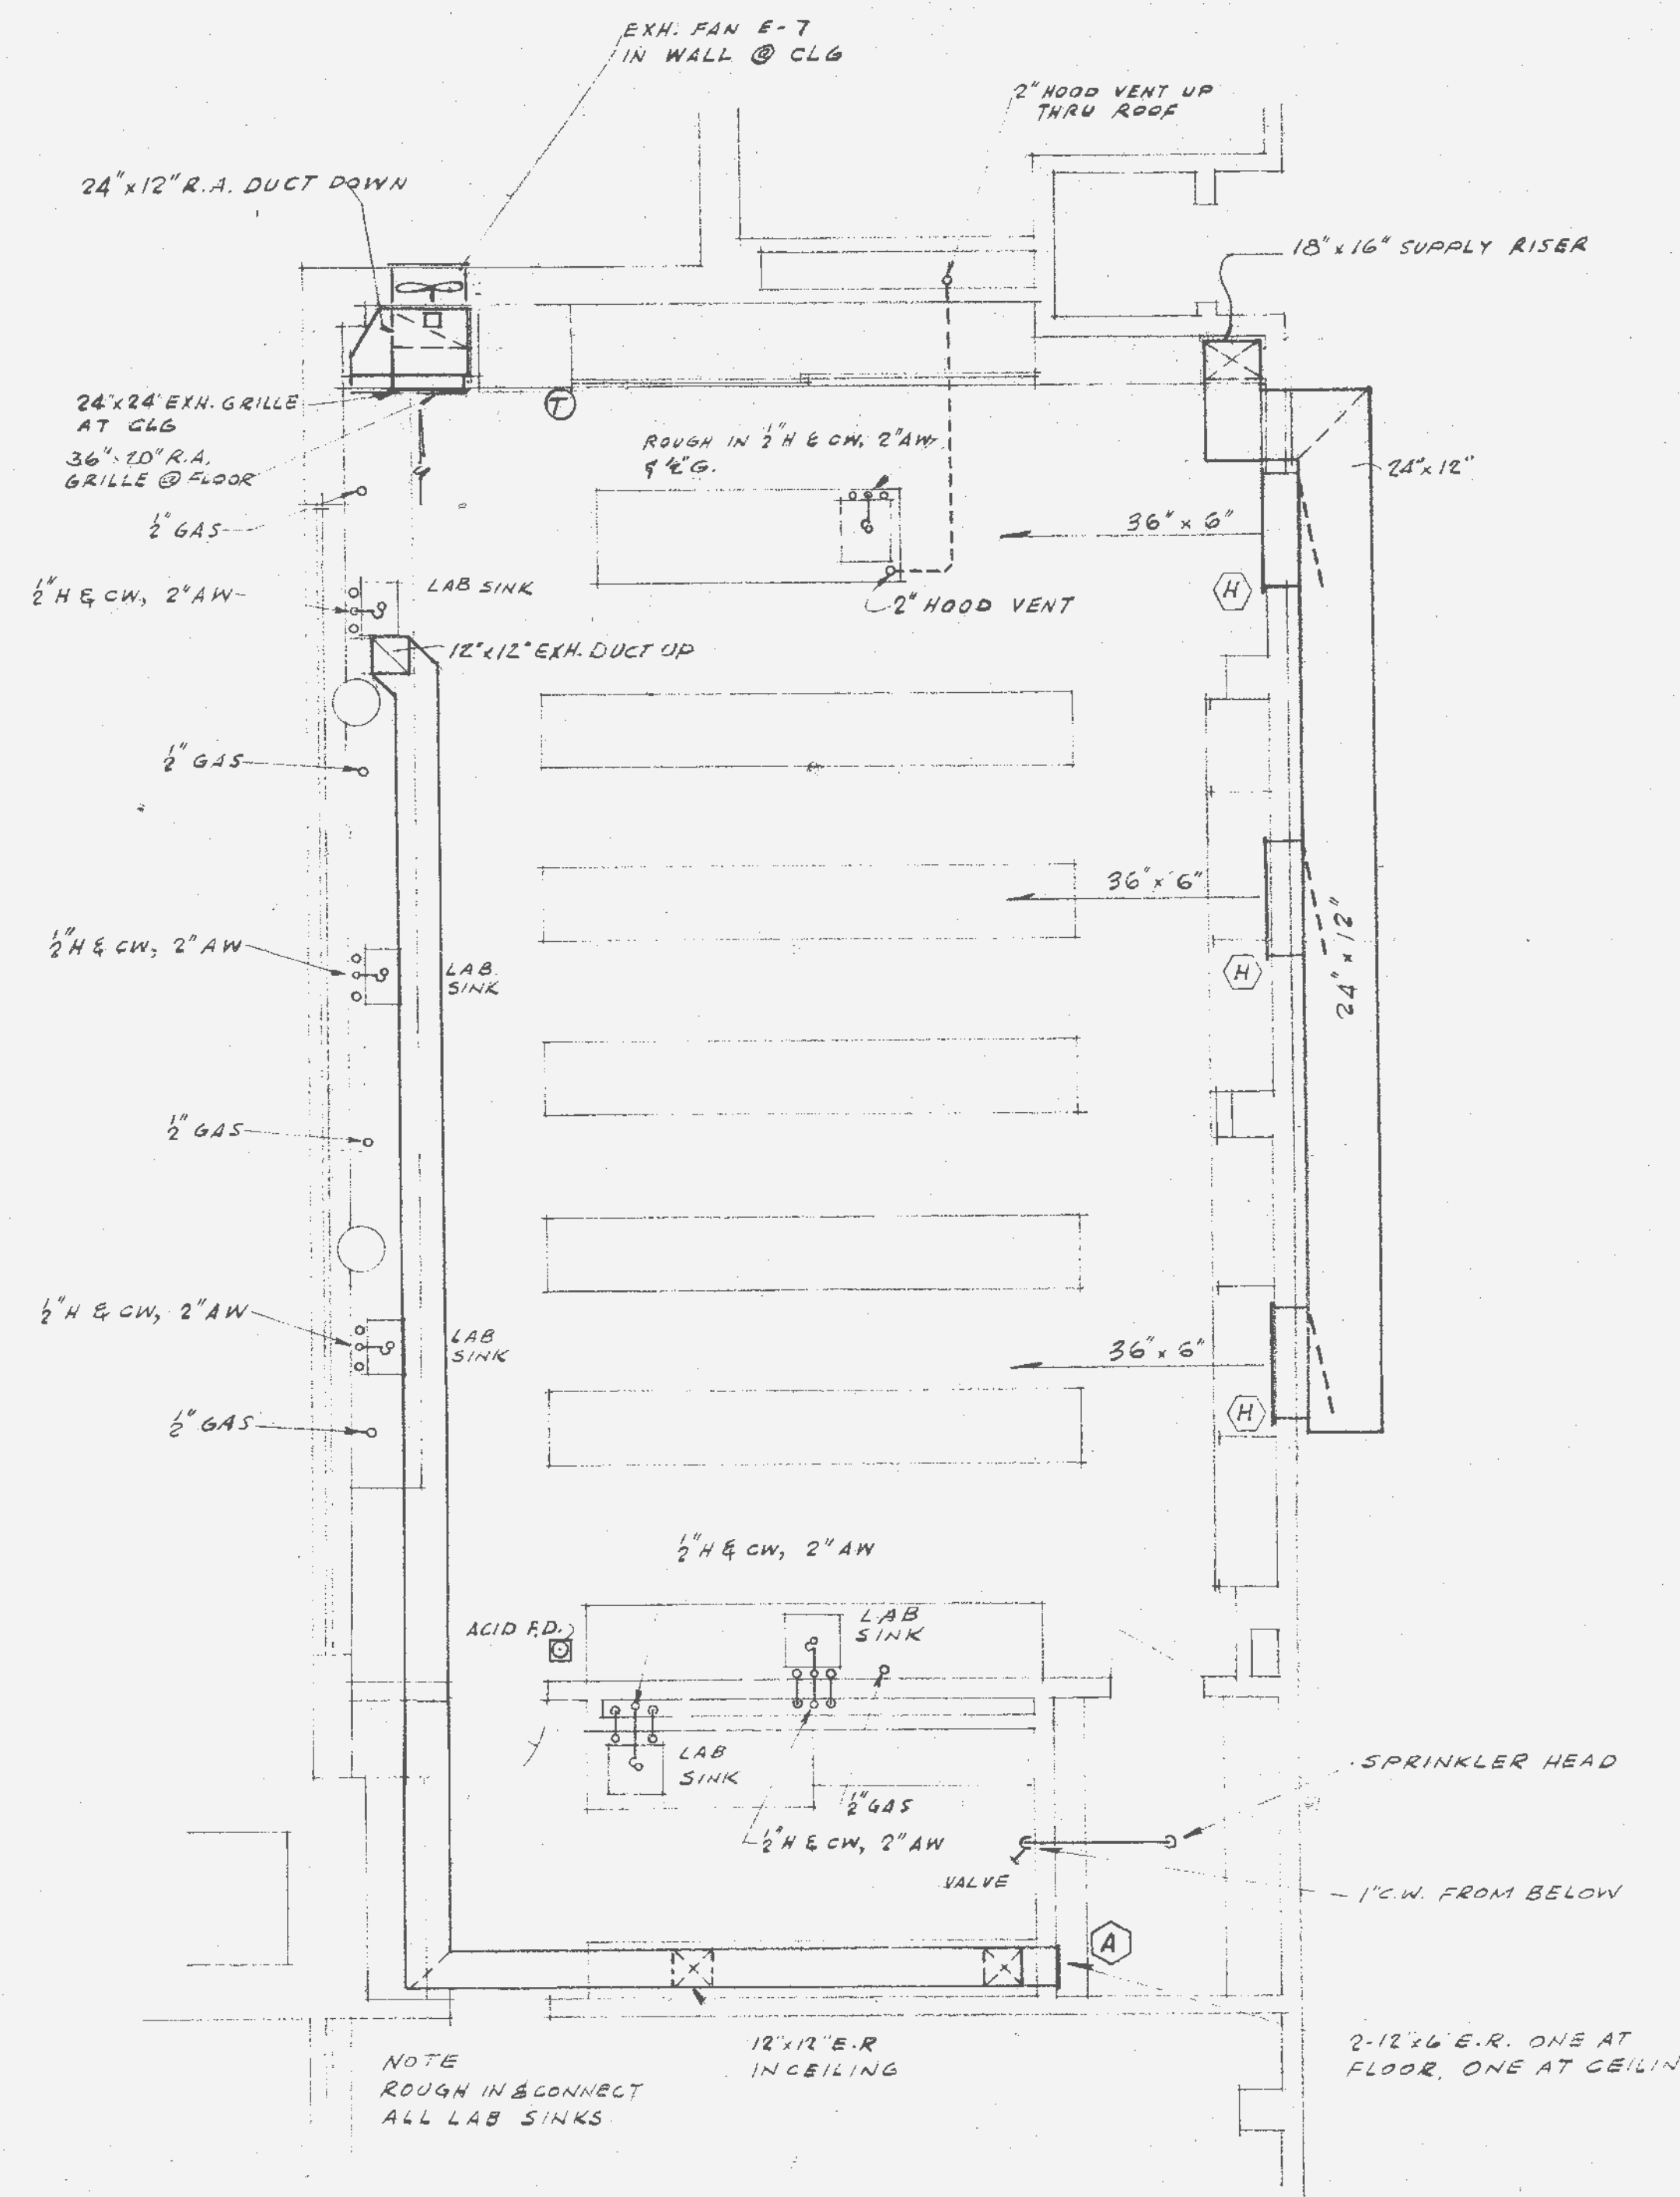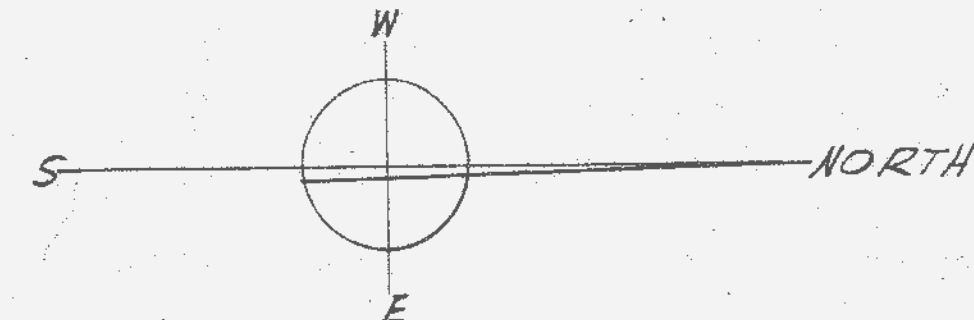

PLAN OF
SCIENCE LAB-113
SCALE: 1/4" = 1'-0"

DATE:	ADDITION TO ST. MARYS INSTITUTE O'FALLON, MO.	
DRAWN BY C.C.	FOR THE SISTERS OF THE MOST PRECIOUS BLOOD MOTHER M. LORENZA, C.PHS., MOTHER GENERAL	
JOB NO. 3102	A.F. & ARTHUR STAUDER, ARCHITECTS 3608 SOUTH GRAND BLVD. ST. LOUIS 18, MISSOURI PAUL LONDE & ASSOC. CONSULTING ENGINEERS	SHEET M-5
REVISIONS:		