

# STREET LIGHTING PLAN - PHASE 3



MAY, 2021


## LEGEND

EXISTING	PROPOSED

CUIVRE RIVER WILL INSTALL ALL CONDUIT, PRIMARY & SECONDARY WIRING AND STREET LIGHTS.

Drawing name: E:\17-6821 - 860 Acre Tract along Hwy 40, O'Fallon, MO\AutoCad Drawings\6821 - Plan Sheets\Construction Drawings\PH3 Residential Plans\06\_Street Lighting Plan Phase 3.dwg Tab: LIGHTING PLAN PH3-1 Plotted on: May 25, 2021 - 3:47pm Plotted by: jreyer

A  
B  
C  
D  
E  
F  
G  
H  
I  
J  
K  
L

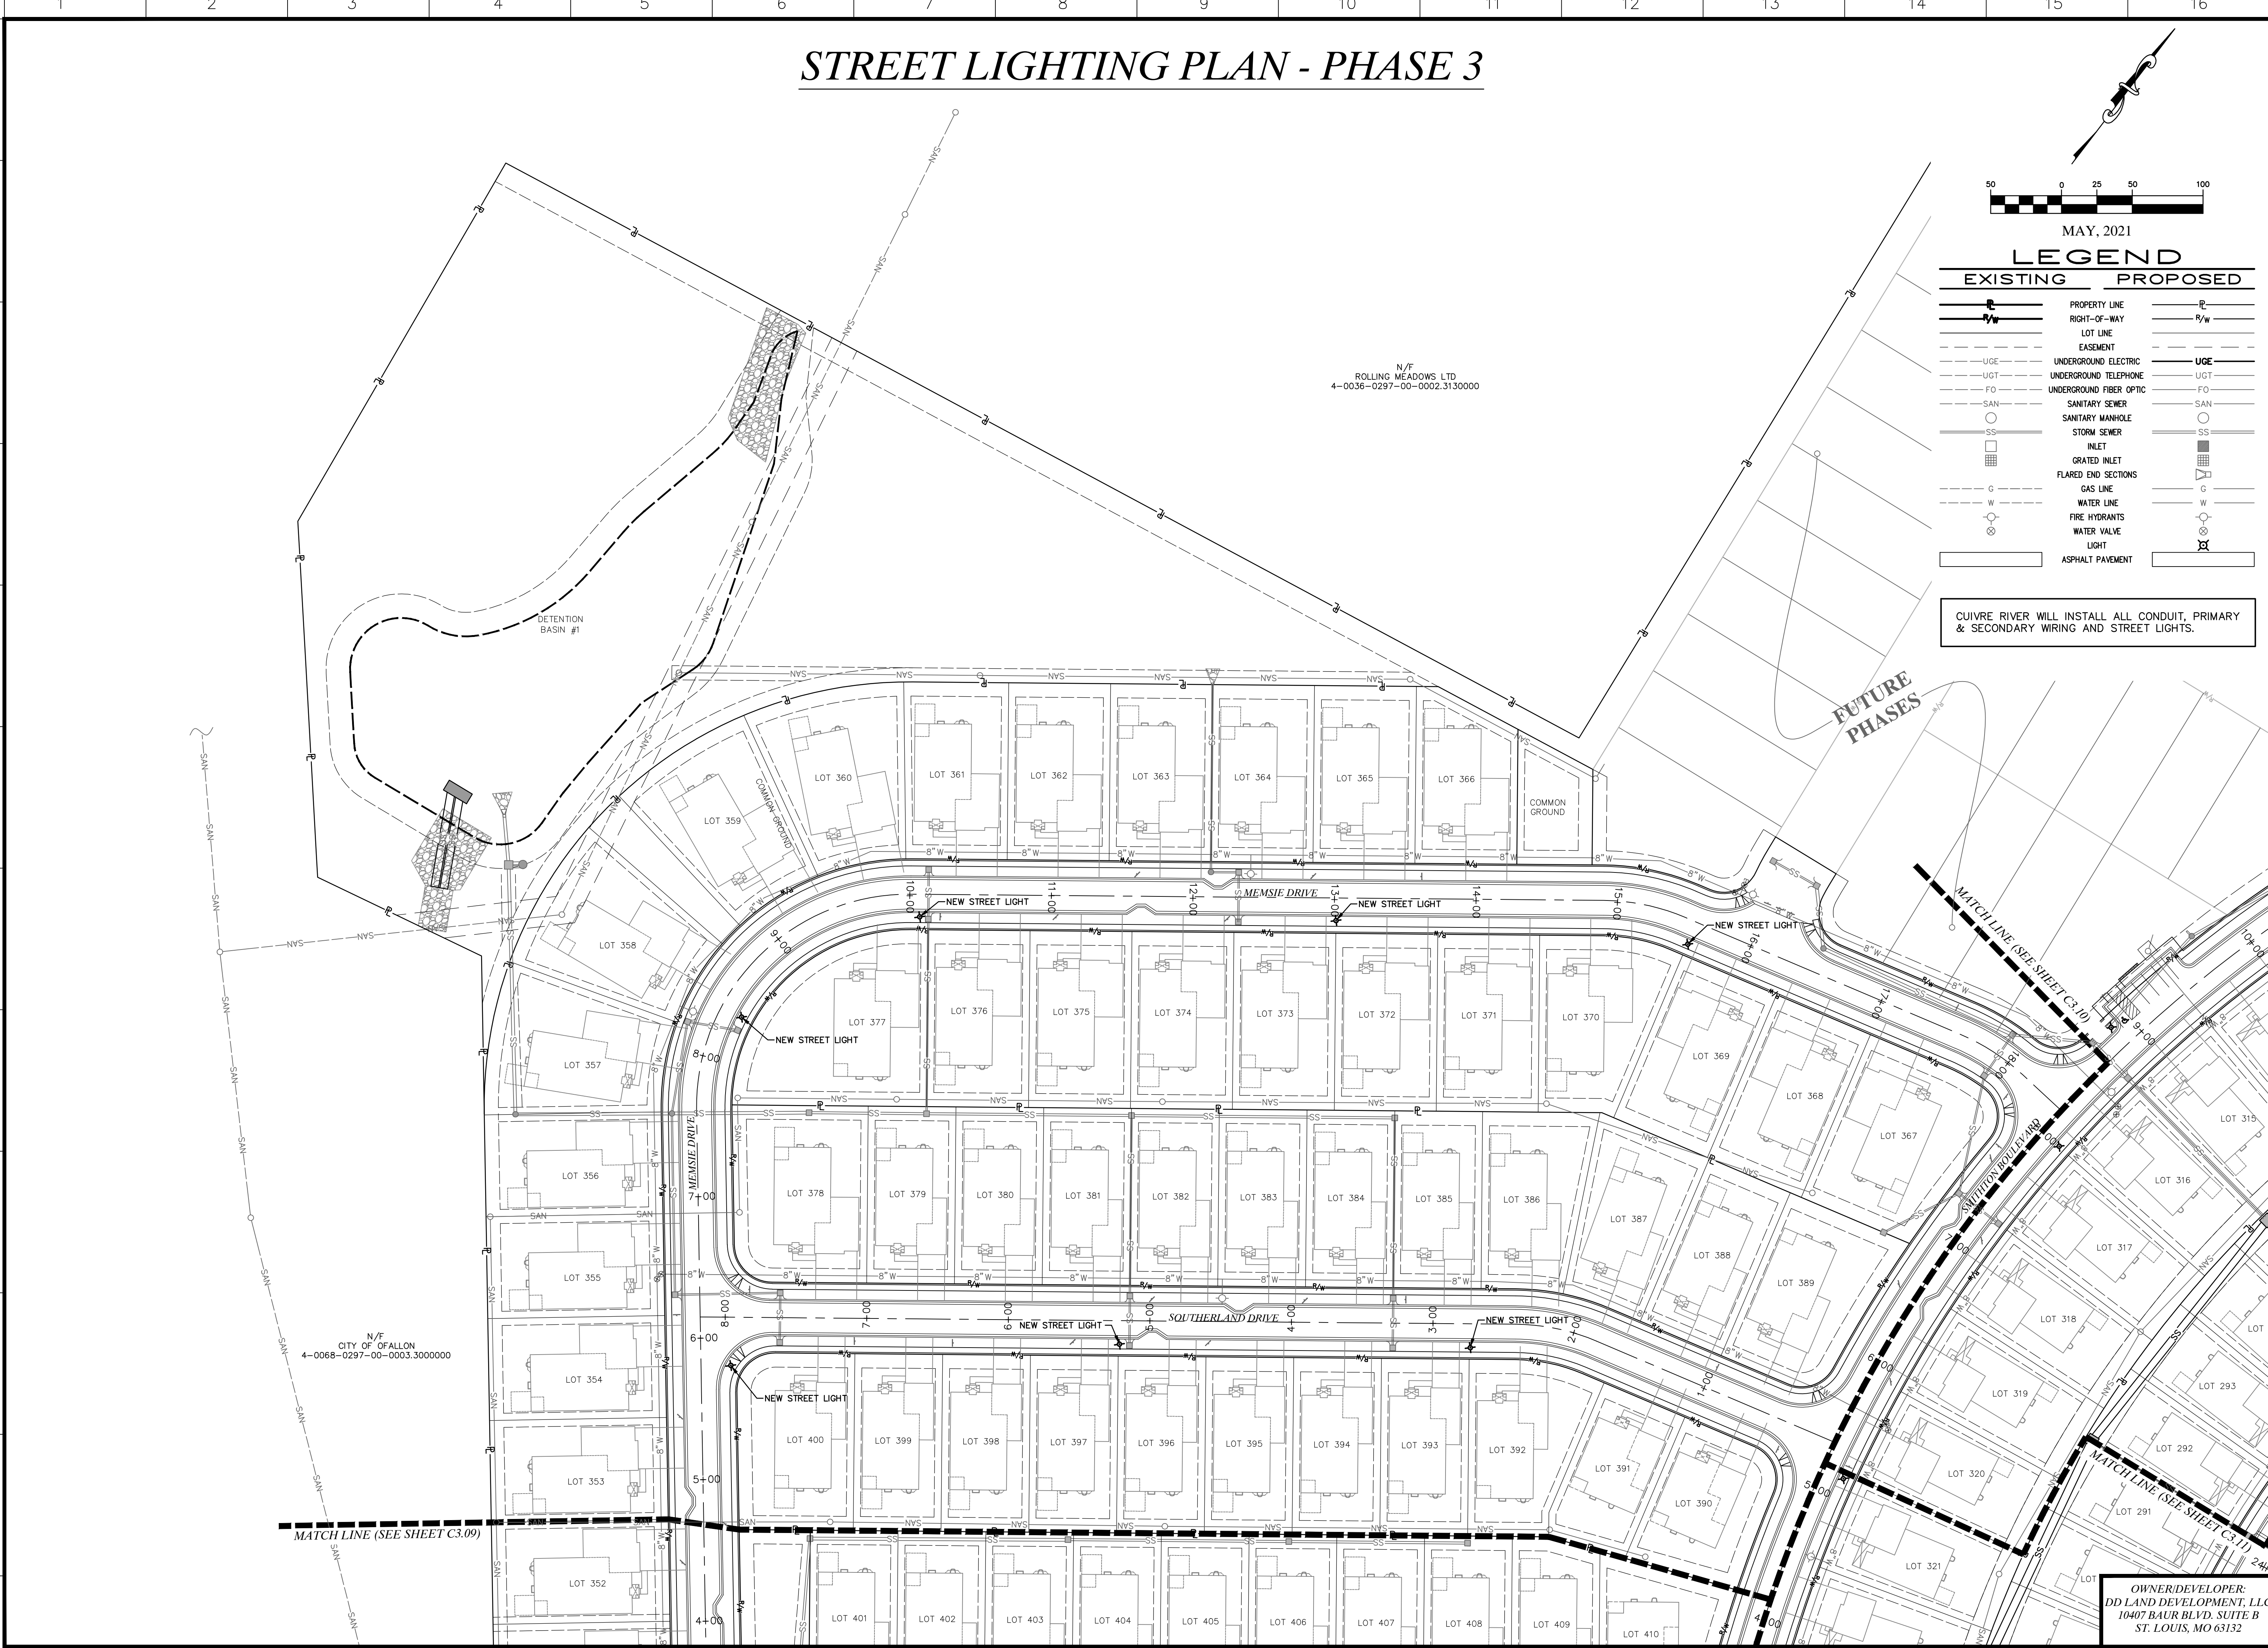

N/F  
ROLLING MEADOWS LTD  
4-0036-0297-00-0002.3130000

N/F  
CITY OF OFALLON  
4-0068-0297-00-0003.3000000

636-584-0540 (tel.)  
636-584-0512 (fax)  
mailto:ochran@ochran.com

**UCHRAN**  
Civil Engineering  
Land Surveying  
Architecture  
Site Development  
General Consulting  
Master Planning

Missouri State Certificate of Authority Numbers:  
Survey: 000380  
Engineering: 001655  
Architecture: 2002014240

Three working days prior to the start of any excavation, call 1-800-UGC-RTTE for utility location information.

All OSHA rules & regulations and state & local construction requirements for these plans shall be strictly followed (i.e. trenching, blasting, etc.)

THE STREETS OF CALEDONIA  
PHASE 3 RESIDENTIAL  
O'FALLON, MISSOURI

STREET LIGHTING PLAN - PHASE 3

DATE:	DATE:
DESIGN BY: JMM	APPROVED BY: ERR
DATE: MAY 25, 2021	
SCALE: 1" = 50'	
PROJ. NO: 17-6821	
DWG. NO: C3.08	

OWNER/DEVELOPER:  
DD LAND DEVELOPMENT, LLC  
10407 BAUR BLVD, SUITE B  
ST. LOUIS, MO 63132