


STREET LIGHTING PLAN - PHASE 3

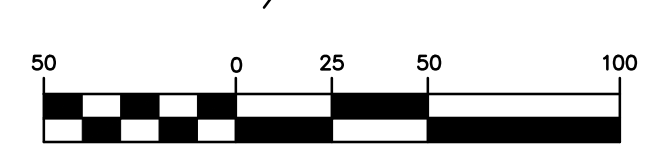


MAY, 2021

LEGEND

EXISTING	PROPOSED

CUIVRE RIVER WILL INSTALL ALL CONDUIT, PRIMARY & SECONDARY WIRING AND STREET LIGHTS.

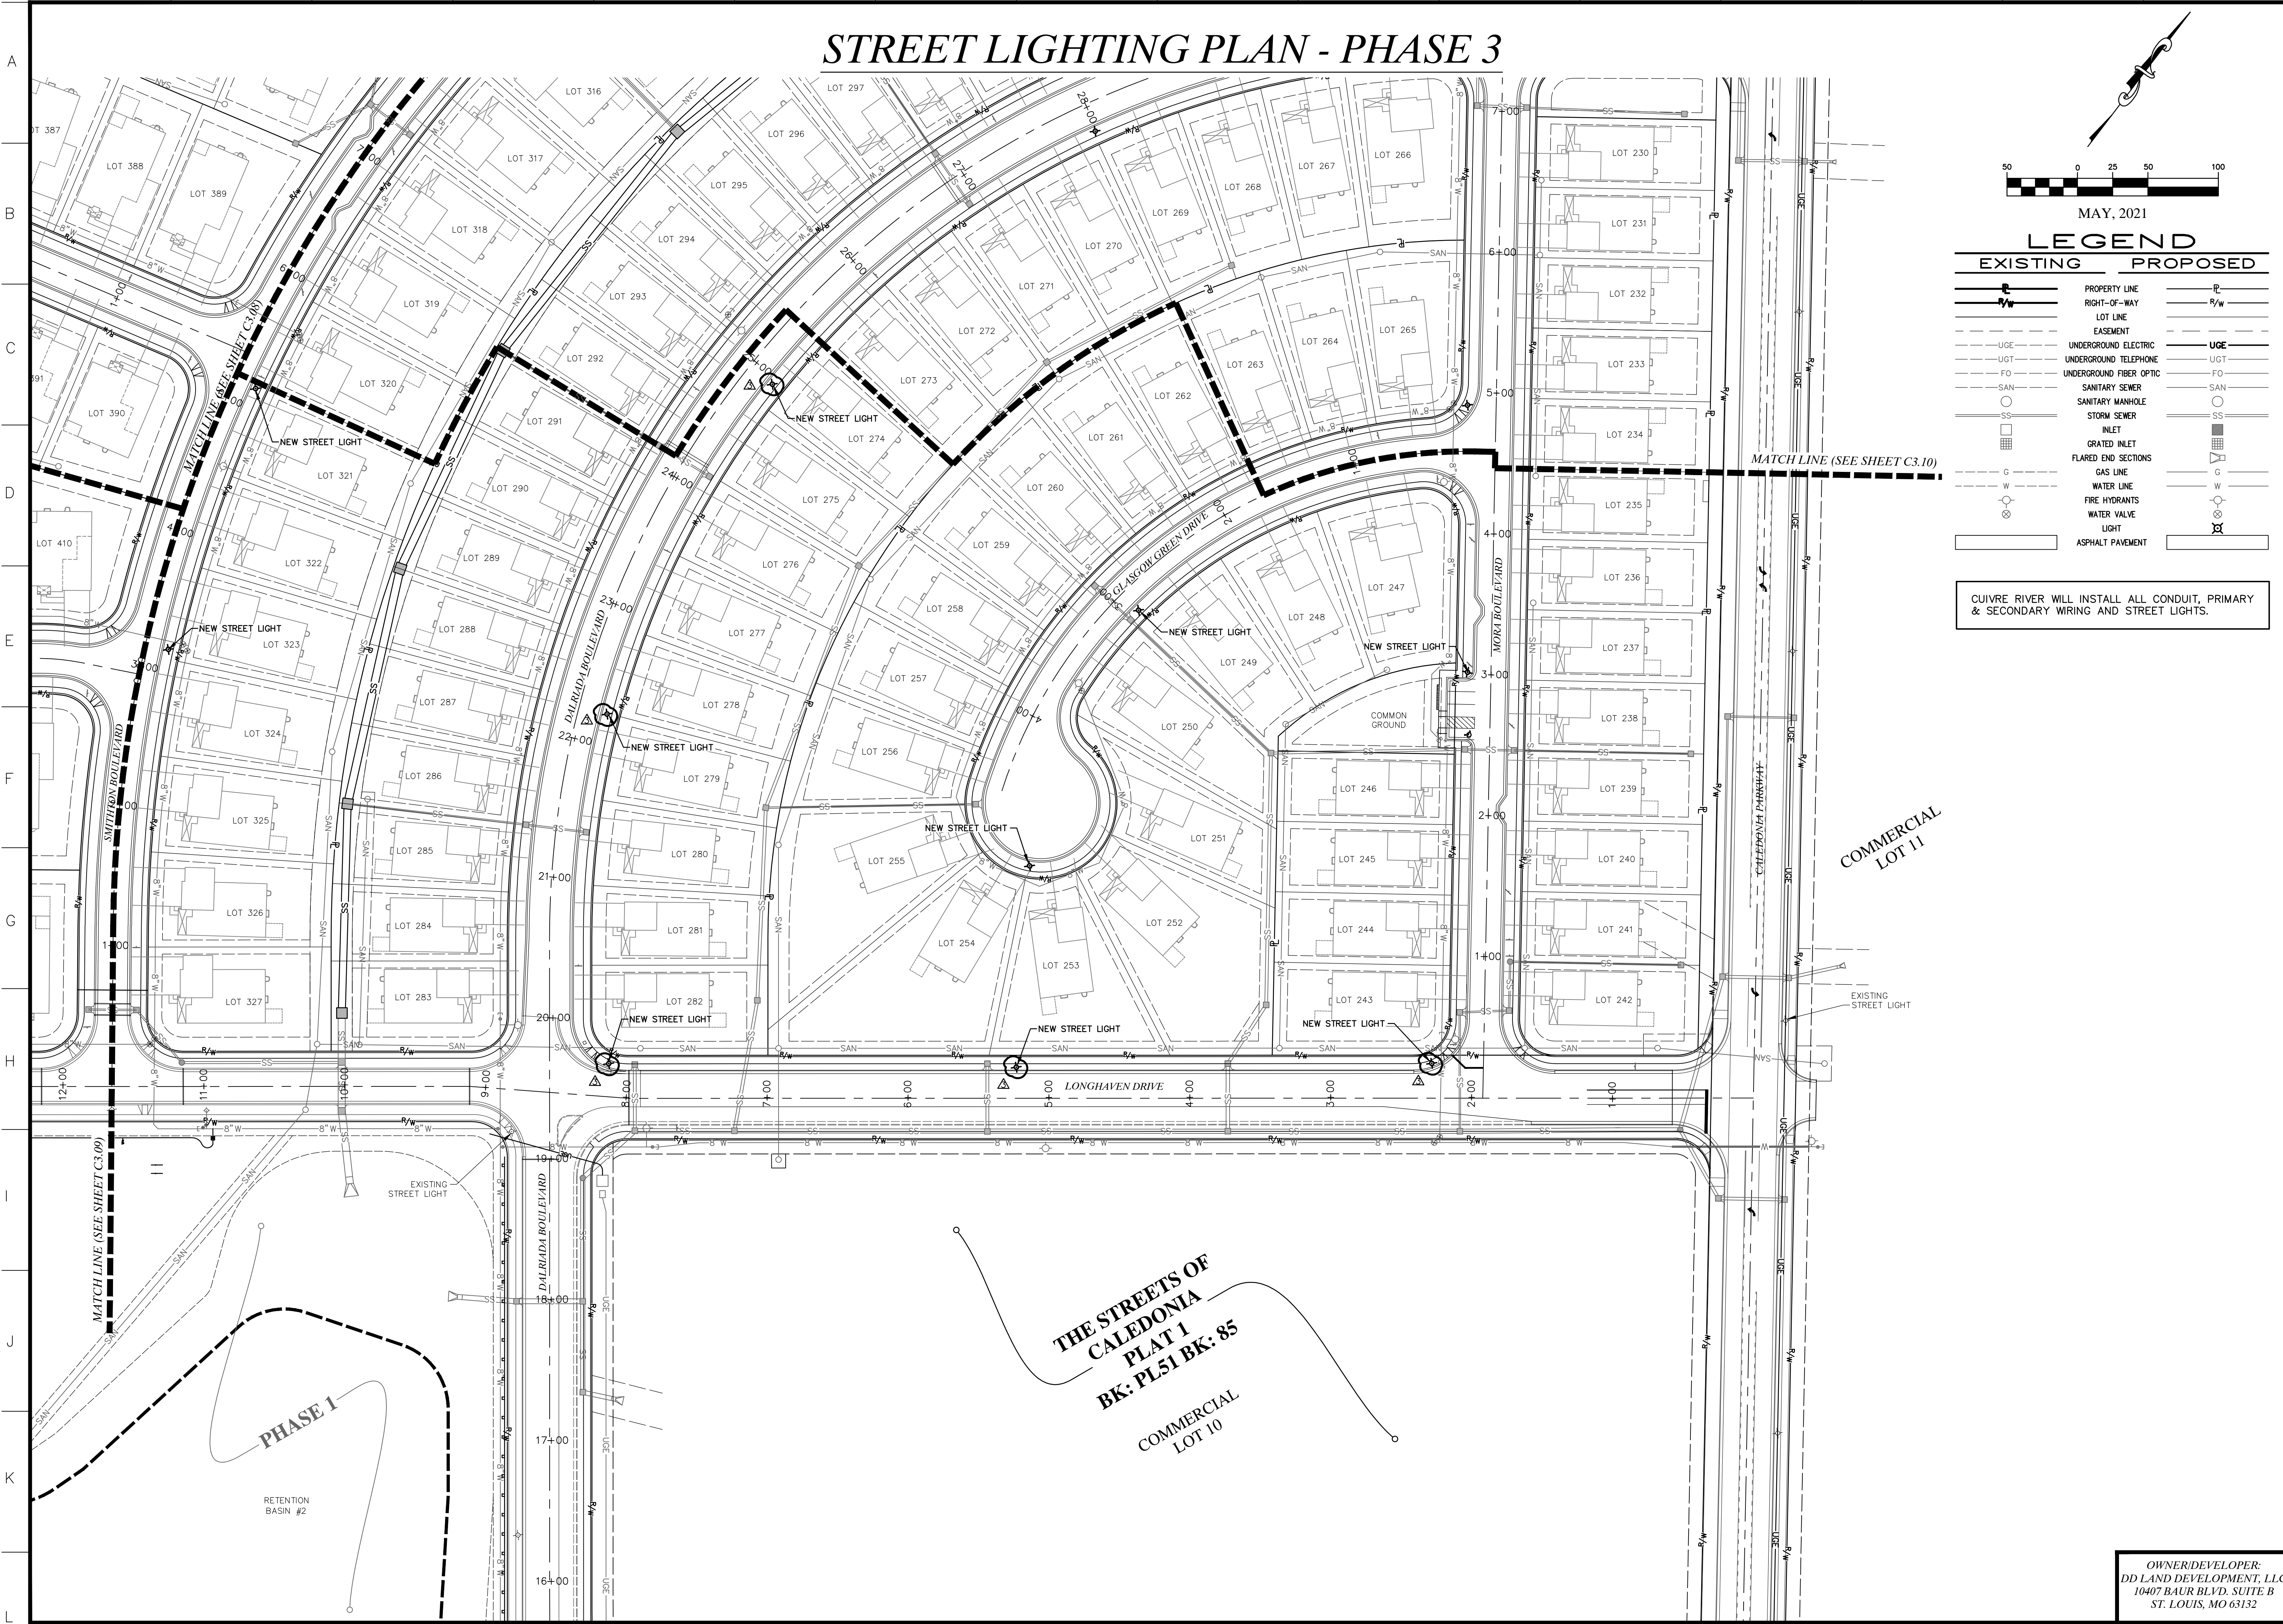


636-594-0540 (tel.)
636-594-0512 (fax)
mail@ochran.com
330A E. Independence Dr.
Union, Missouri 63084

UCHRAN
Civil Engineering
Land Surveying
Architecture
Site Development
General Consulting
Master Planning

Missouri State Certificate of Authority Numbers:
Survey 000380
Engineering 001655
Architecture 200214240

Three working days prior to the start of any excavation call 1-800-816-RTTE for utility location information.

All OSHA rules & regulations construction required by these plans shall be strictly followed (ie. trenching, blasting, etc.)

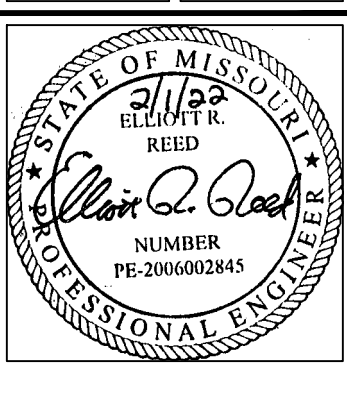

THE STREETS OF CALEDONIA
PHASE 3 RESIDENTIAL
O'FALLON, MISSOURI

DATE	BY	REVISIONS
02-01-22	JMM	LIGHT POLE REVISIONS

DATE: MAY 25, 2021
SCALE: 1" = 50'
PROJ. NO.: 17-6821
SHEET NO.: C3.11

OWNER/DEVELOPER:
DD LAND DEVELOPMENT, LLC
10407 BAUR BLVD, SUITE B
ST. LOUIS, MO 63132

Drawing name: F:\17-6821 - 260 Acre Tract along Hwy 40, O'Fallon, MO\AutoCad Drawings\6821 - Plan Sheets\Construction Drawings\PH3 Residential Plans\06_Street Lighting Plan Phase 3.dwg Tab: LIGHTING PLAN PH3-4 Plotted on: Feb 01, 2022 - 10:34am Plotted by: jmayr