


# STREET LIGHTING PLAN - PHASE 4

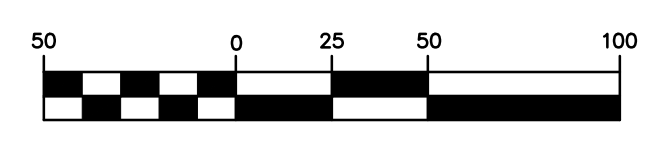

MAY, 2022

## LEGEND

EXISTING	PROPOSED

CUIVRE RIVER WILL INSTALL ALL CONDUIT, PRIMARY & SECONDARY WIRING AND STREET LIGHTS.

636-594-0540 (tel.)  
636-594-0512 (fax)  
mailto:ochran@ochran.com


**CHORAN**  
Civil Engineering  
Land Surveying  
Architecture  
Site Development  
General Consulting  
Master Planning

630A E. Independence Dr.  
Union, Missouri 63084

Missouri State Certificate of Authority Numbers:  
Survey: 000380  
Engineering: 001655  
Architecture: 2002014240

Three working days prior to the start of any excavation call 1-800-463-ARTE for utility location information.

All OSHA rules & regulations and state & local construction regulations required by these plans shall be strictly followed (i.e. trenching, blasting, etc.)

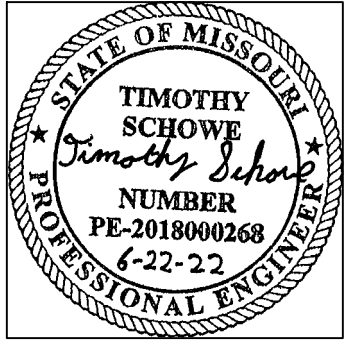

THE STREETS OF CALEDONIA  
PHASE 4 RESIDENTIAL  
O'FALLON, MISSOURI

STREET LIGHTING PLAN - PHASE 4

DATE	BY	APP'D BY
08-22-22	JMM	ERR
CITY COMMENTS		

DATE: MAY 09, 2022  
SCALE: 1" = 50'  
PROJ. NO.: 17-6821  
DRWG. NO.: C3.05

OWNER/DEVELOPER:  
DD LAND DEVELOPMENT, LLC  
10407 BAUR BLVD, SUITE B  
ST. LOUIS, MO 63132

Drawing name: F:\17-6821 - 860 Acre Tract along Hwy 40, O'Fallon, MO\AutoCad Drawings\6821 - Plan Sheets\Construction Drawings\PH4 Residential Plans\06\_Street Lighting Plan Phase 4.dwg Tab: STREET LIGHTING PLAN PH4-2 Plotted on: Jun 22, 2022 - 8:59pm Plotted by: j\_meyer

ROLLING MEADOWS LTD  
4-0036-0297-00-0002.3130000

