


N/A  
 UNGERBOECK DEVELOPMENT L.C.  
 2298/1853  
 ST. CHARLES COUNTY  
 ZONED BUSINESS PARK

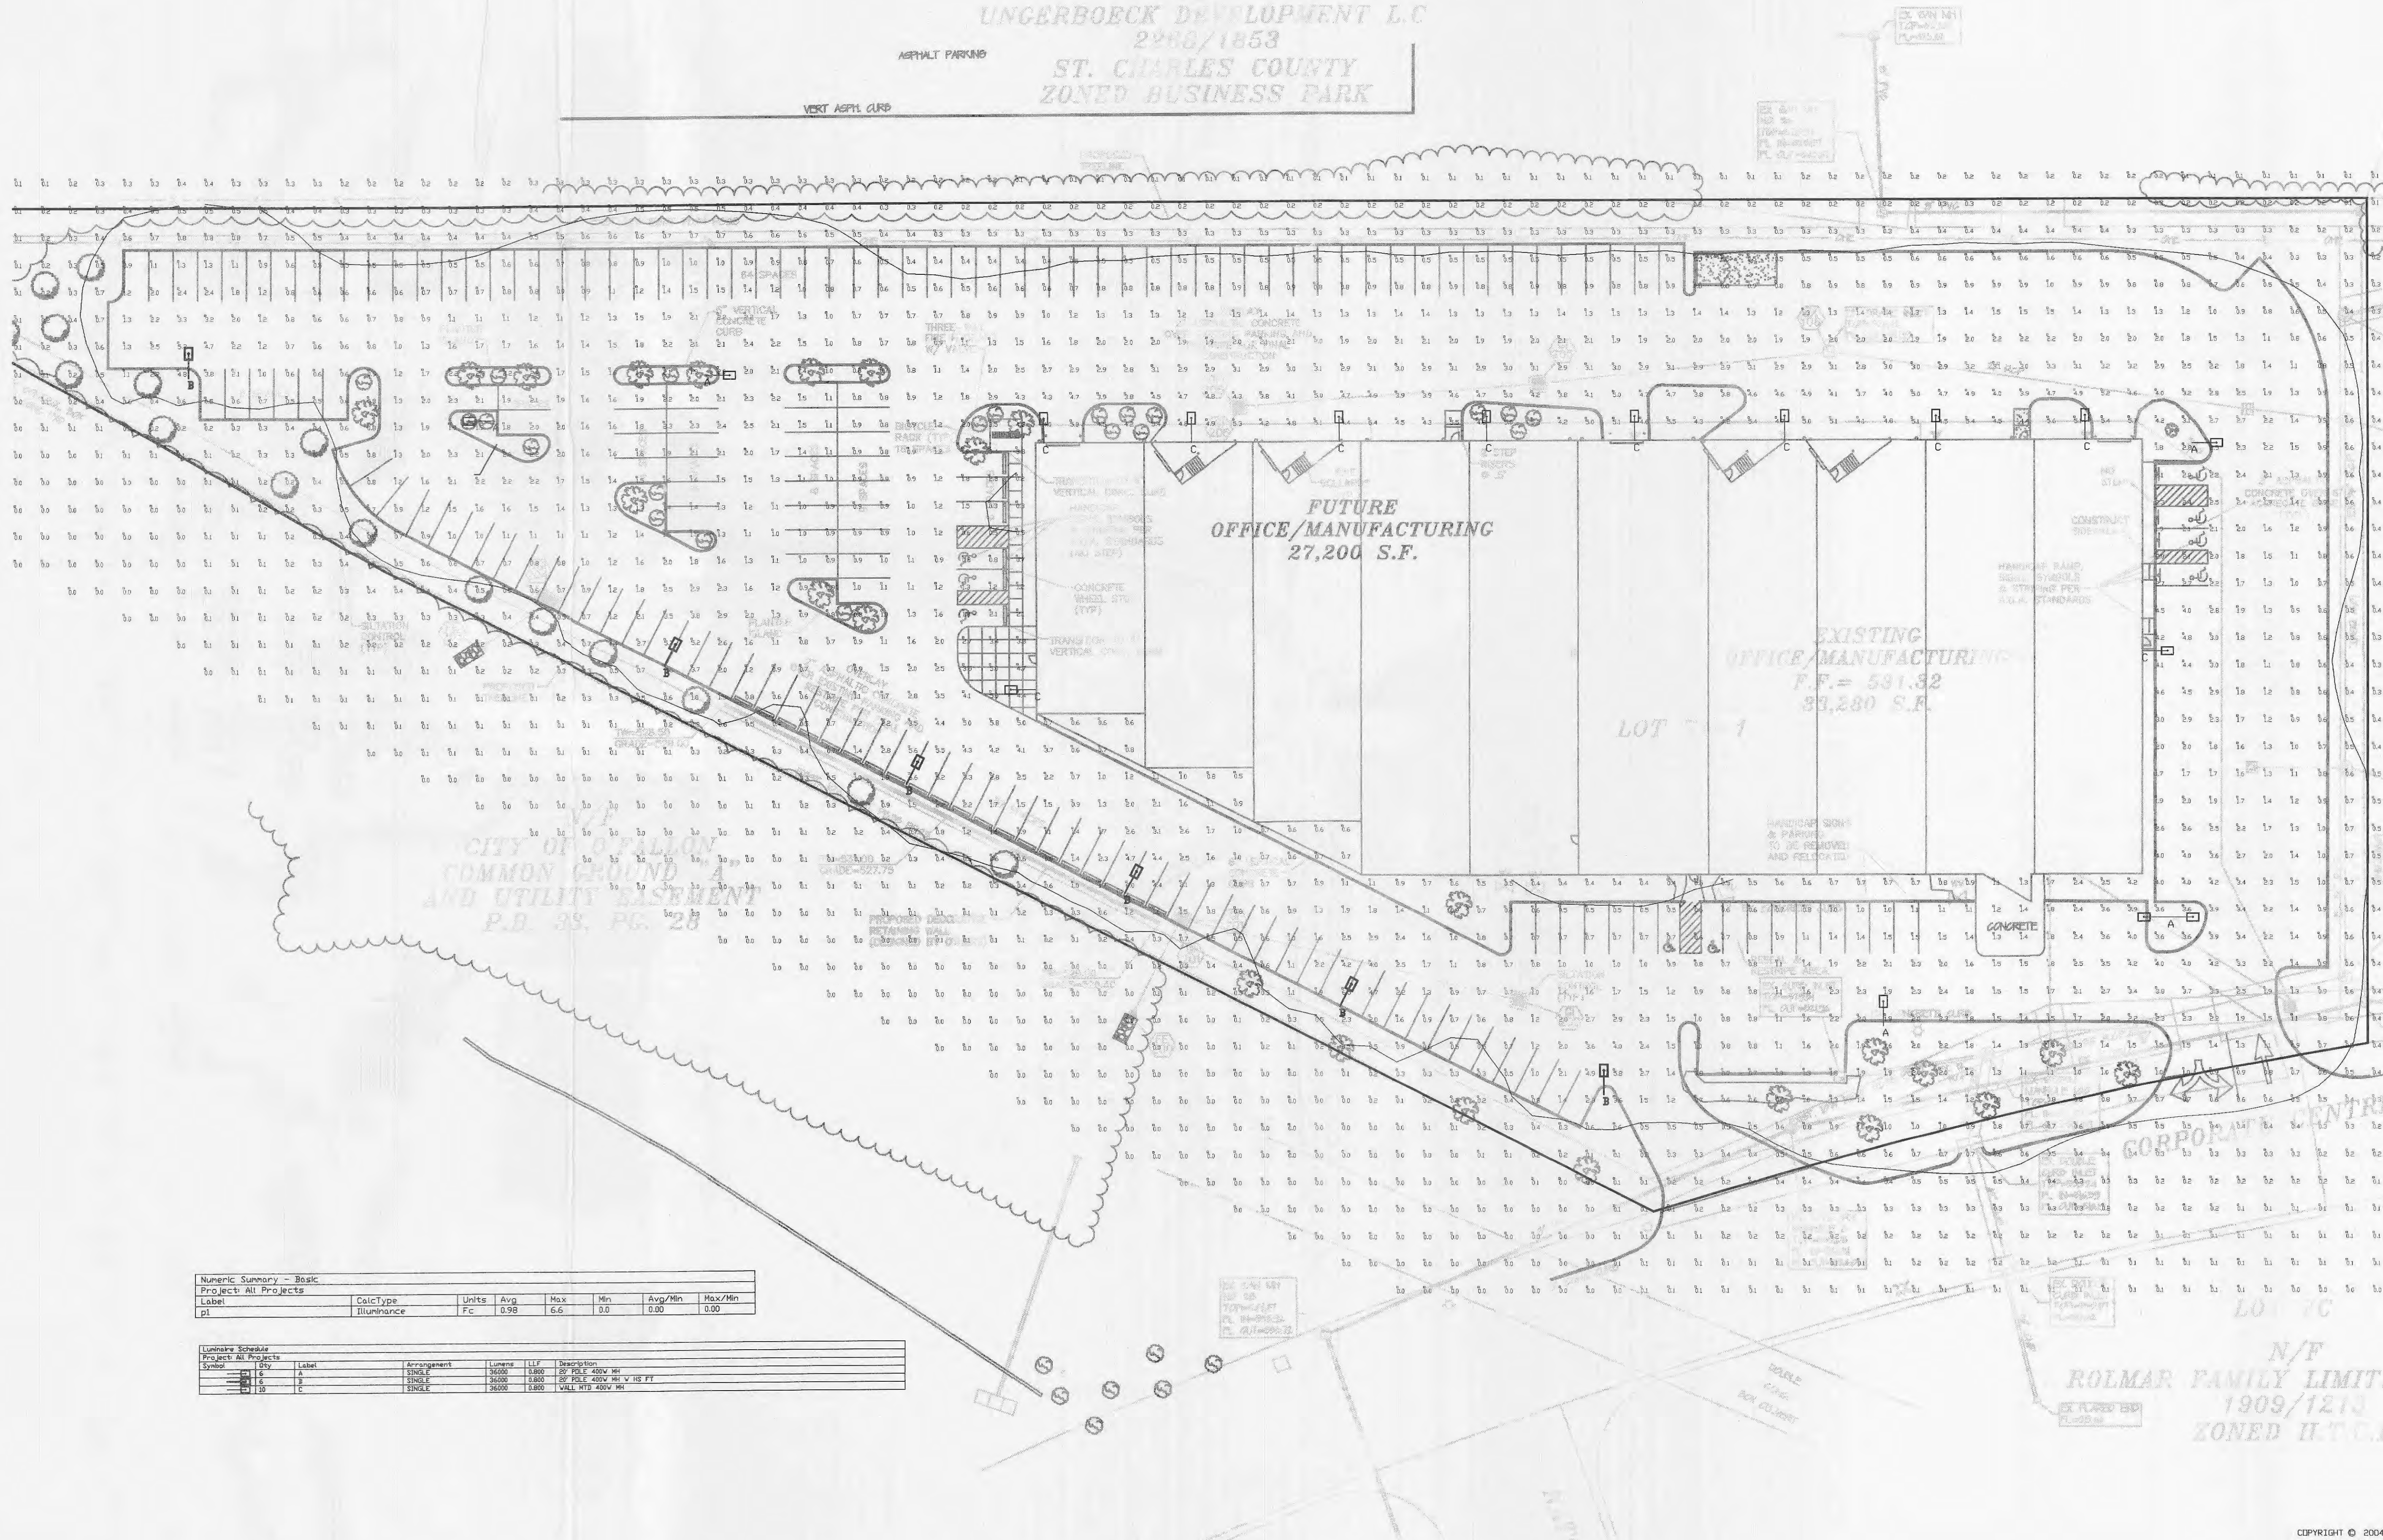

**Numeric Summary - Basic**  
 Project: All Projects

Label	CalcType	Units	Avg	Max	Min	Avg/Min	Max/Min
pl	Illuminance	Fc	0.98	6.6	0.0	0.00	0.00

**Luminaire Schedule**  
 Project: All Projects

Label	Qty	Label	Arrangement	Lumens	LLF	Description
pl	1	A	SINGLE	3600	0.80	20' POLE 400V MH VHS FT
pl	1	C	SINGLE	3600	0.80	VALL HTS 400V MH

**SITE POINT BY POINT**  
 SCALE: 1" = 30'-0"


N/A  
 ROLMAR FAMILY LIMITED  
 1909/1213  
 ZONED H.T.C.D.

COPYRIGHT © 2004  
 BELL ELECTRICAL CONTRACTORS  
 ALL RIGHTS RESERVED

THIS DOCUMENT CONTAINS PROPRIETARY INFORMATION BELONGING TO BELL ELECTRICAL CONTRACTORS, INC. OR ITS AFFILIATED COMPANY AND SHALL BE USED ONLY FOR THE PURPOSE FOR WHICH IT WAS SUPPLIED. IT SHALL NOT BE COPIED, REPRODUCED, OR OTHERWISE USED OR SHALL SUCH INFORMATION BE FURNISHED IN WHOLE OR IN PART TO OTHERS, EXCEPT IN ACCORDANCE WITH THE PRIOR WRITTEN CONSENT OF THE COMPANY, AND SHALL BE RETURNED UPON REQUEST.

REVISION	BY

**Bell Electrical Contractors**  
 128 MILLELL  
 MARYLAND HEIGHTS, MO. 63046  
 TELE. NO. 314-798-7744  
 FAX NO. 314-798-0717

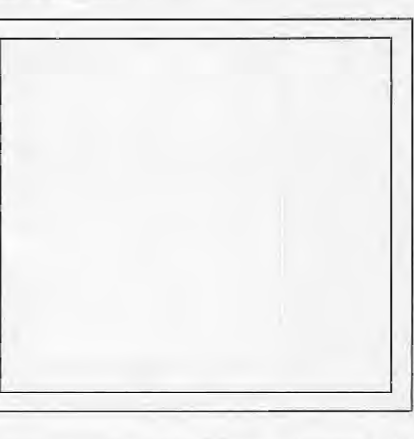

**SYNERGETICS, INC.**  
 O'FALLON CORP. CENTRE  
 O'FALLON, MISSOURI

**DRAWN BY:**  
 RE PROPS

**CHECKED BY:**  
 JB

**DATE:**  
 11/01/04

**SCALE:**  
 AS NOTED

**JOB NO.**

**SHEET**  
**PXP-1**  
 OF SHEETS

DISCLAIMER OF RESPONSIBILITY: I hereby specify that this document is submitted by my seal. I hereby disclaim any responsibility for all other plans, specifications, estimates, reports, or other documents or instruments relating to or intended to be used for any part or parts of the architectural or engineering project or survey. Bell Electrical Contractors, Inc. Douglas T. Feneck, Missouri Engineer License E-5898