


DATE: Apr 20, 2005 2:35pm
 DRAWING: S:\055\05052005\05-017\REC'D\SITE LIGHTING_PLAN_4_20_05\05\0501.dwg

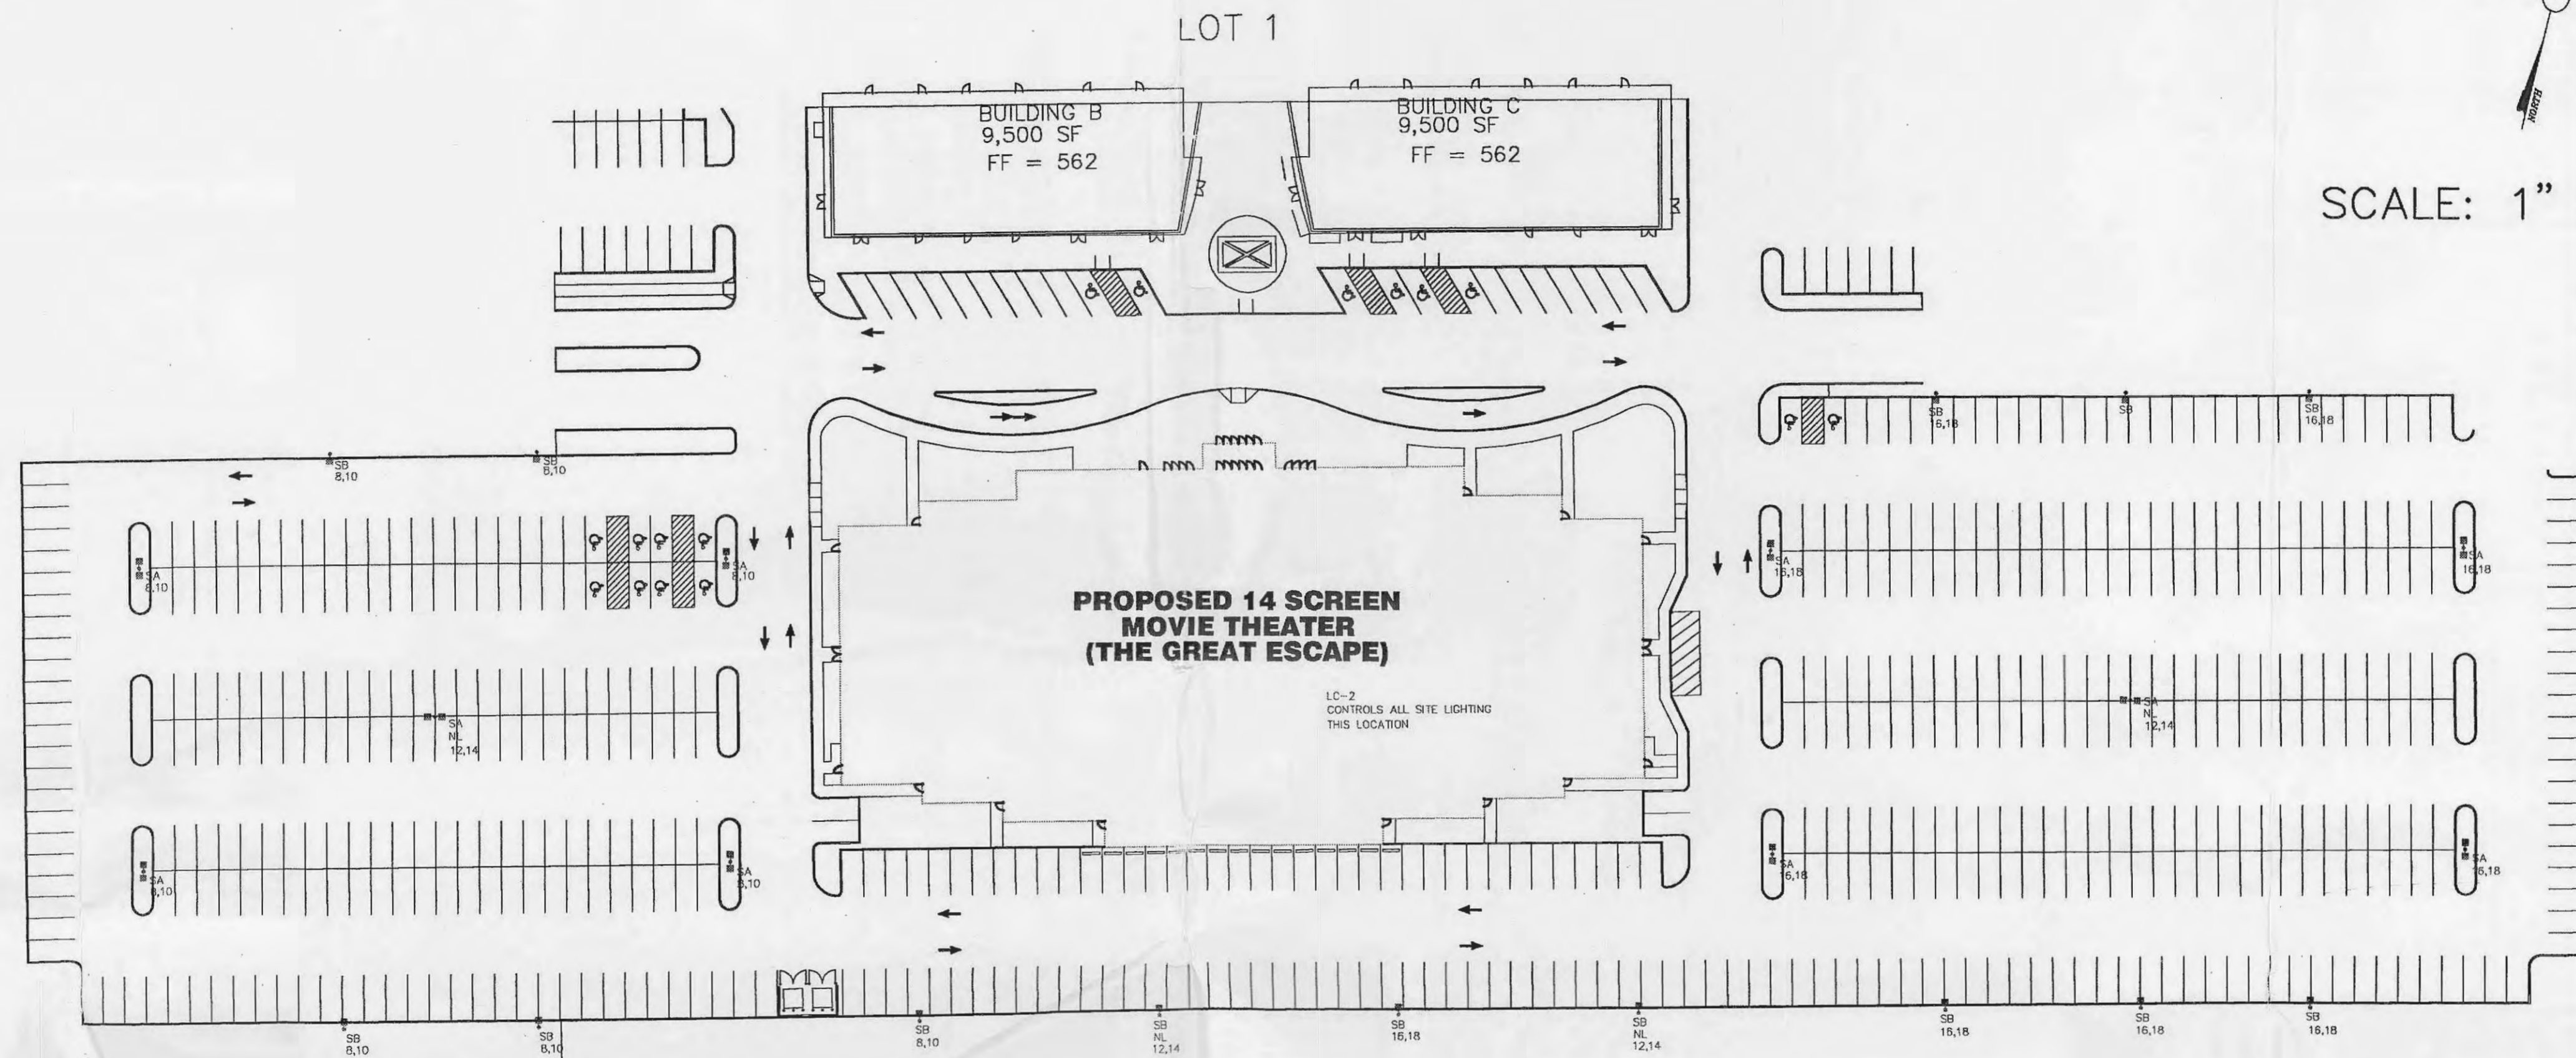

SCALE: 1" = 50'-0"

LIGHT FIXTURE SCHEDULE

- SA TWIN LUMINAIRE 400W METAL HALIDE FORWARD THROW SHARP CUTOFF 480V MOUNTED ON 25' ROUND POLE DARK BRONZE FINISH
- SB SINGLE LUMINAIRE 400W METAL HALIDE FORWARD THROW SHARP CUTOFF 480V MOUNTED ON 25' ROUND POLE DARK BRONZE FINISH
- NL NIGHT LIGHT CIRCUIT

IMPORTANT NOTE

THIS DRAWING IS FOR EXCLUSIVE USE OF BRINER ELECTRIC CO.
 ANY OTHER USE IS STRICTLY PROHIBITED

BRINER ELECTRIC CO.
 2466 OLD DORSETT RD.
 MARYLAND HEIGHTS, MO 63043
 314-298-0800
ELECTRIC
Serving St. Louis Electrically Since 1895

REVISIONS		
DATE	DESC.	BY
3/25/05	CITY OF OFALLON COMMENTS	
3/29/05	CITY OF OFALLON COMMENTS	
4/20/05	CADREXAL COORDINATION OF UTILITIES	

DEVELOPER/OWNER:
ALLIANCE ENTERTAINMENT COMPANY
 300 PROFESSIONAL COURT
 NEW ALBANY IN. 47705
 (812) 945-4006

SEAL:
 THE PROFESSIONAL WHOSE SIGNATURE AND PERSONAL SEAL APPEAR HEREON ASSUMES RESPONSIBILITY ONLY FOR WHAT APPEARS ON THIS PAGE, AND DISCLAIMS LIABILITY FOR ANY ERRORS OR OMISSIONS IN ANY OTHER PARTS OF THE PROJECT. THIS DOCUMENT IS NOT TO BE USED FOR ANY PART OF THE PROJECT TO WHICH THIS PAGE APPEARS.

THE GREAT ESCAPE
 HIGHWAY 40/61 AND WINGHAVEN
 O'FALLON, MO 63066

SITE LIGHTING PLAN

planning • engineering • surveying • landscape architecture
Cole and ASSOCIATES
 INCORPORATED
 10777 sunset office dr. suite 10
 saint louis, missouri
 p: 314 984 9887 f: 314 984 0587

DESIGNED BY: BE
 DRAWN BY: BE
 CHECKED BY: BE
 DATE: 2/7/05

Job Number
05-017
 Sheet Number
SE-1