



1
24 SECTION THRU SOUTH WALL @ DRIVE-THRU DOOR
SCALE: 3/4" = 1'-0"

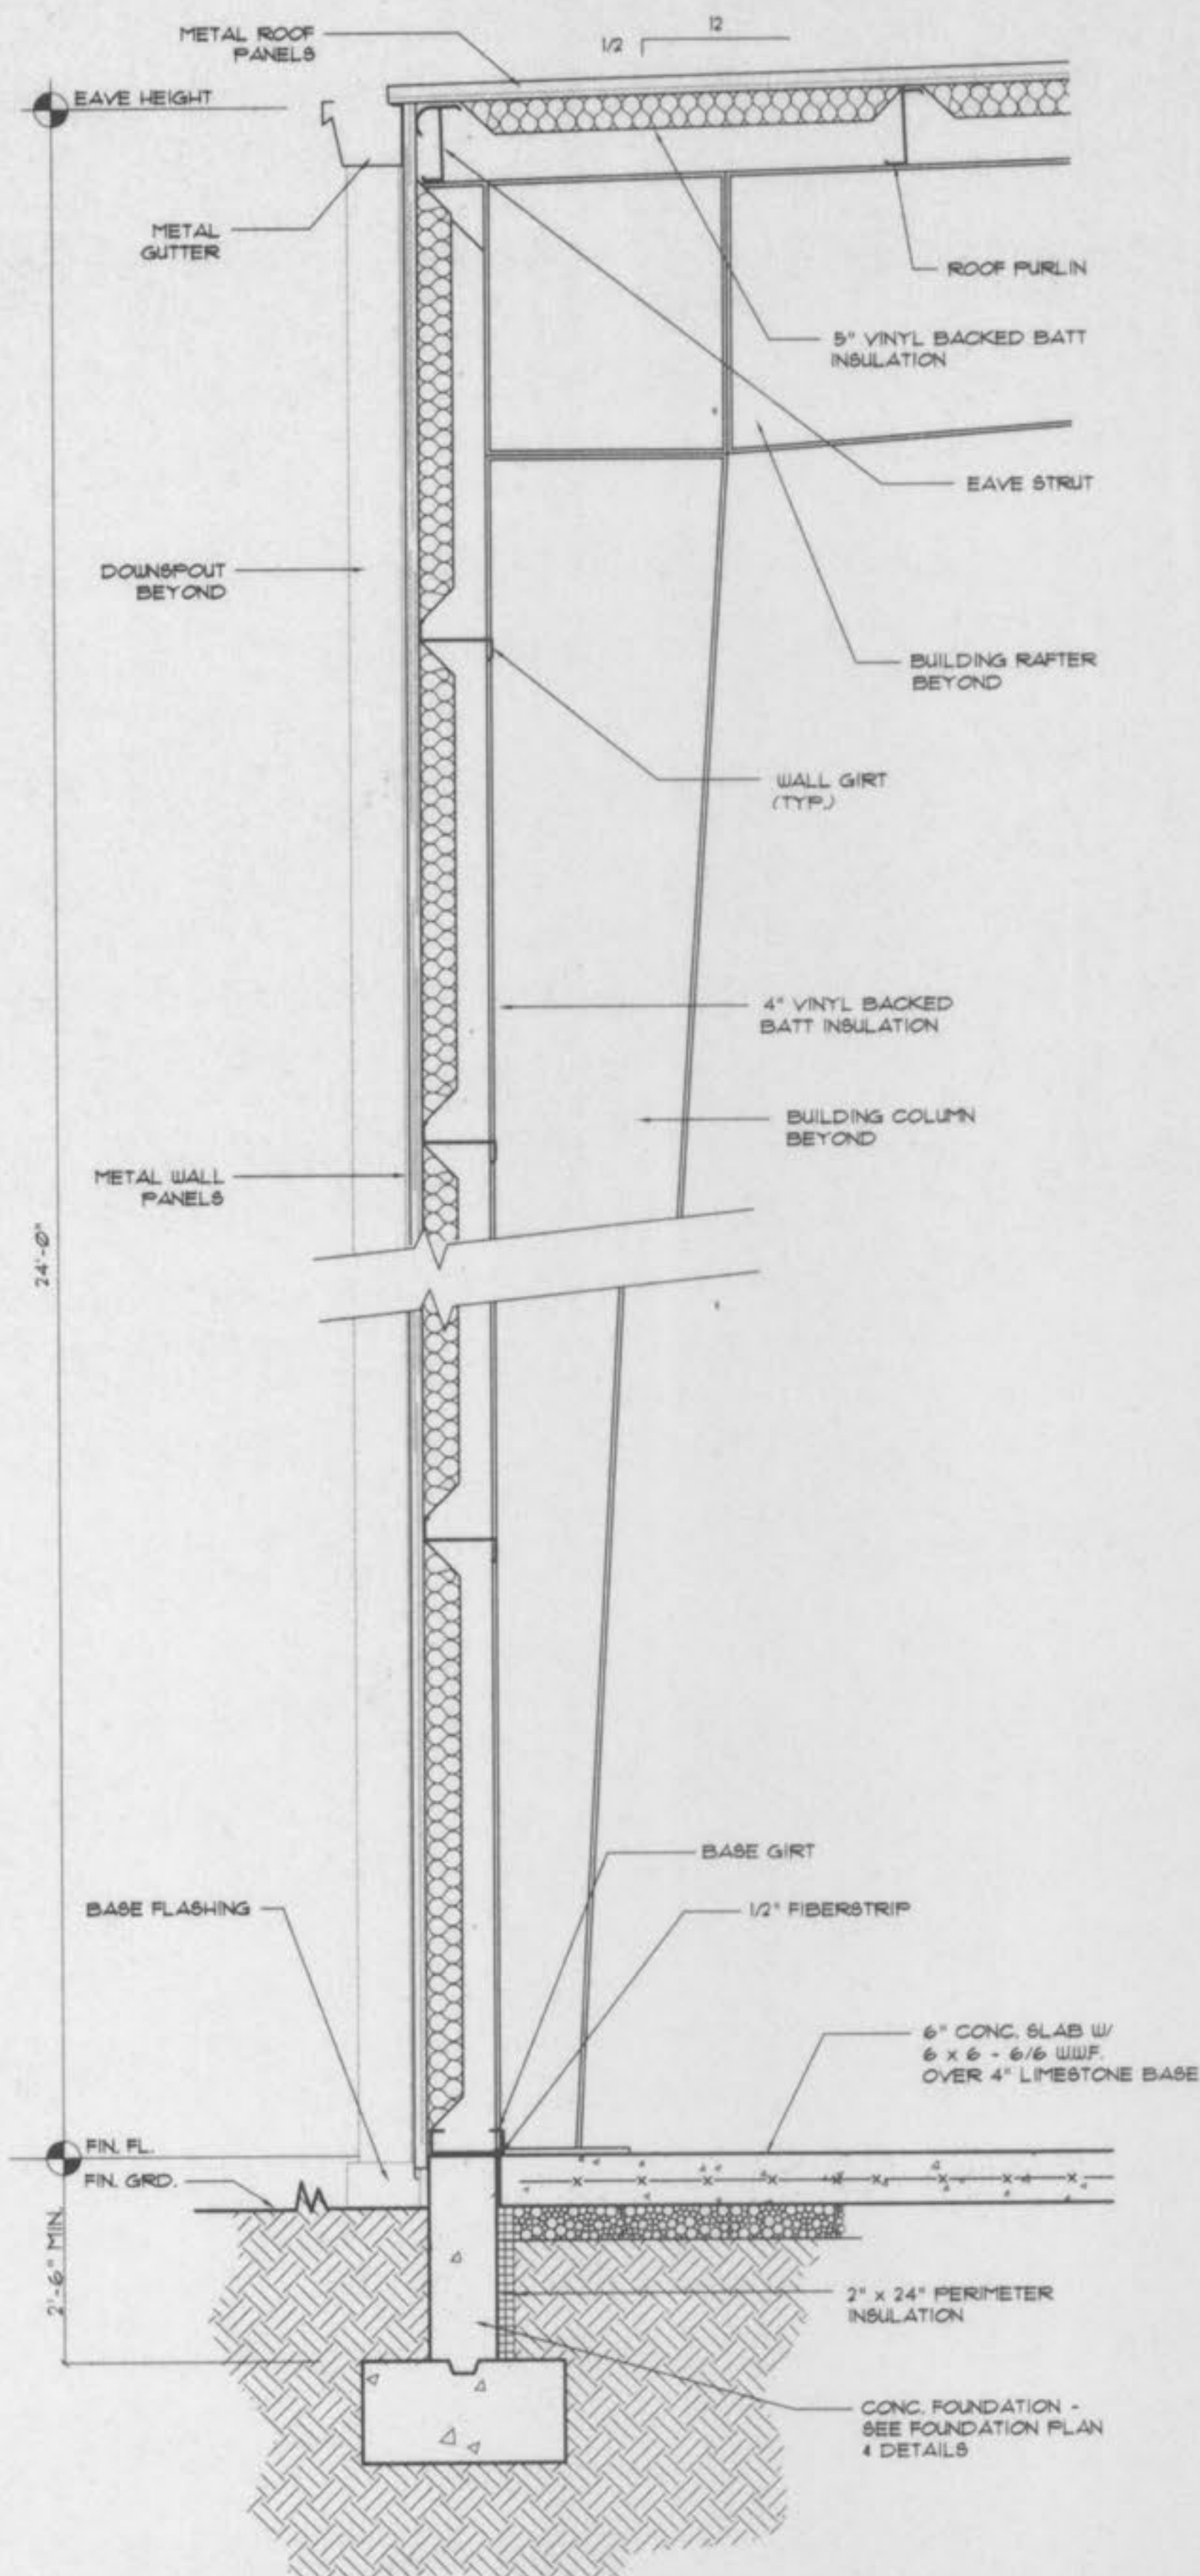

2
24 SECTION THRU SIDEWALL
SCALE: 3/4" = 1'-0"

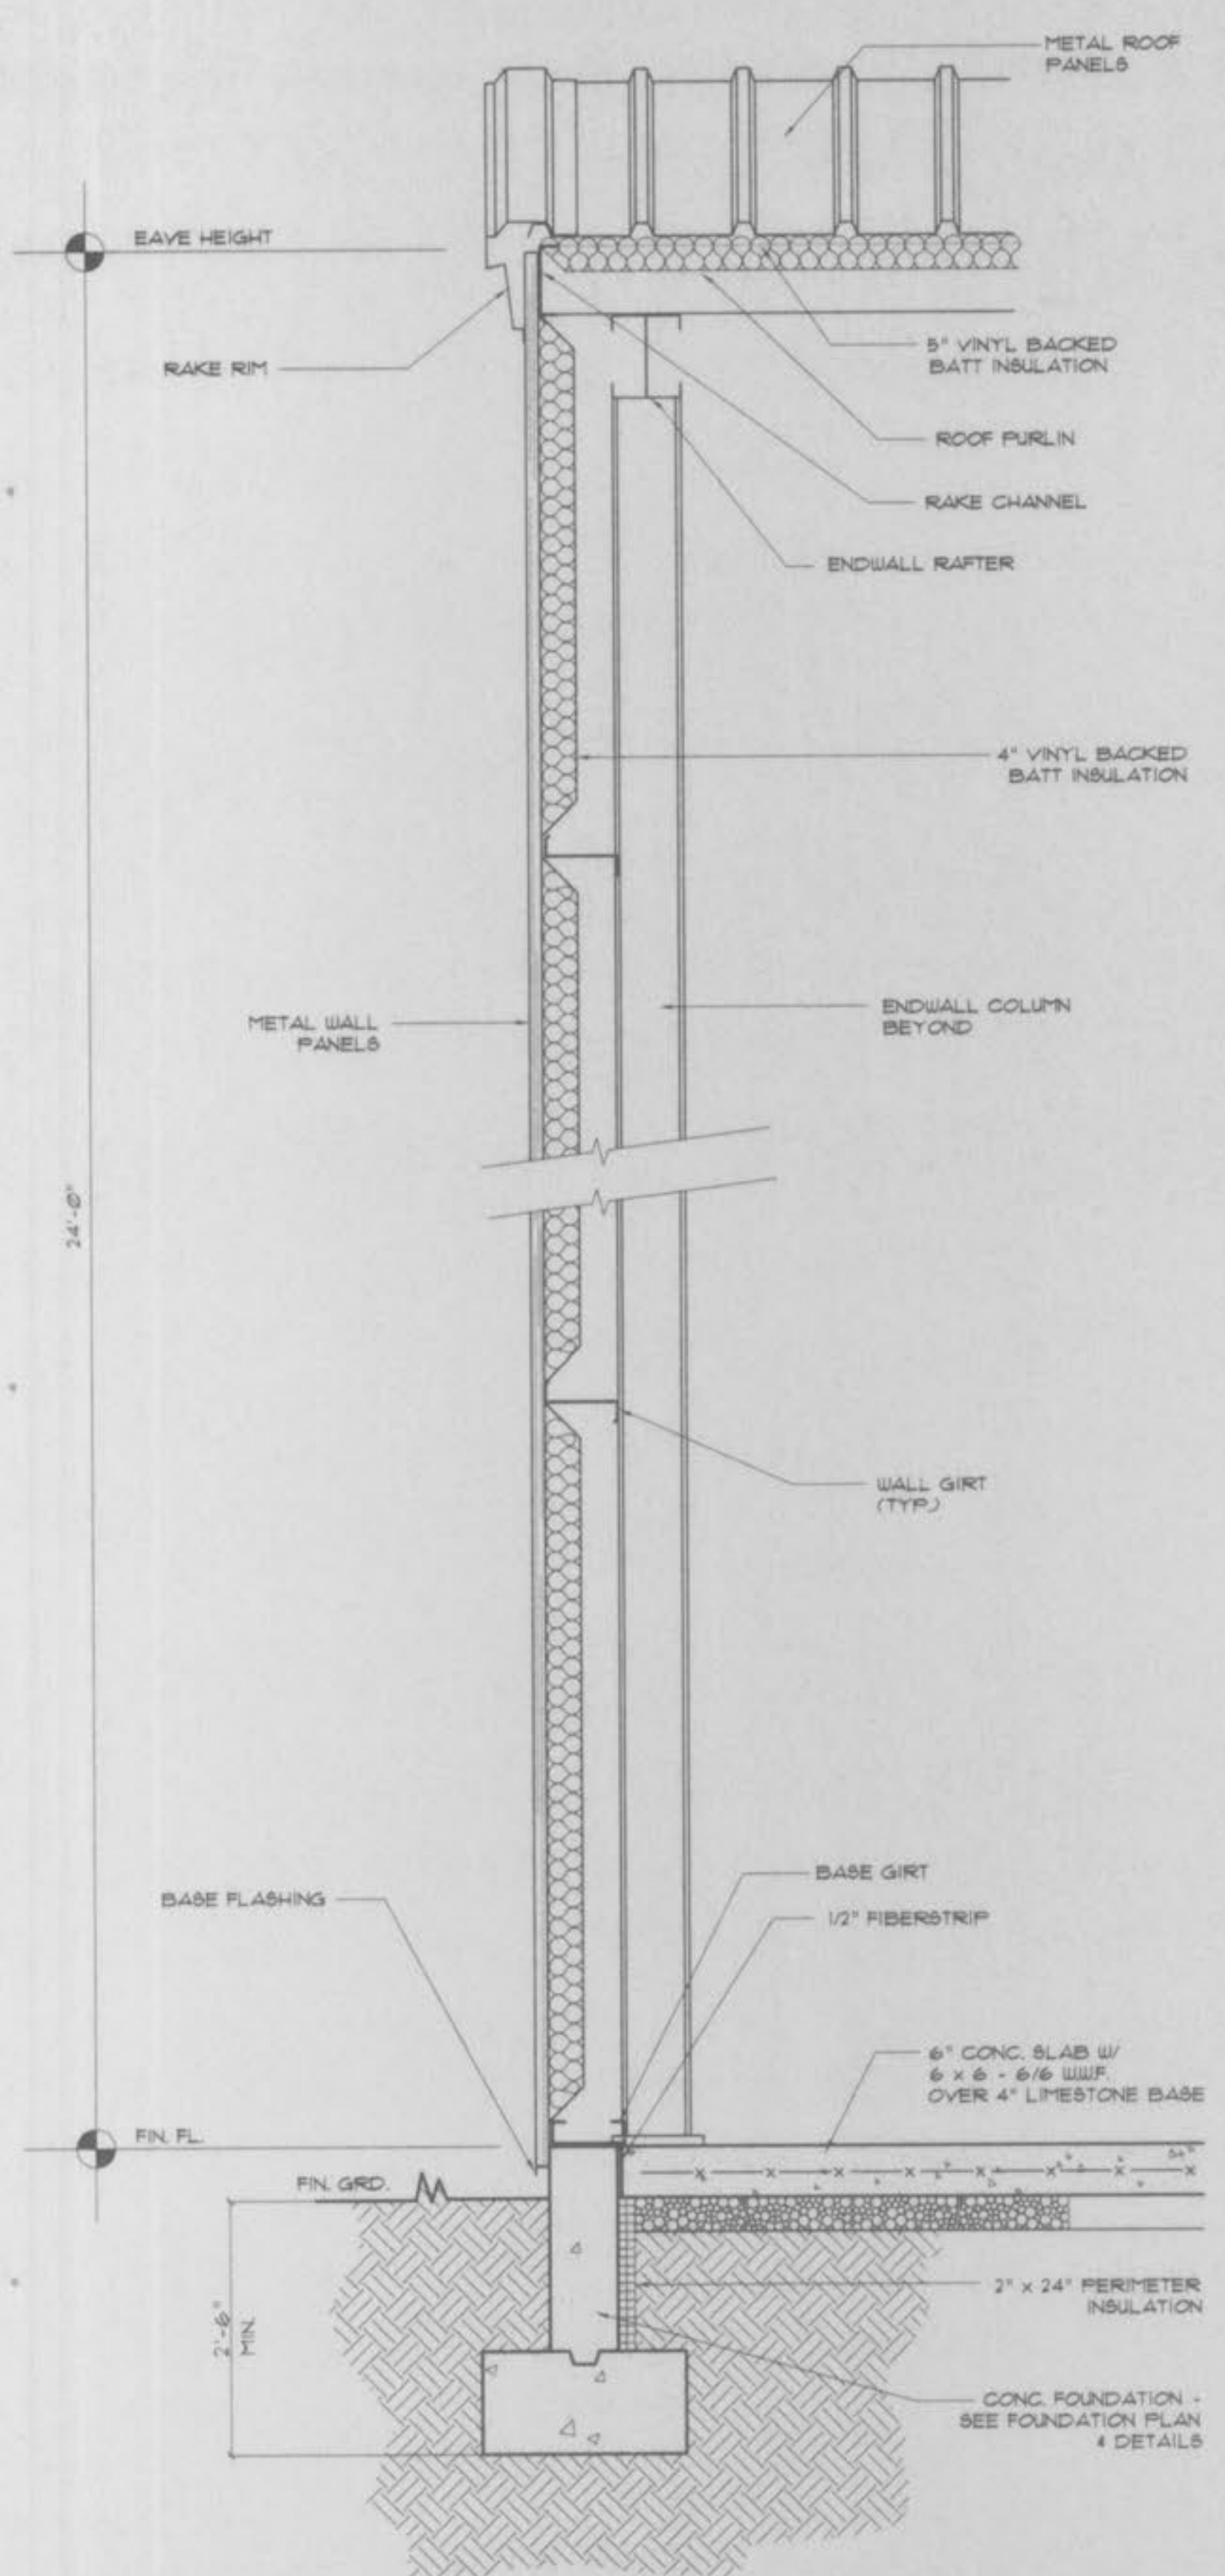

3
24 SECTION THRU WEST ENDWALL
SCALE: 3/4" = 1'-0"

NO.	DESCRIPTION	DATE
REVISIONS		



STRUCTURAL SYSTEMS, INC.

DESIGN CONTRACTORS



(314) 966-5920

816 South Kirkwood Road
St. Louis, Missouri 63122

Proposed Building for:
TRUE & TRUE
Hoff Road
O'Fallon, MO 63366
(636) 272-1100

WALL SECTIONS

DRAWN	R.R.R.
CHECKED	
SCALE	AS NOTED
ISSUE DATE	06/13/01
SSI JOB NUMBER	01-205
DRAWING NUMBER	

4 of 9

C:\Program Files\Autodesk\AutoCAD 2005\Draw Files\1005-4.dwg, Tue Jun 19 14:33:41 2001.