




- 1 FURNISH & INSTALL (2) 1000 WATT, 120V, METAL-HALIDE FLOODLIGHT, ARCHITECTURAL LANDSCAPE LIGHTING NO. FL-01-K-1000-MH-120-7HBV-AH. PROVIDE CONCRETE MOUNTING BASE.
- 2 CONNECT TO SPARE 20A, 1P CIRCUIT BREAKER IN PANELBOARD.

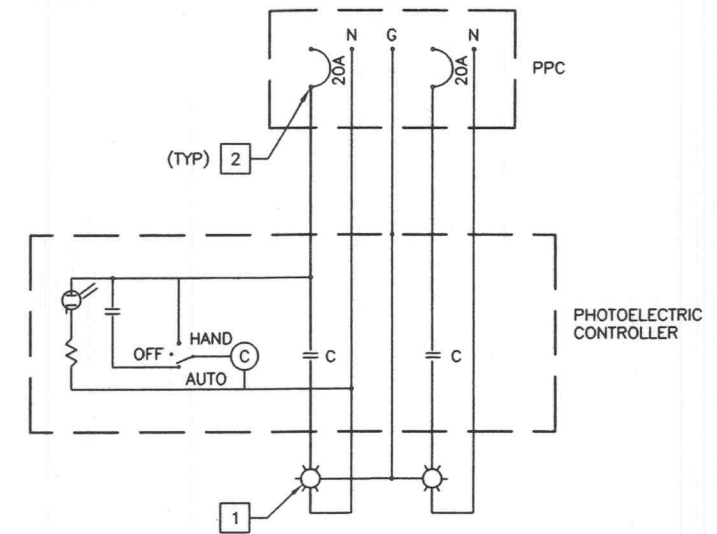

6 PHOTOELECTRIC CONTROL SCHEMATIC 4

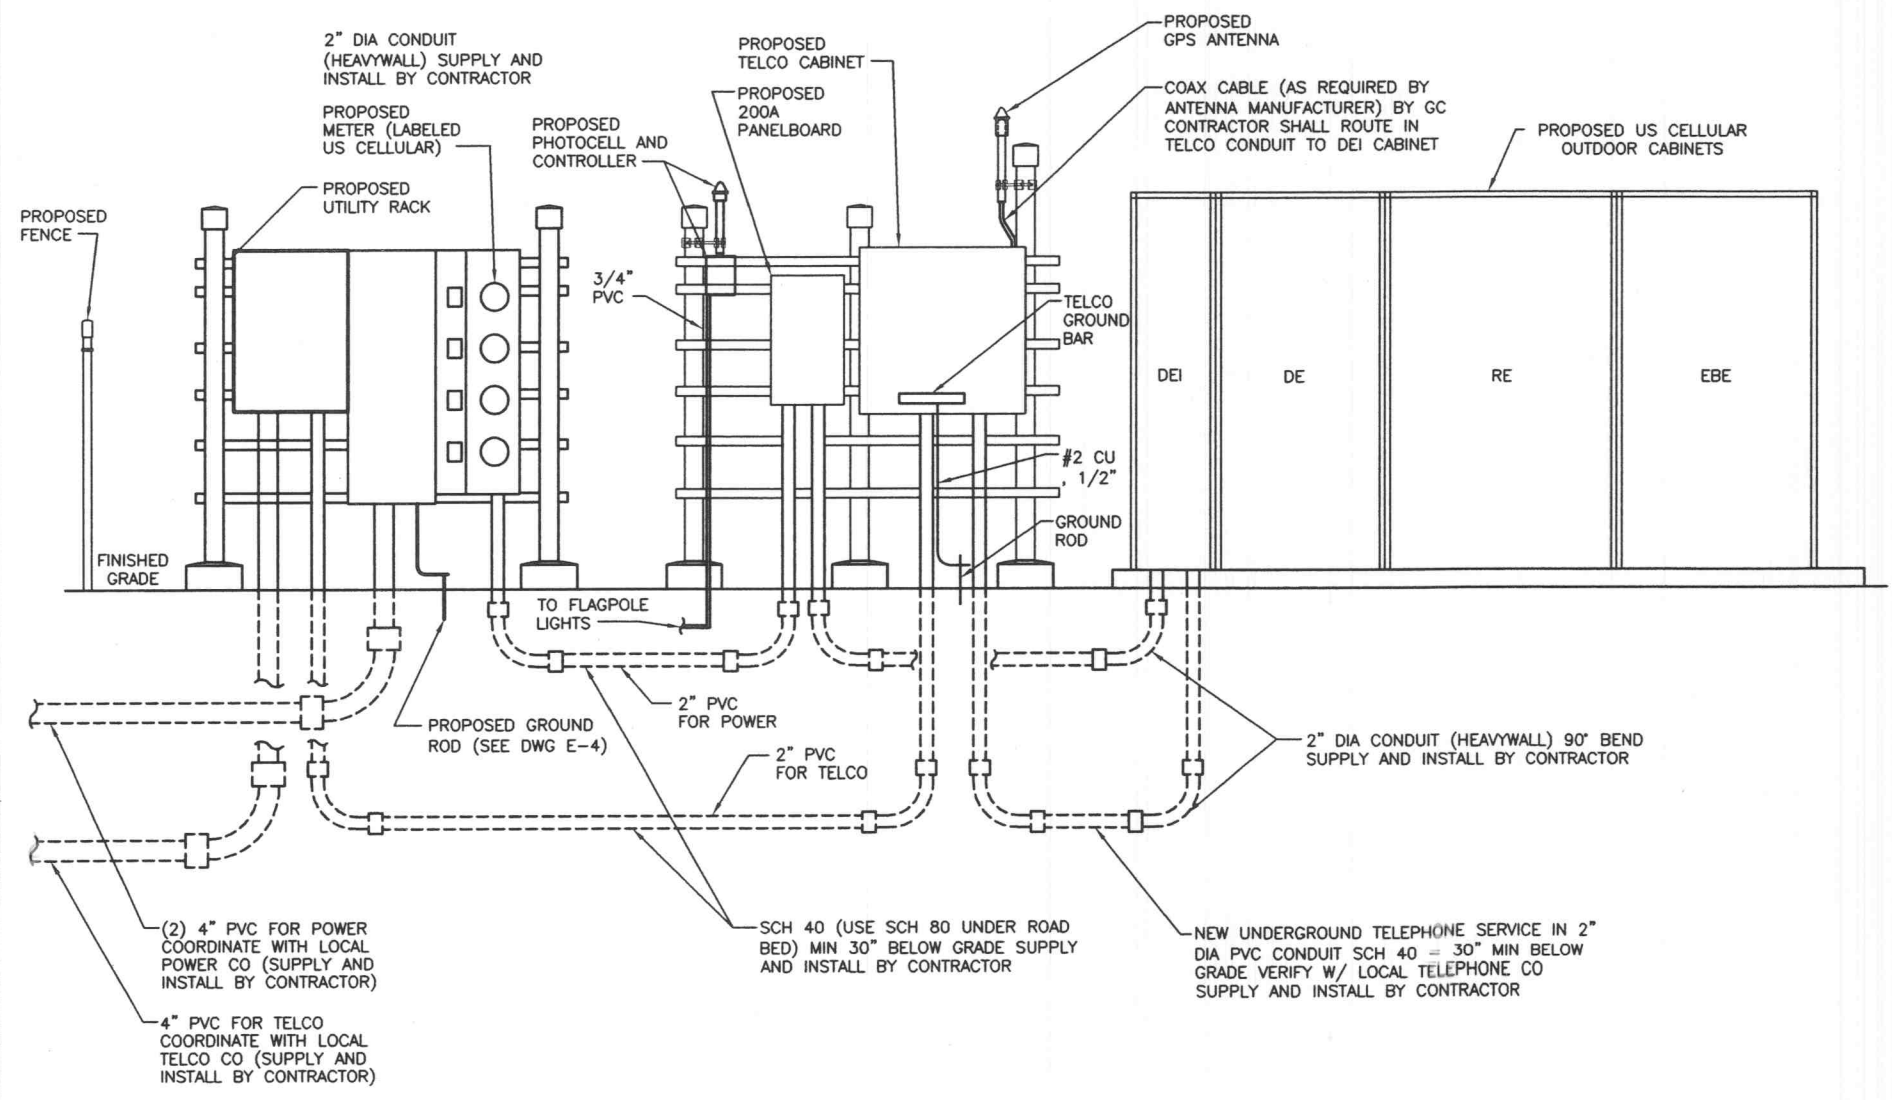


5 ELECTRICAL RISER DIAGRAM

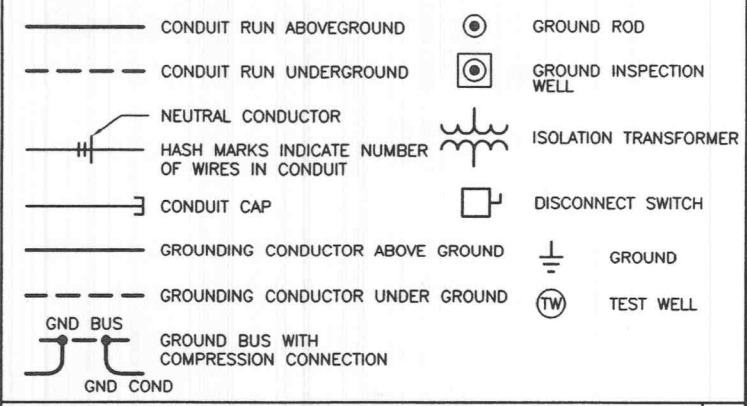

1 ELECTRICAL SYMBOLS

NO.	FROM	TO	CONFIGURATION
1	EXISTING SOURCE	METER CENTER ON UTILITY RACK	(2) 3# 500KCMIL IN 4" PVC
2	METER CENTER ON UTILITY RACK	200A PANELBOARD	3#3/0, 1#6G, 2" PVC
3	200A PANELBOARD	DCI (LOAD CENTER)	3#2, 1#8G, 2" PVC
4	200A PANELBOARD	PHOTOELECTRIC CONTROLLER	4#10, 1#10G IN 3/4" PVC
5	PHOTOELECTRIC CONTROLLER	FLAGPOLE LIGHT #1	4#10, 1#10G IN 3/4" PVC
6	FLAGPOLE LIGHT #1	FLAGPOLE LIGHT #2	2#10, 1#10G IN 3/4" PVC

2 CIRCUIT SCHEDULE


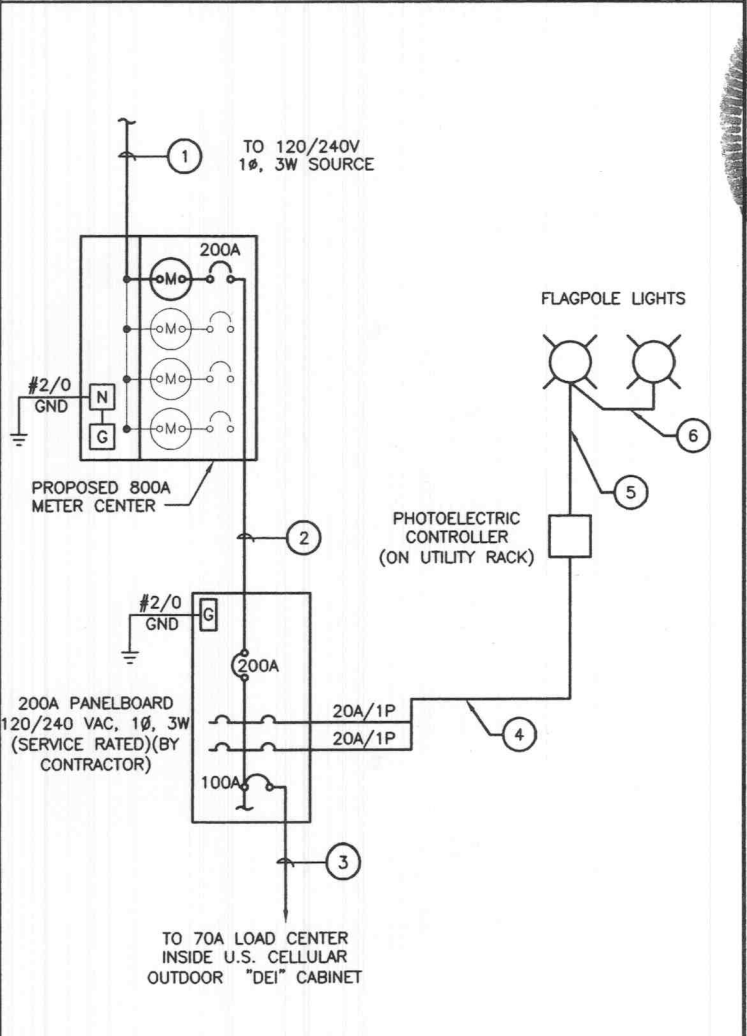


3 ONE-LINE DIAGRAM



SELECTIVE SITE CONSULTANTS, INC.
 A Site Assessment, Engineering, and Construction Quality Assurance Company
 1816 Lackland Hills Parkway, Suite 400
 St. Louis, Missouri 63146
 Phone: 314-993-1010
 Fax: 314-993-1036

CIS COMMUNICATIONS, LLC
 165 N MERAMEC AVE, STE. 400
 CLAYTON, MO 63105
 OFFICE: 314-727-5405
 FAX: 314-727-8503
 TOLL FREE: 877-720-8600

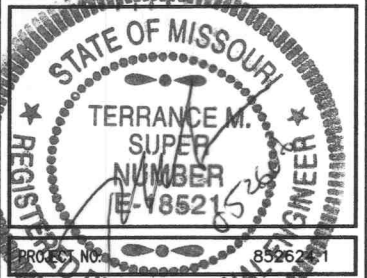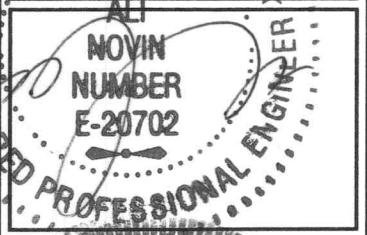

PROJECT NO: 85262-1
 DRAWN BY: ANP
 CHECKED BY: HAN

SUBMITTALS		
A	05/23/06	ISSUED FOR REVIEW ANP
0	05/25/06	ISSUED FOR CONSTRUCTION ANP

THE INFORMATION CONTAINED IN THIS SET OF DOCUMENTS IS PROPRIETARY BY NATURE. ANY USE OR DISCLOSURE OTHER THAN THAT WHICH RELATES TO US CELLULAR COMMUNICATIONS INC. IS STRICTLY PROHIBITED.

SITE NAME
MEXICO AND HIGHWAY K
 8621-8635 MEXICO ROAD
 O'FALLON, MISSOURI 63304

SHEET TITLE
ELECTRICAL RISER DIAGRAM AND DETAILS

SHEET NUMBER
E-2