




PRIMARY CLARIFIER NO. 1
FOUNDATION PLAN
 Scale: 1/4" = 1'-0"

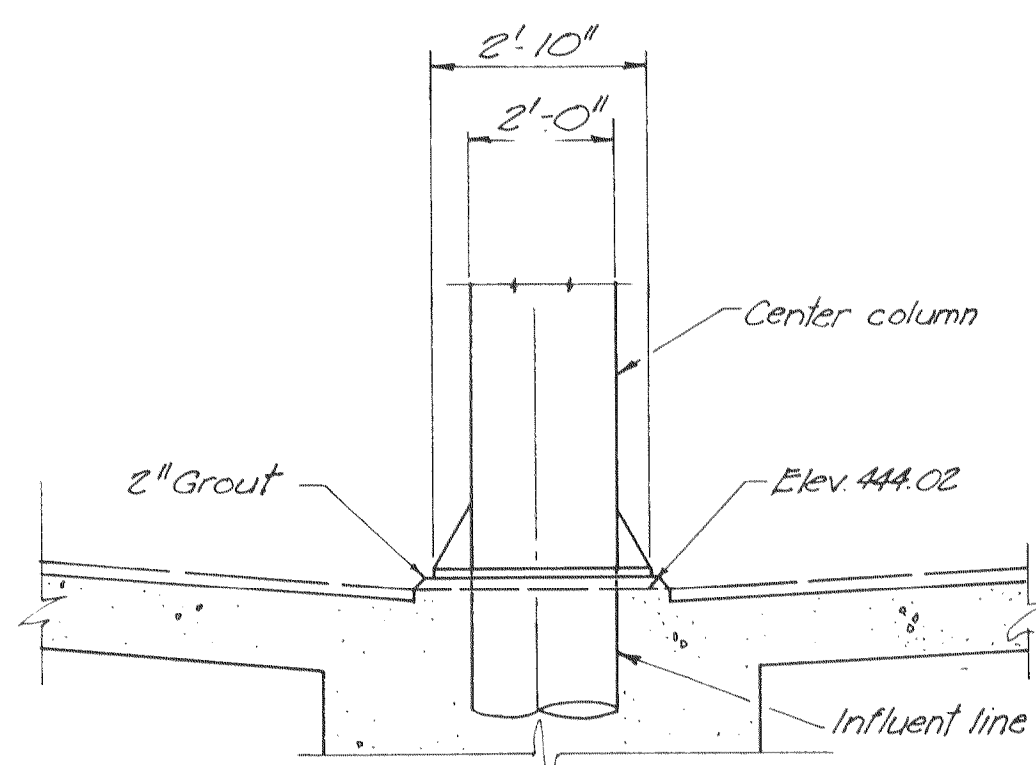

CENTER COLUMN SUPPORT
 Scale: 3/8" = 1'-0"

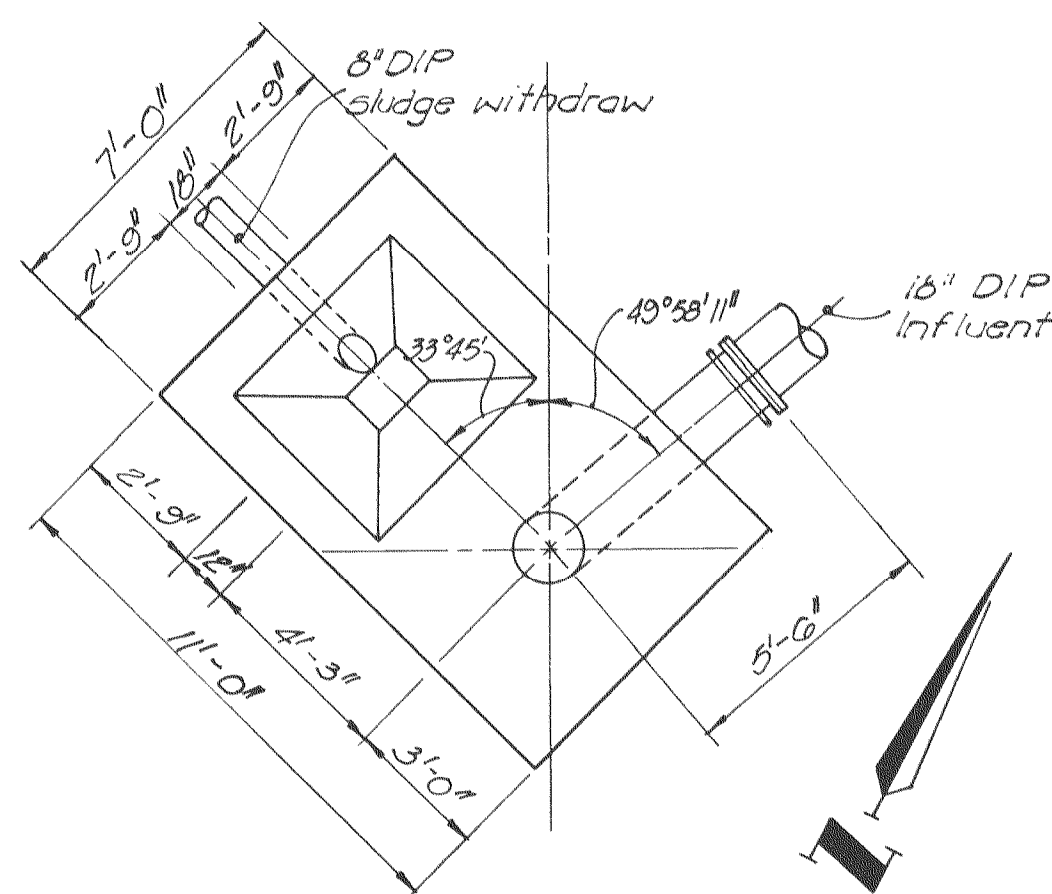


PRIMARY CLARIFIER NO. 2
FOUNDATION PLAN
 Scale: 1/4" = 1'-0"

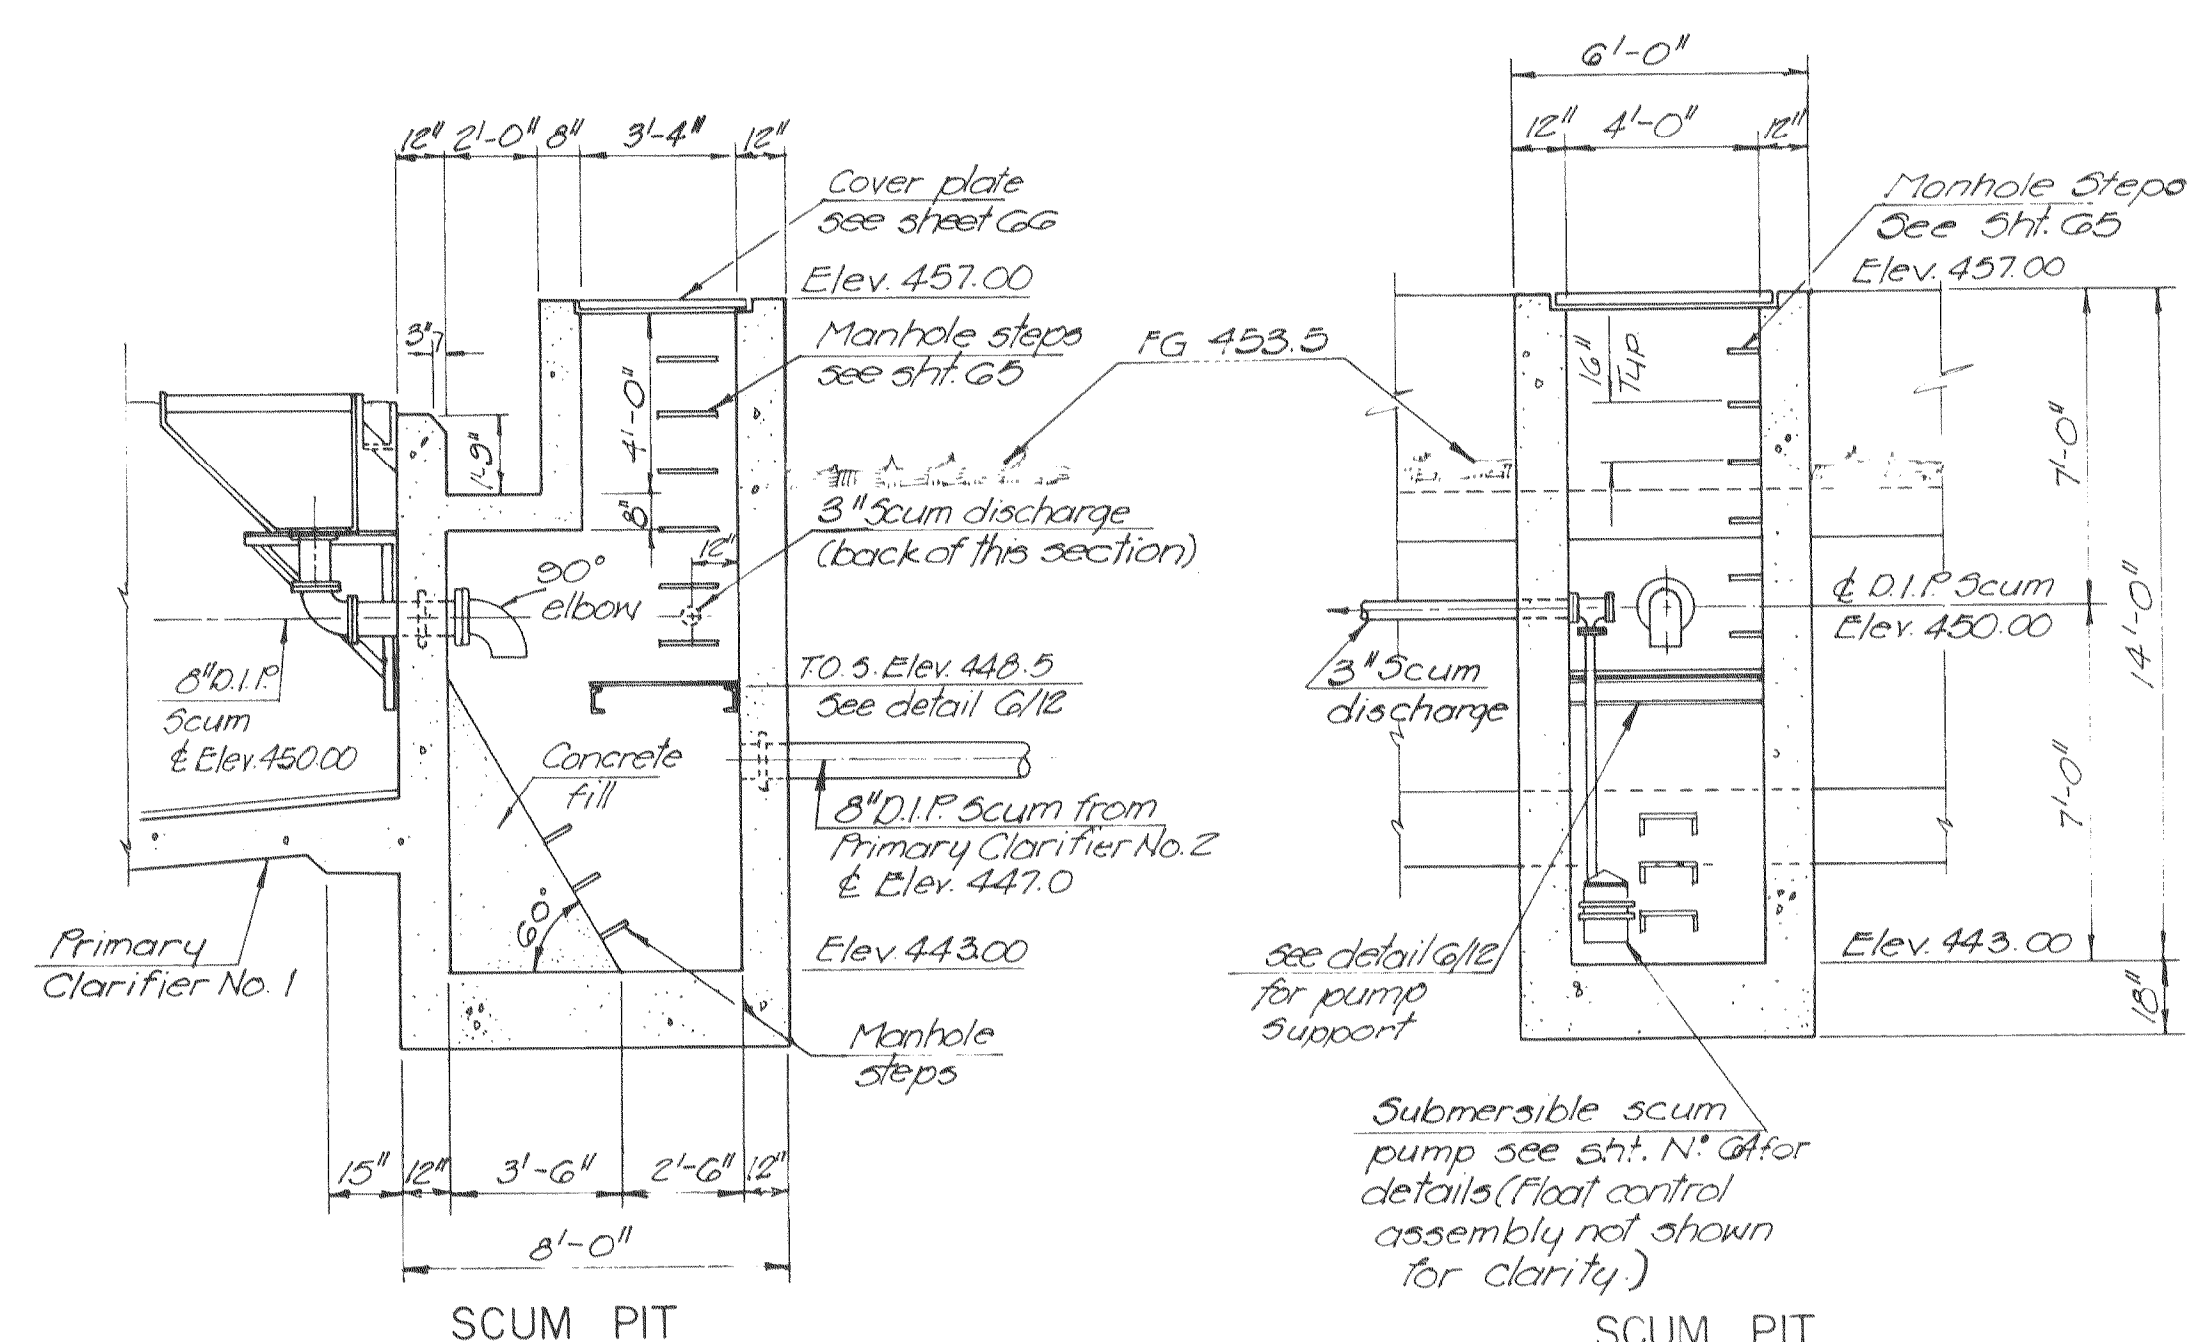


SCUM PIT
SECTION 2
 Scale: 1/4" = 1'-0"
 (Re. sht. 10)

SCUM PIT
SECTION 3
 Scale: 1/4" = 1'-0"
 (Re. sht. 10)

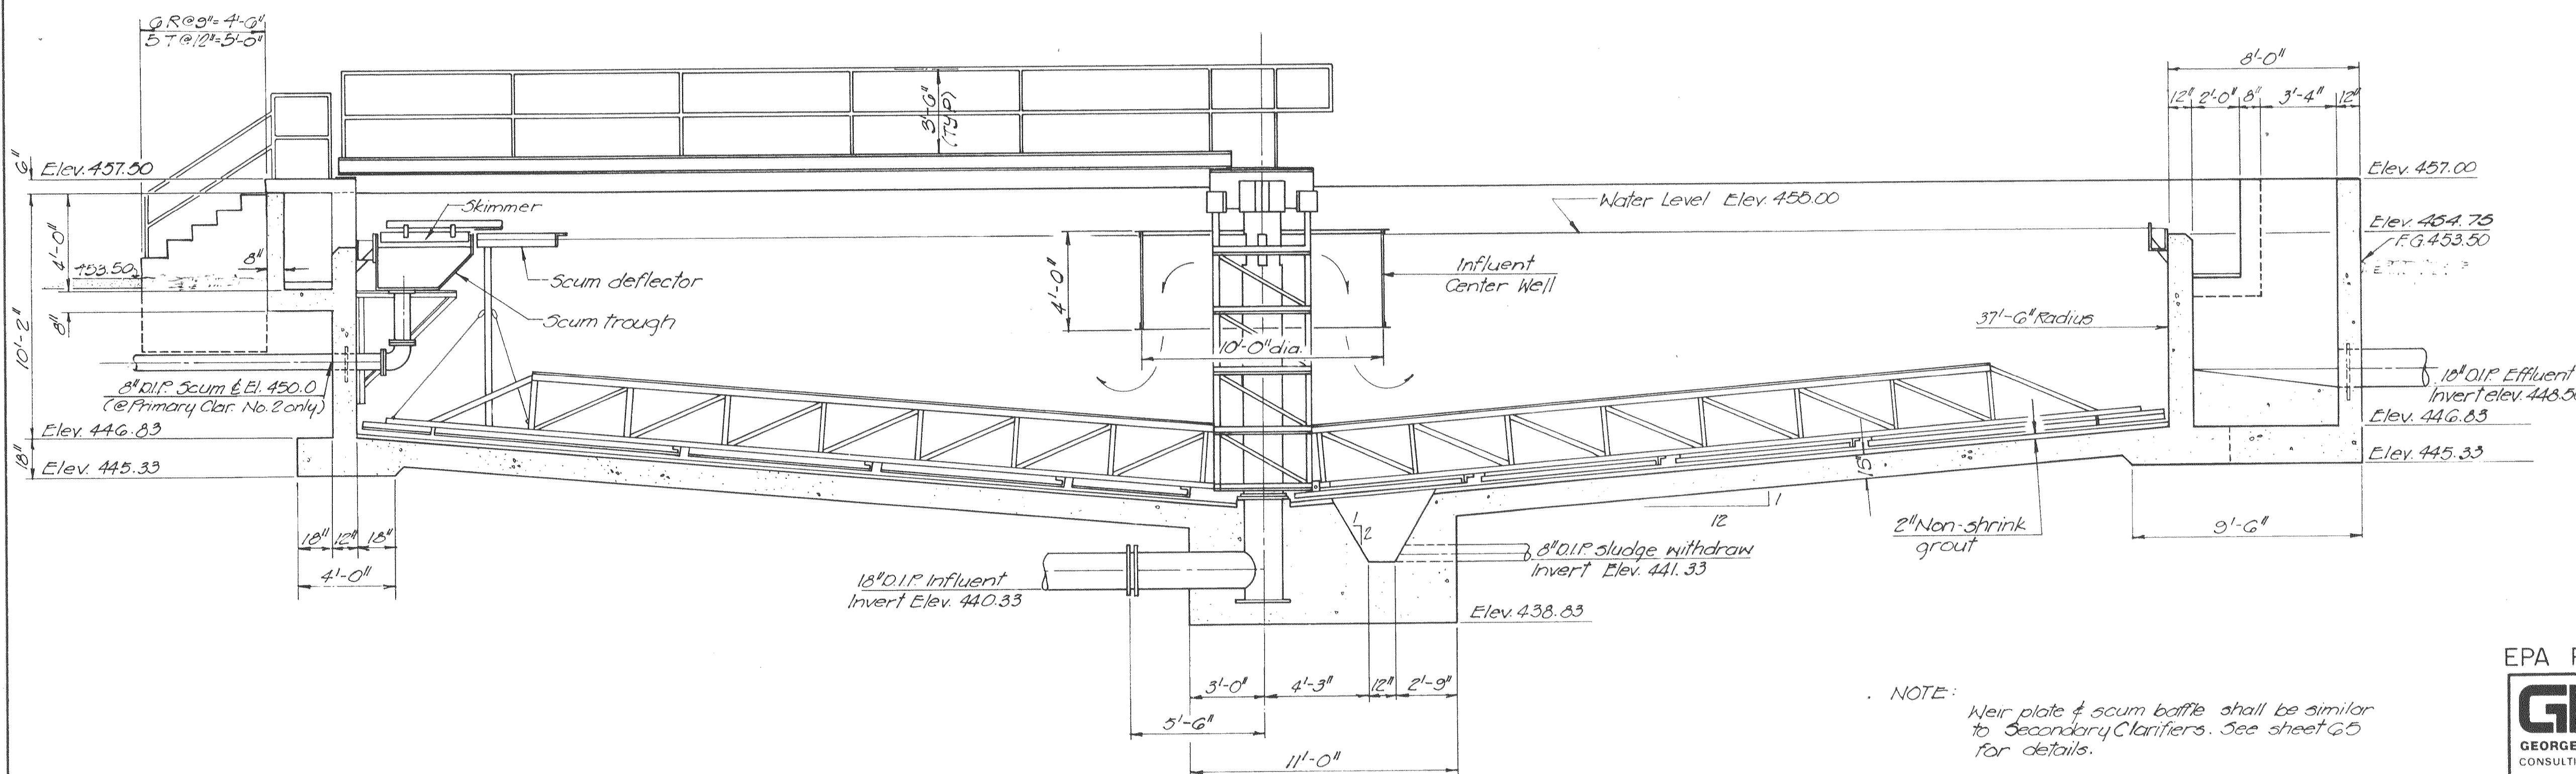

TYPICAL PRIMARY CLARIFIER

SECTION 1
 Scale: 1/4" = 1'-0"
 (Re. sht. 10)

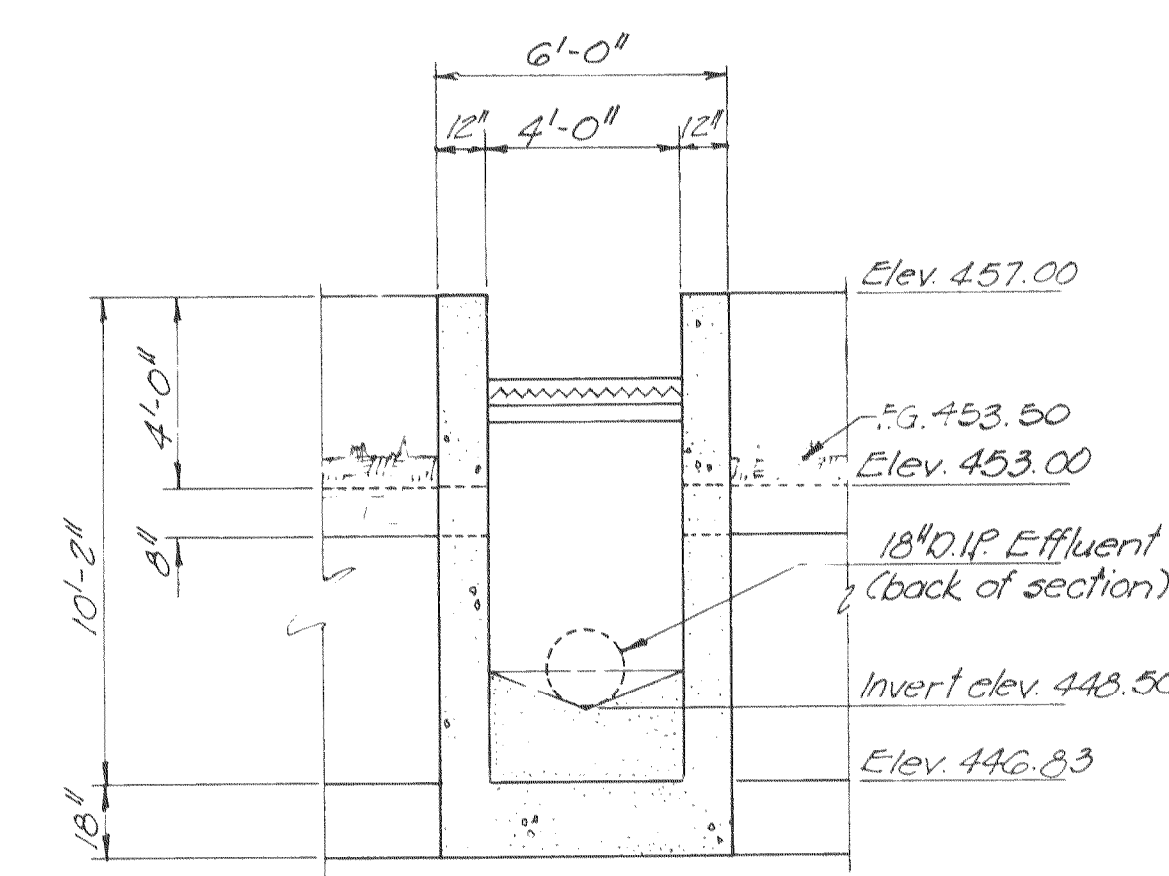

EFFLUENT BOX
SECTION 4
 Scale: 1/4" = 1'-0"
 (Re. sht. 10)

NOTE: Weir plate & scum baffle shall be similar to Secondary Clarifiers. See sheet 65 for details.

EPA PROJECT NO. C29109C

Rev. 2-82 MKK

GBA
 GEORGE BUTLER ASSOCIATES
 CONSULTING ENGINEERS / ARCHITECTS
 LANDSCAPE ARCHITECTS / PLANNERS

OFFICES:
 SUITE 300-A MAINWAY OFFICE CENTER
 4210 JOHNSON DRIVE / SHAWNEE MISSION, KANSAS 66205
 1100 CITY CENTER SQUARE
 1100 MAIN / KANSAS CITY, MISSOURI 64105
 SUITE 134 LAKESIDE PLAZA II
 6700 CORPORATE DRIVE / KANSAS CITY, MISSOURI 64120

WASTEWATER TREATMENT
 PLANT EXPANSION
**PRIMARY CLARIFIER
 SECTIONS**

CITY OF FALLON, MISSOURI

DESIGNED BY WCC/LS DRAWN BY C. Raya CHECKED BY W.A.C.

JOB NO. 72-2025
 DATE July 30, 1981
 SCALE As shown
 SHEET 11 OF 88