
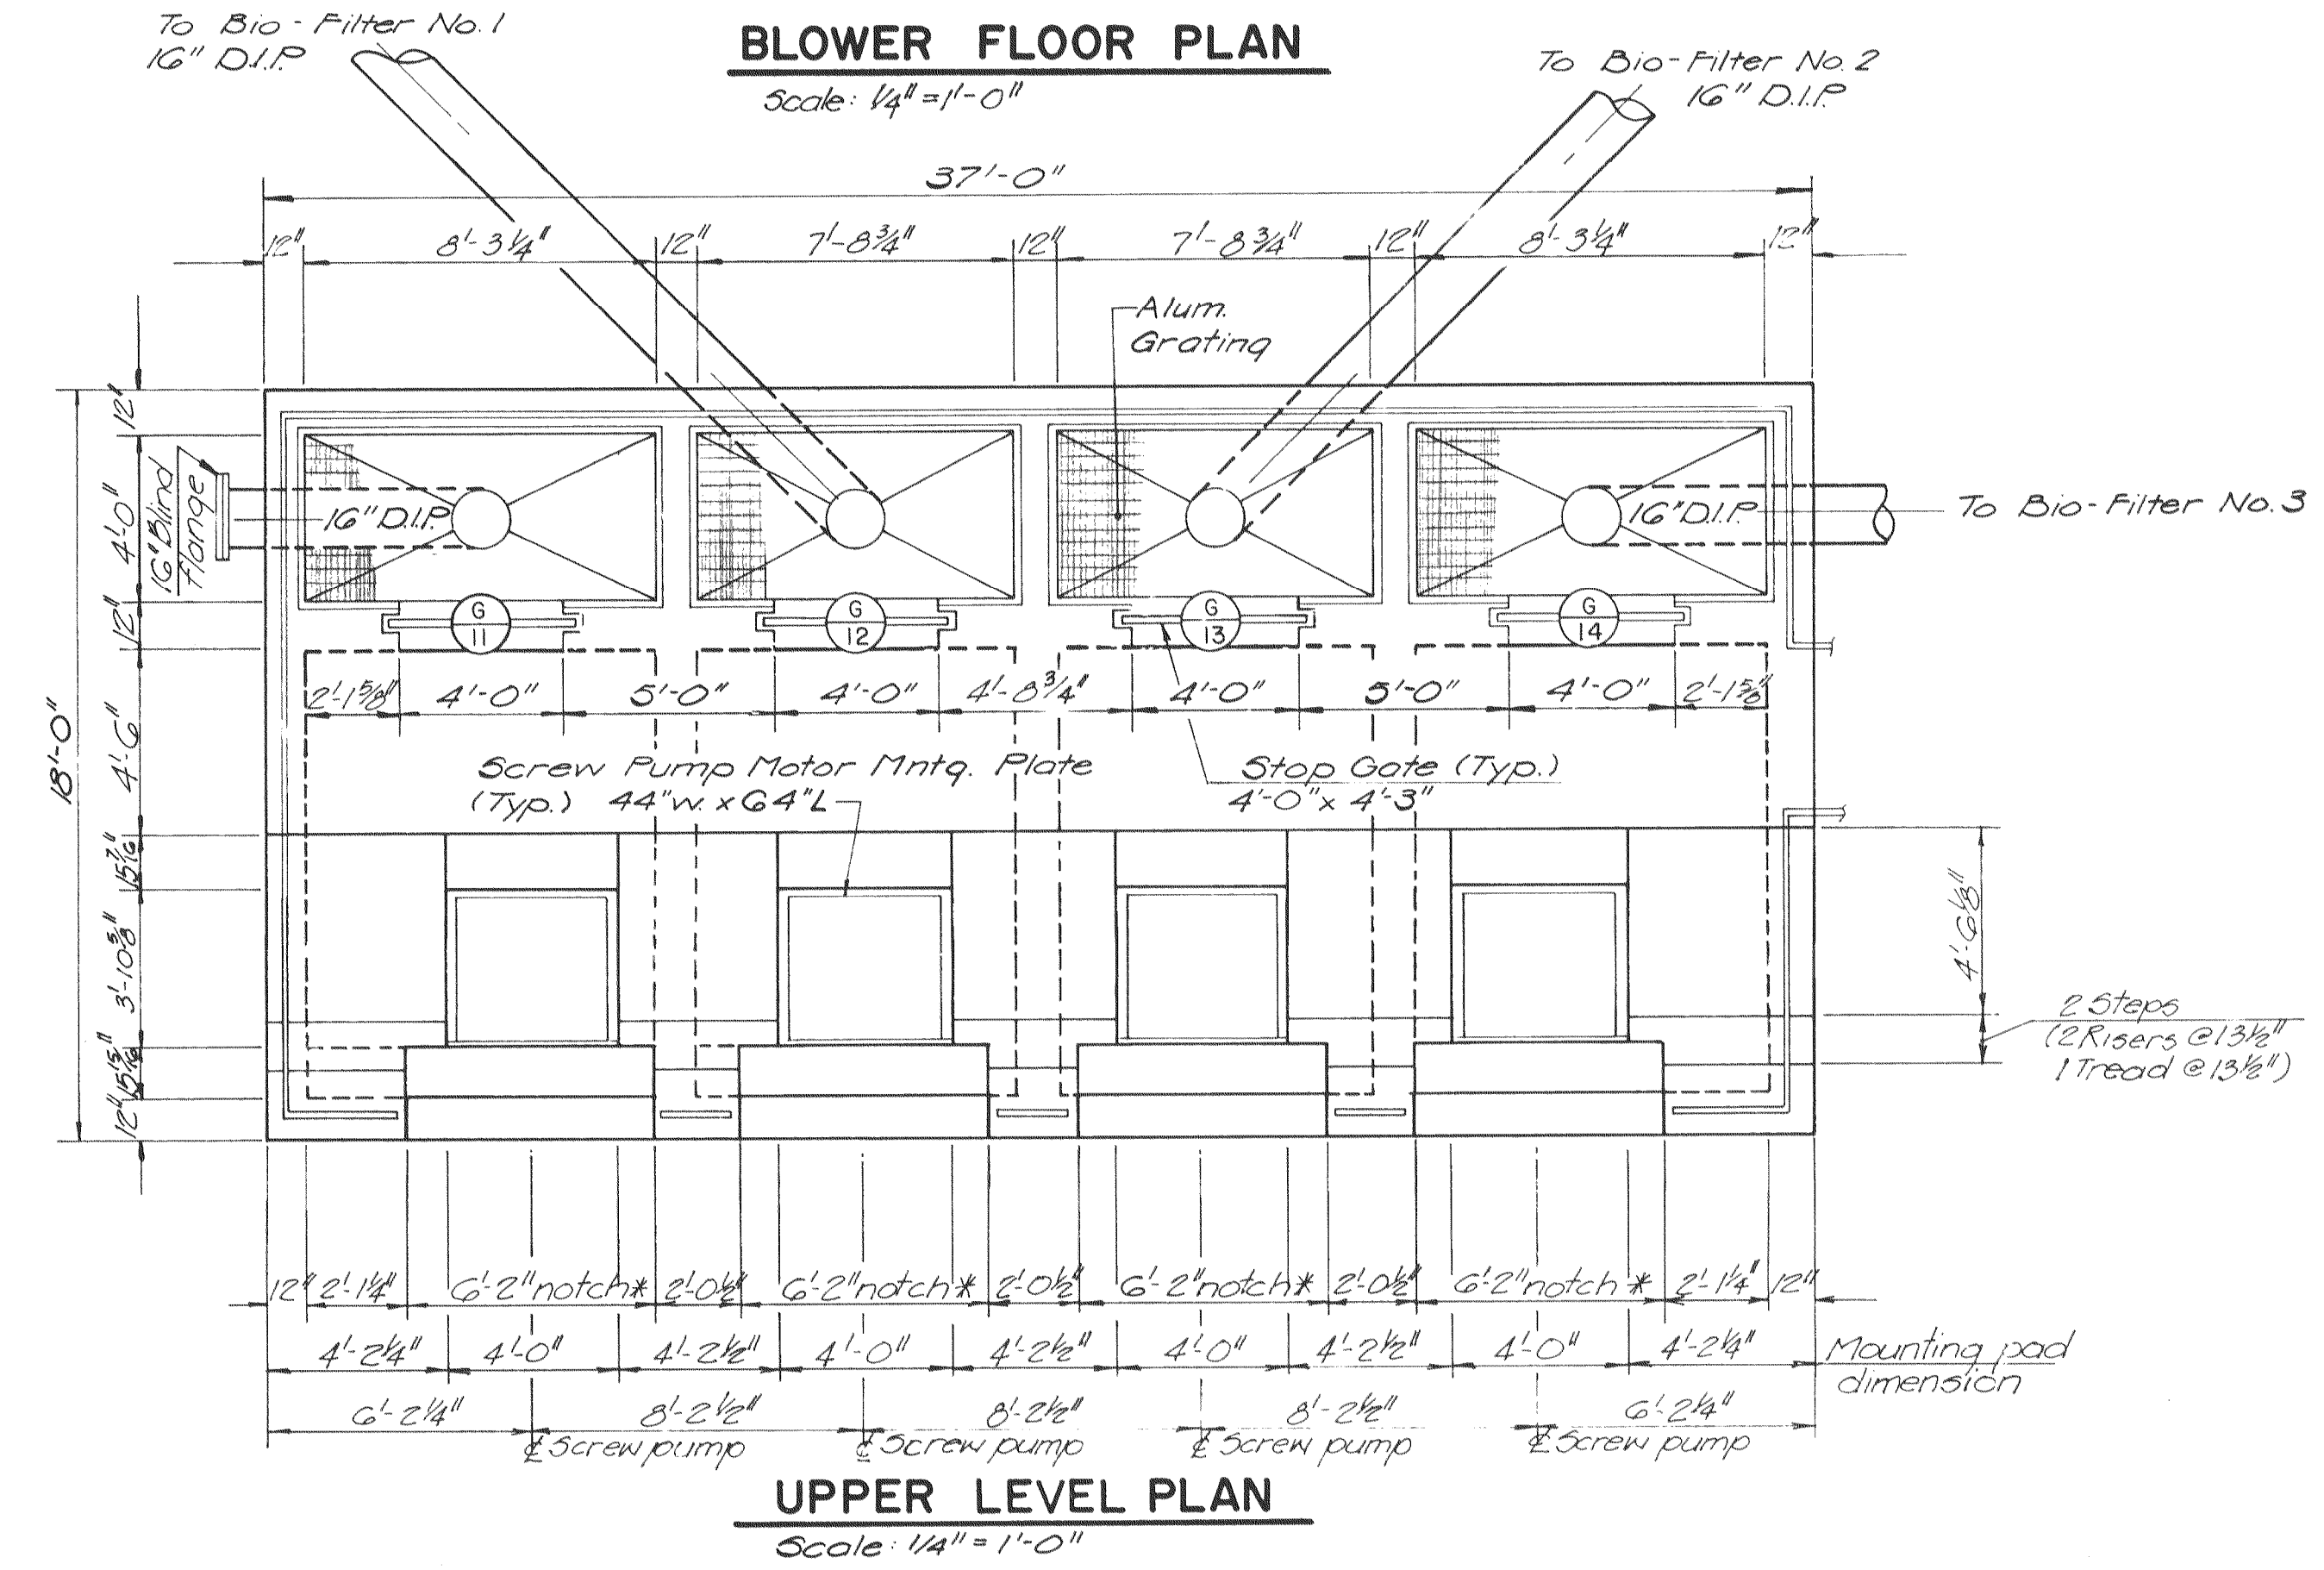


**OPERATING FLOOR PLAN**  
Scale: 1/4" = 1'-0"

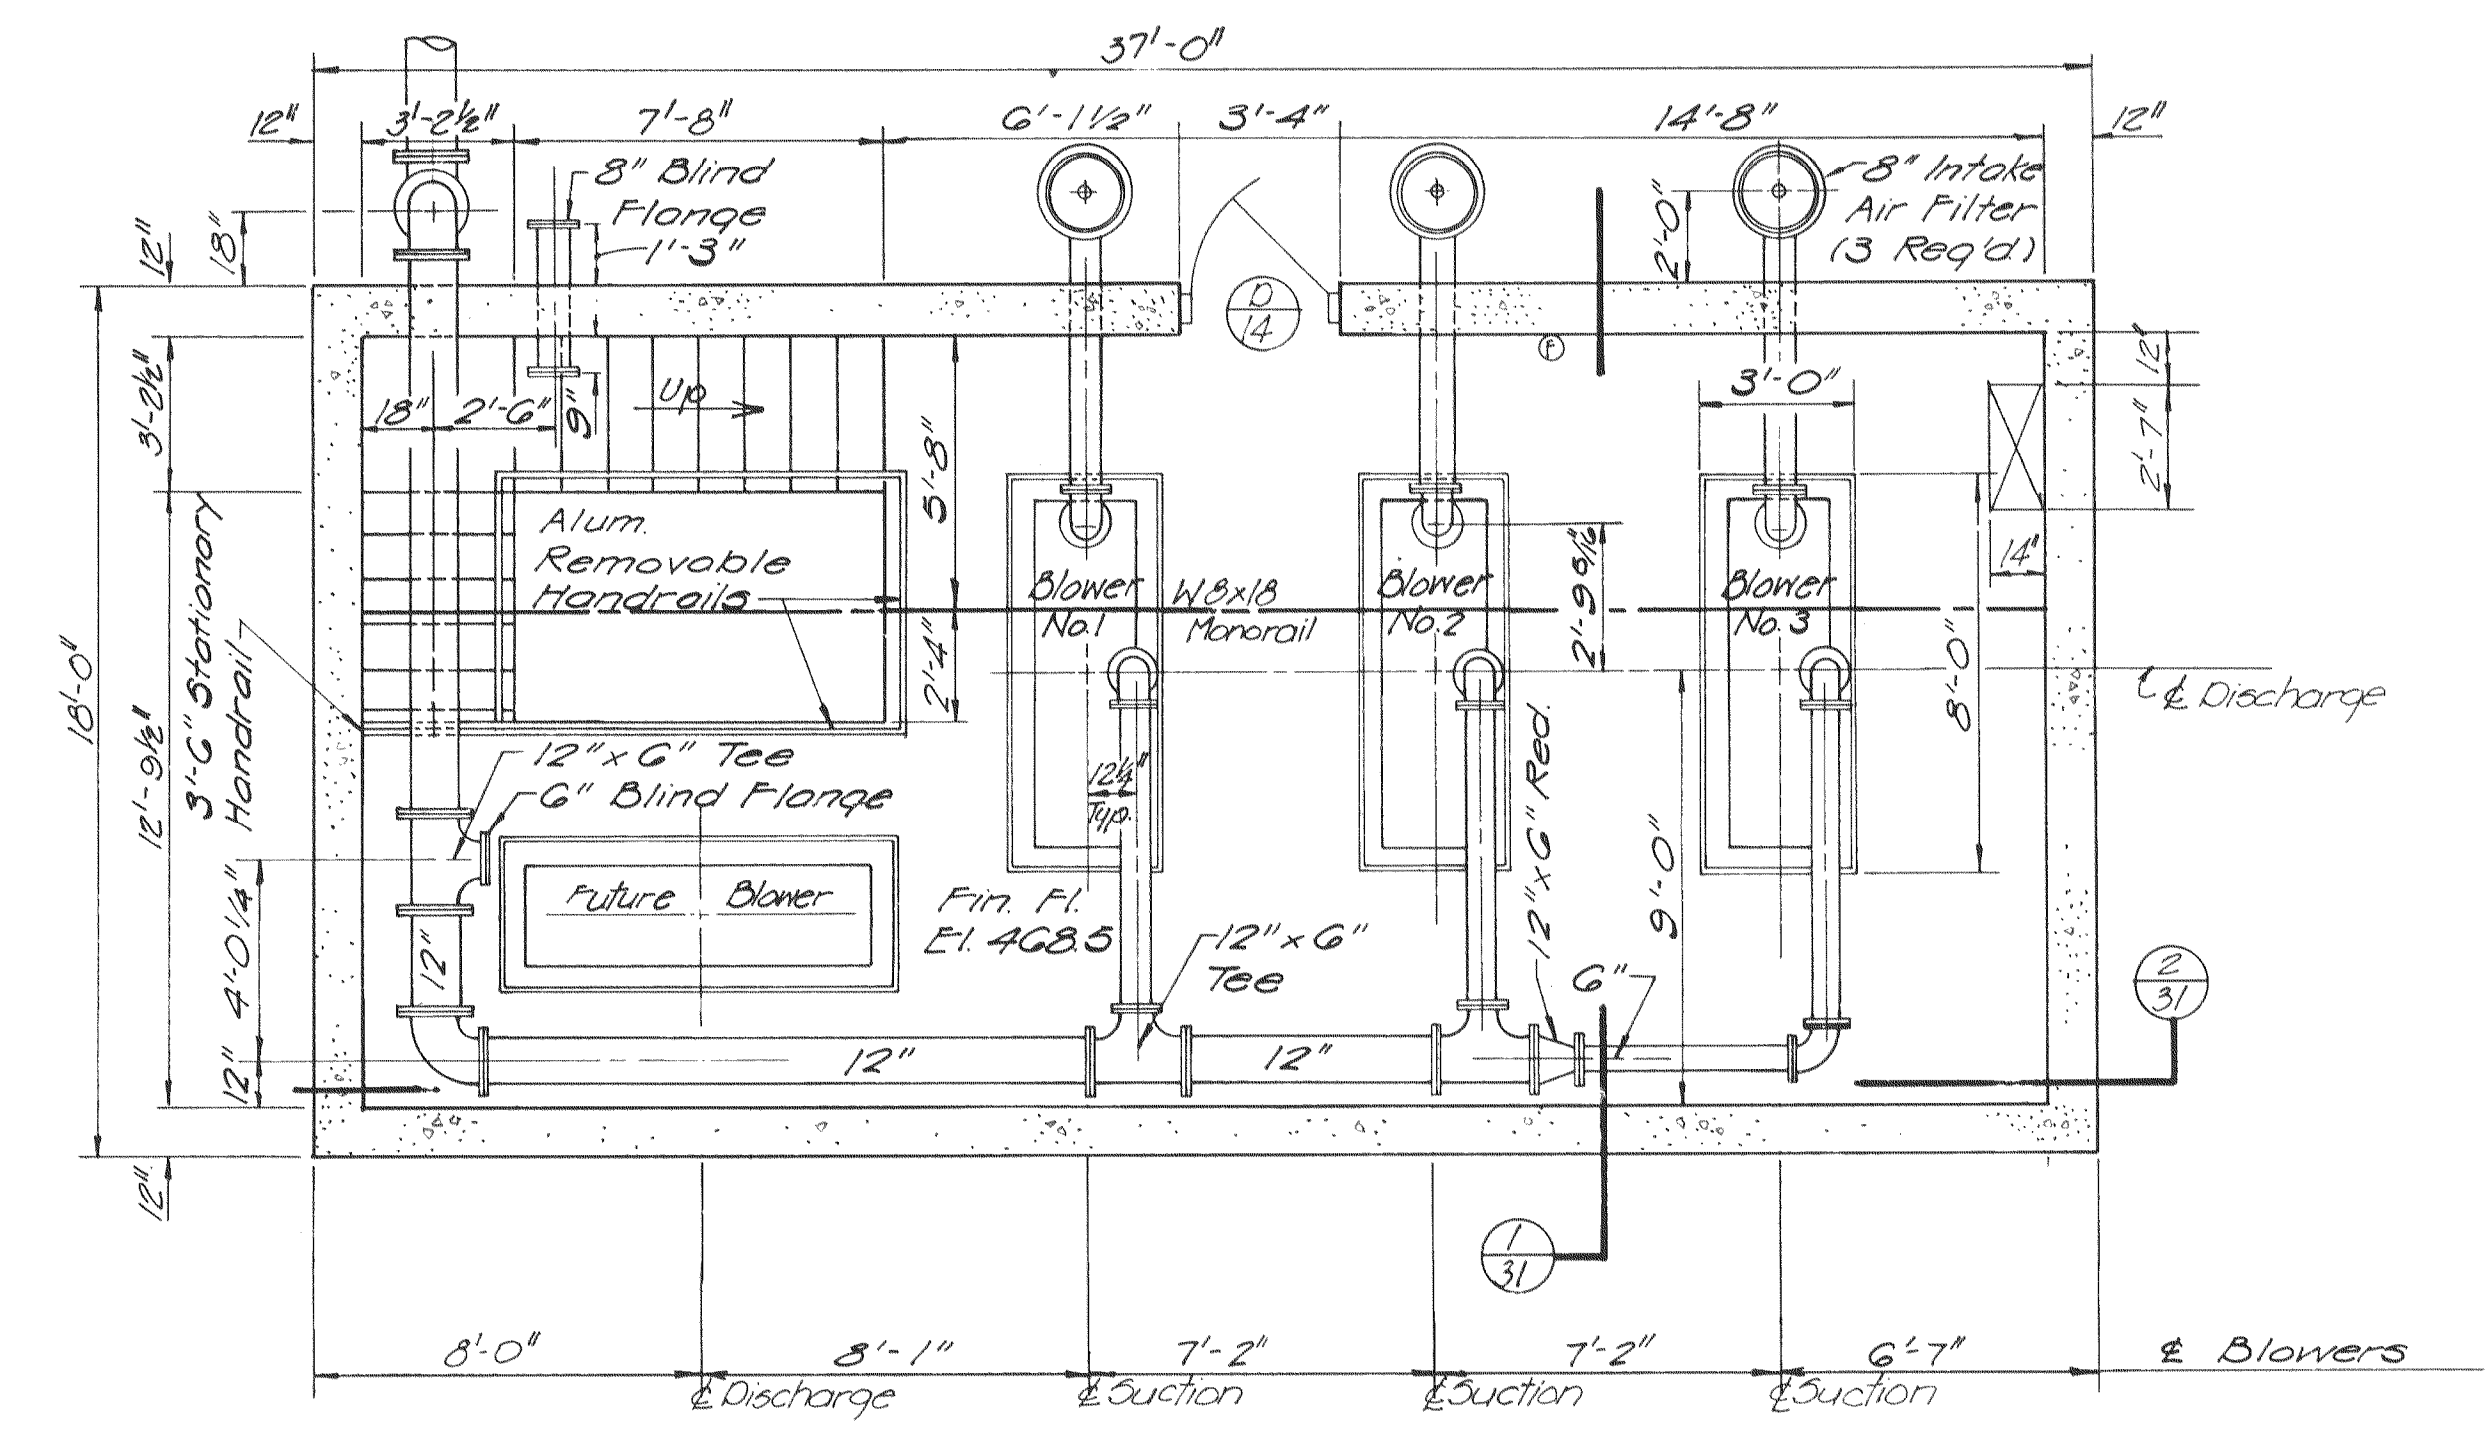

\* Notch on wall - Depth to be determined by equipment purchased.  
 © Fire Extinguisher  
 Note 1) Eyebolt and Eyebolt assembly shall be capable of sustaining a 3000 lbs working load.

EPA PROJECT NO. C291090

<b>GBA</b> GEORGE BUTLER ASSOCIATES CONSULTING ENGINEERS/ARCHITECTS LANDSCAPE ARCHITECTS/PLANNERS	OFFICES: SUITE 200-A FAIRWAY OFFICE CENTER 4210 JUNCTION DRIVE / SHANNEE MISSION / KANSAS 66205 1100 CITY CENTER SQUARE 1100 MAIN / KANSAS CITY / MISSOURI 64105 SUITE 134 LAKESIDE PLAZA II 6700 CORPORATE DRIVE / KANSAS CITY / MISSOURI 64120
	<b>WASTEWATER TREATMENT PLANT EXPANSION</b> <b>BIO-FILTER COMPLEX-UPPER, BLOWER &amp; OPERATING FLOOR PLANS</b> CITY OF O'FALLON, MISSOURI
DESIGNED BY: W.C.C.    DRAWN BY: C. R. RYAN    CHECKED BY: W.A.C.	JOB NO. 79-2065 DATE July 30, 1981 SCALE As Shown SHEET NO. 19 OF 88