




**CENTER COLUMN SUPPORT**  
Scale: 1/2" = 1'-0"

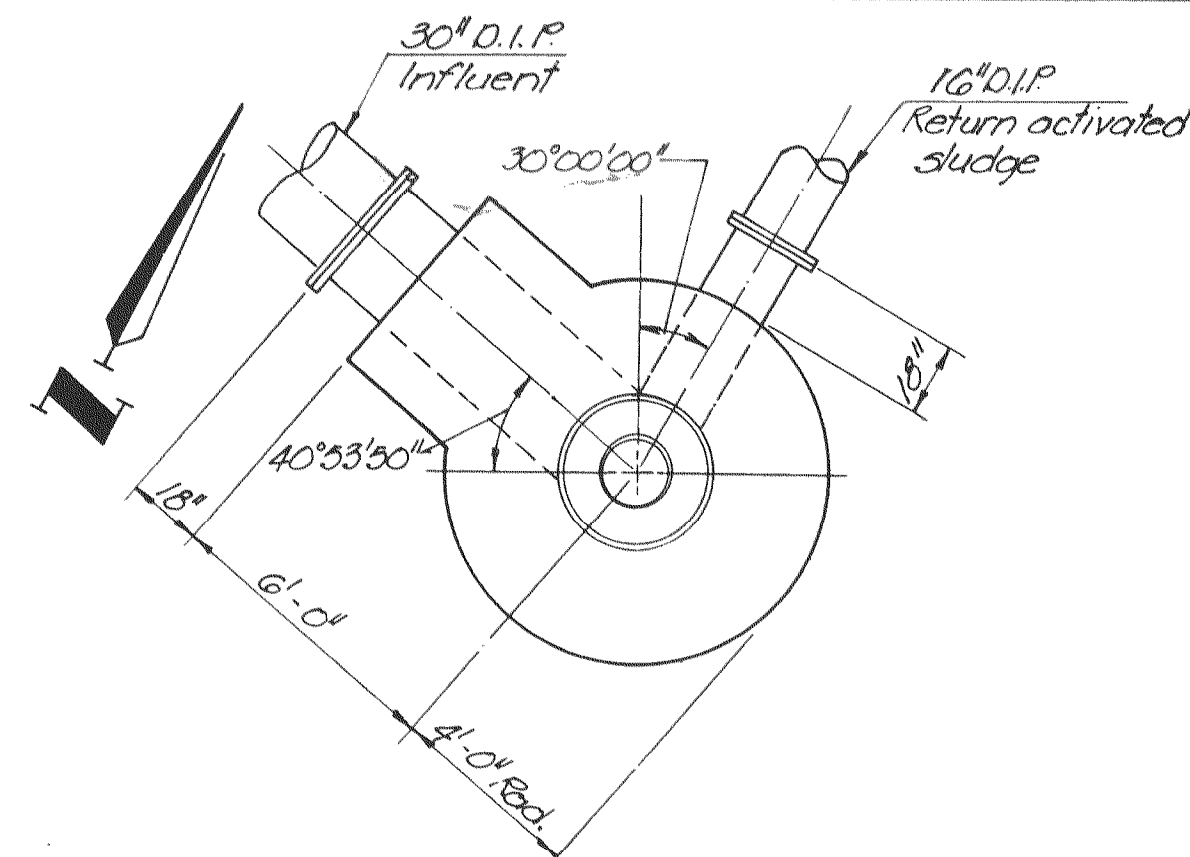


**FINAL CLARIFIER NO. 2  
FOUNDATION PLAN**  
Scale: 1/4" = 1'-0"

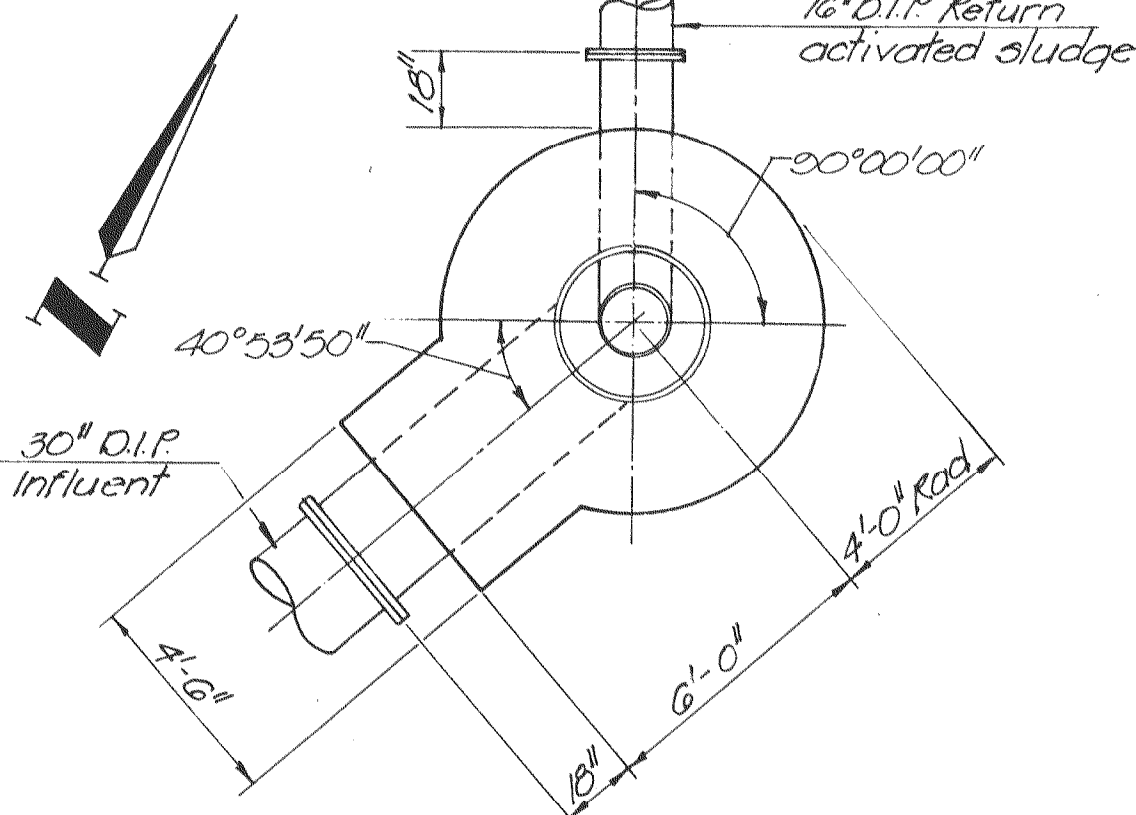


**FINAL CLARIFIER NO. 1  
FOUNDATION PLAN**  
Scale: 1/4" = 1'-0"

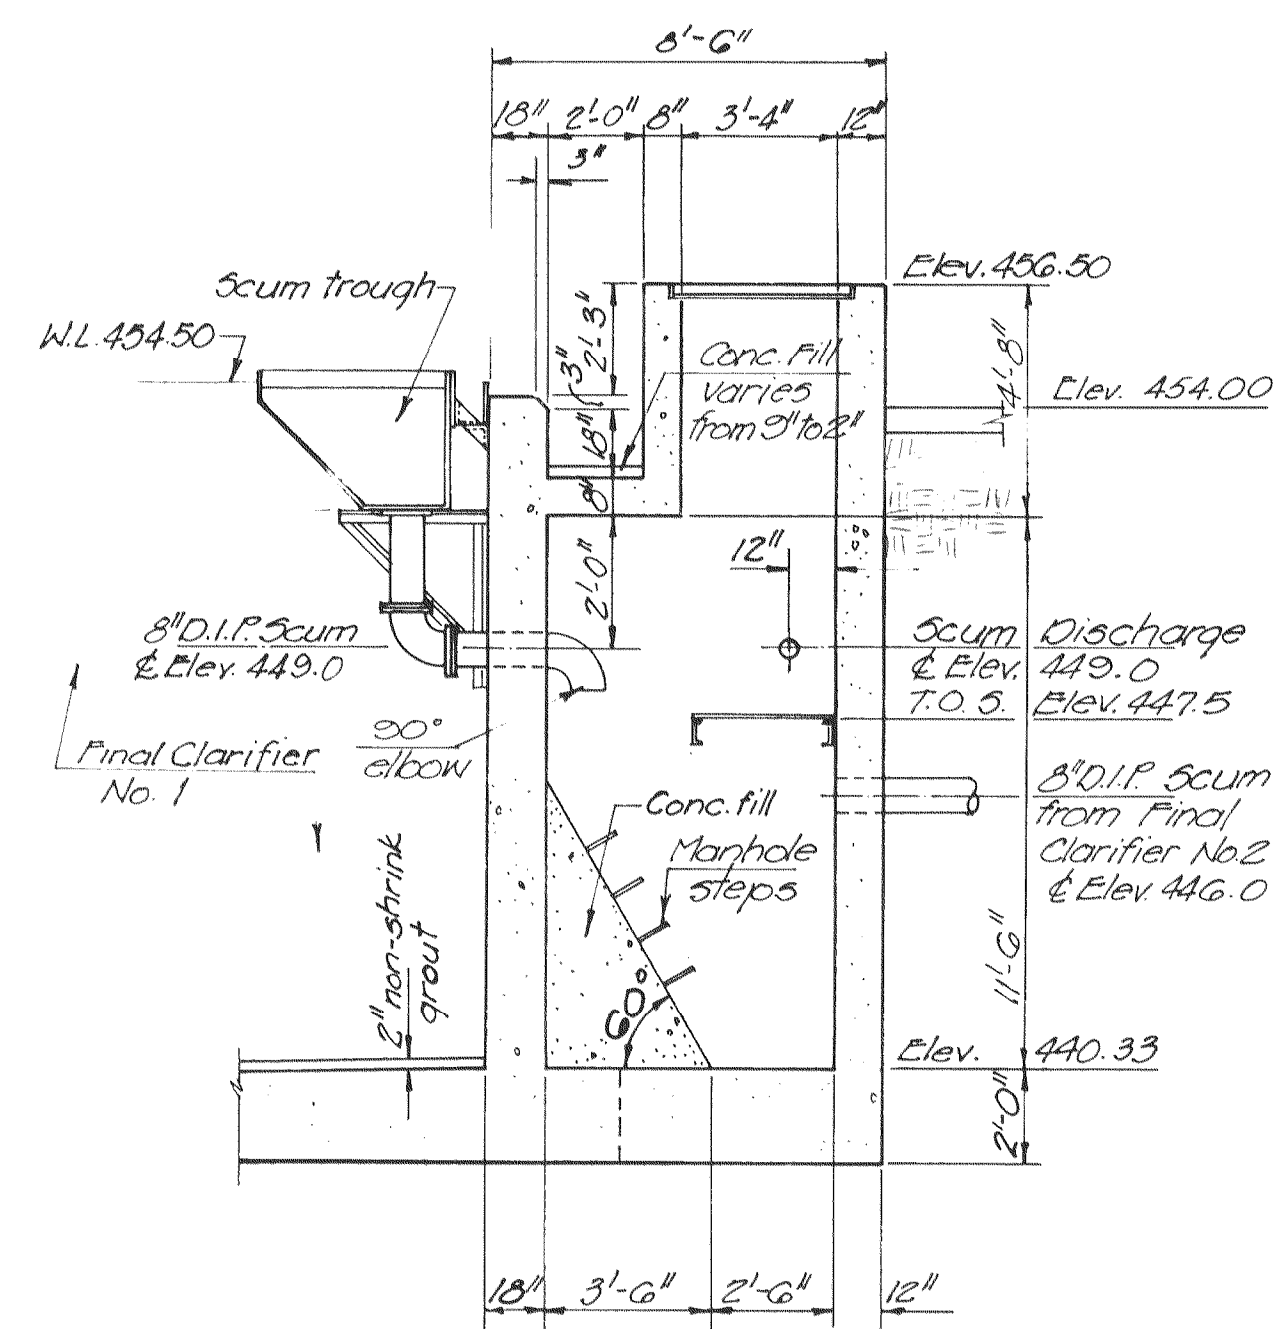

**SECTION 2**  
Scale: 1/4" = 1'-0" (41)  
(Re. sht. 40)

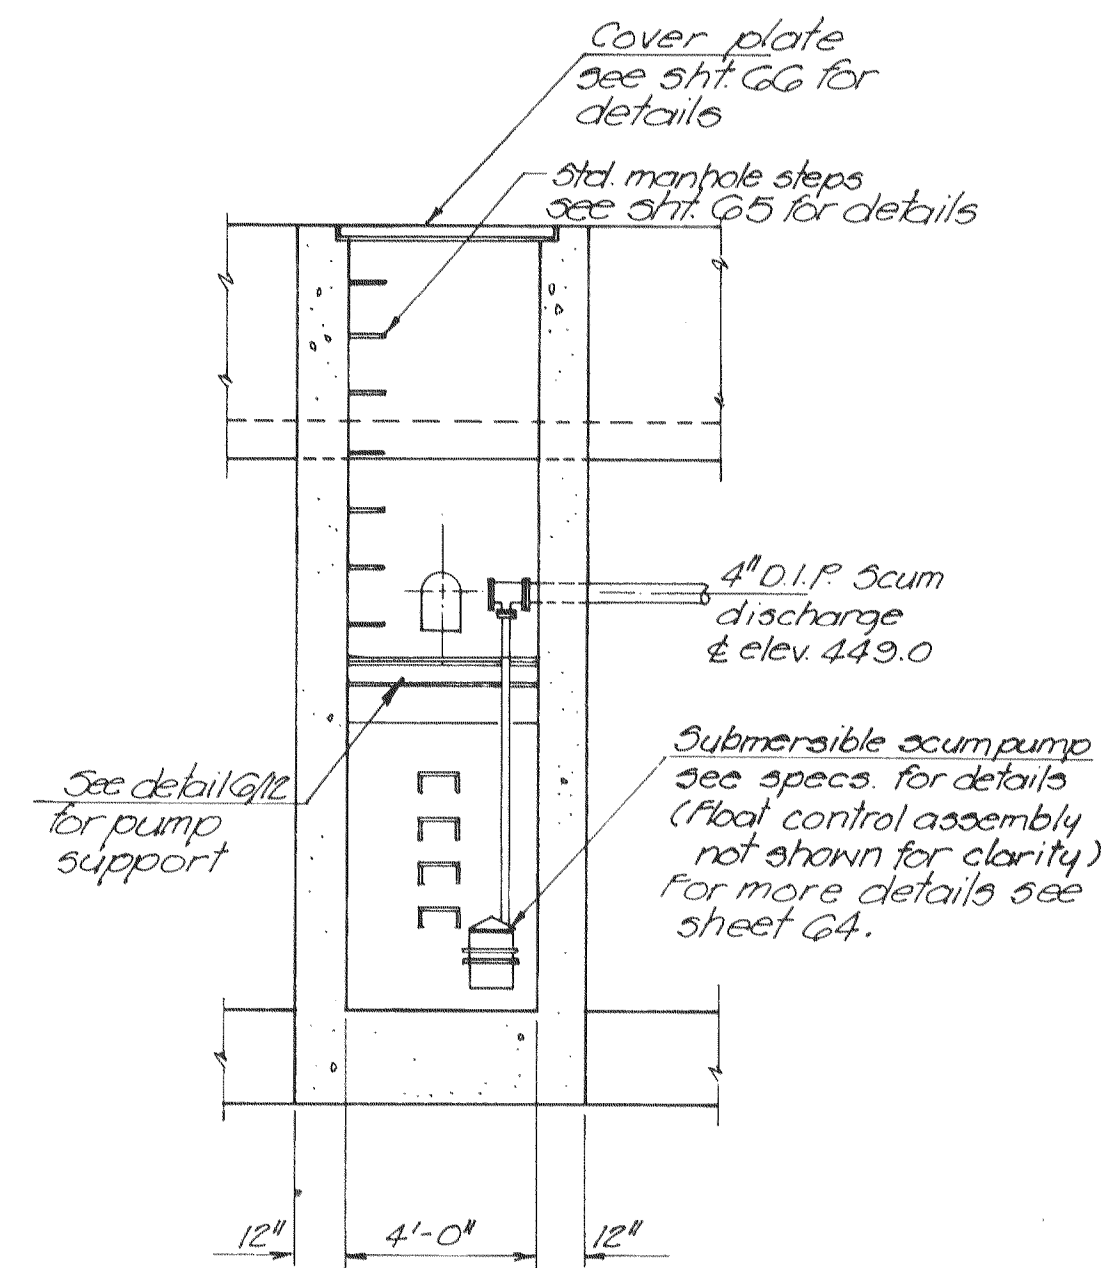


**SECTION 3**  
Scale: 1/4" = 1'-0" (41)  
(Re. sht. 40)

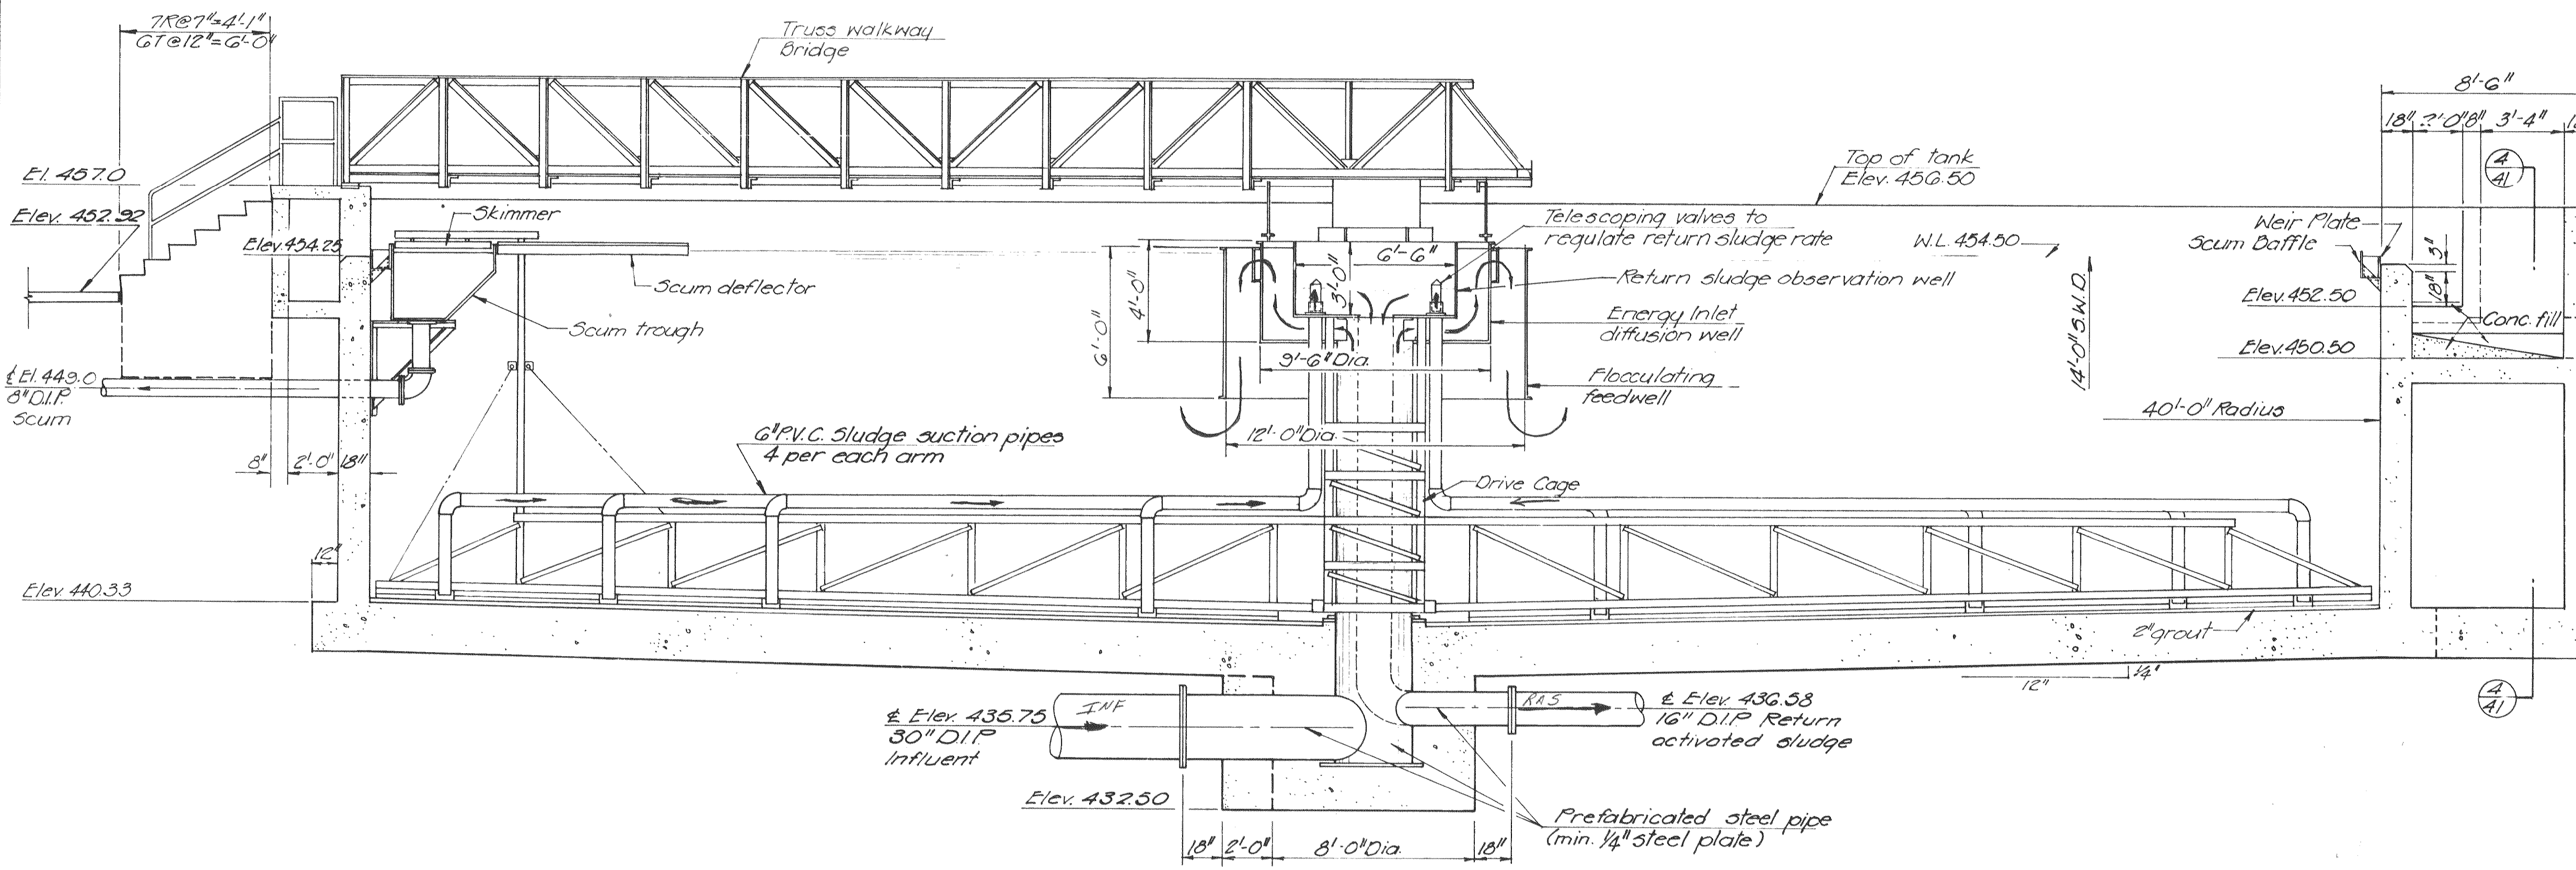

**TYPICAL FINAL CLARIFIER**

**SECTION 1**  
Scale: 1/4" = 1'-0" (41)

(Some items shown are out of true position.  
For orientation see sheet no. 40.)

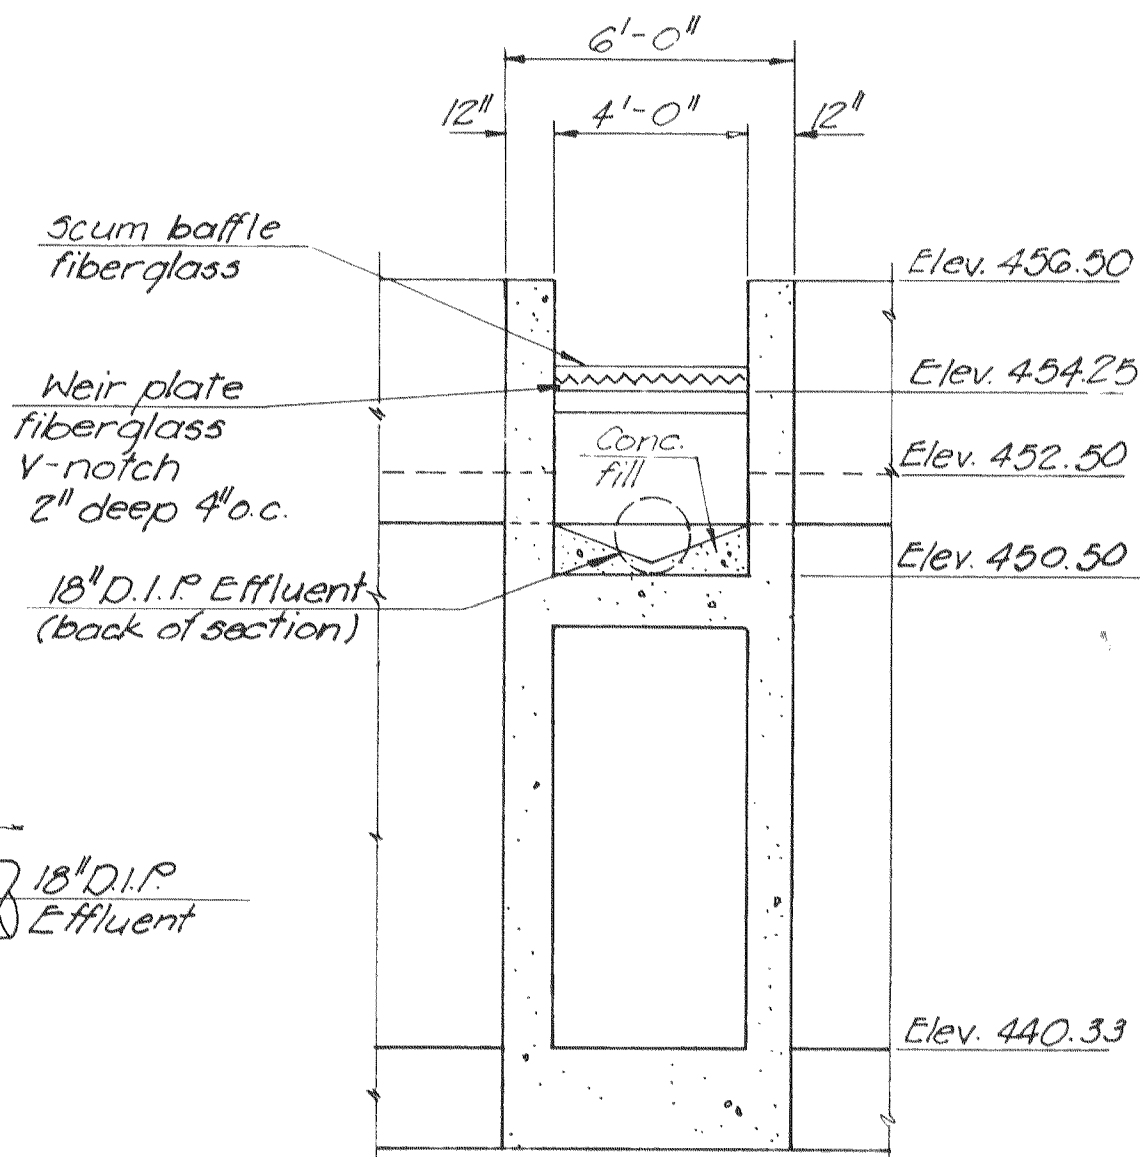

**SECTION A**  
Scale: 1/4" = 1'-0" (41)  
(Re. sht. 40)

EPA PROJECT NO. C291090

Rev. 2-82 MKK

**GBA**  
GEORGE BUTLER ASSOCIATES  
CONSULTING ENGINEERS / ARCHITECTS  
LANDSCAPE ARCHITECTS / PLANNERS

**OFFICES:**  
SUITE 305-A FAIRWAY OFFICE CENTER  
4310 JOHNSON DRIVE / SHAWNEE MISSION / KANSAS 66205  
1100 CITY CENTER SQUARE  
1100 MAIN / KANSAS CITY / MISSOURI 64105  
SUITE 134 LAKESIDE PLAZA II  
6700 CORPORATE DRIVE / KANSAS CITY / MISSOURI 64120

**WASTEWATER TREATMENT  
PLANT EXPANSION  
FINAL CLARIFIER  
SECTIONS**  
CITY OF O'FALLON, MISSOURI

JOB NO 79-2065  
DATE July 30, 1981  
SCALE As shown  
SHEET NO 41 OF 88

DESIGNED BY W.C.C. DRAWN BY C. Rupp CHECKED BY W.A.C.