

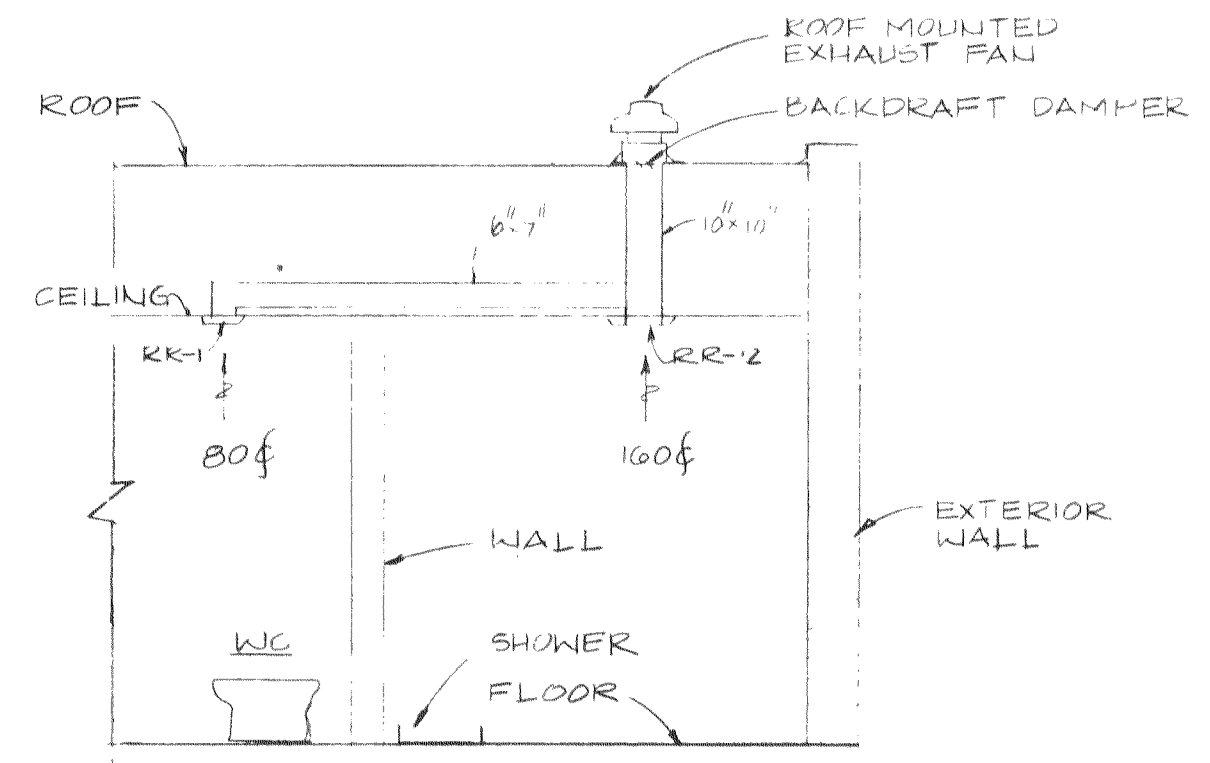



BLOWER FLOOR PLAN
SCALE: 1/4" = 1'-0"

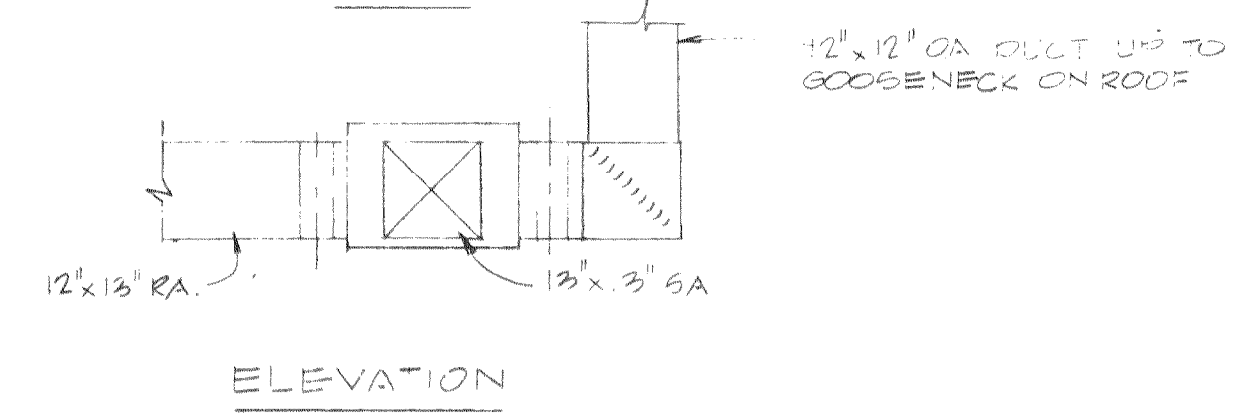


DETAIL-B
SCALE: 1/4" = 1'-0"

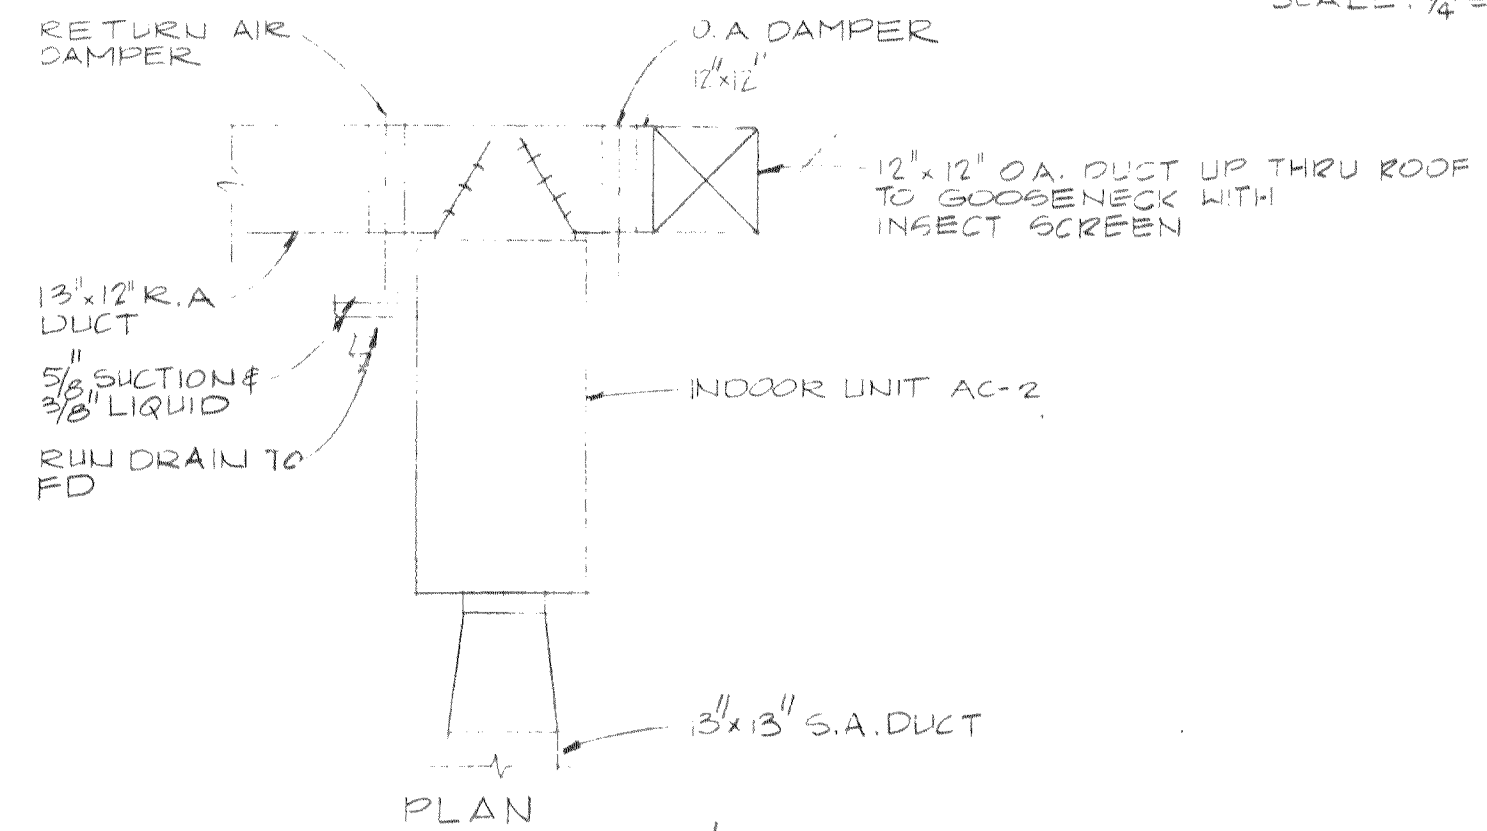

DETAIL-A
SCALE: 1/2" = 1'-0"

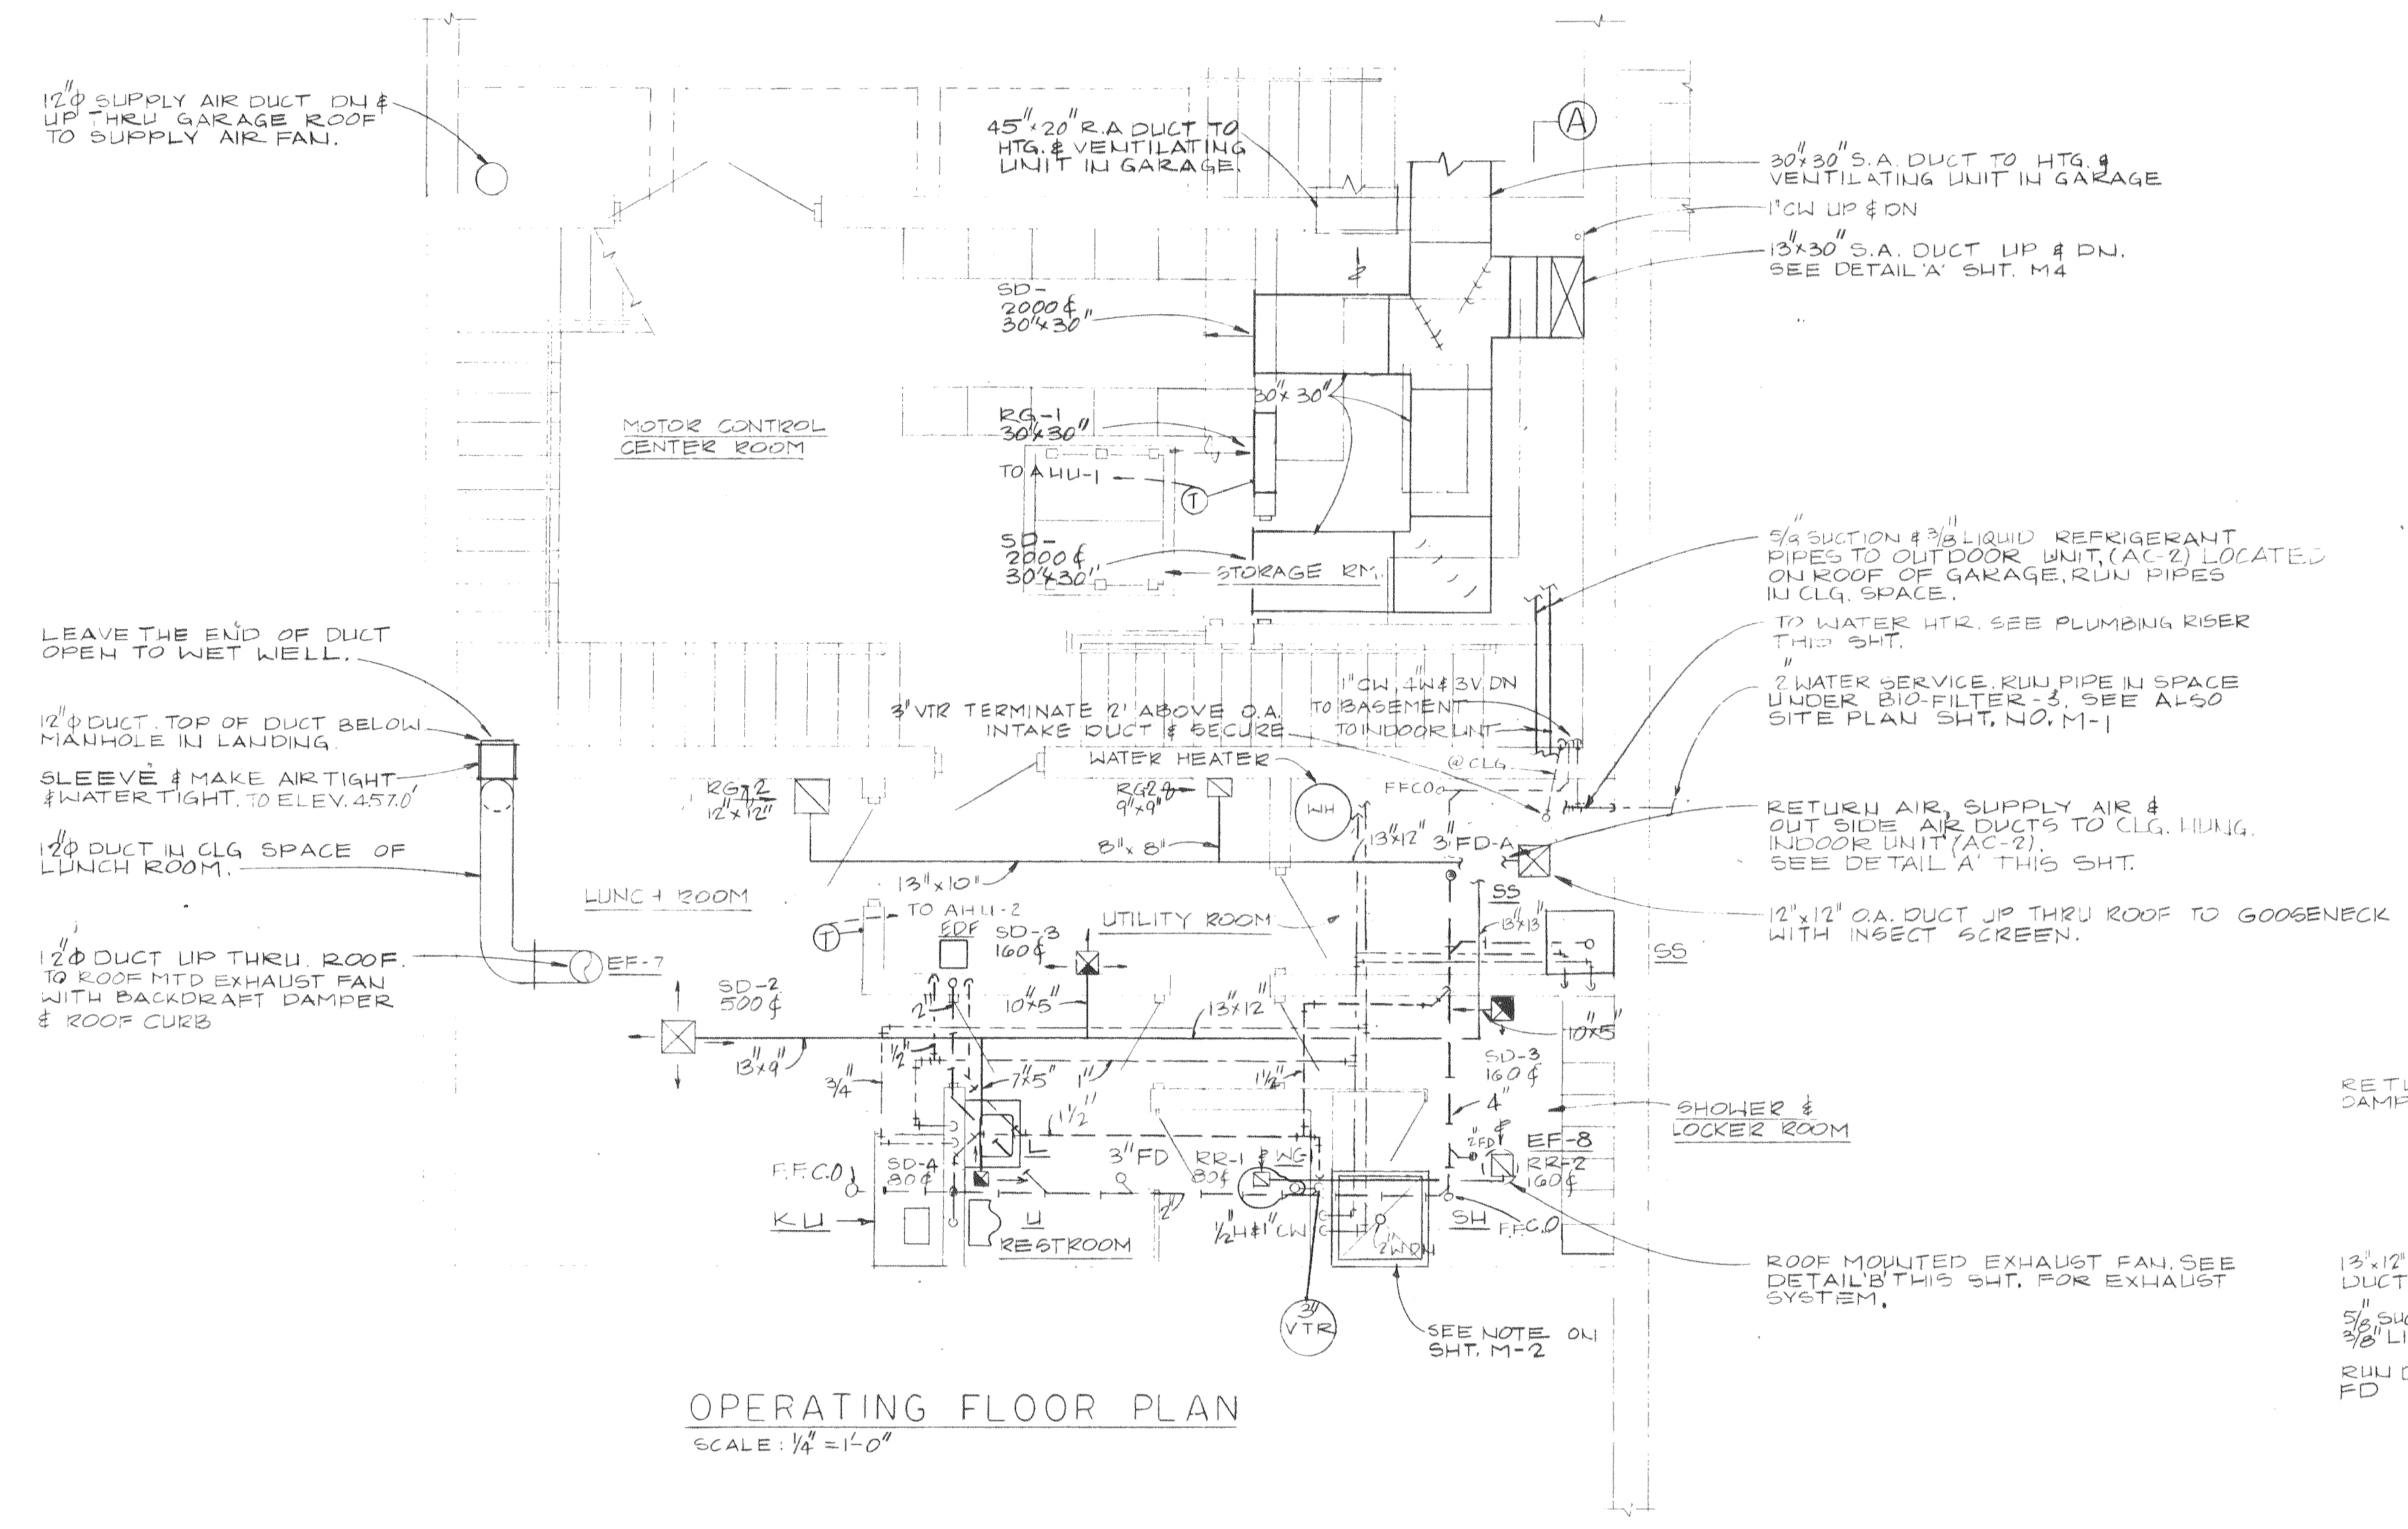

OPERATING FLOOR PLAN
SCALE: 1/4" = 1'-0"

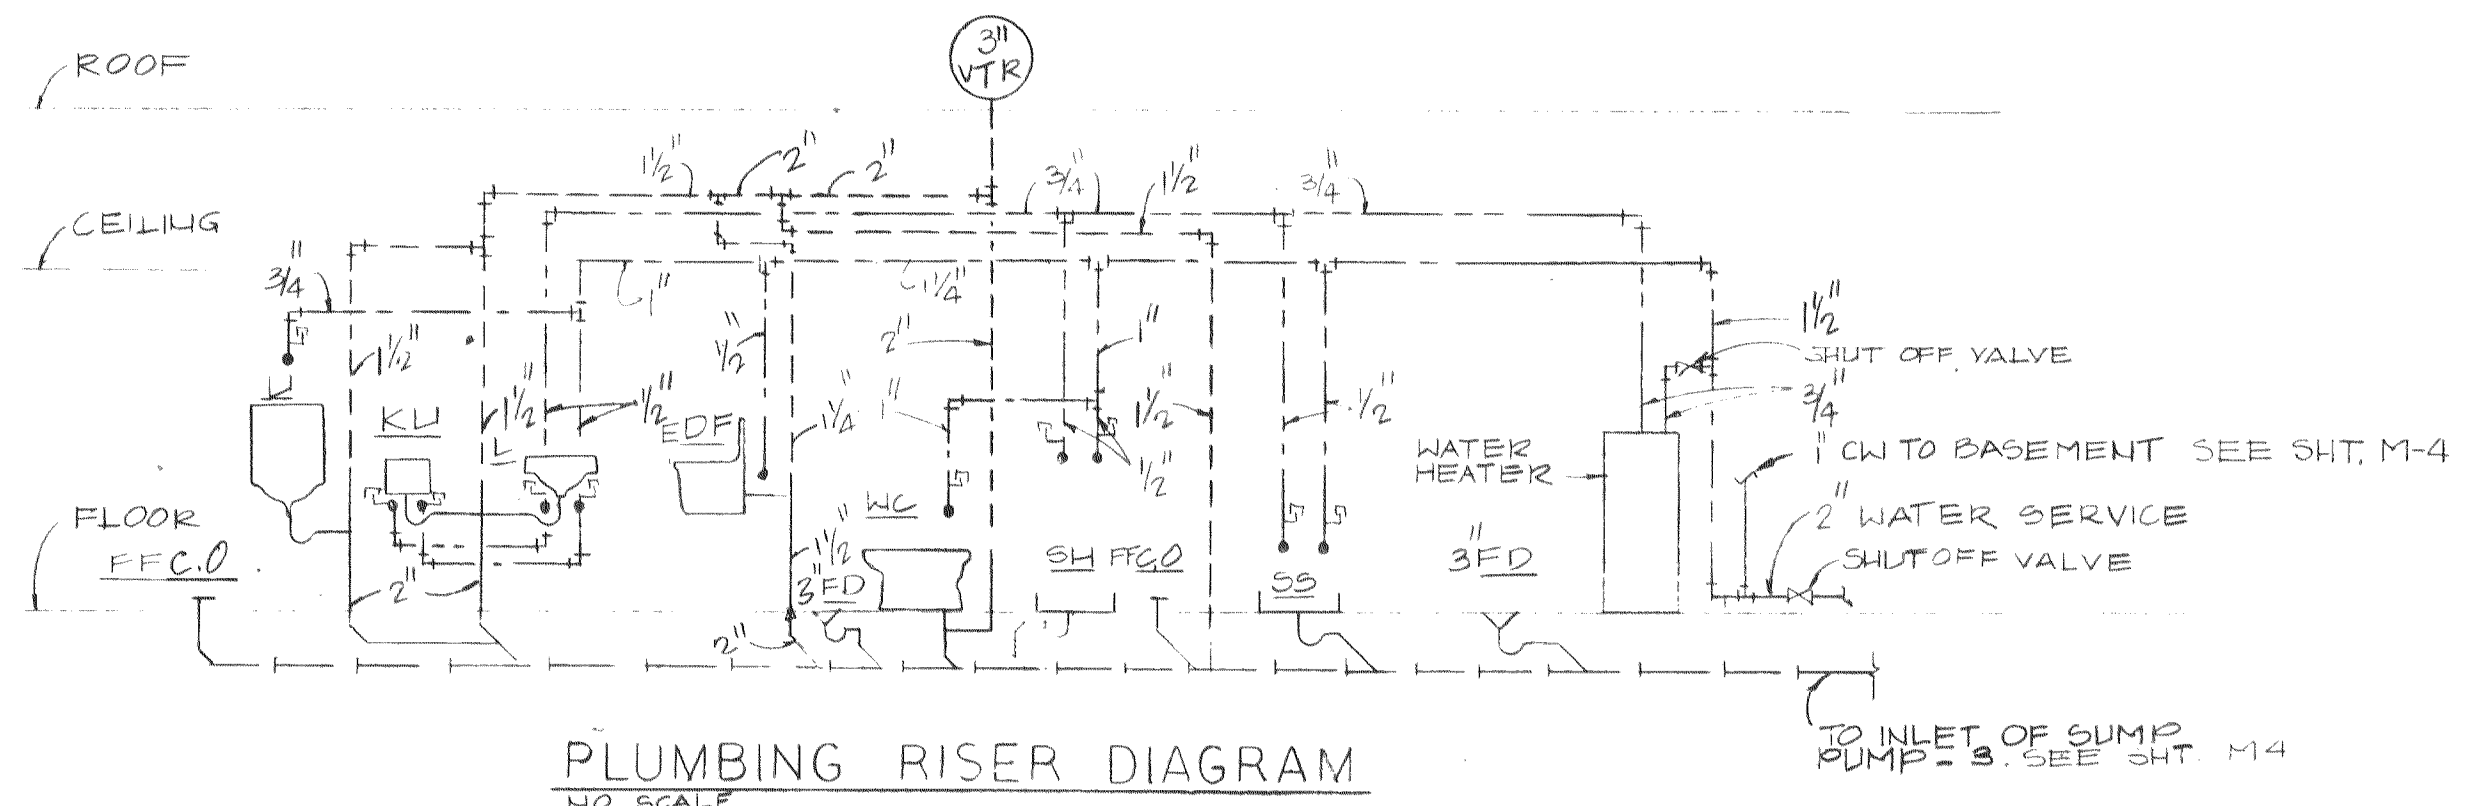

PLUMBING RISER DIAGRAM
NO SCALE

EPA PROJECT NO. C291090

GBA
GEORGE BUTLER ASSOCIATES
CONSULTING ENGINEERS/ARCHITECTS
LANDSCAPE ARCHITECTS/PLANNERS

OFFICES:
SUITE 305-A FAIRWAY OFFICE CENTER
4210 JOHNSON DRIVE / SHAWNEE MISSION / KANSAS 66205
1100 CITY CENTER SQUARE
1100 MAIN / KANSAS CITY / MISSOURI 64105
SUITE 13A LAKESIDE PLAZA II
6700 CORPORATE DRIVE / KANSAS CITY / MISSOURI 64120

WASTE WATER TREATMENT PLANT EXPANSION
BIO-FILTER BUILDING-OPERATING & BLOWER FLOOR-HVAC & PLUMBING
CITY OF O'FALLON, MISSOURI

DESIGNED BY J.P.A. DRAWN BY J.P.A. CHECKED BY G.E.S.

M5

JOB NO 79-2065
DATE 30 JULY 81
SCALE AS SHOWN
SHEET NO 78 OF 88