



K:\Client\O'Fallon\92344\92344.dwg\Exec\923440003.dwg Layout: E0.03 Monday, October 08, 2001, 12:50pm Copyright 2001, George Butler Associates, Inc.

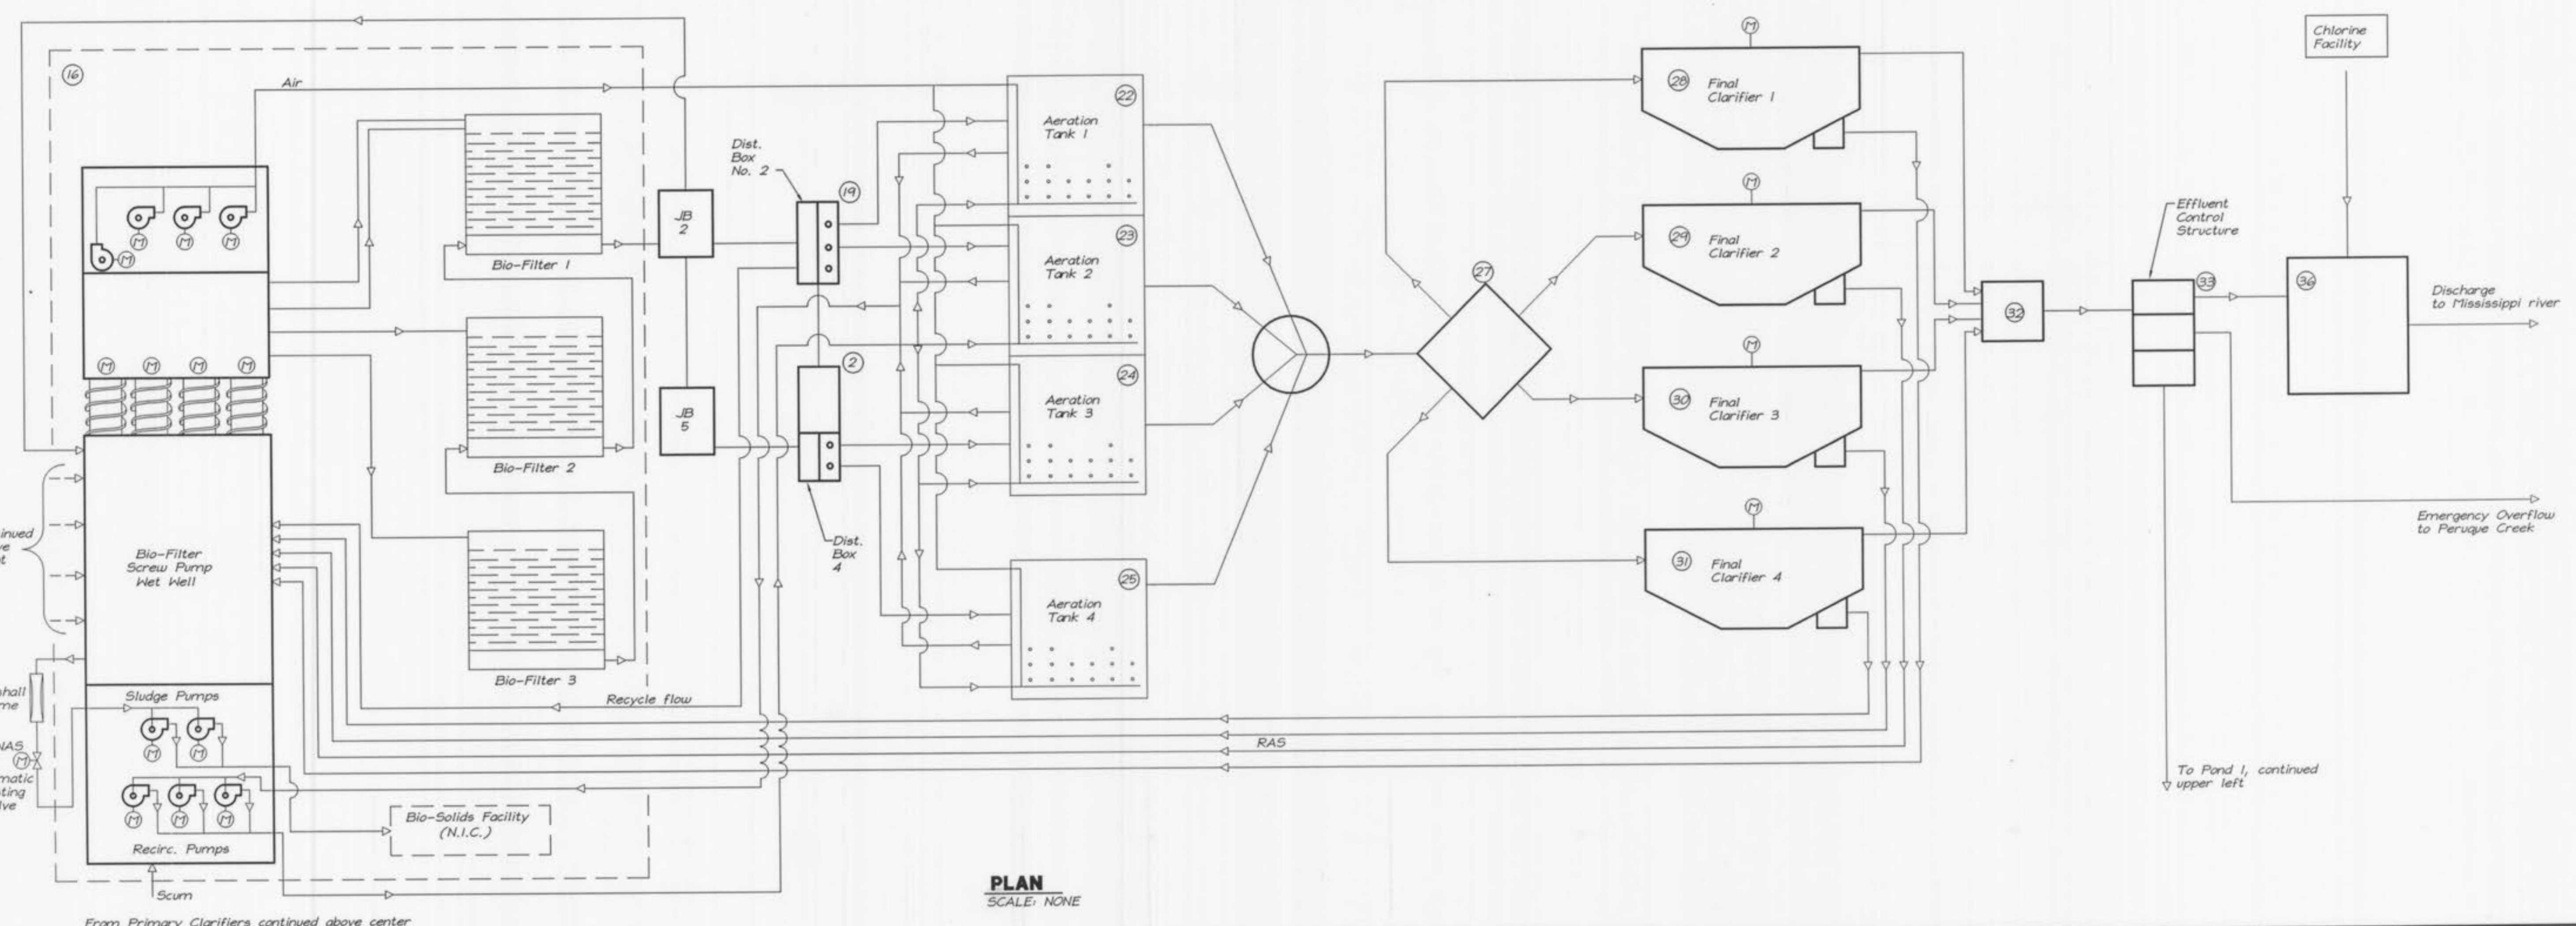

**PLAN**  
SCALE: NONE

**GEORGE BUTLER ASSOCIATES, INC.**  
Engineers • Architects  
Kansas • Missouri • Illinois

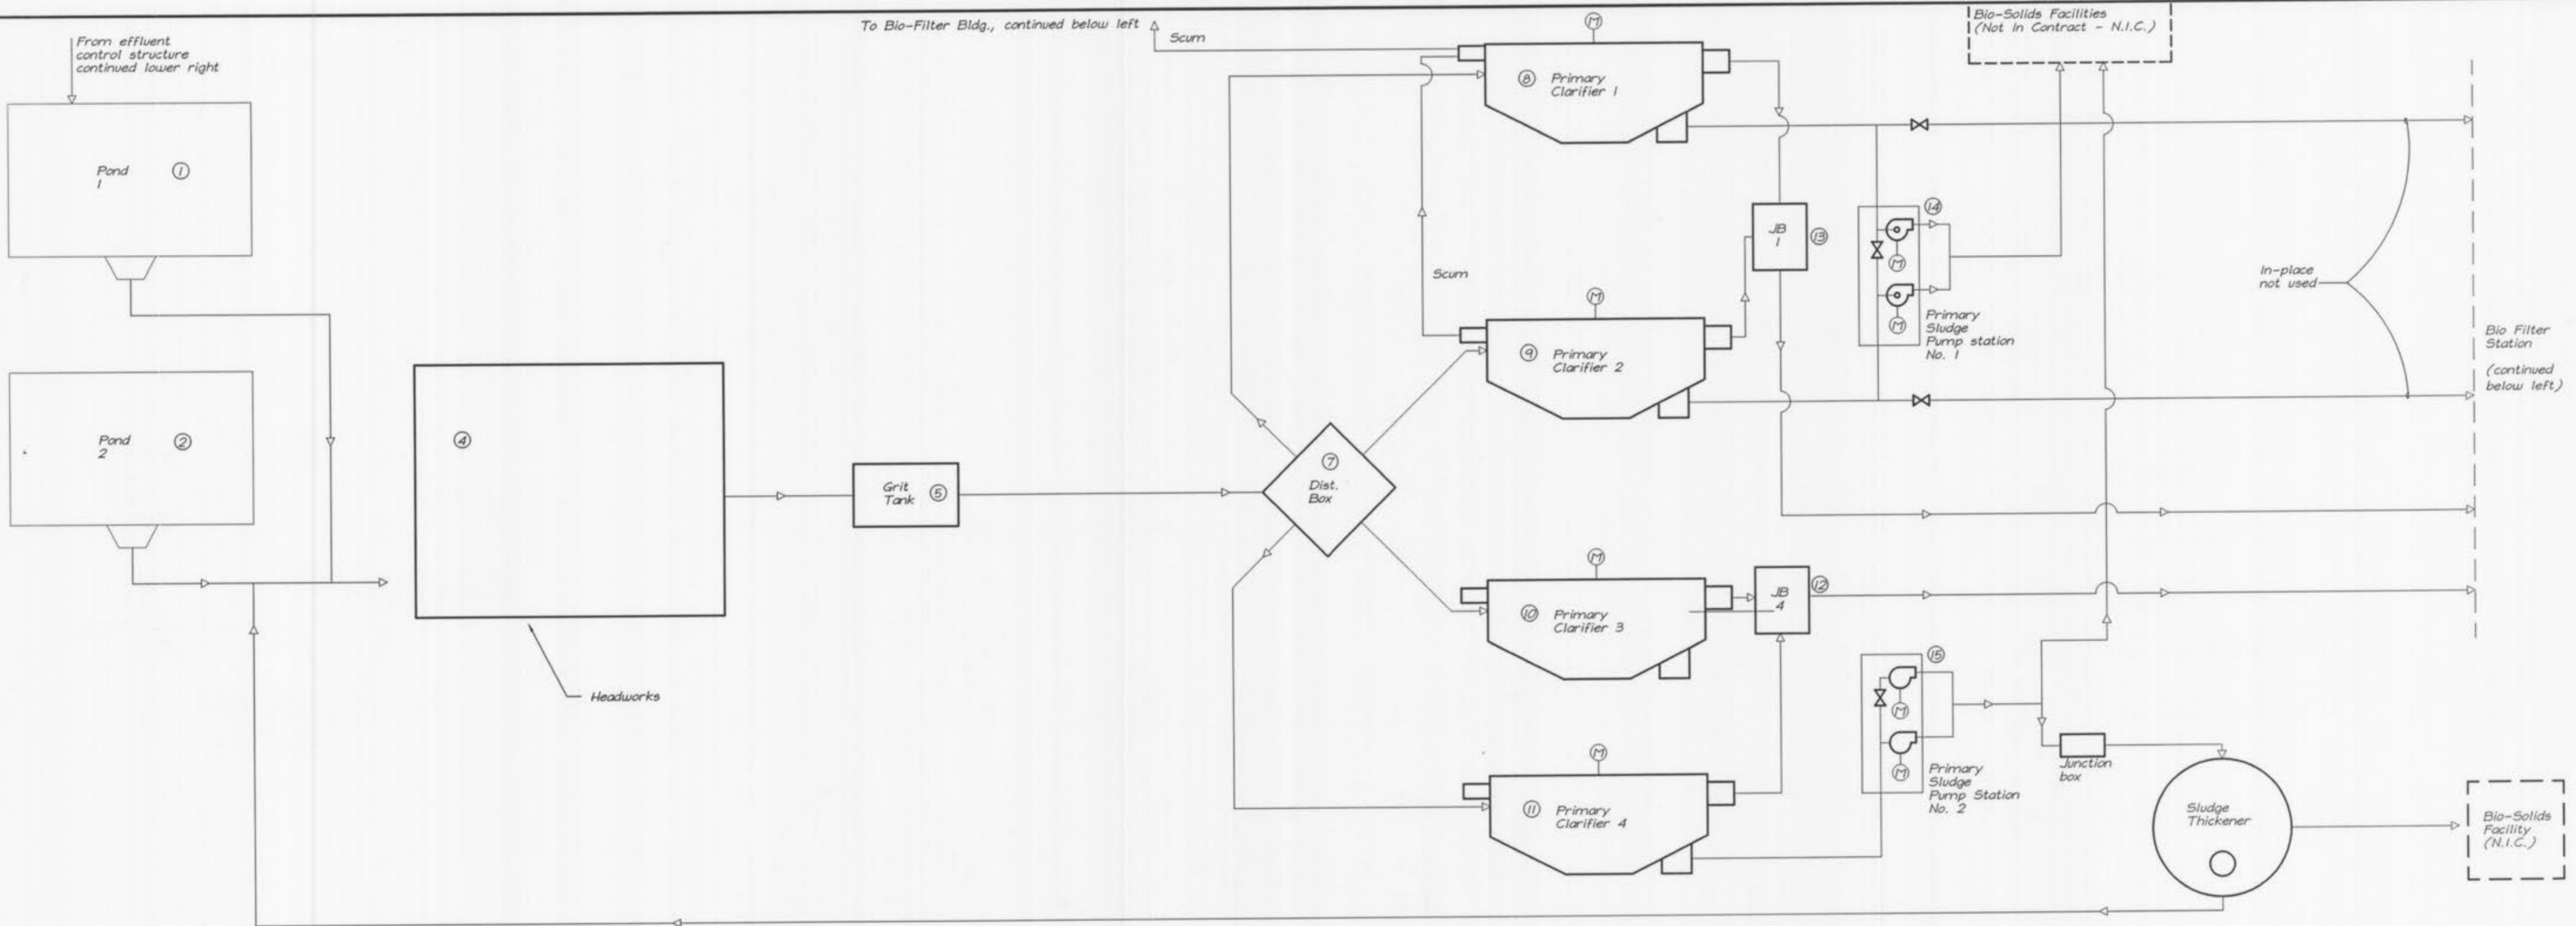

**WASTEWATER TREATMENT PLANT EXPANSION  
PROCESS AND INSTRUMENTATION  
DIAGRAM (P & ID)**  
CITY OF O'FALLON, MISSOURI

JOB NO.: 9234
DATE: 10-08-2001
DESIGNED BY: SLC
DRAWN BY: KRC
CHECKED BY: SLC
SHEET NUMBER
<b>E0.03</b>