






WASTEWATER TREATMENT PLANT EXPANSION
PRIMARY SLUDGE PUMP STATION NO. 2
ELECTRICAL PLAN AND SECTION
 CITY OF O'FALLON, MISSOURI

JOB NO.: 9234
 DATE: 10-08-2001

DESIGNED BY: SLC
 DRAWN BY: KRC
 CHECKED BY: SLC
 SHEET NUMBER

E15.01

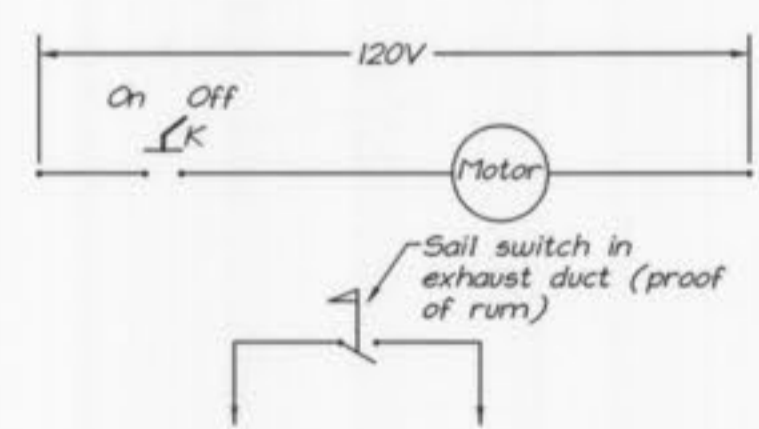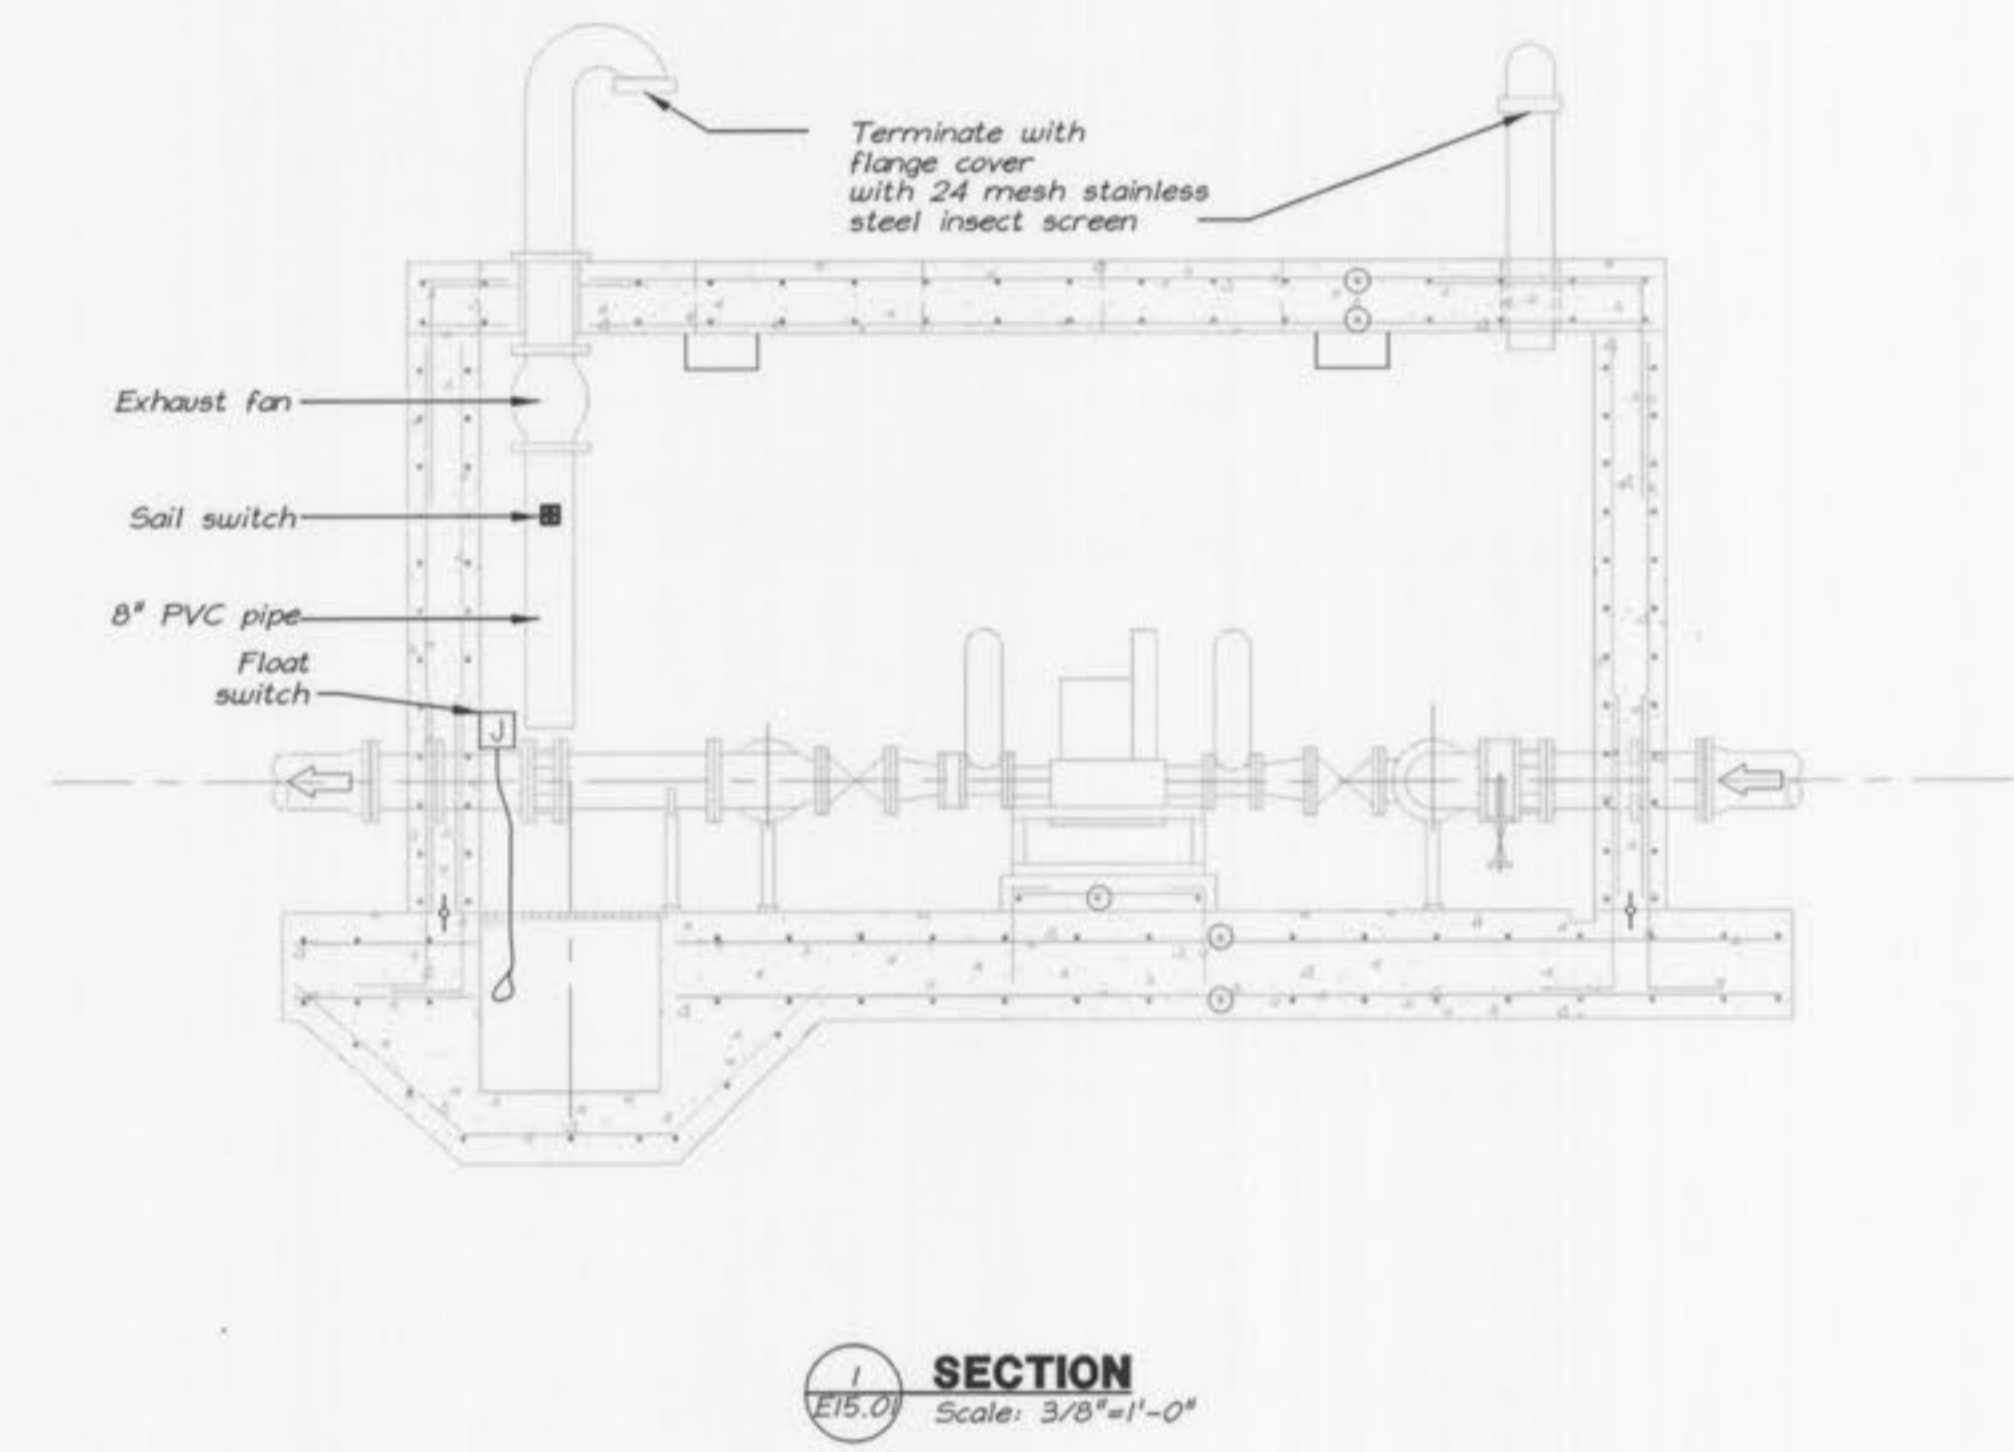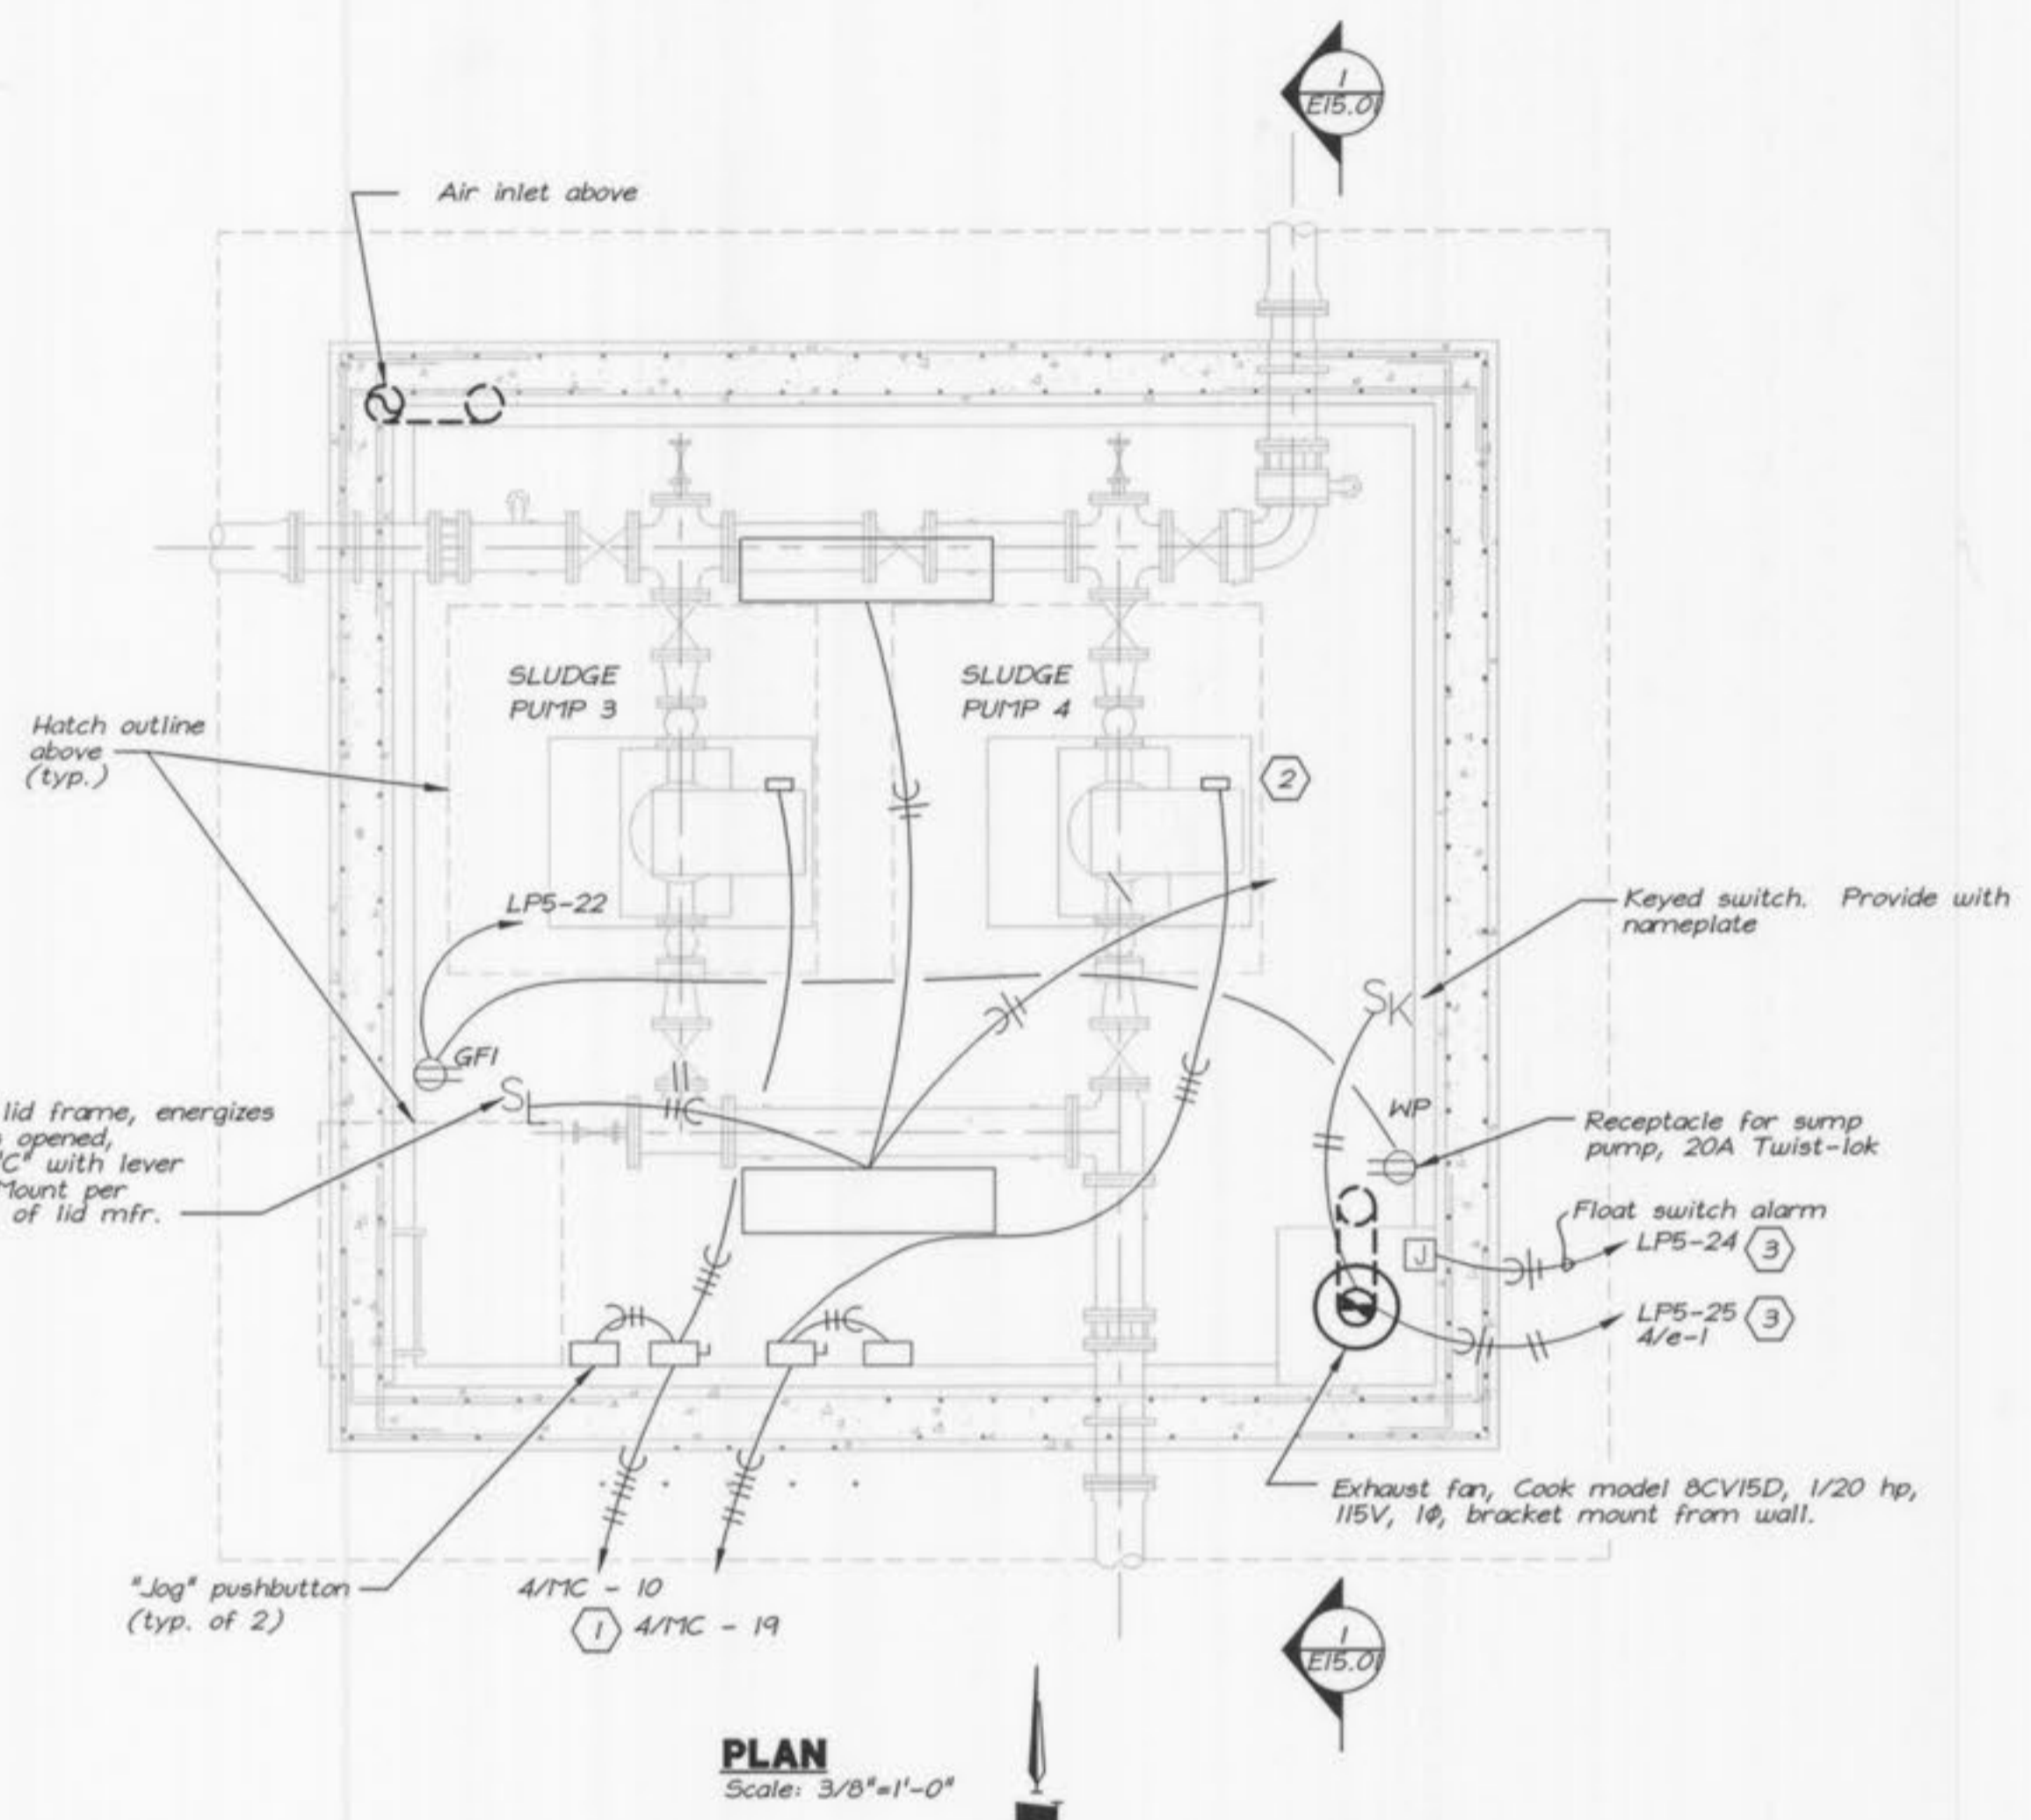

EXHAUST FAN CONTROL
 No Scale

- Notes:**
- ① See Sheet E4.01, One-Line
 - ② Exact location of equipment terminations may vary slightly from that shown, coordinate with G.C. for precise locations and requirements.
 - ③ LP-5 on sheet E4.02.