



**EAST ELEVATION BIO-FILTER COMPLEX**

SCALE 1/8" = 1'-0"

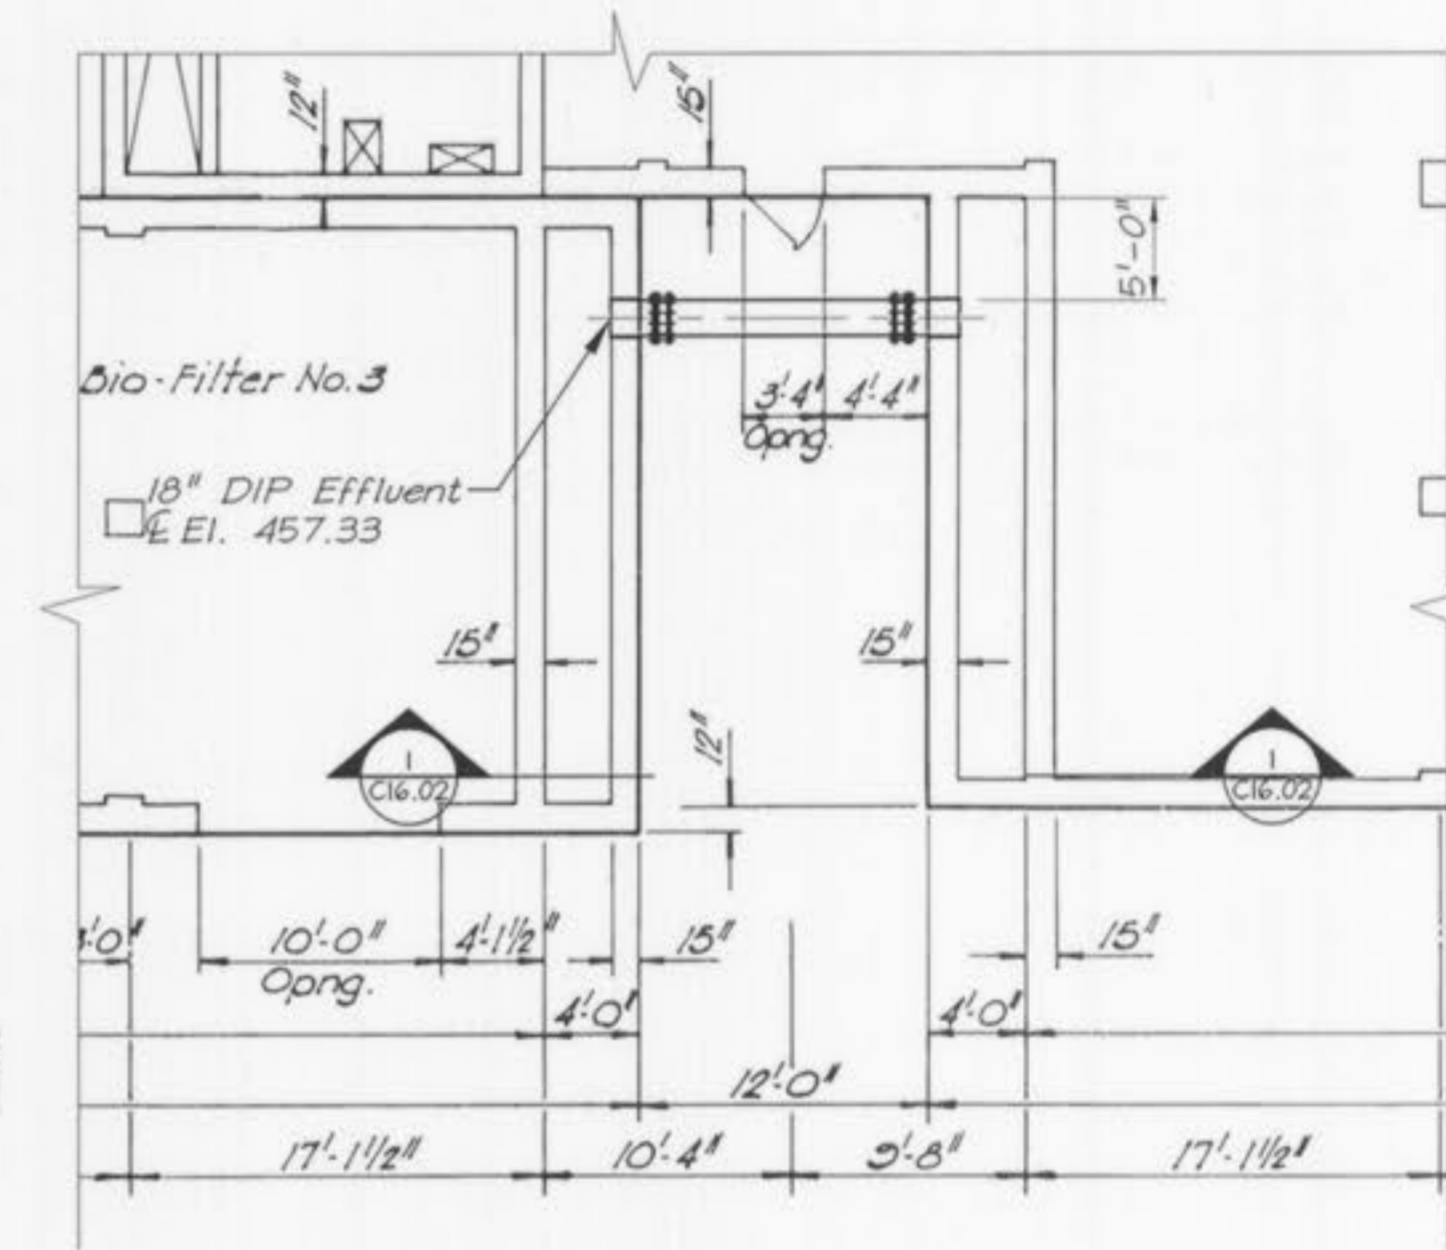

**BIO-FILTER PIPING PLAN**

SCALE 1/8" = 1'-0"

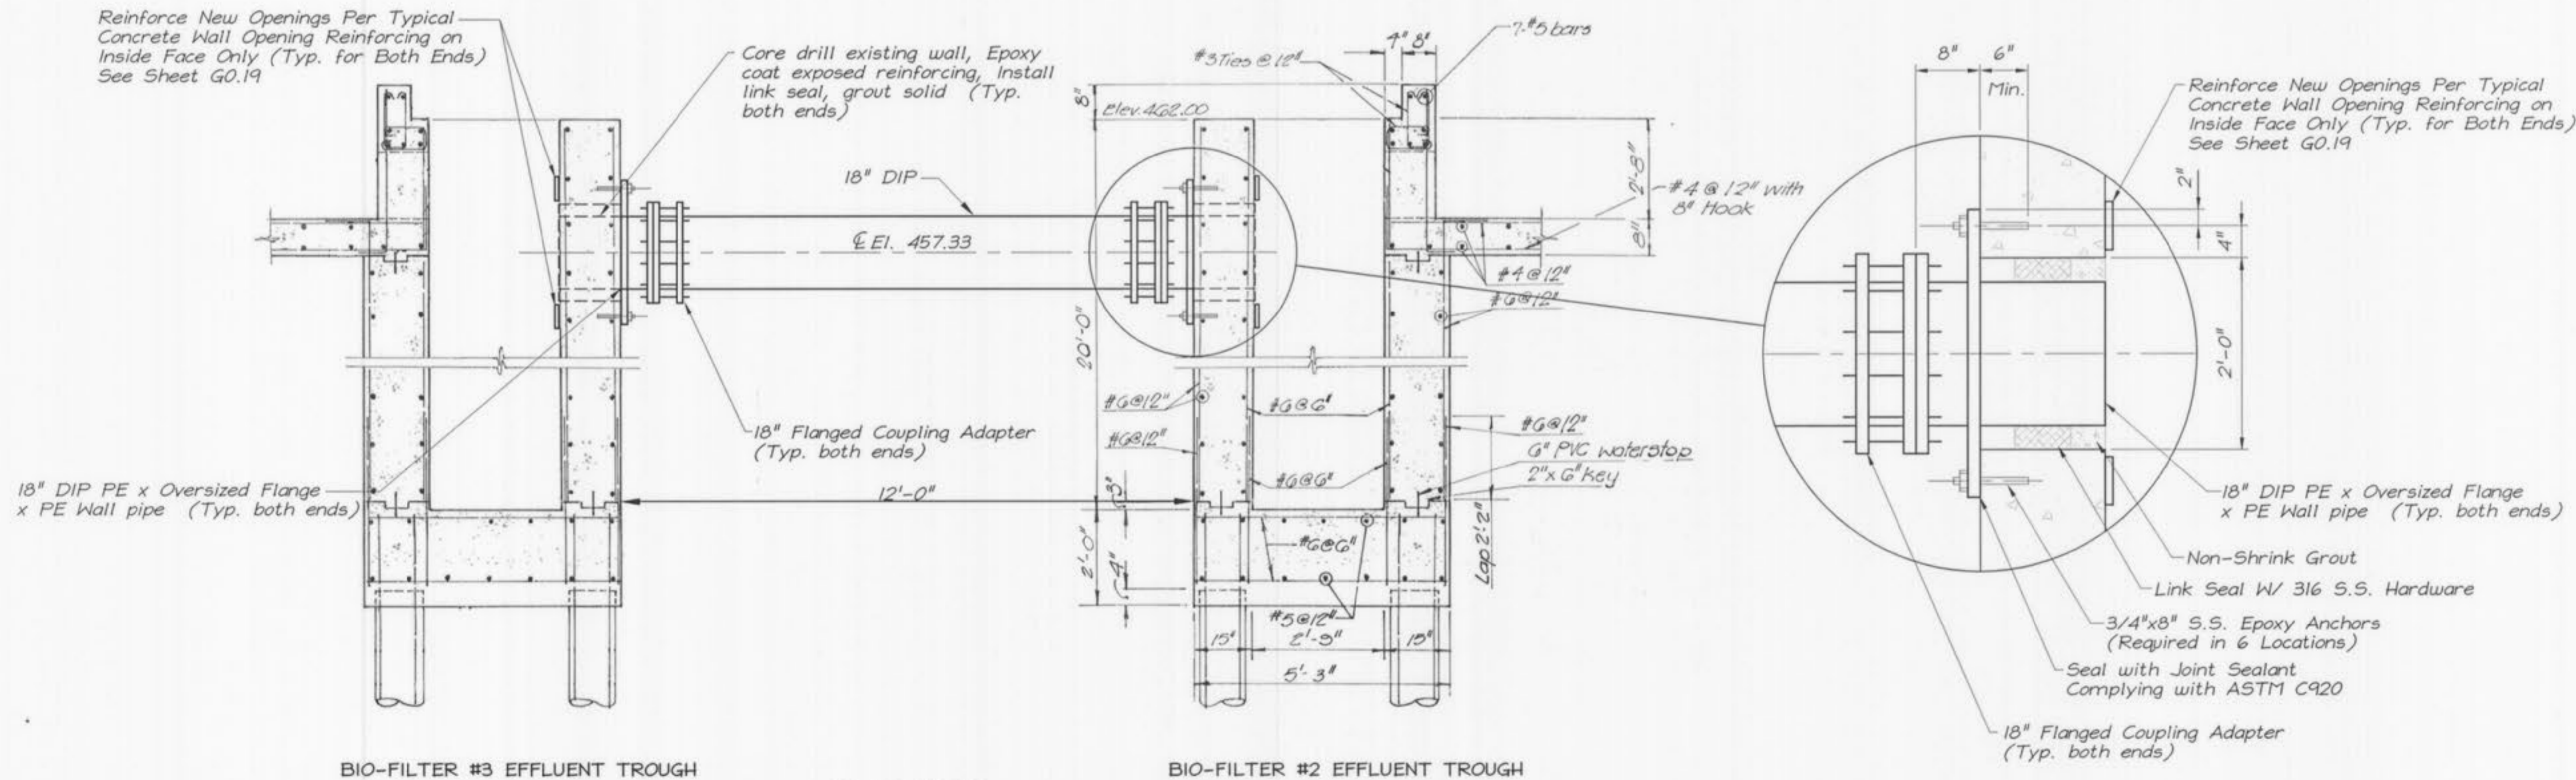

BIO-FILTER #3 EFFLUENT TROUGH

BIO-FILTER #2 EFFLUENT TROUGH

**SECTION**

SCALE 1/2" = 1'-0"

C16.02

**WASTEWATER TREATMENT PLANT EXPANSION**  
**BIO-FILTER COMPLEX MODIFICATIONS**  
**PIPING CONNECTION PLAN**  
 CITY OF FALLON, MISSOURI

**GBA**  
 GEORGE BUTLER ASSOCIATES, INC.  
 Engineers • Architects  
 Kansas • Missouri • Illinois

SITE OF MISSOURI  
 ROBERT J. RUSSELL  
 NUMBER  
 E200047  
 [Signature]

JOB NO.: 9234  
 DATE: 10-08-2001

DESIGNED BY: RJR  
 DRAWN BY: RJR  
 CHECKED BY: RJR/TMS  
 SHEET NUMBER

**C16.02**

K:\Client\O'Fallon\9234\O'Fallon\Download from O'Fallon\9234\1806.dwg Layout: C16.02 -- Thursday October 04, 2001, 2:04pm -- Copyright 2001, George Butler Associates, Inc.