


PARTIAL BASEMENT FLOOR PLAN
SCALE : 3/8" = 1'-0"

NOTES:

1. The Existing Aurora pumps (Model 613, Size 10x10x15, G.P.M. 3500, TDH 30', Power Series 5A) shall be removed and replaced with New Recirculation Pumps in accordance with the technical specifications.
2. The Contractor shall field verify proposed equipment with the current piping configuration. Any modifications to the current piping configuration or Housekeeping pad shall be the contractor's responsibility at no additional cost to the owner. Such modifications shall be submitted with the pump submittal for the Engineer's review.
3. The Owner has the right to salvage all or any part of the fittings, equipment or piping. The contractor shall deliver such salvaged items to a location directed by the Owner's Representative at no additional cost to the Owner.

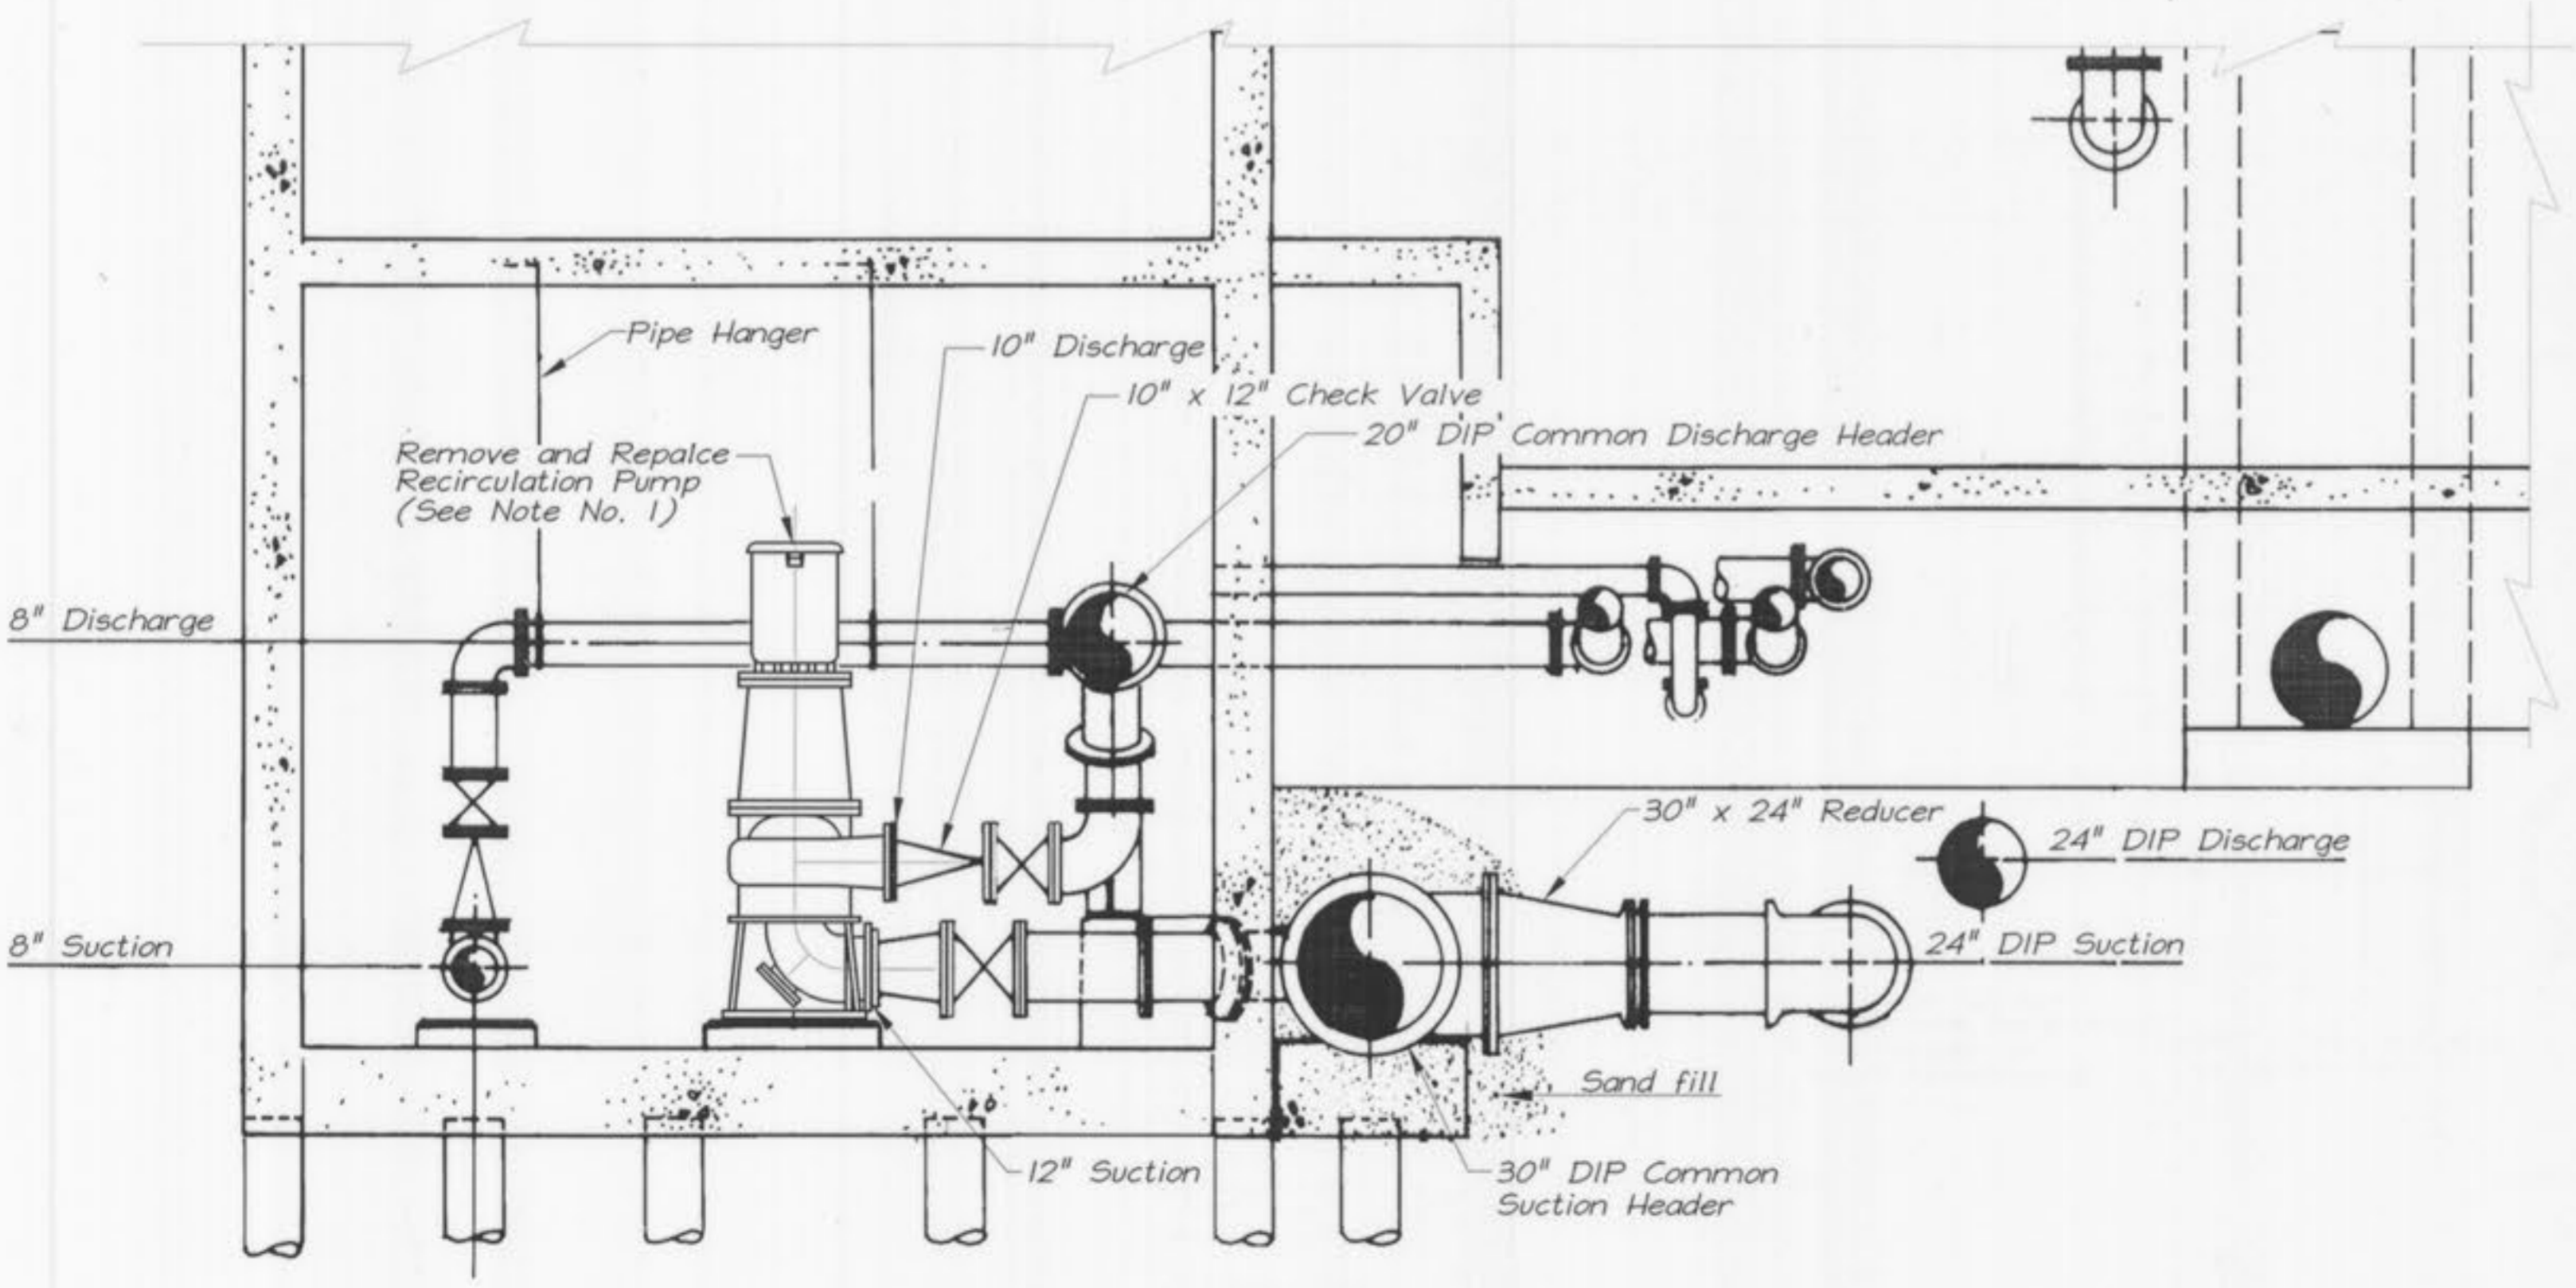

SECTION 1
SCALE : 3/8" = 1'-0"

GEORGE BUTLER ASSOCIATES, INC.
Engineers • Architects
Kansas • Missouri • Illinois



WASTEWATER TREATMENT PLANT EXPANSION
BIO-FILTER COMPLEX MODIFICATIONS
PUMP REPLACEMENT - PLANS
 CITY OF OFALLON, MISSOURI

JOB NO.: 9234
DATE: 10-08-2001

DESIGNED BY: TMS
DRAWN BY: RGA
CHECKED BY: TMS/RJR
SHEET NUMBER

C16.03