



K:\Client\O'Fallon\9234\dwg\Elec\92343102.dwg Layout: E31.02: -- Monday, October 08, 2001, 1:08pm -- Copyright 2001, George Butler Associates, Inc.

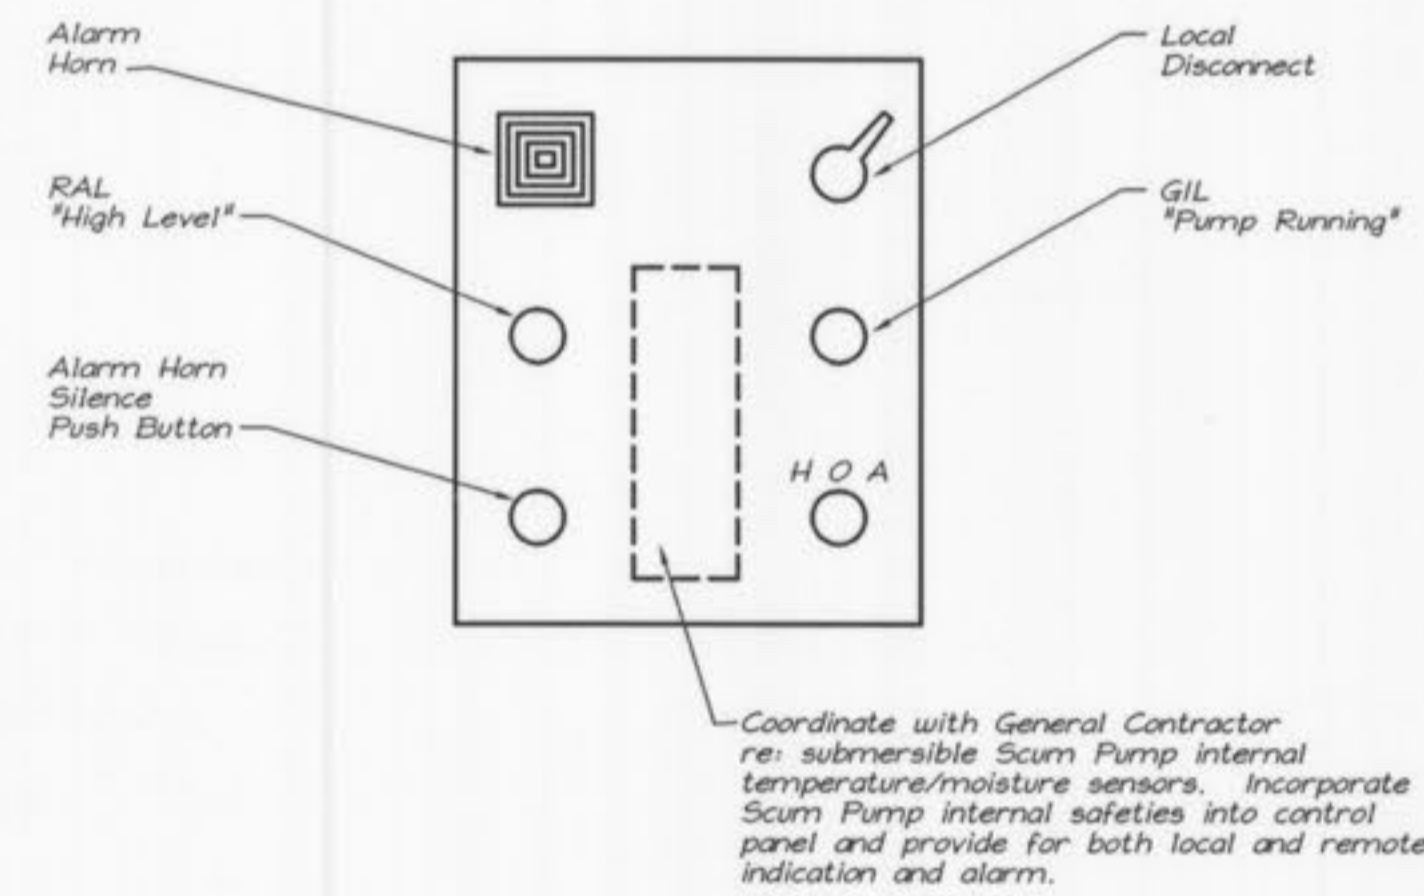

DETAIL 1
SCUM PUMP CONTROL PANEL (TYP.)
 NO SCALE

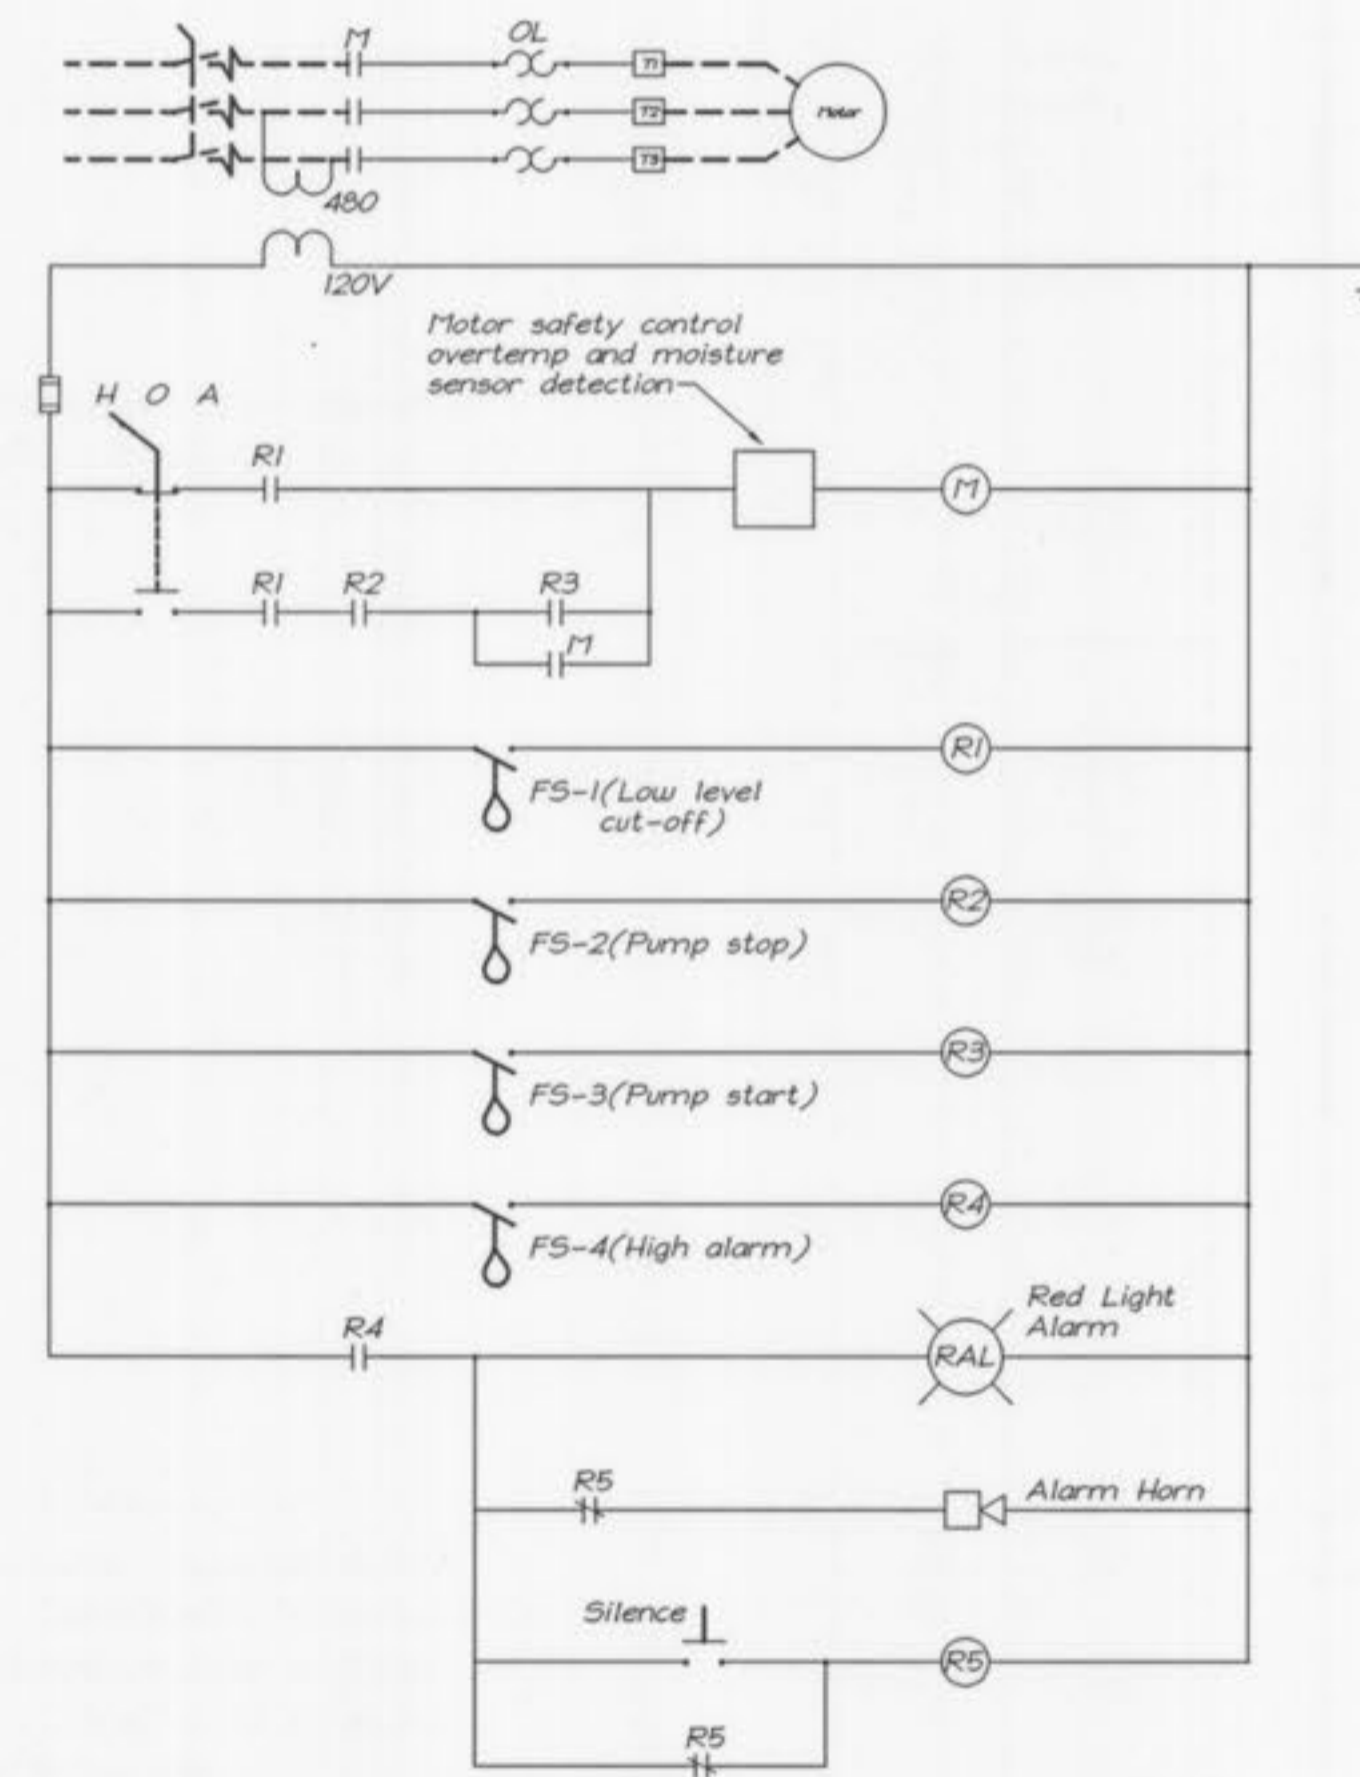

SCUM PUMP CONTROL SCHEMATIC
 NO SCALE

- Notes:
- ① Power to Clarifier Drive and alarm panel (separate panels) from Chlorine Building to be reconfigured to Bio-Filter building. See sh. E31.01 and note 5, same sheet.
 - ②



WASTEWATER TREATMENT PLANT EXPANSION
FINAL CLARIFIER
SCUM PUMP DETAIL
 CITY OF O'FALLON, MISSOURI

JOB NO.: 9234
DATE: 10-08-2001
DESIGNED BY: SLC
DRAWN BY: KRC
CHECKED BY: SLC
SHEET NUMBER
E31.02

GBA
 GEORGE BUTLER ASSOCIATES, INC.
 Engineers • Architects
 Kansas • Missouri • Illinois