

LUMINAIRE SCHEDULE


Symbol	Label	Qty	Catalog Number	Description	Lamp	File	Lumens	LLF	Watts
	B	6	TFA 1000M RN	FLOODLIGHT W/SPECTULAR CURVED REFL. & END PANELS, CLEAR GLASS.	ONE 1000-WATT CLEAR BT-56 METAL HALIDE, HORIZONTAL POS.	97120101.IES	107800	0.60	1060
	C	7	TWH 100M FS	GLASS REFRACTOR WALLPACK WITH FULL SHIELD.	ONE 100-WATT CLEAR ED17U METAL HALIDE, HORIZONTAL POS.	LTL8384.IES	8500	0.60	94.8
	F	4	KVF-1000M ASYFL EHS	SQUARE AREA LIGHT, ASYMMETRIC DISTRIBUTION, FLAT LENS, HOUSE SIDE SHIELD.	ONE 1000-WATT CLEAR BT-37 METAL HALIDE, VERTICAL BASE UP POS.	L189397.ies	110000	0.60	3240
	G	4	KVF-1000M ASYFL EHS	SQUARE AREA LIGHT, ASYMMETRIC DISTRIBUTION, FLAT LENS, HOUSE SIDE SHIELD.	ONE 1000-WATT CLEAR BT-37 METAL HALIDE, VERTICAL BASE UP POS.	L189397.ies	110000	0.60	1060

STATISTICS

Description	Symbol	Avg	Max	Min	Max/Min	Avg/Min
SITE CALCS	+	0.9 fc	30.4 fc	0.0 fc	N/A	N/A
PARKING CALCS	X	5.6 fc	30.4 fc	0.2 fc	152.0:1	28.1:1

NOTES

- POLE MOUNTED FIXTURES ARE AT 30.0 FEET.
- BUILDING MOUNTED FIXTURES IS AT 20.0 FEET.

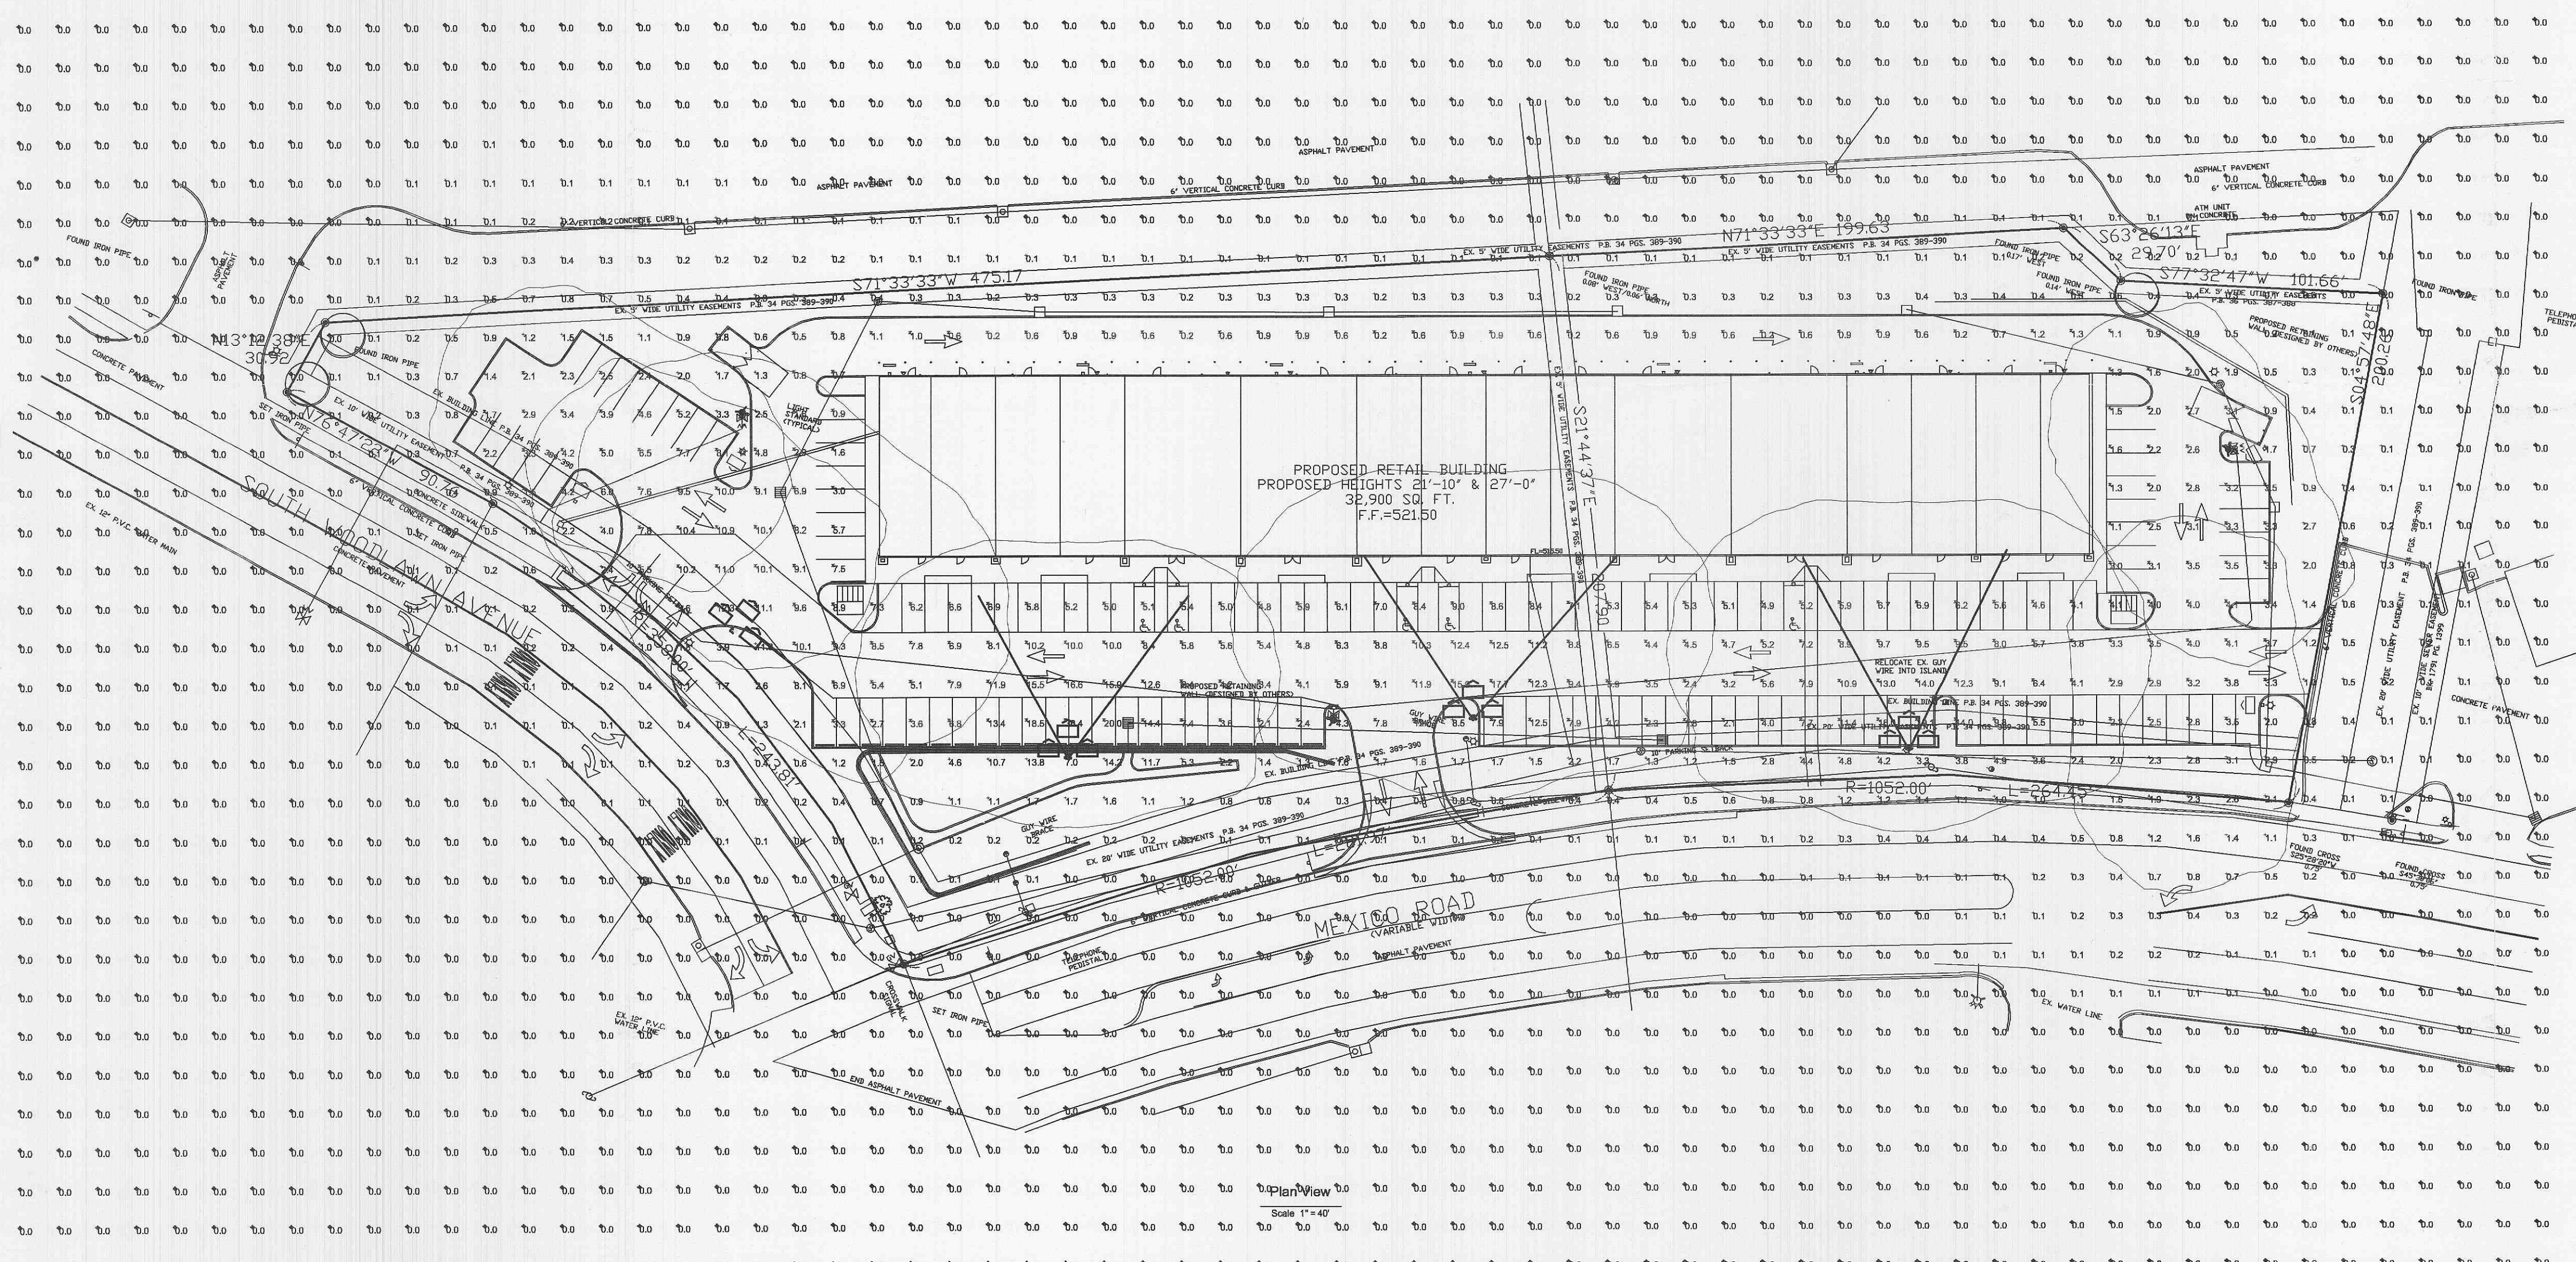

WOODLAWN PLAZA
SITE LIGHTING
POINT ILLUMINATION STUDY

Designer
R.A. MCILRATH
Date
FEB. 18, 2004
Scale
AS NOTED
Drawing No.
124-01903A7

2-20-04
APPROVED

These lighting calculations are not a substitute for independent engineering analysis of lighting system suitability and safety.